
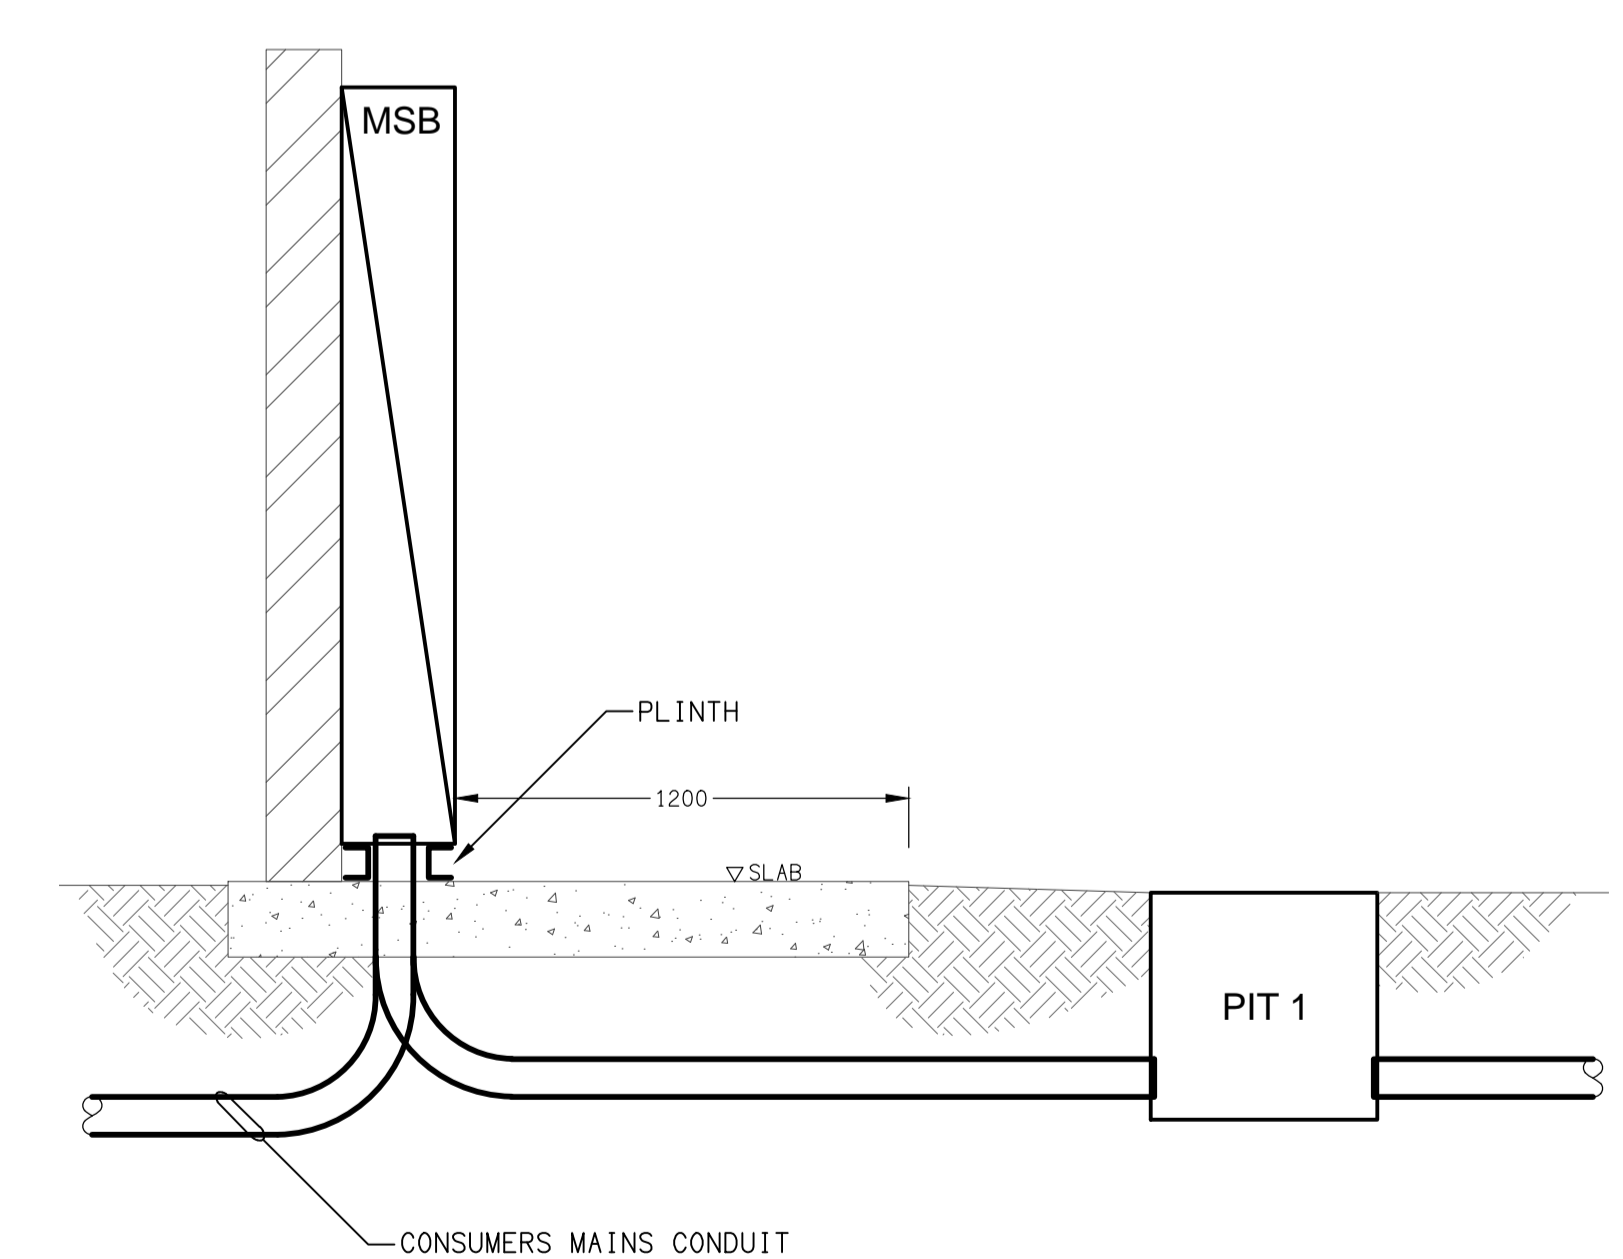


DETAIL B
MSB FRONT ELEVATION VIEW
NOT TO SCALE

NOTE:
UNIT NUMBERS 4 AND 13 HAVE BEEN
DELIBERATELY NOT USED BY THE DEVELOPER.

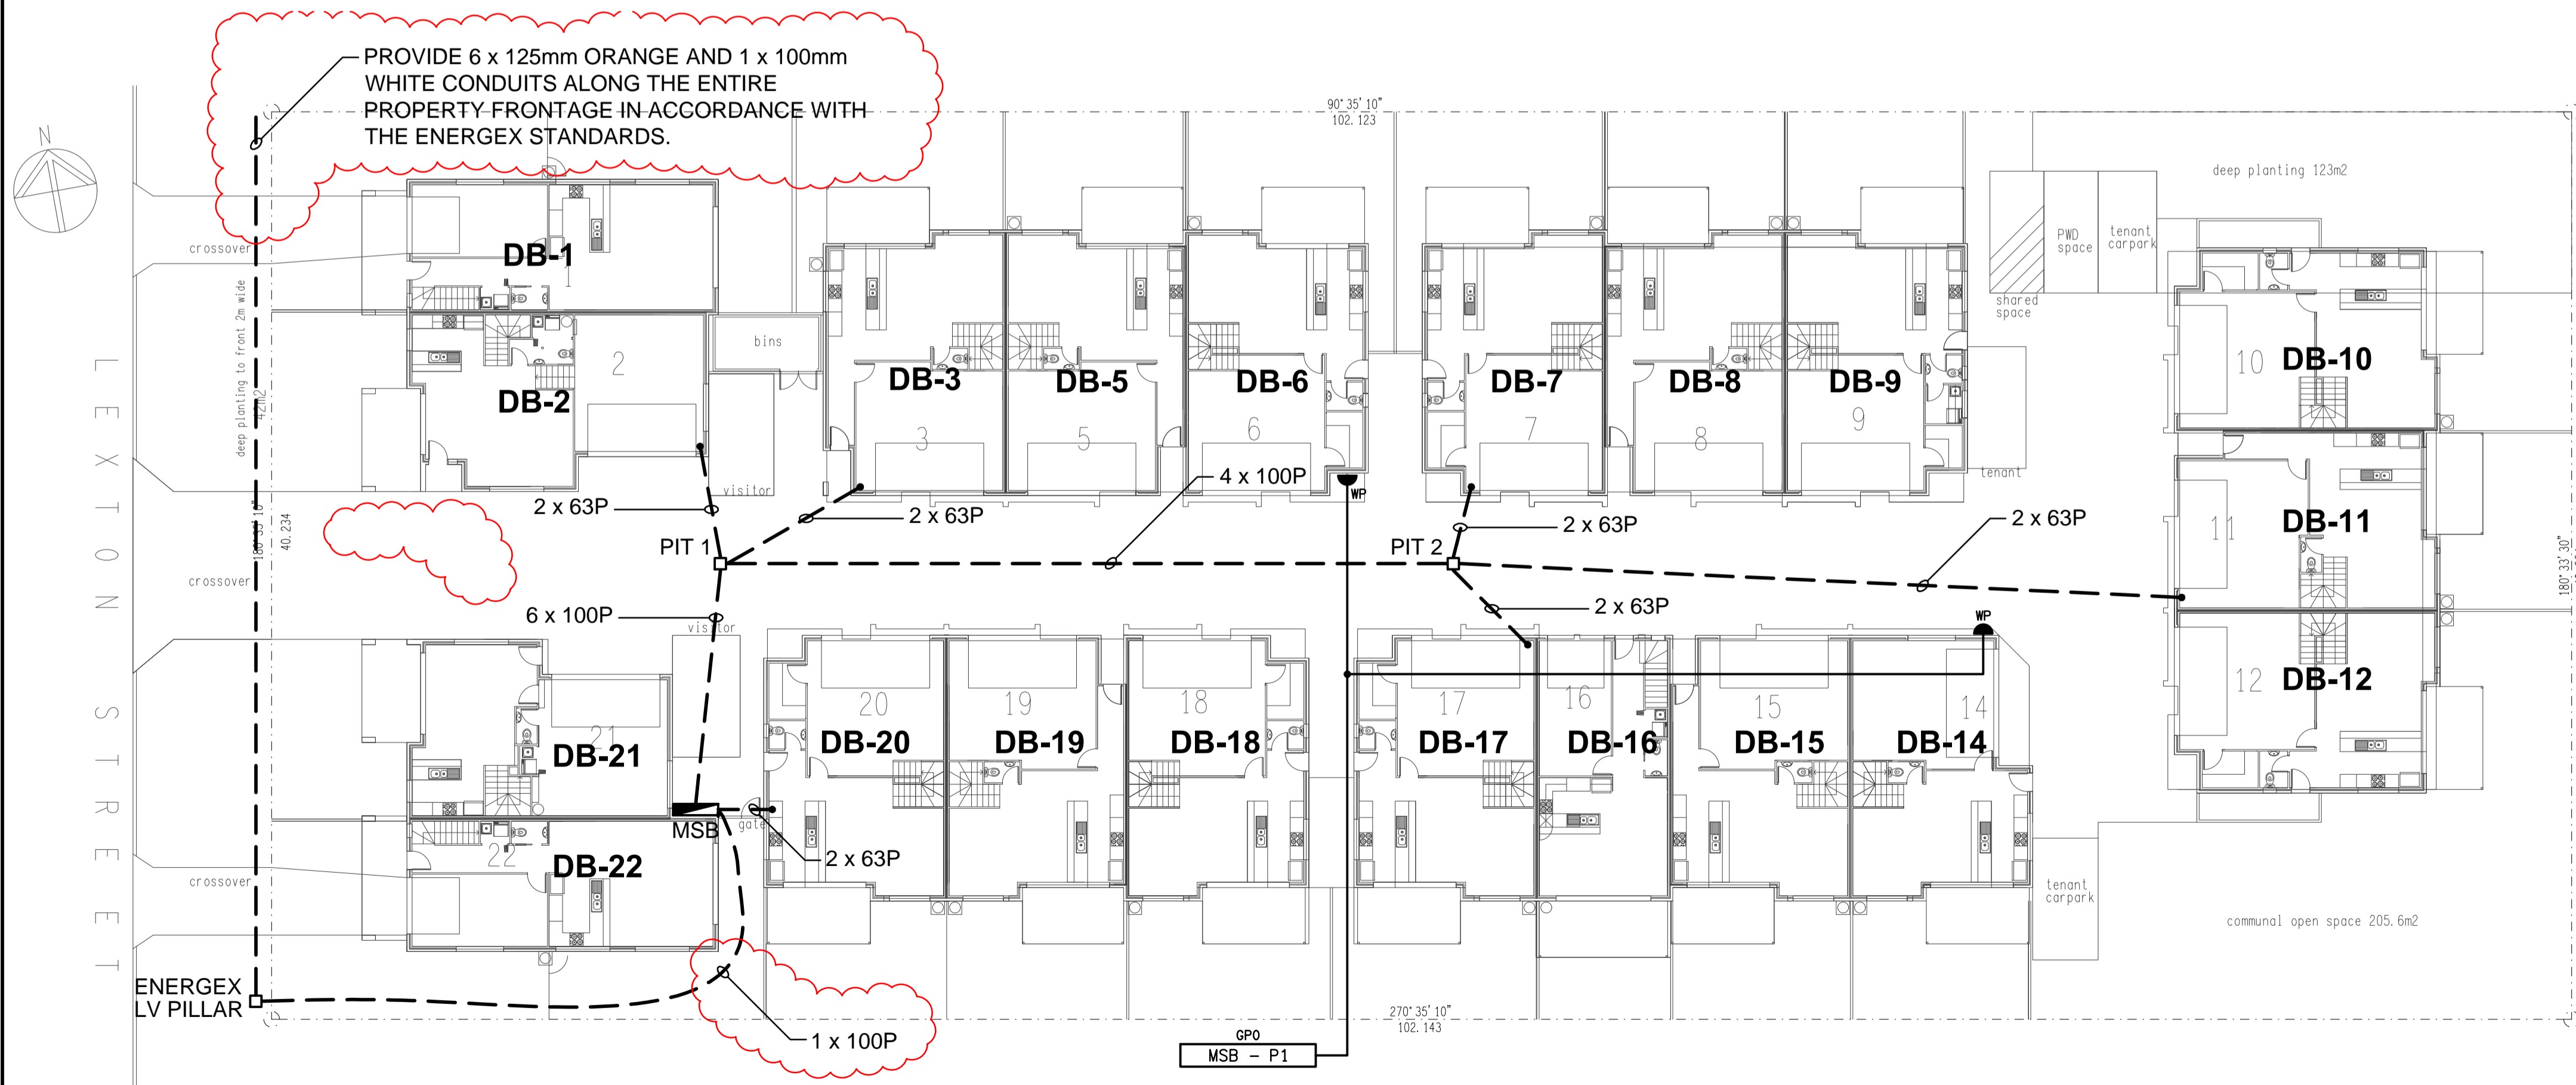

DETAIL A
MSB SECTION VIEW
NOT TO SCALE

ELECTRICAL DESIGN GROUP BRISBANE
PTY LTD
ACN 092 710 793
TRADING AS:
ELECTRICAL DESIGN GROUP

THE COPYRIGHT OF THIS DRAWING
REMAINS THE PROPERTY OF THE
ELECTRICAL DESIGN GROUP.
USE FIGURED DIMENSIONS
IN PREFERENCE TO SCALE.
ALL DIMENSIONS TO BE
VERIFIED ONSITE.

ELECTRICAL DESIGN GROUP
ELECTRICAL BUILDING SERVICES CONSULTANTS
BRISBANE GOLD COAST
P.O. Box 15, Sherwood Q.4075
Phone: (07) 3278 4375
Email: brisbane@edg.net.au
Web: www.edg.net.au

PROJECT:
60 LEXTON STREET, STRETTON

C	TENDER	09/09/2019
REV.	DESCRIPTION:	DATE:
DRAWING: ELECTRICAL SERVICES SITE PLAN - POWER & CONDUIT		
SCALE: 1:200	PROJECT NO: C1880a	DRAWING NO: E02
AT A1	REVISION: C	