



IP64

CONSTRUCTION & DESIGN

- Surface mounted LED exterior wall light
- Constructed in pressure die cast aluminium alloy and finished in textured white, textured black and textured silver durable powdercoated paint
- High performance luminaire designed with LED technology providing optimal and uniform light output with low power consumption
- One way and two way light distribution for direct and indirect illumination with low glare
- Frosted, tempered glass cover, stainless steel exposed fasteners and silicone seals provide IP64 protection
- Ideal for general illumination and highlighting architectural features

TECHNICAL PERFORMANCE


- 8W or 2x6W total system power consumption with overload and short circuit protection
- >65,000 hours lifespan (L70)
- Premium quality Japanese LED Module with high lumen output per watt
- Chromaticity tolerance (MacAdam steps) -2
- Available in 3K and 4K colour temperature with low colour shift over time

OPTICAL & THERMAL PERFORMANCE

- Customised heatsink provides premium optical and thermal performance
- Efficient optical control with no harsh cut off and ultra low glare

ELECTRICAL SYSTEM

- Supplied completely assembled with integral leading and trailing edge dimmable drivers and terminal block
- Power factor > 0.9 with active power factor correction
- Input voltage 220-240V, 50/60 Hz

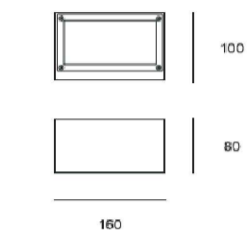

ONE WAY	TWO WAY	Weight (kg)	3K and 4K	IP64
		1.7	CRI >85	

TOTAL SYSTEM POWER CONSUMPTION = 8W / 2x6W

CODE ORDERING GUIDE: PRODUCT CODE - COLOUR SUFFIX
Example: 1214-3K-03


WATTAGE	COLOUR TEMPERATURE	> 35° WIDE		HOT LED LUMENS
		ONE OR TWO LIGHT	TWO LIGHT	
8W	3K	1214-3K	ONE	828
	4K	1214-4K	ONE	870
2x6W	3K	1215-3K	TWO	1518
	4K	1215-4K	TWO	1607

Supplied as standard with integral leading & trailing edge mains dimmable driver

COLOUR OPTIONS: ADD SUFFIX AFTER THE CODE

-03	Textured White
-07	Textured Black
-11	Textured Silver

LIGHT TYPE L1 & L2

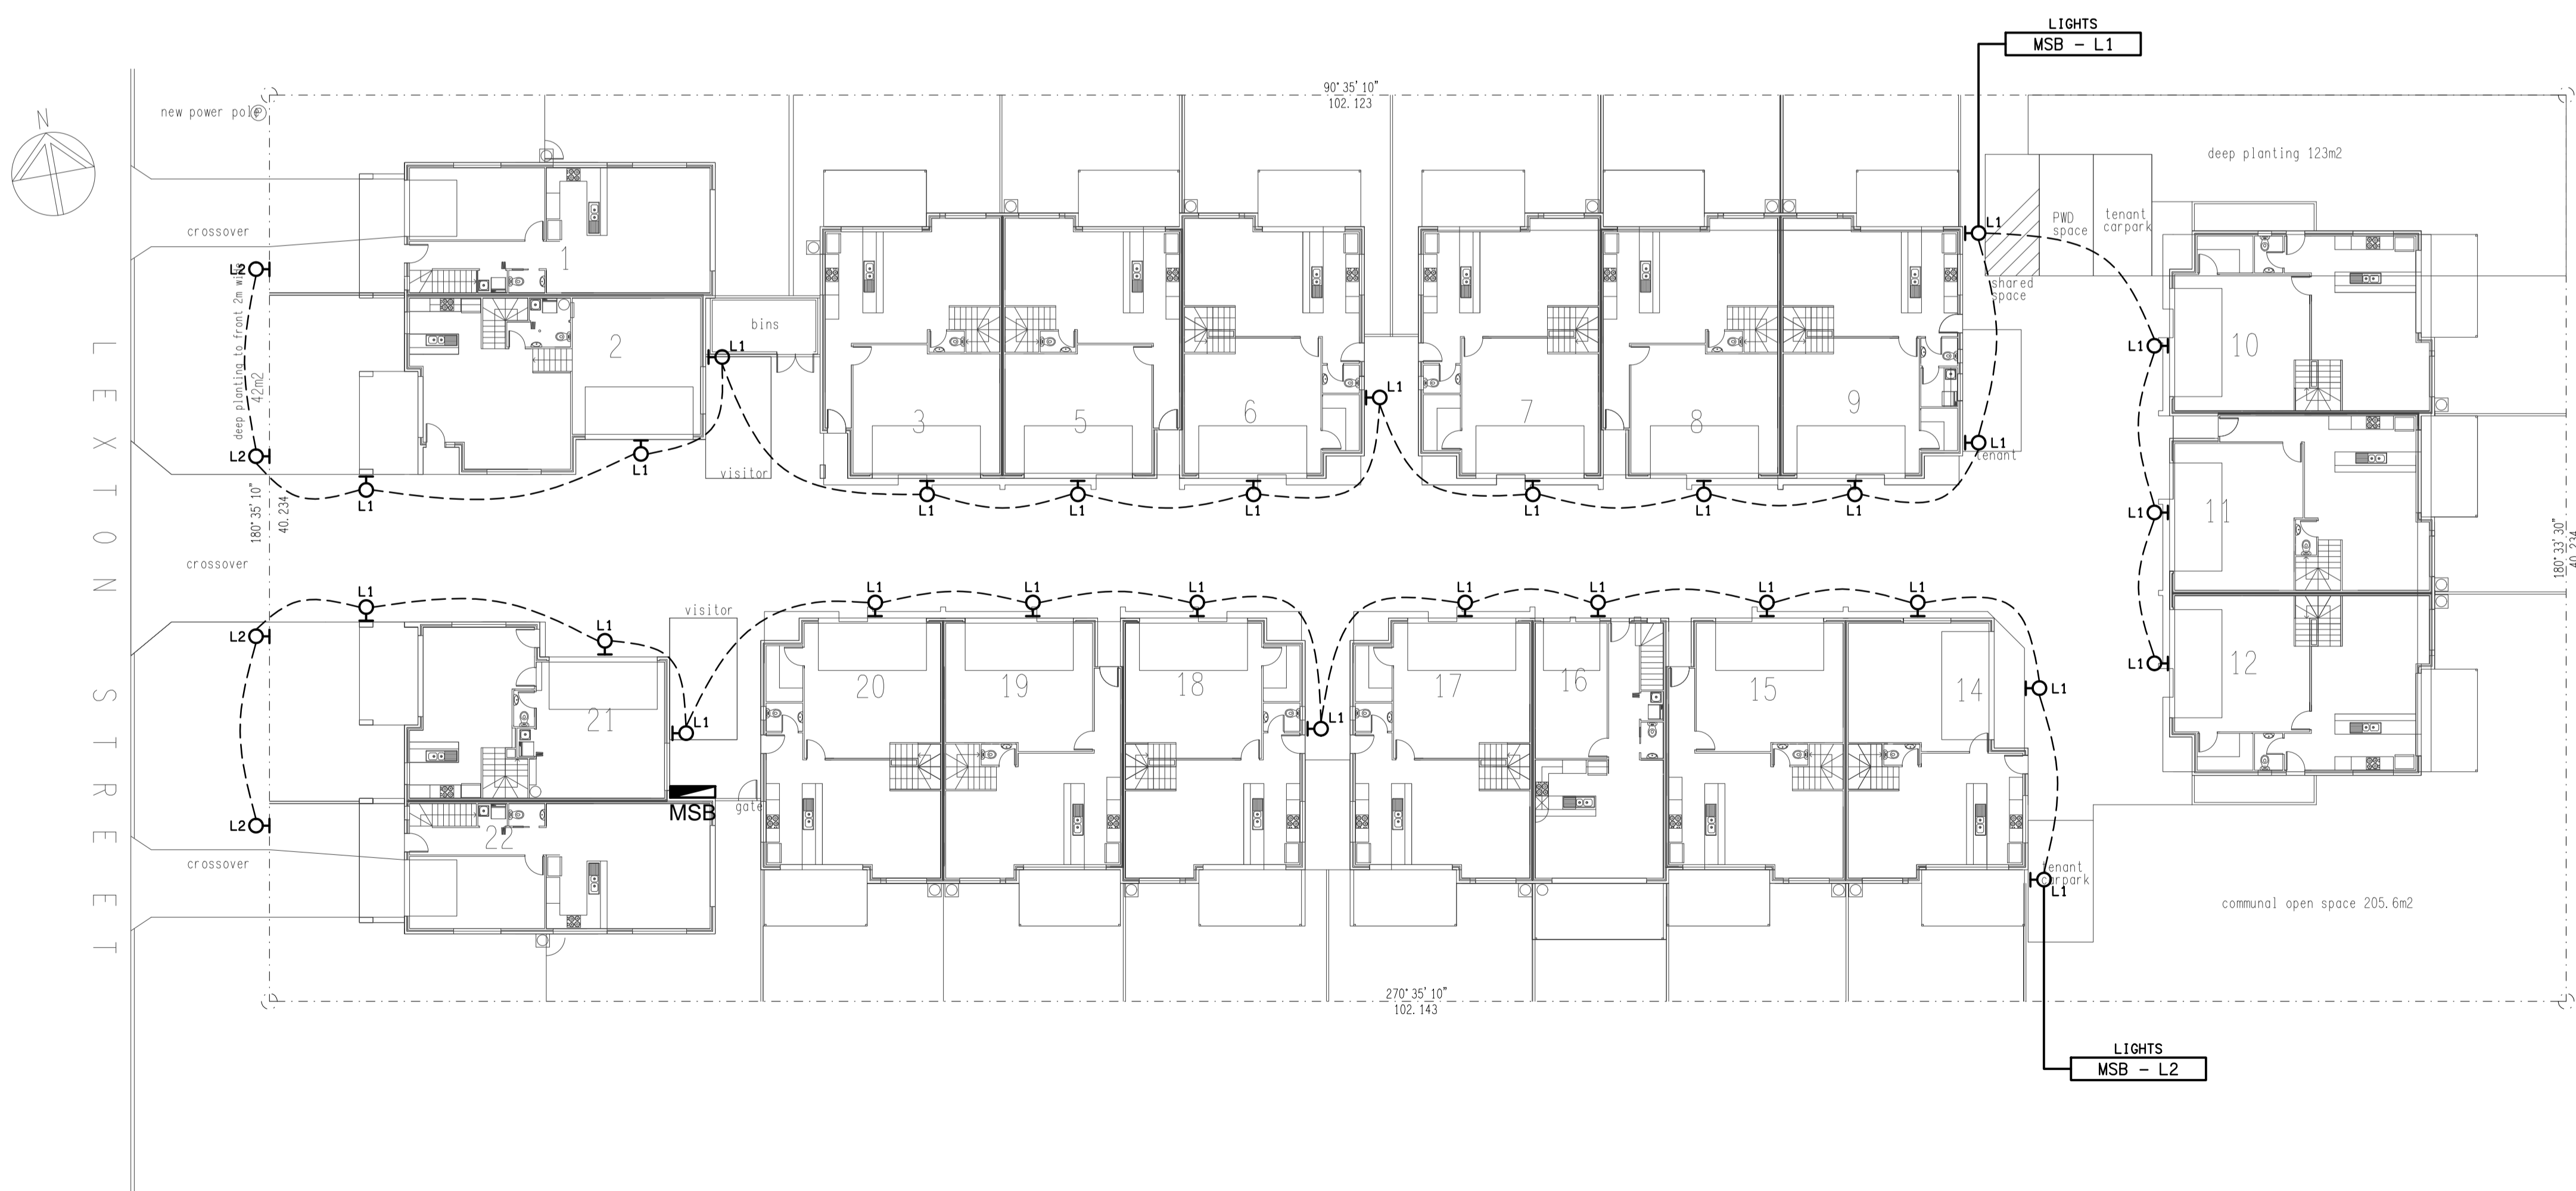

ELECTRICAL DESIGN GROUP BRISBANE PTY LTD
 ACN 092 710 793
 TRADING AS:
 ELECTRICAL DESIGN GROUP

THE COPYRIGHT OF THIS DRAWING REMAINS THE PROPERTY OF THE ELECTRICAL DESIGN GROUP.
 USE FIGURED DIMENSIONS IN PREFERENCE TO SCALE.
 ALL DIMENSIONS TO BE VERIFIED ONSITE.

ELECTRICAL DESIGN GROUP
 ELECTRICAL BUILDING SERVICES CONSULTANTS
 BRISBANE GOLD COAST
 P.O. Box 15, Sherwood Q.4075
 Phone: (07) 3278 4375
 Email: brisbane@edg.net.au
 Web: www.edg.net.au

PROJECT:
60 LEXTON STREET, STRETTON

B	TENDER	08/08/2019
REV:	DESCRIPTION:	DATE:
DRAWING: ELECTRICAL SERVICES SITE PLAN - LIGHTING		
SCALE: 1:200	AT A1	PROJECT NO: C1880a
		DRAWING NO: E03
		REVISION: B