
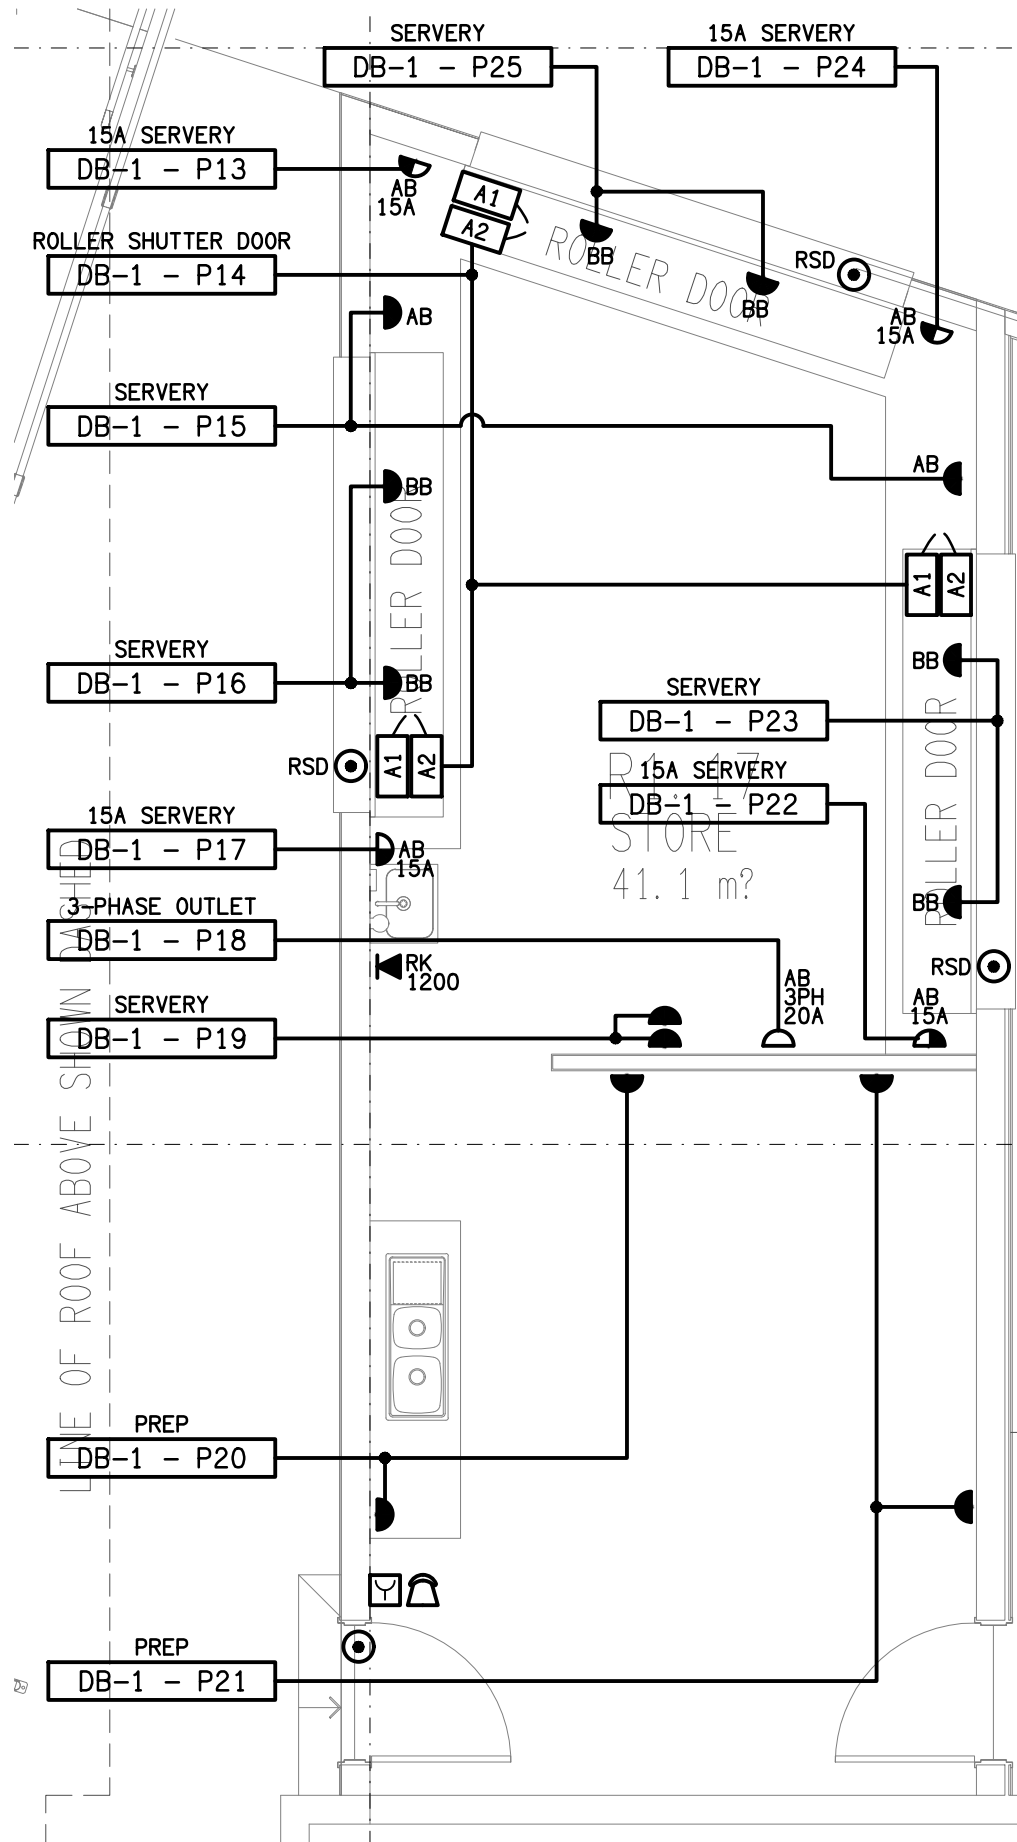


THE COPYRIGHT OF THIS DRAWING REMAINS THE PROPERTY OF THE ELECTRICAL DESIGN GROUP.

USE FIGURED DIMENSIONS IN PREFERENCE TO SCALE.

ALL DIMENSIONS TO BE VERIFIED ONSITE.

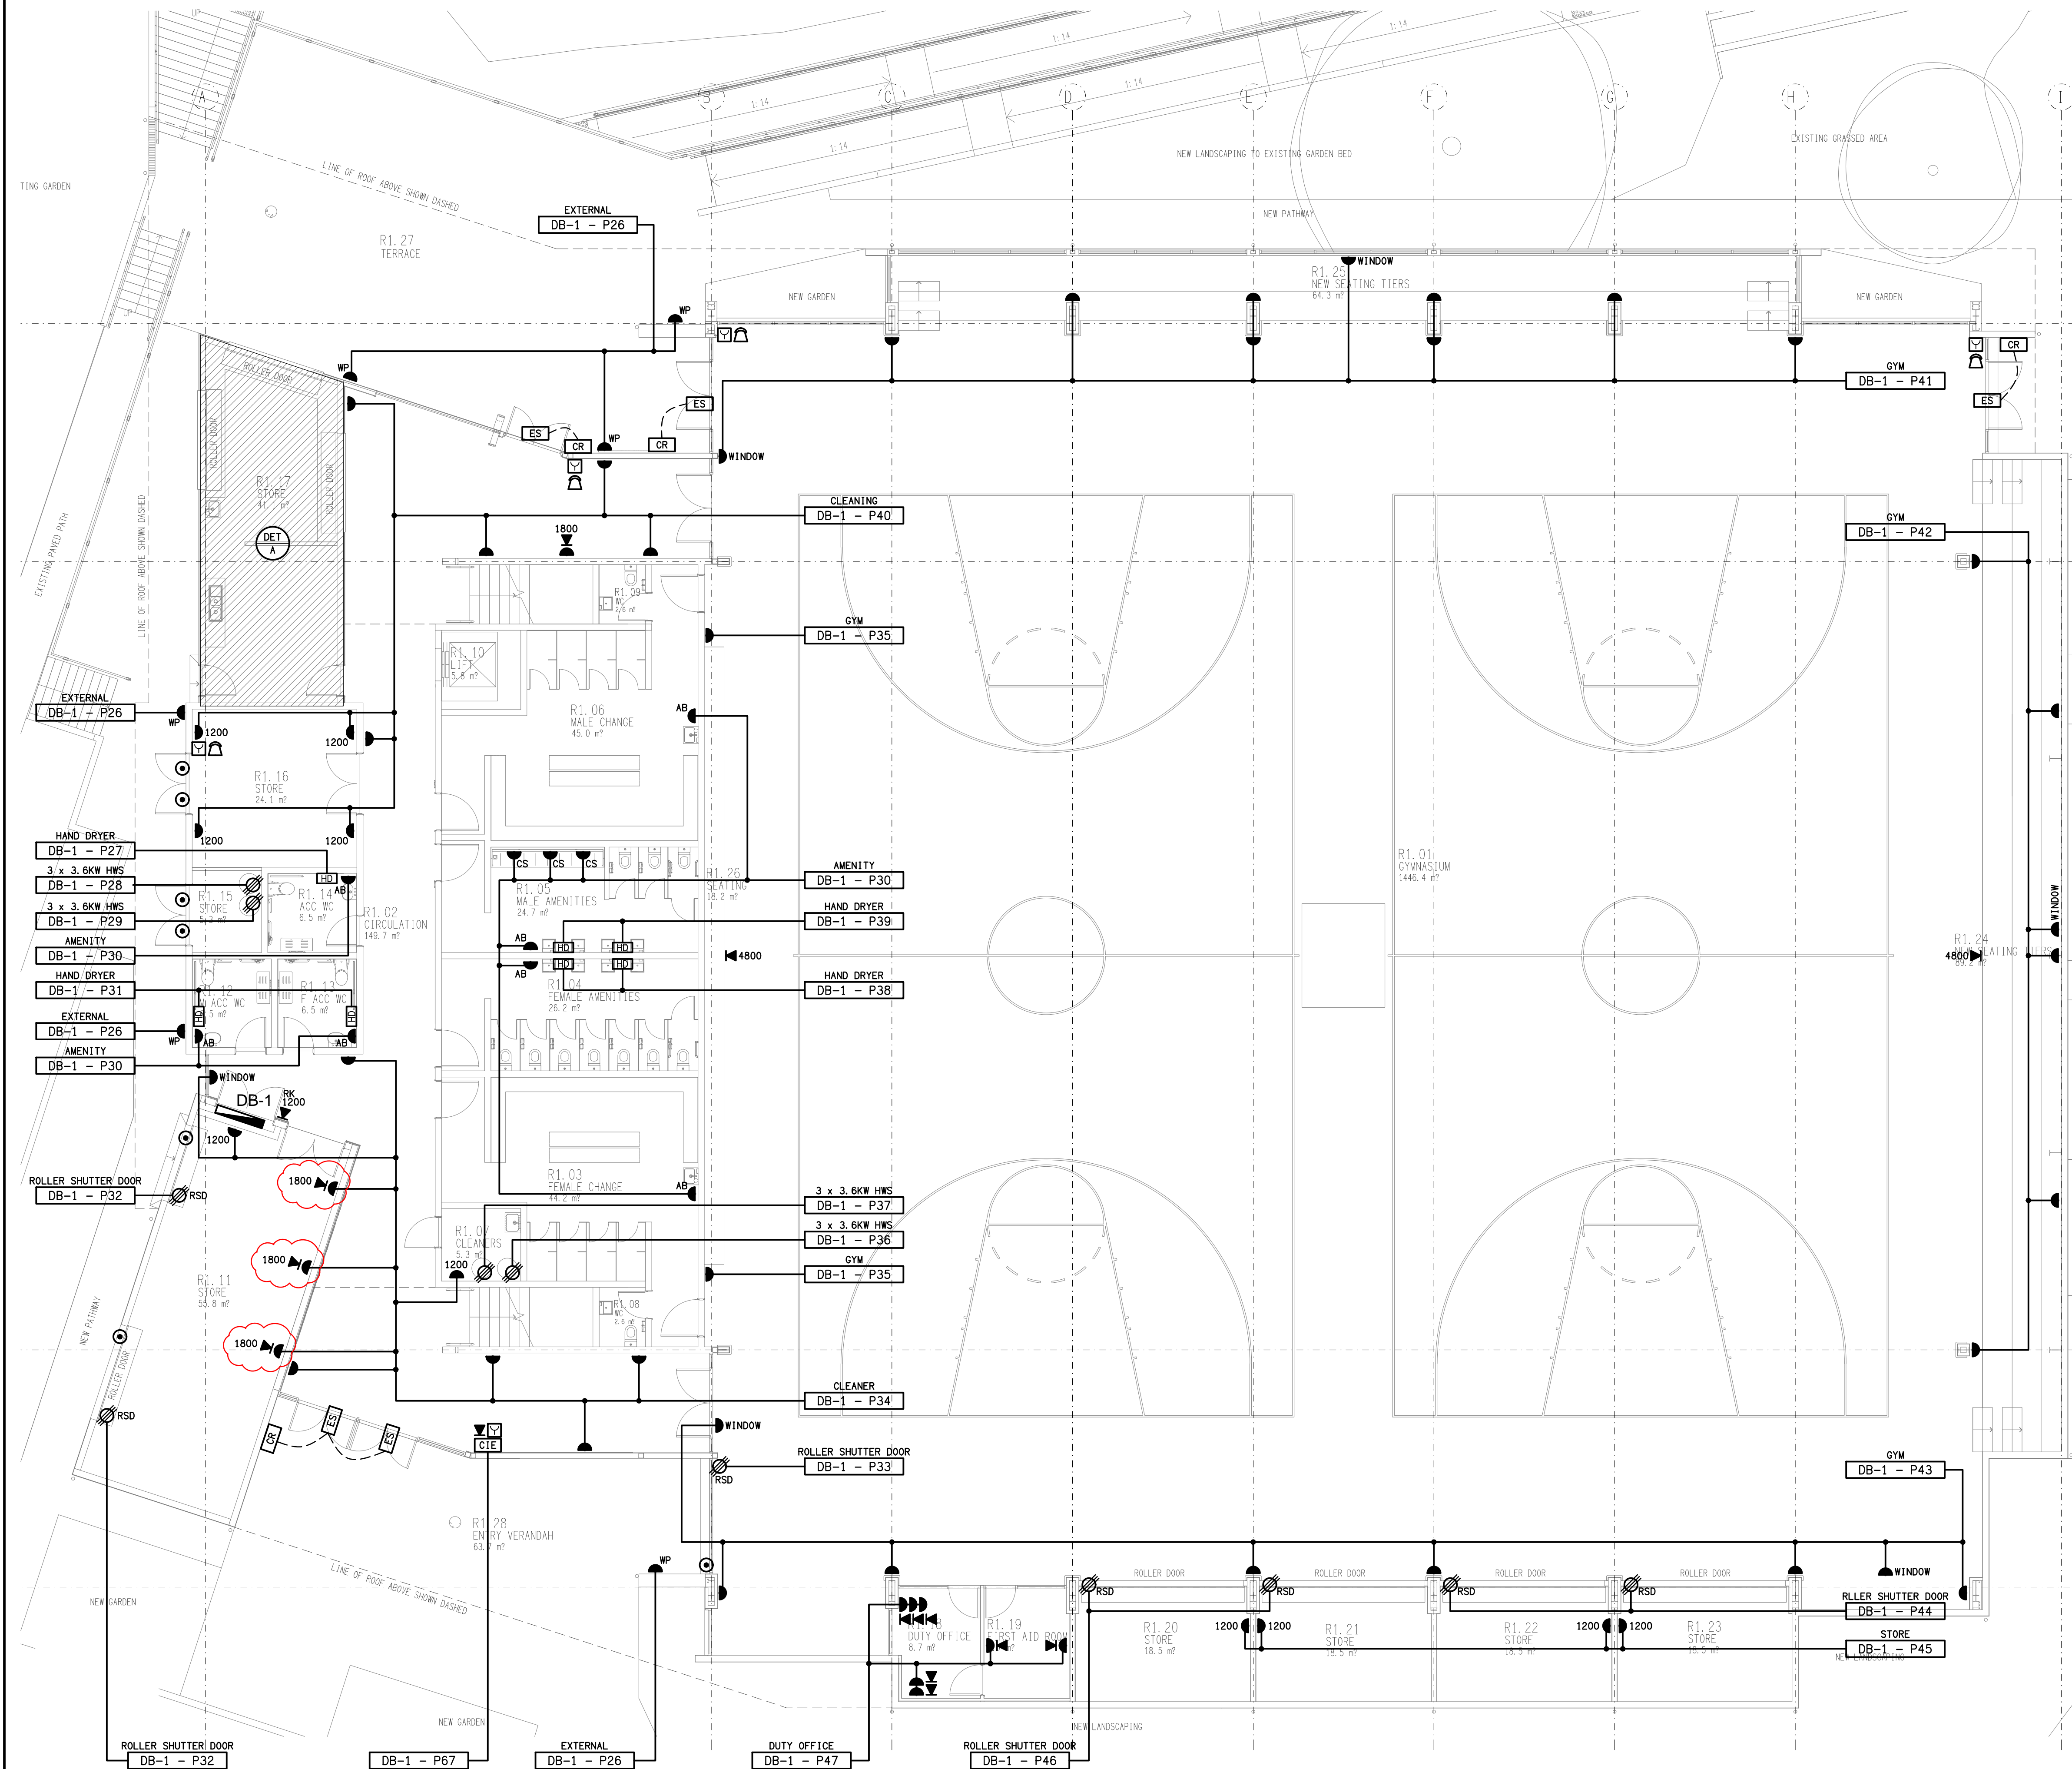

DETAIL A
CANTEEN / STORE ROOM PLAN
SCALE 1:50

H	CONSTRUCTION	20/02/2020
REV:	DESCRIPTION:	DATE:

ELECTRICAL DESIGN GROUP
ELECTRICAL BUILDING SERVICES CONSULTANTS

BRISBANE: P.O. Box 15 Sherwood Qld 4075
Phone: (07) 3278 4375
Email: brisbane@edg.net.au
Web: www.edg.net.au

ELECTRICAL DESIGN GROUP BRISBANE PTY LTD
ACN 092 710 793

PROJECT:
ST JOHN'S ANGLICAN COLLEGE, FOREST LAKE COVERED COURT

SITE ADDRESS:
COLLEGE AVENUE, FOREST LAKE

SCALE: 1:100
SHEET SIZE: AT A1

DRAWING TITLE:
**ELECTRICAL SERVICES
GROUND LEVEL
FLOOR PLAN**

PROJECT NO: DRAWING NO: REVISION:
C2049a E03 H