




**DETAIL A**  
COURT WALL SECTION  
SCALE 1: 100

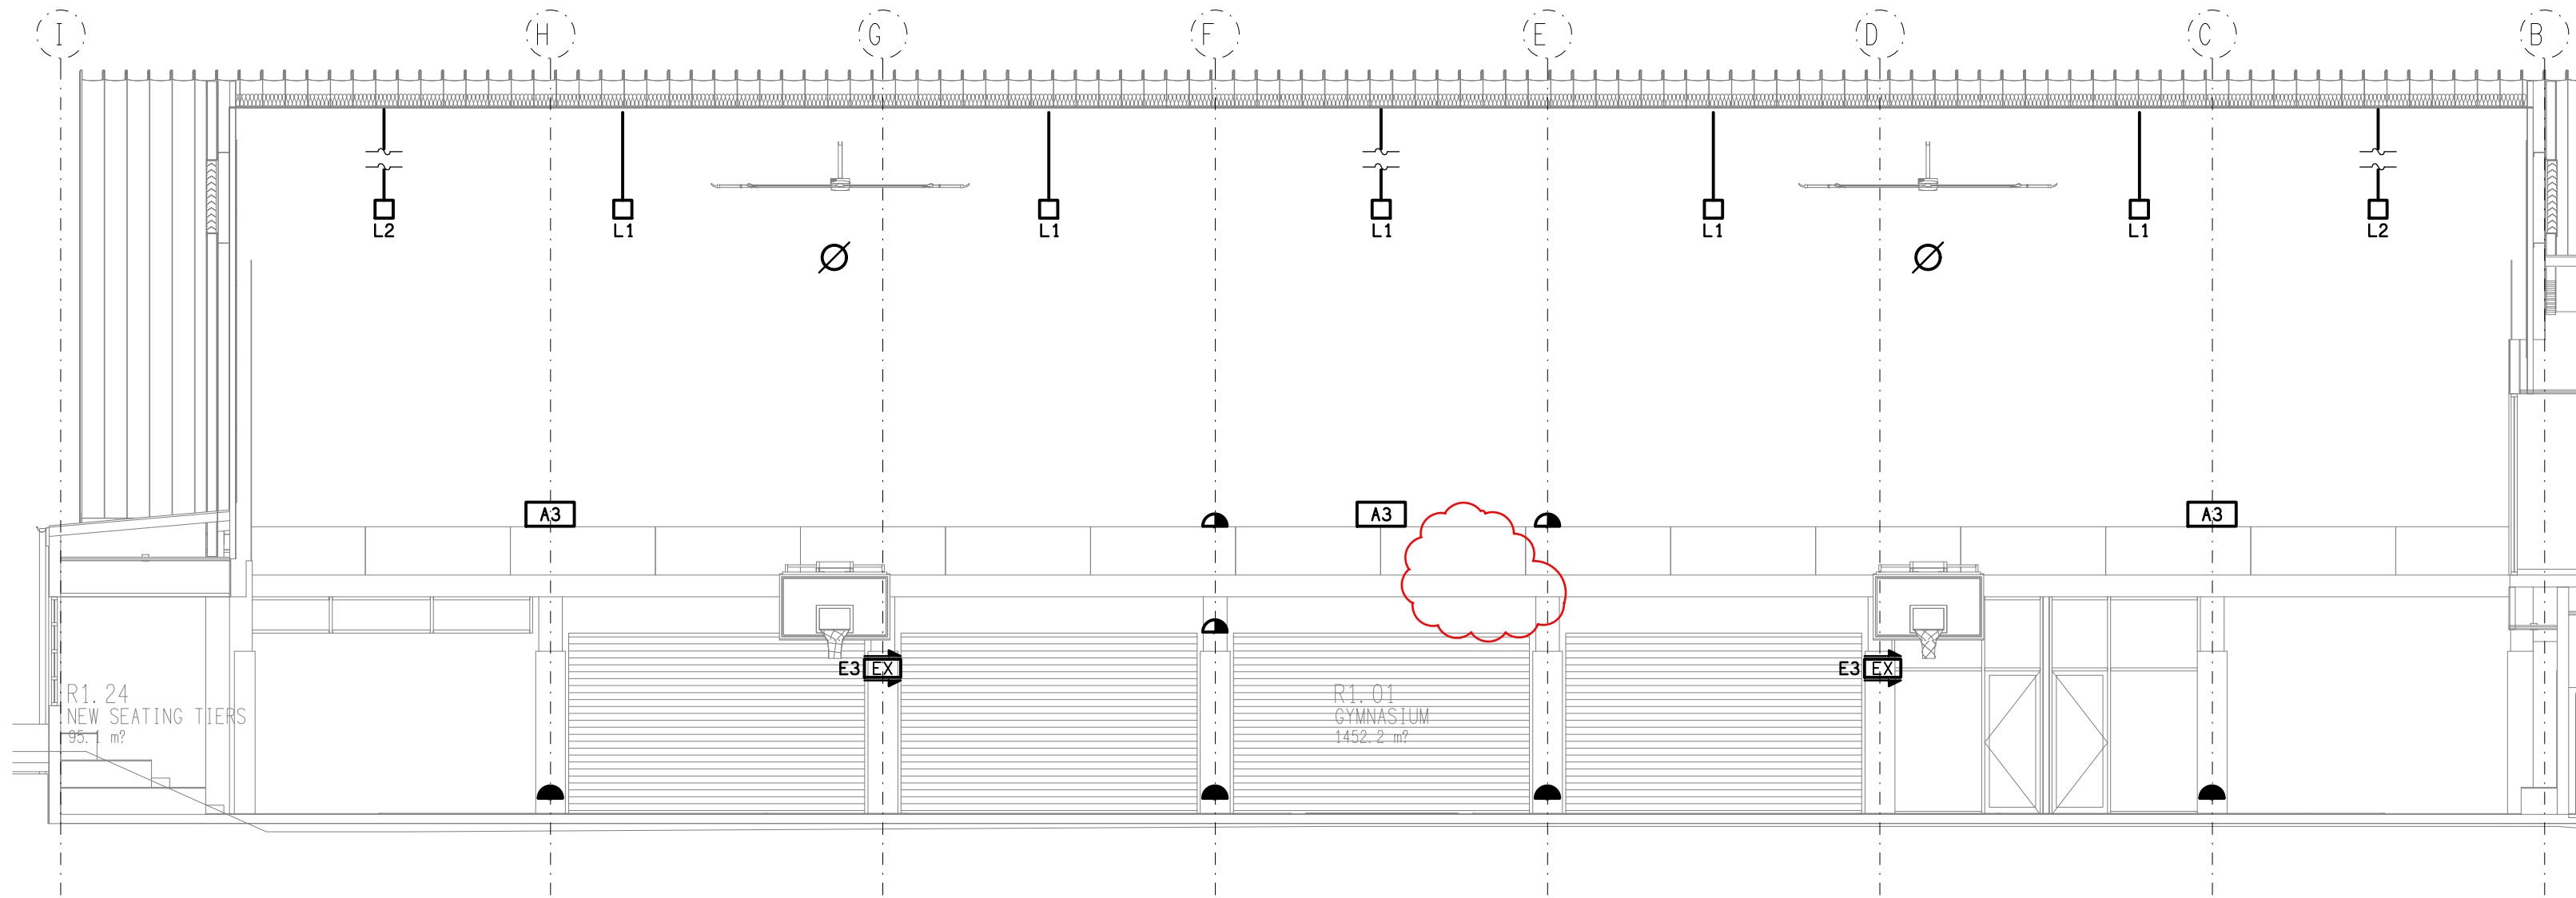

**DETAIL B**  
COURT WALL SECTION  
SCALE 1: 100

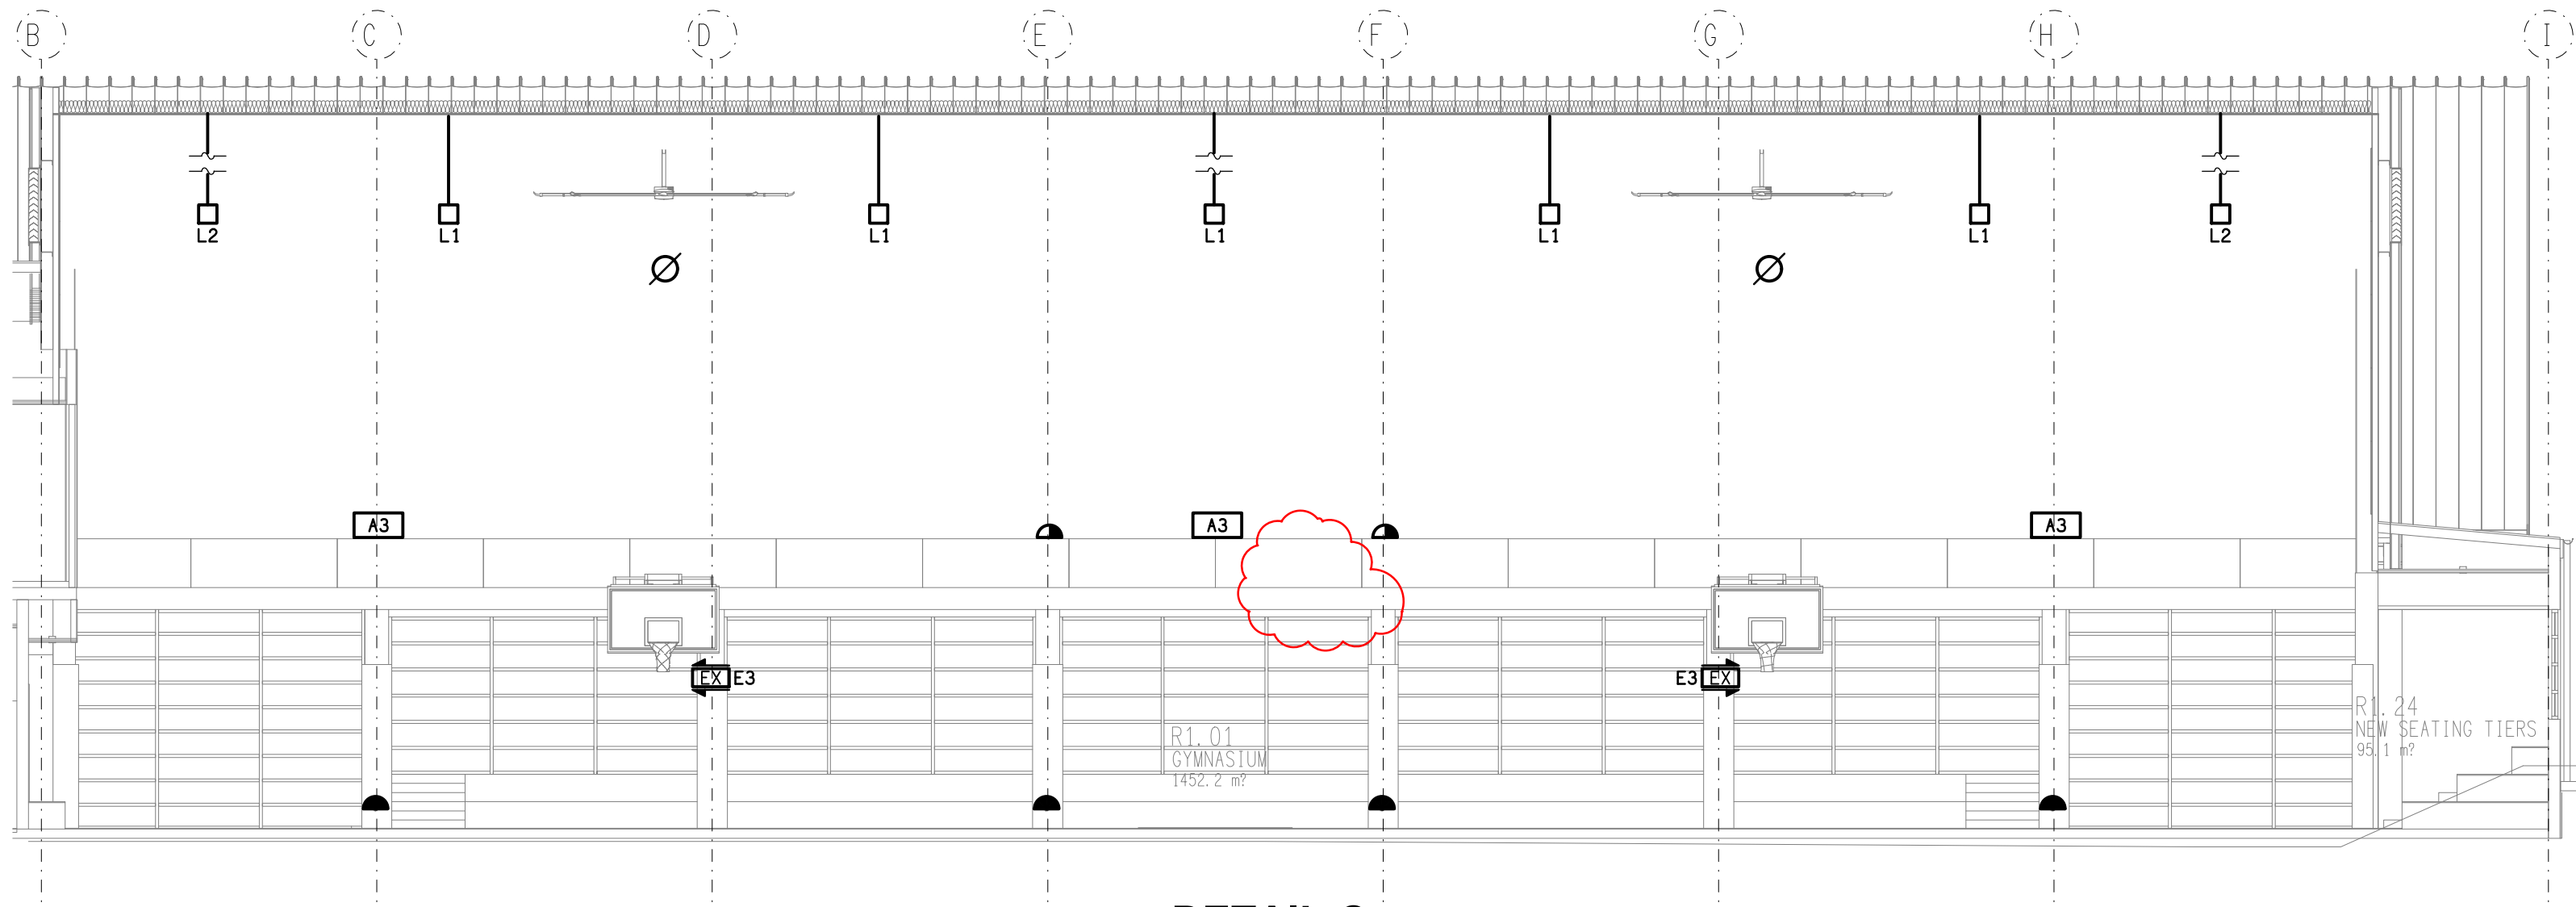

**DETAIL C**  
COURT WALL SECTION  
SCALE 1: 100

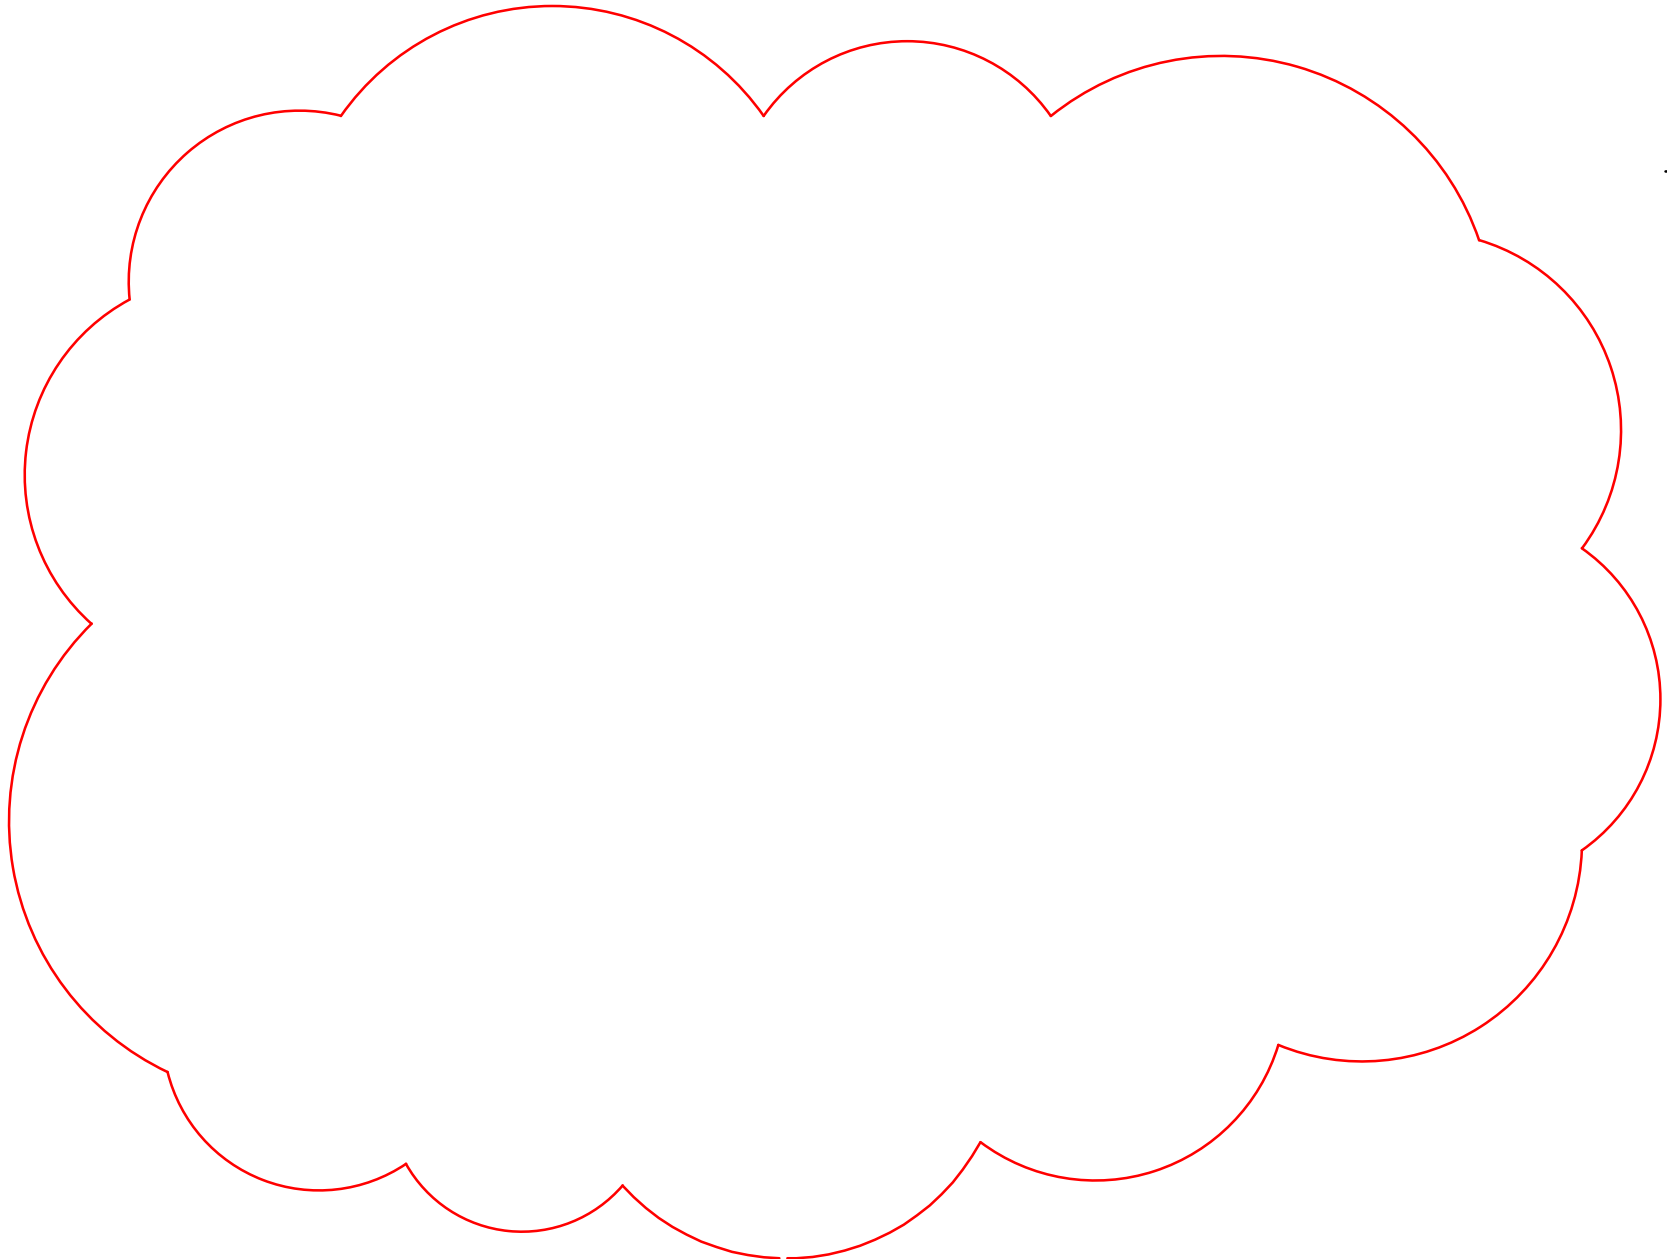

THE COPYRIGHT OF THIS DRAWING REMAINS THE PROPERTY OF THE ELECTRICAL DESIGN GROUP.

USE FIGURED DIMENSIONS IN PREFERENCE TO SCALE.

ALL DIMENSIONS TO BE VERIFIED ONSITE.

D	CONSTRUCTION	10/12/2019
REV:	DESCRIPTION:	DATE:

**ELECTRICAL DESIGN GROUP**  
ELECTRICAL BUILDING SERVICES CONSULTANTS

BRISBANE: P.O. Box 15, Sherwood Qld 4075  
Phone: (07) 3278 4375  
Email: brisbane@edg.net.au  
Web: www.edg.net.au

ELECTRICAL DESIGN GROUP BRISBANE PTY LTD  
ACN 092 710 793

TRADING AS:  
ELECTRICAL DESIGN  
GROUP

PROJECT:

**ST JOHN'S ANGLICAN  
COLLEGE, FOREST LAKE  
COVERED COURT**

SITE ADDRESS:

COLLEGE AVENUE, FOREST LAKE

SCALE: SHEET SIZE:

1:100 AT A1

DRAWING TITLE:

**ELECTRICAL SERVICES  
COURT WALL SECTIONS**

PROJECT NO: DRAWING NO: REVISION:

**C2049a E07 D**