



SCHEMATIC
LIGHTING CONTROL
NOT TO SCALE

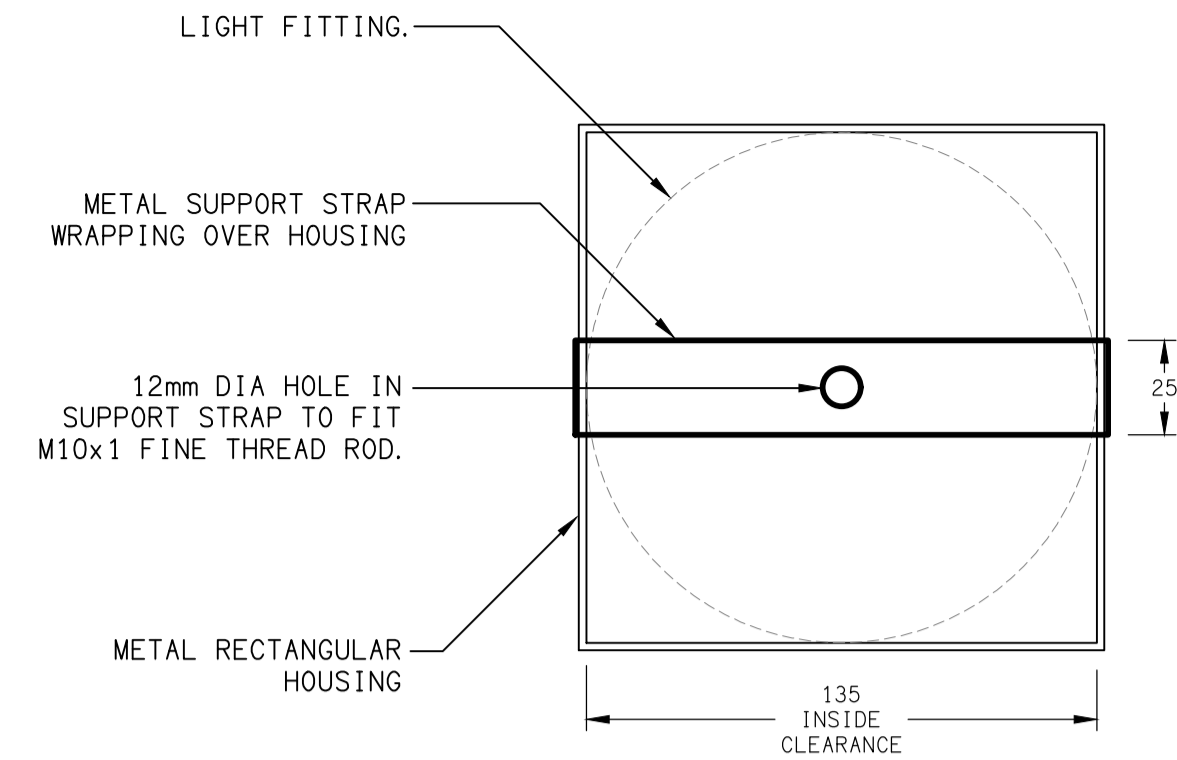

PLAN VIEW

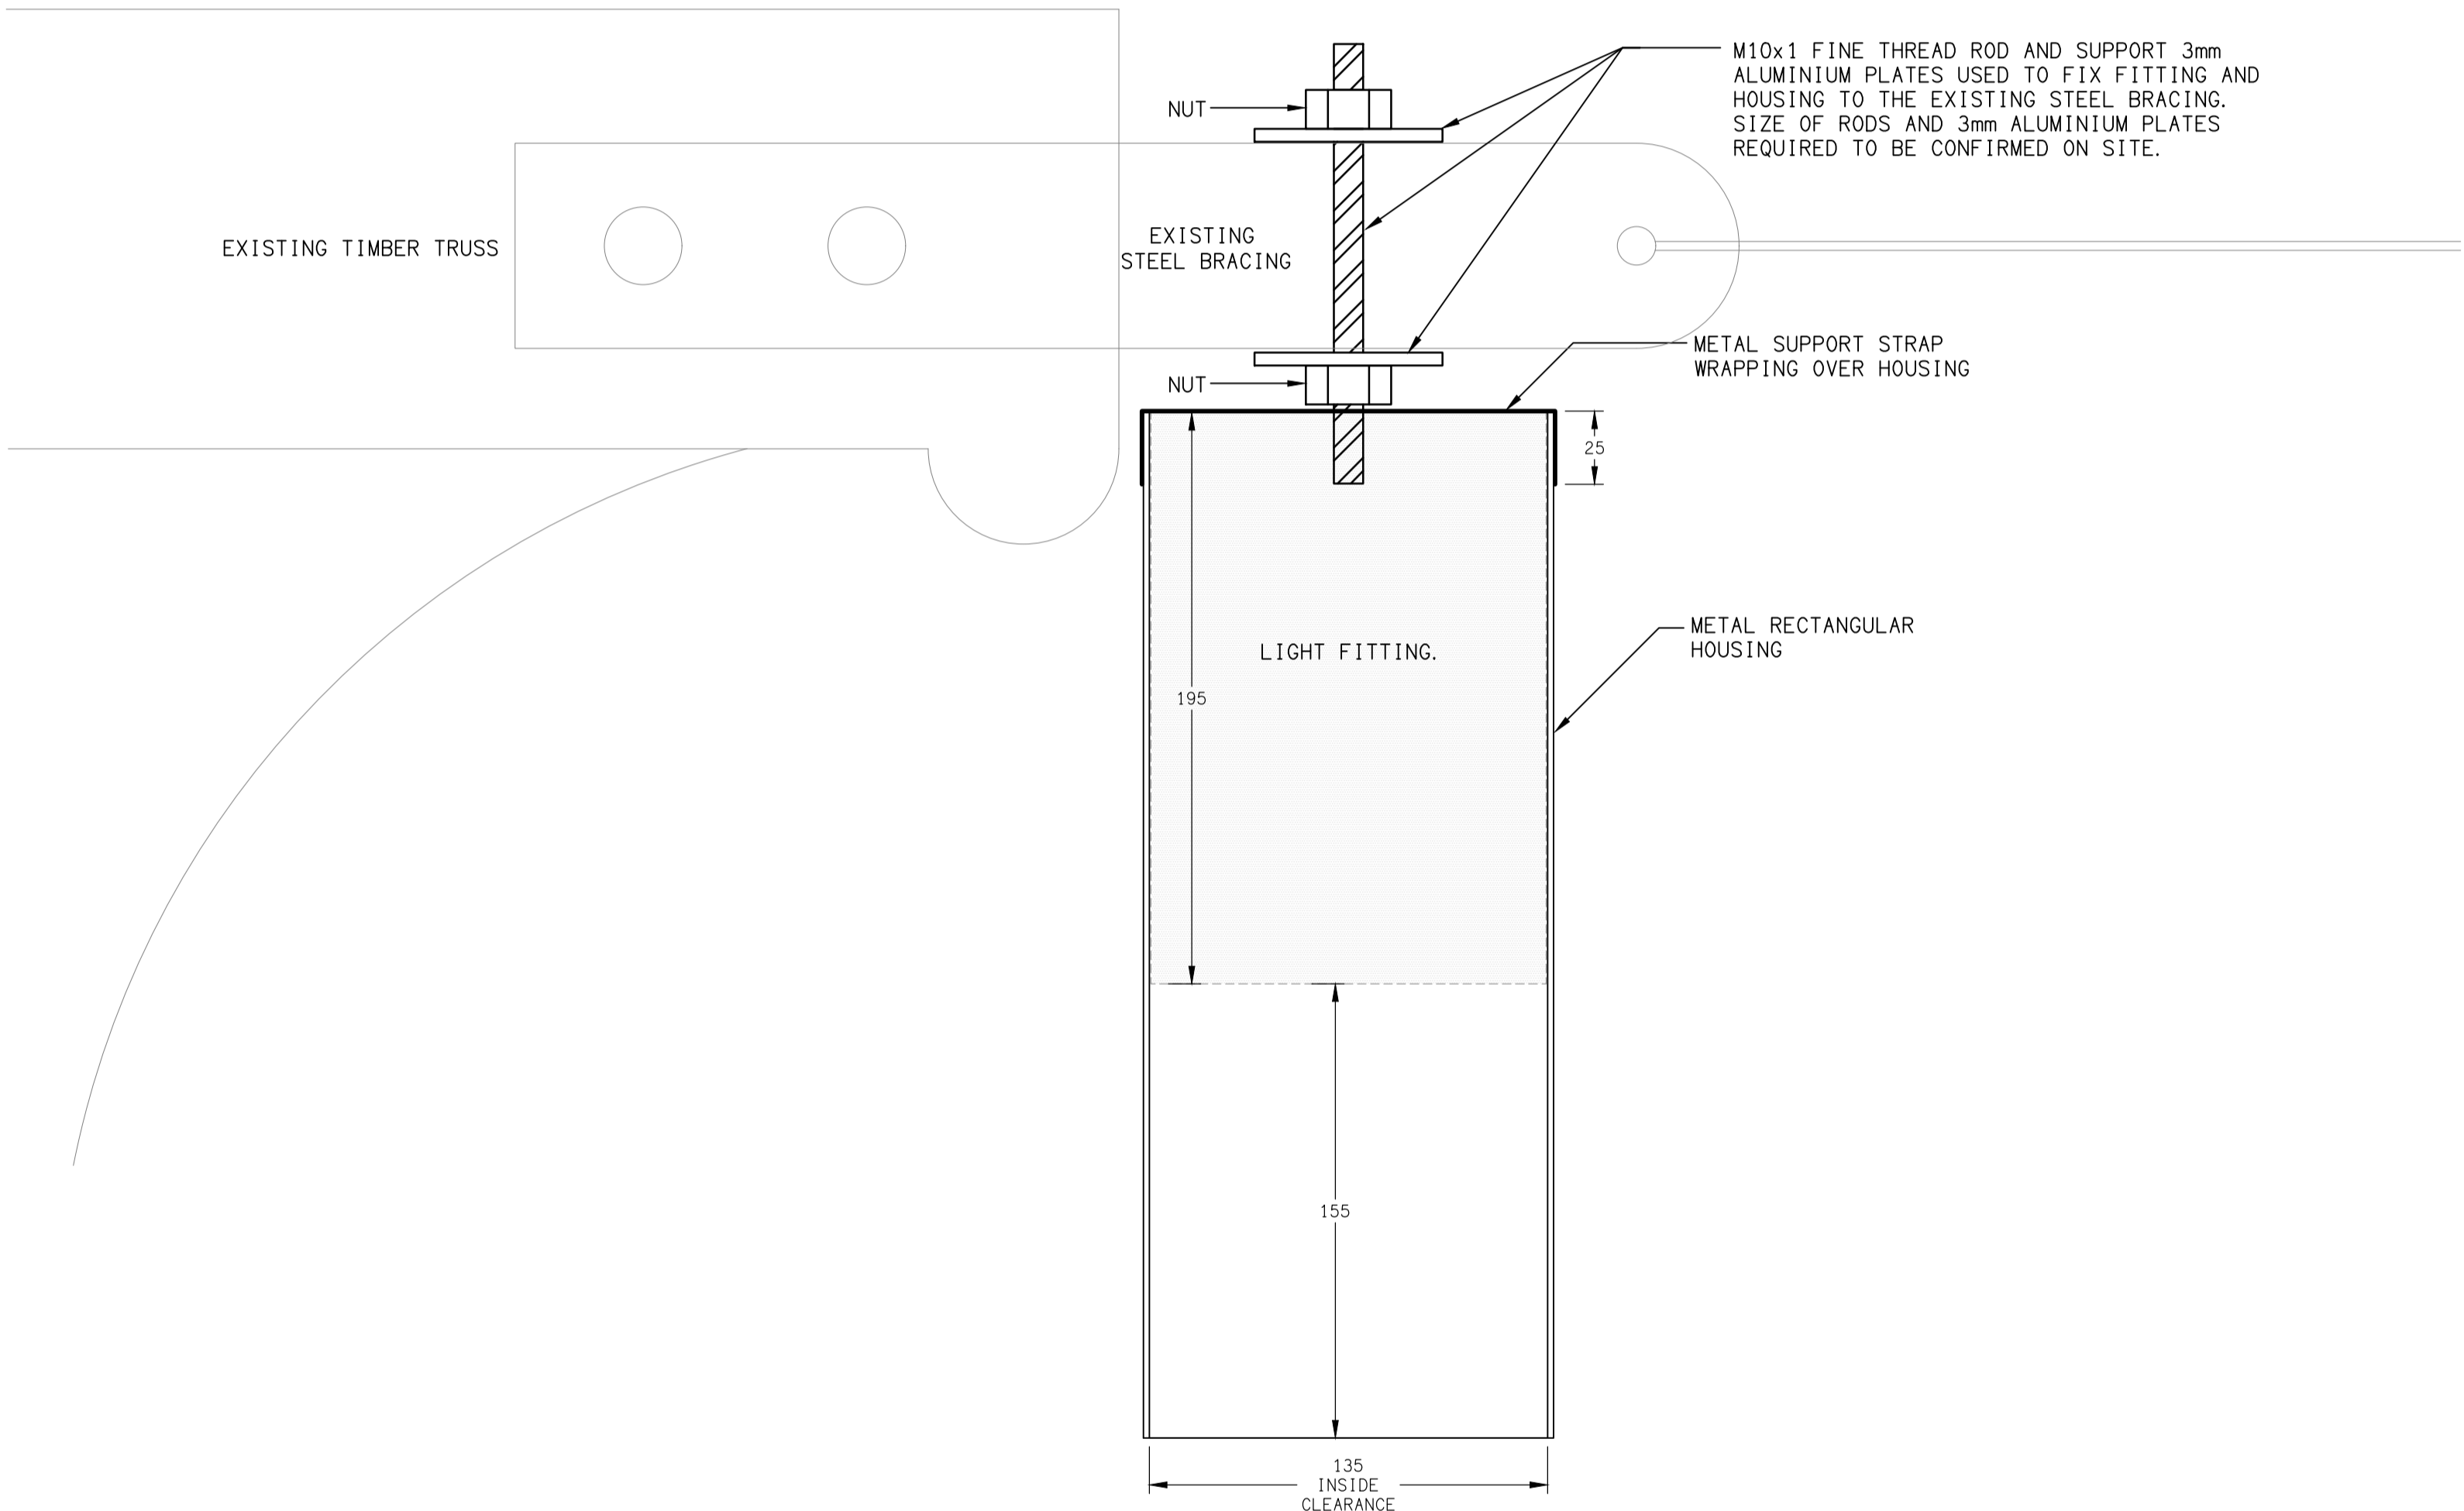

ELEVATION VIEW

DETAIL A
FITTINGS L1 TO L5
SCALE 1 : 2

ELECTRICAL DESIGN GROUP BRISBANE
PTY LTD
ACN 092 710 793

TRADING AS:
ELECTRICAL DESIGN GROUP

THE COPYRIGHT OF THIS DRAWING
REMAINS THE PROPERTY OF THE
ELECTRICAL DESIGN GROUP.

USE FIGURED DIMENSIONS
IN PREFERENCE TO SCALE.

ALL DIMENSIONS TO BE
VERIFIED ONSITE.

ELECTRICAL DESIGN GROUP
ELECTRICAL BUILDING SERVICES CONSULTANTS
BRISBANE GOLD COAST

P.O.Box 15, Sherwood Q.4075
Phone: (07) 3278 4375
Email: brisbane@edg.net.au
Web: www.edg.net.au

PROJECT:
**CATHEDRAL OF ST MICHAEL & ST JOHN
BATHURST - SCHEMATIC DESIGN**

CORNER WILLIAM STREET & KEPPEL STREET, BATHURST, NSW

B	CONSTRUCTION	19/03/2020
REV.	DESCRIPTION:	DATE:

DRAWING:
**ELECTRICAL SERVICES
LIGHTING CONTROL SCHEMATIC**

SCALE:
NOT TO SCALE AT A1

PROJECT NO:
C2057a

DRAWING NO:
W07

REVISION:
B