



DETAIL A

VISUAL ARTS & MAKER SPACE FEATURE CEILING MOUNTING
NOT TO SCALE

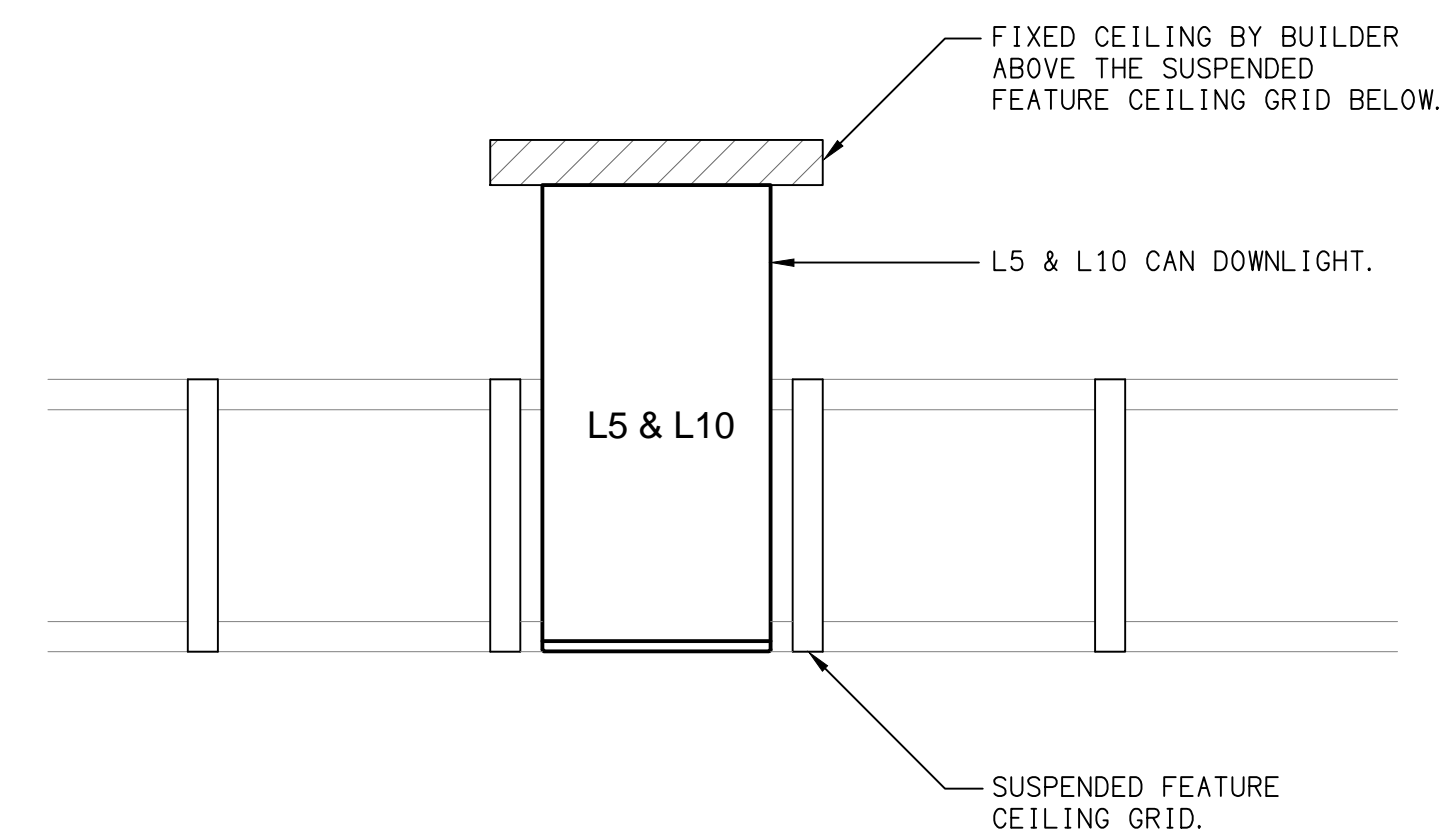

DETAIL B

VISUAL ARTS & MAKER SPACE FEATURE CEILING MOUNTING
NOT TO SCALE

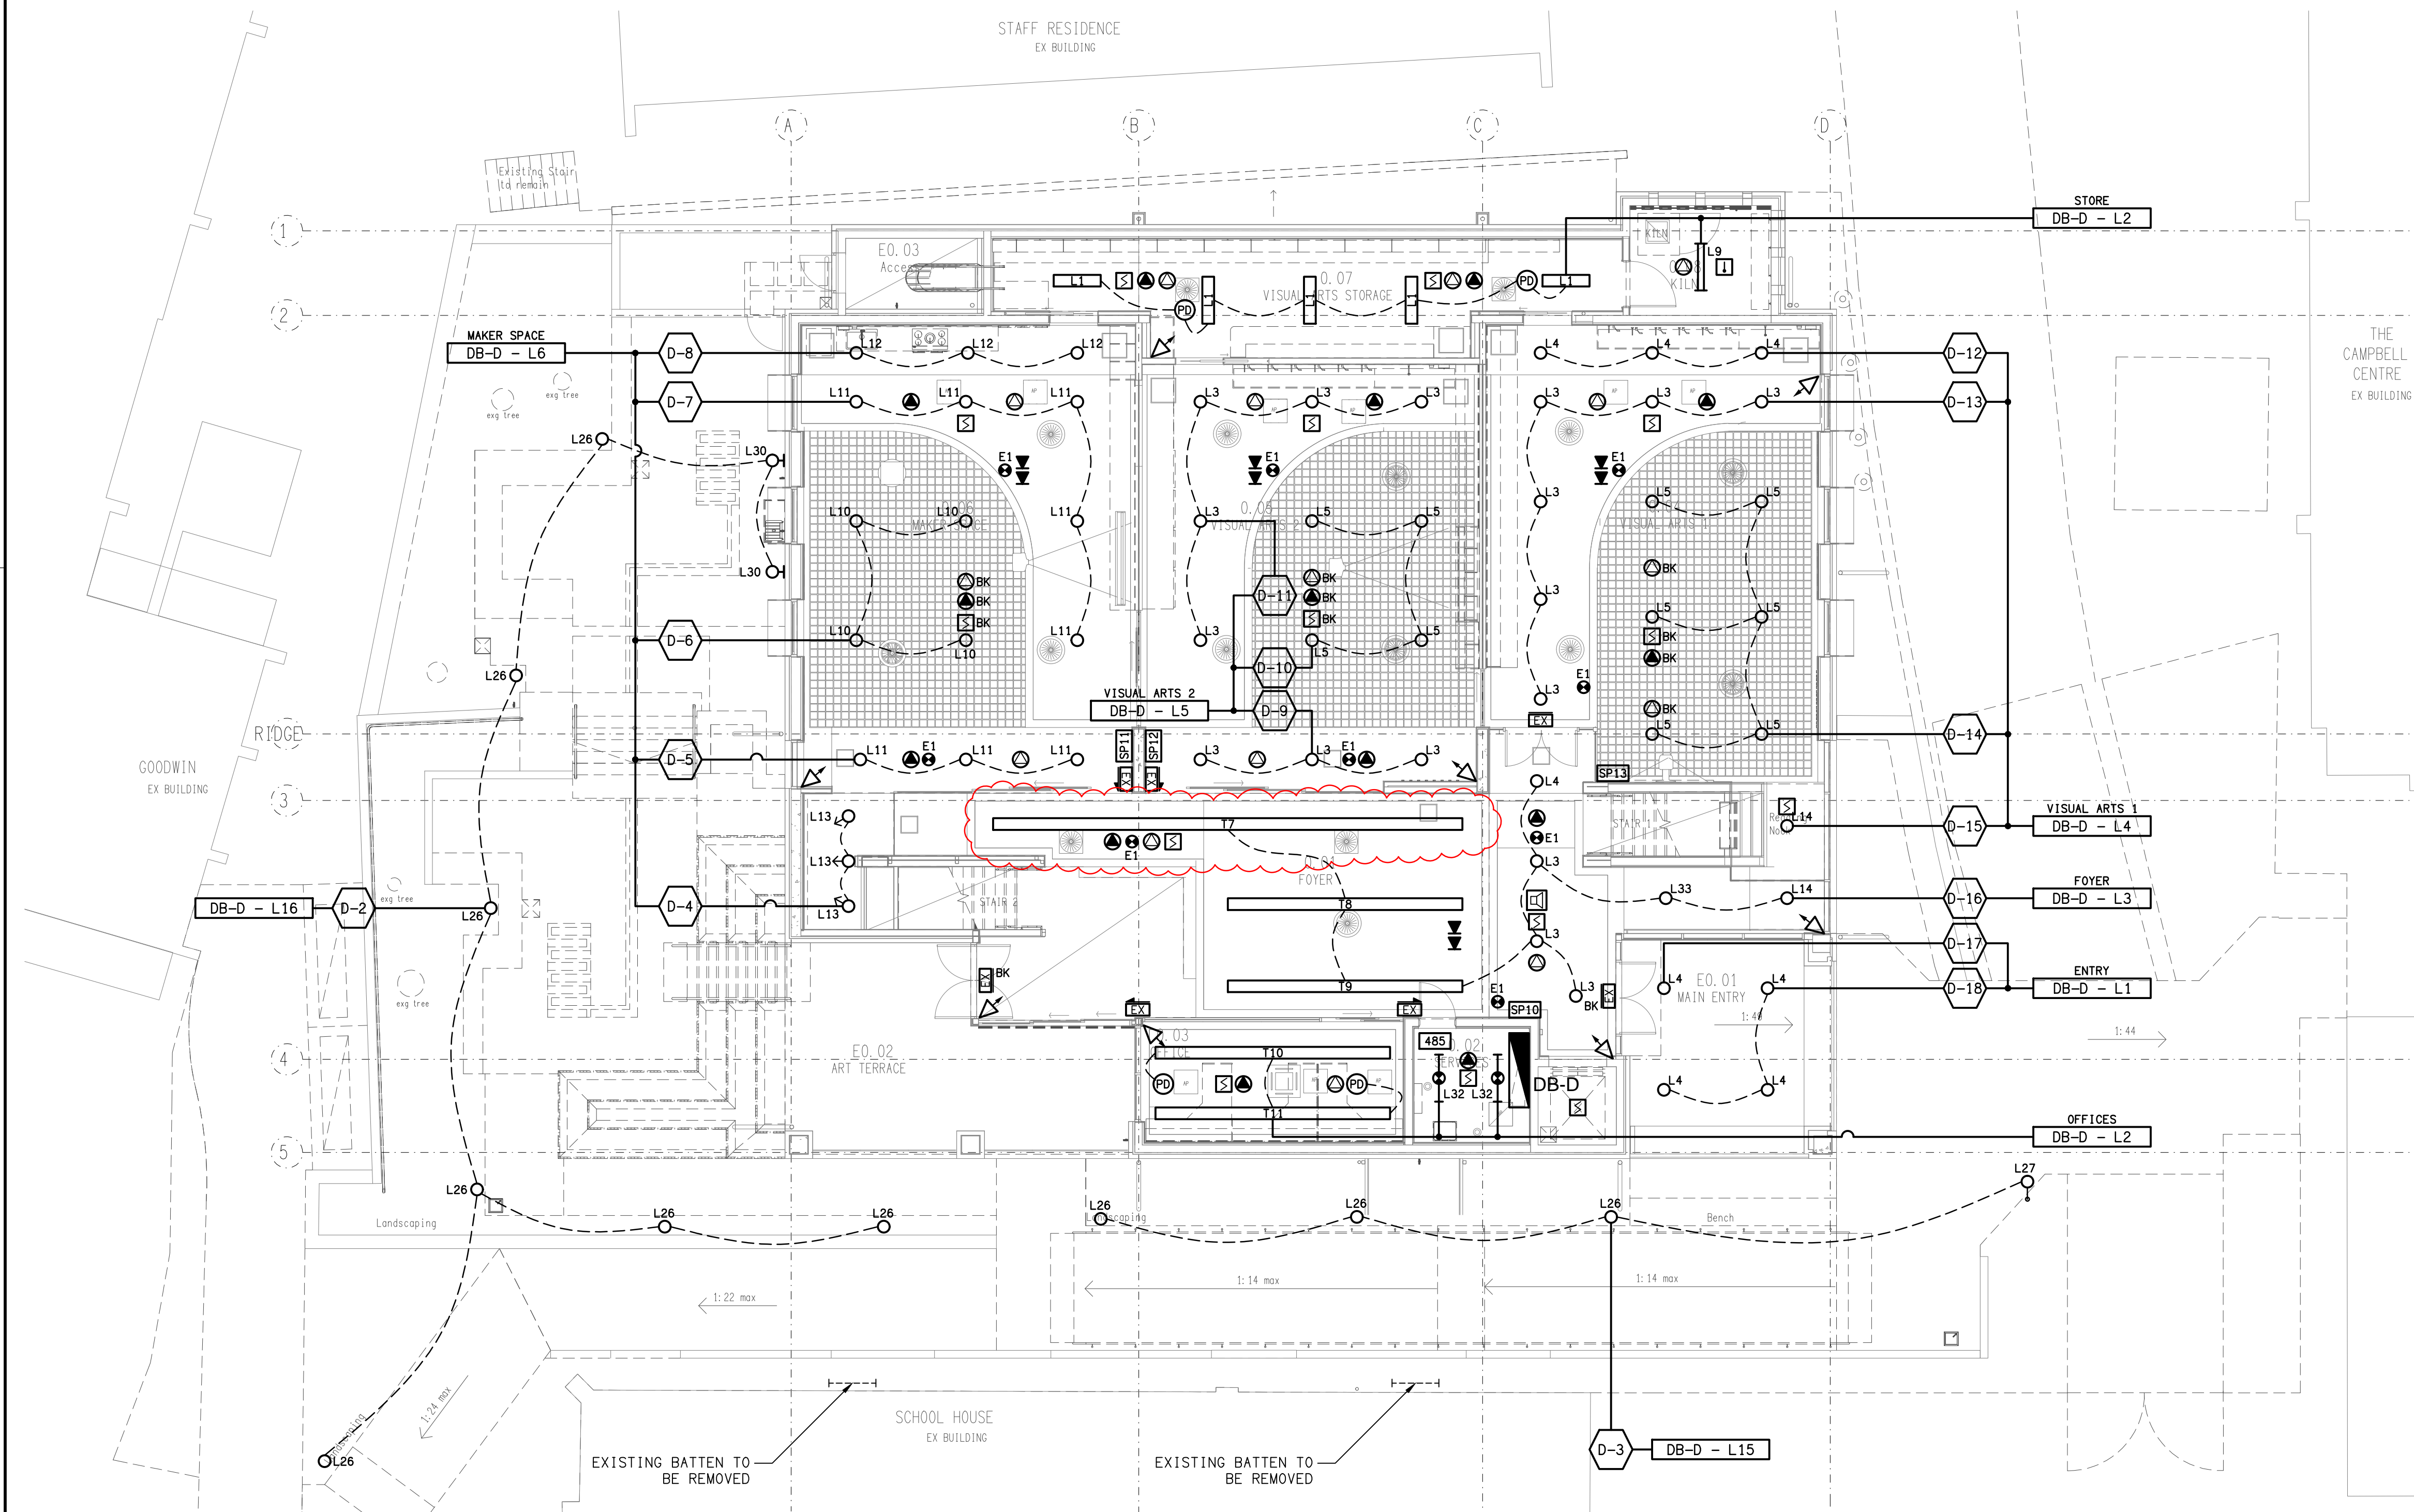

ELECTRICAL DESIGN GROUP BRISBANE
PTY LTD
ACN 092 710 793
TRADING AS:
ELECTRICAL DESIGN GROUP

THE COPYRIGHT OF THIS DRAWING
REMAINS THE PROPERTY OF THE
ELECTRICAL DESIGN GROUP.
USE FIGURED DIMENSIONS
IN PREFERENCE TO SCALE.
ALL DIMENSIONS TO BE
VERIFIED ONSITE.

ELECTRICAL DESIGN GROUP
ELECTRICAL BUILDING SERVICES CONSULTANTS
BRISBANE GOLD COAST

P.O. Box 15, Sherwood Q.4075
Phone: (07) 3278 4375
Email: brisbane@edg.net.au
Web: www.edg.net.au

PROJECT:
ANGLICAN CHURCH GRAMMAR SCHOOL
VIKING CAFE & PREP SCHOOL GLAS

OAKLANDS PARADE, EAST BRISBANE

C4	CONSTRUCTION	04/12/2020
REV:	DESCRIPTION:	DATE:

DRAWING:	PROJECT NO:	DRAWING NO:	REVISION:
ELECTRICAL SERVICES			
PREP SCHOOL GLAS			
GROUND LEVEL REFLECTED CEILING PLAN			
SCALE:	AT A1	C2083a	E08
1:100			C4