


1 0.04 ROOM DETAIL PLAN  
1 : 50

#### NOTE

OUTLET QUANTITIES AND LOCATIONS SHOWN ON THIS DRAWING ARE INDICATIVE ONLY. OUTLET QUANTITIES AND LOCATIONS SHOWN ON THE FLOOR PLANS & REFLECTED CEILING PLANS TAKE PRECEDENCE OVER OUTLETS SHOWN ON THIS DRAWING.

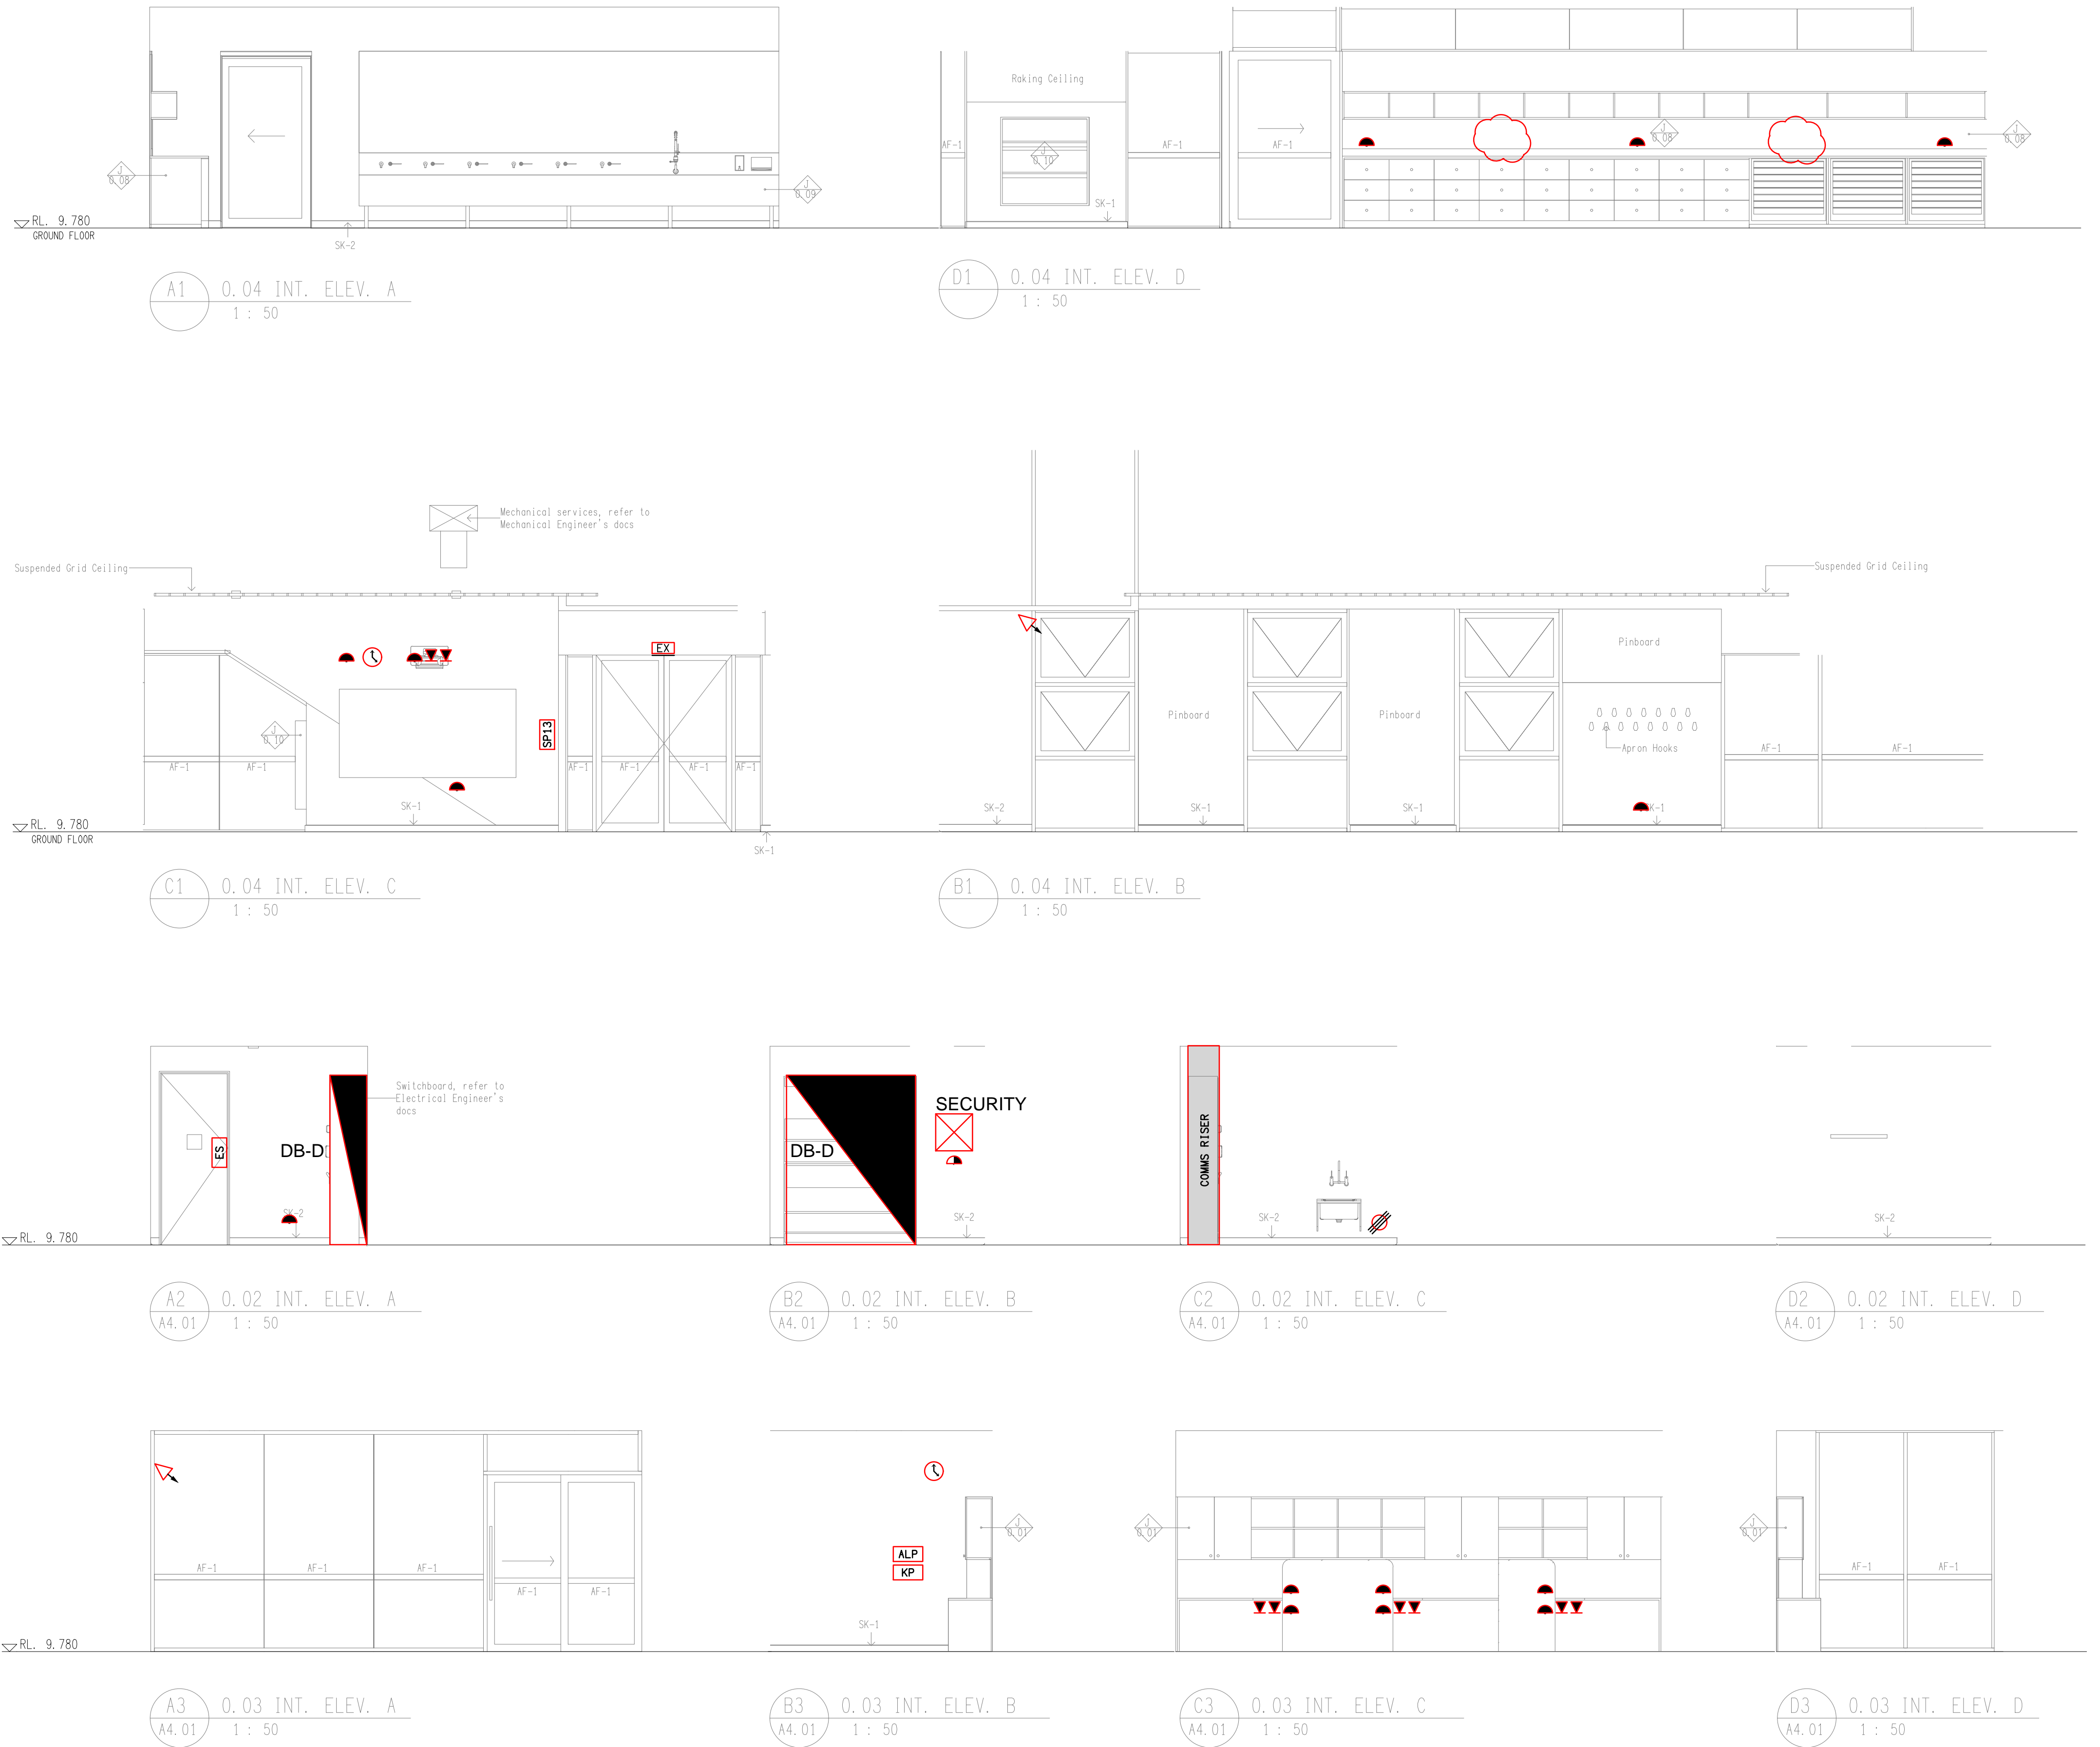

C3	CONSTRUCTION	01/07/2020
REV.	DESCRIPTION:	DATE:
DRAWING:	<b>ELECTRICAL SERVICES</b> <b>PREP SCHOOL GLAS</b> <b>JOINERY &amp; WALL ELEVATIONS</b>	
SCALE:	PROJECT NO:	DRAWING NO:
NTS	AT A1	<b>C2083a PRE-A4.03 C3</b>

ELECTRICAL DESIGN GROUP BRISBANE  
PTY LTD  
ACN 092 710 793  
TRADING AS:  
ELECTRICAL DESIGN GROUP

THE COPYRIGHT OF THIS DRAWING  
REMAINS THE PROPERTY OF THE  
ELECTRICAL DESIGN GROUP.  
USE FIGURED DIMENSIONS  
IN PREFERENCE TO SCALE.  
ALL DIMENSIONS TO BE  
VERIFIED ON SITE.

**ELECTRICAL DESIGN GROUP**  
ELECTRICAL BUILDING SERVICES CONSULTANTS  
BRISBANE GOLD COAST  
P.O.Box 15, Sherwood Q.4075  
Phone: (07) 3278 4375  
Email: brisbane@edg.net.au  
Web: www.edg.net.au

PROJECT:  
**ANGLICAN CHURCH GRAMMAR SCHOOL**  
**VIKING CAFE & PREP SCHOOL GLAS**  
**OAKLANDS PARADE, EAST BRISBANE**