


DETAIL A
ELECTRICAL CONTROL ROOM
SCALE 1:50

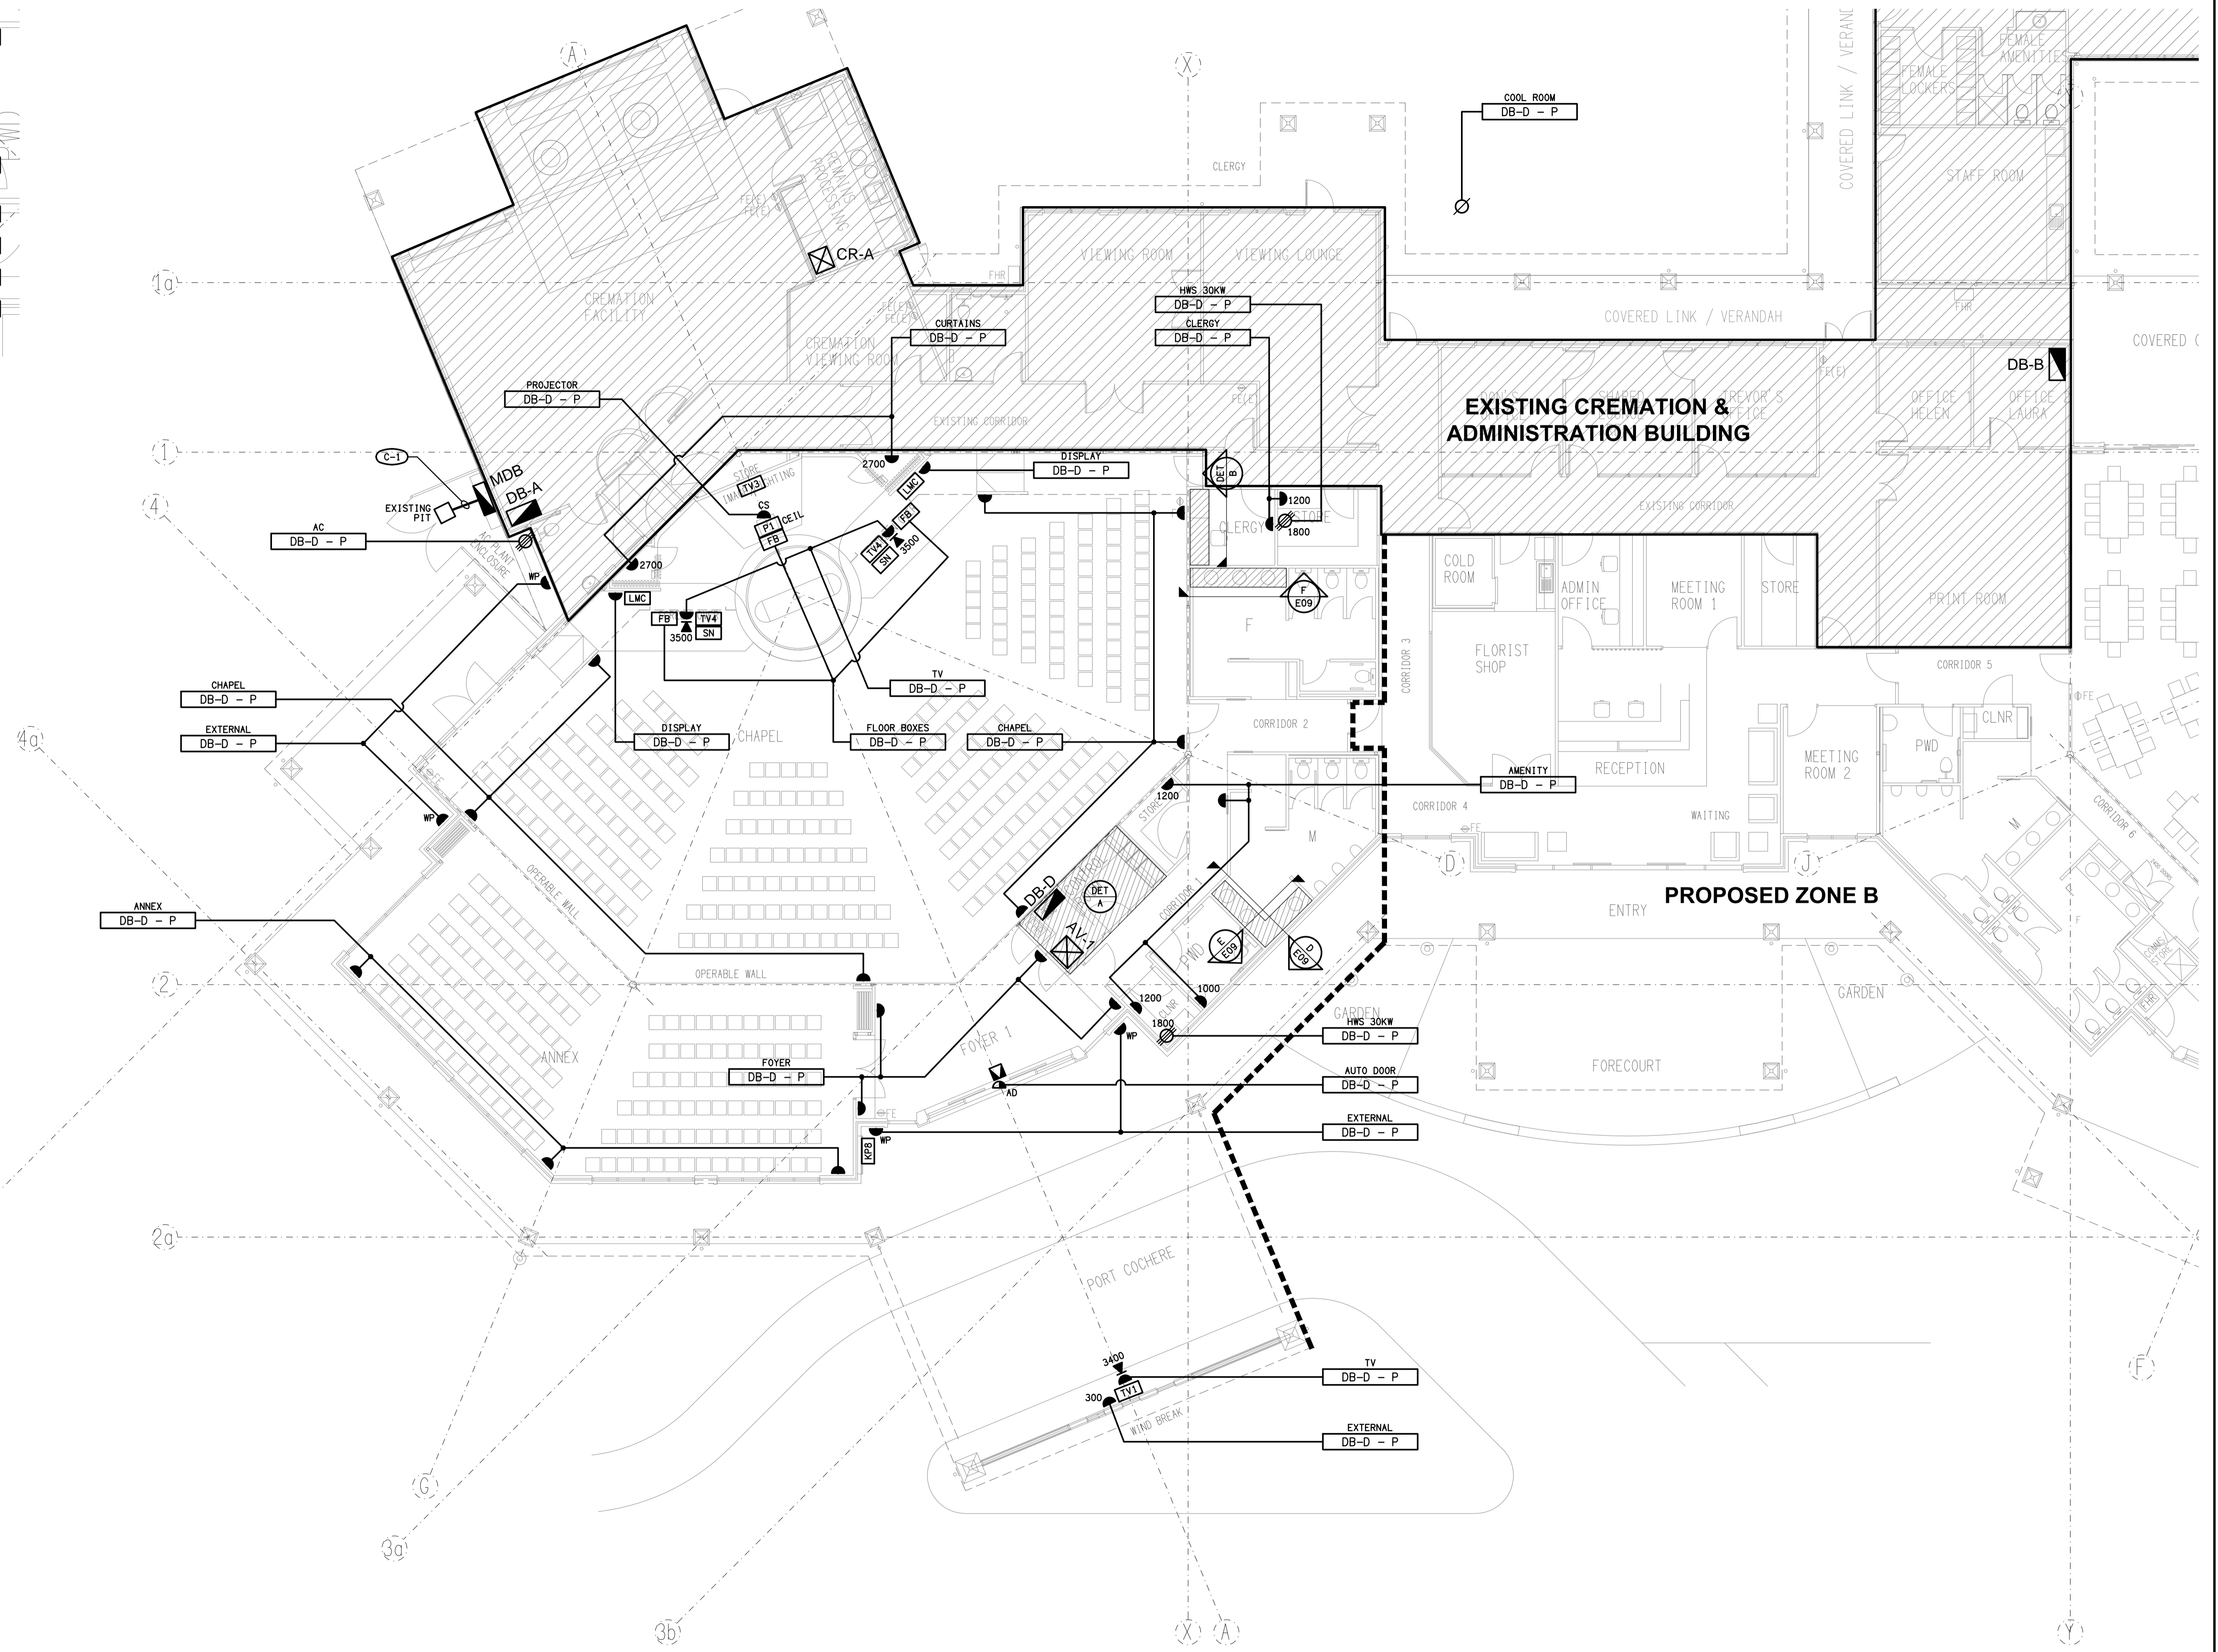


REV	DATE	DESCRIPTION
E	28/01/2022	PRELIMINARY

ELECTRICAL DESIGN GROUP
ELECTRICAL BUILDING SERVICES CONSULTANTS
BRISBANE GOLD COAST
P.O. Box 15, Sherwood Q. 4075
Phone: (07) 3278 4375
Email: brisbane@edg.net.au
Web: www.edg.net.au

CLIENT
T.S BURSTOW FUNERALS
BURSTOWS
Funeral Care Since 1900

PROJECT
BURSTOWS FUNERAL PARLOUR - STAGE 3
1020 RUTHVEN STREET, TOOWOOMBA

DRAWING TITLE
ELECTRICAL SERVICES FLOOR PLAN ZONE A

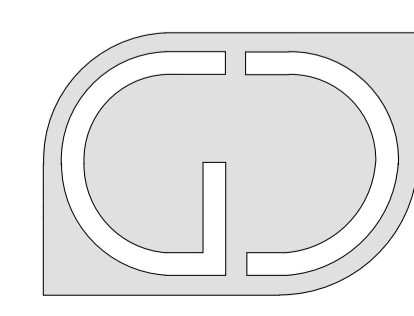

G+D GROUP (QLD)
Level 3 Toowong Terraces
31 Sherwood Road Toowong Q 4066
T (07) 3870 3722
F (07) 3870 3822
E admin@gdgroupqld.com.au

DATE	SCALE	AT
	1:100	A1

C2221a
EDG PROJECT No.
E03
EDG DWG No. REV