

 
 
 
 


 

 






LEGEND

-  ELECTRICAL SWITCHBOARD.
-  EXISTING POWER OUTLET TO BE RECONNECTED.
-  LIGHTING CHANNEL REFERENCE.
-  L1: 1 x 550W 5000K FITTING MOUNTED ON A BLACK 8m HIGH POLE, CONFIGURED AS PART OF THE FENCE. TYPE: SYLVANIA TITTA 33075.
-  L2: 2No. 1 x 550W 5000K FITTING MOUNTED ON A BLACK 8m HIGH POLE, CONFIGURED AS PART OF THE FENCE. EACH FITTING IS TO BE SEPARATELY WIRED. TYPE: SYLVANIA TITTA 33075.
-  L3: EXISTING BATTEN FITTING TO BE RECONNECTED AS PER THE CONTROL SCHEMATIC.
-  SPA-D: WEATHERPROOF PUSH BUTTONS MOUNTED IN A METAL HOUSING LOCATED ON THE FENCE POST INSIDE THE GATE OF EACH COURT.
-  SPE: EXISTING SWITCH PANEL TO BE RECONFIGURED AS PER THE CONTROL SCHEMATIC.
-  Cx: CONTACTOR LOCATED IN THE DISTRIBUTION BOARD.
-  PE: ADJUSTABLE PE CELL TO PREVENT THE LIGHTS BEING TURNED ON 30MIN. PRIOR TO DUSK.
-  ROT: ADJUSTABLE RUN-ON TIMER LOCATED IN THE DISTRIBUTION BOARD. 30MIN TO 4-HOURS.
-  TC1: TIME CLOCK MOUNTED IN THE DISTRIBUTION BOARD TO PREVENT THE LIGHTS OPERATING AFTER 10.00AM.
-  TC2: TIME CLOCK MOUNTED IN THE DISTRIBUTION BOARD TO PREVENT THE LIGHTS OPERATING AFTER 10.30PM.



HILTON STREET

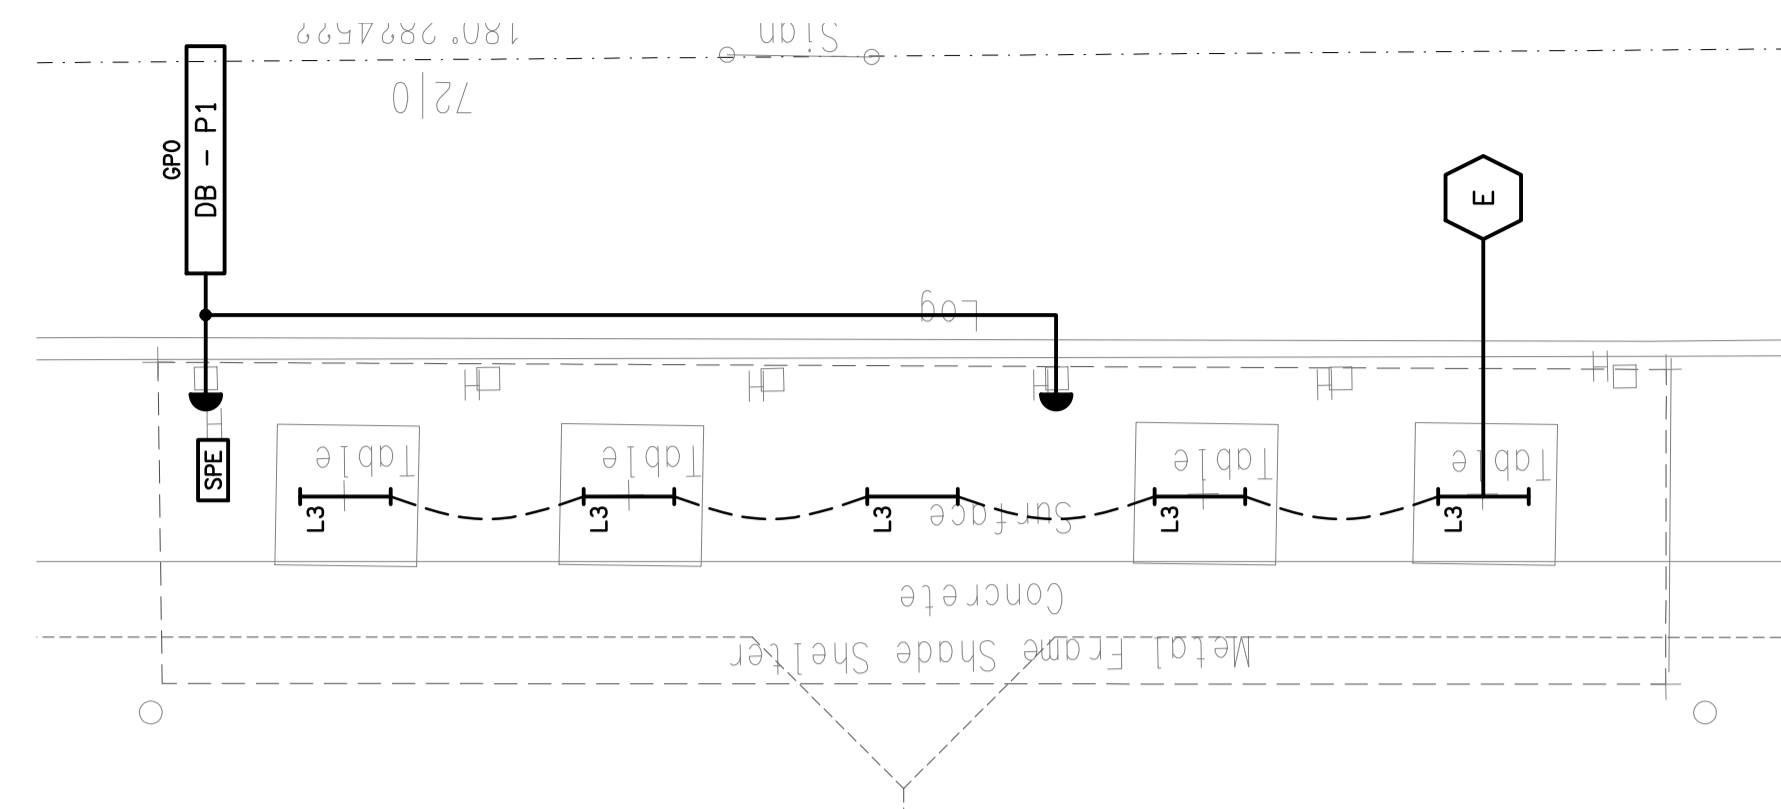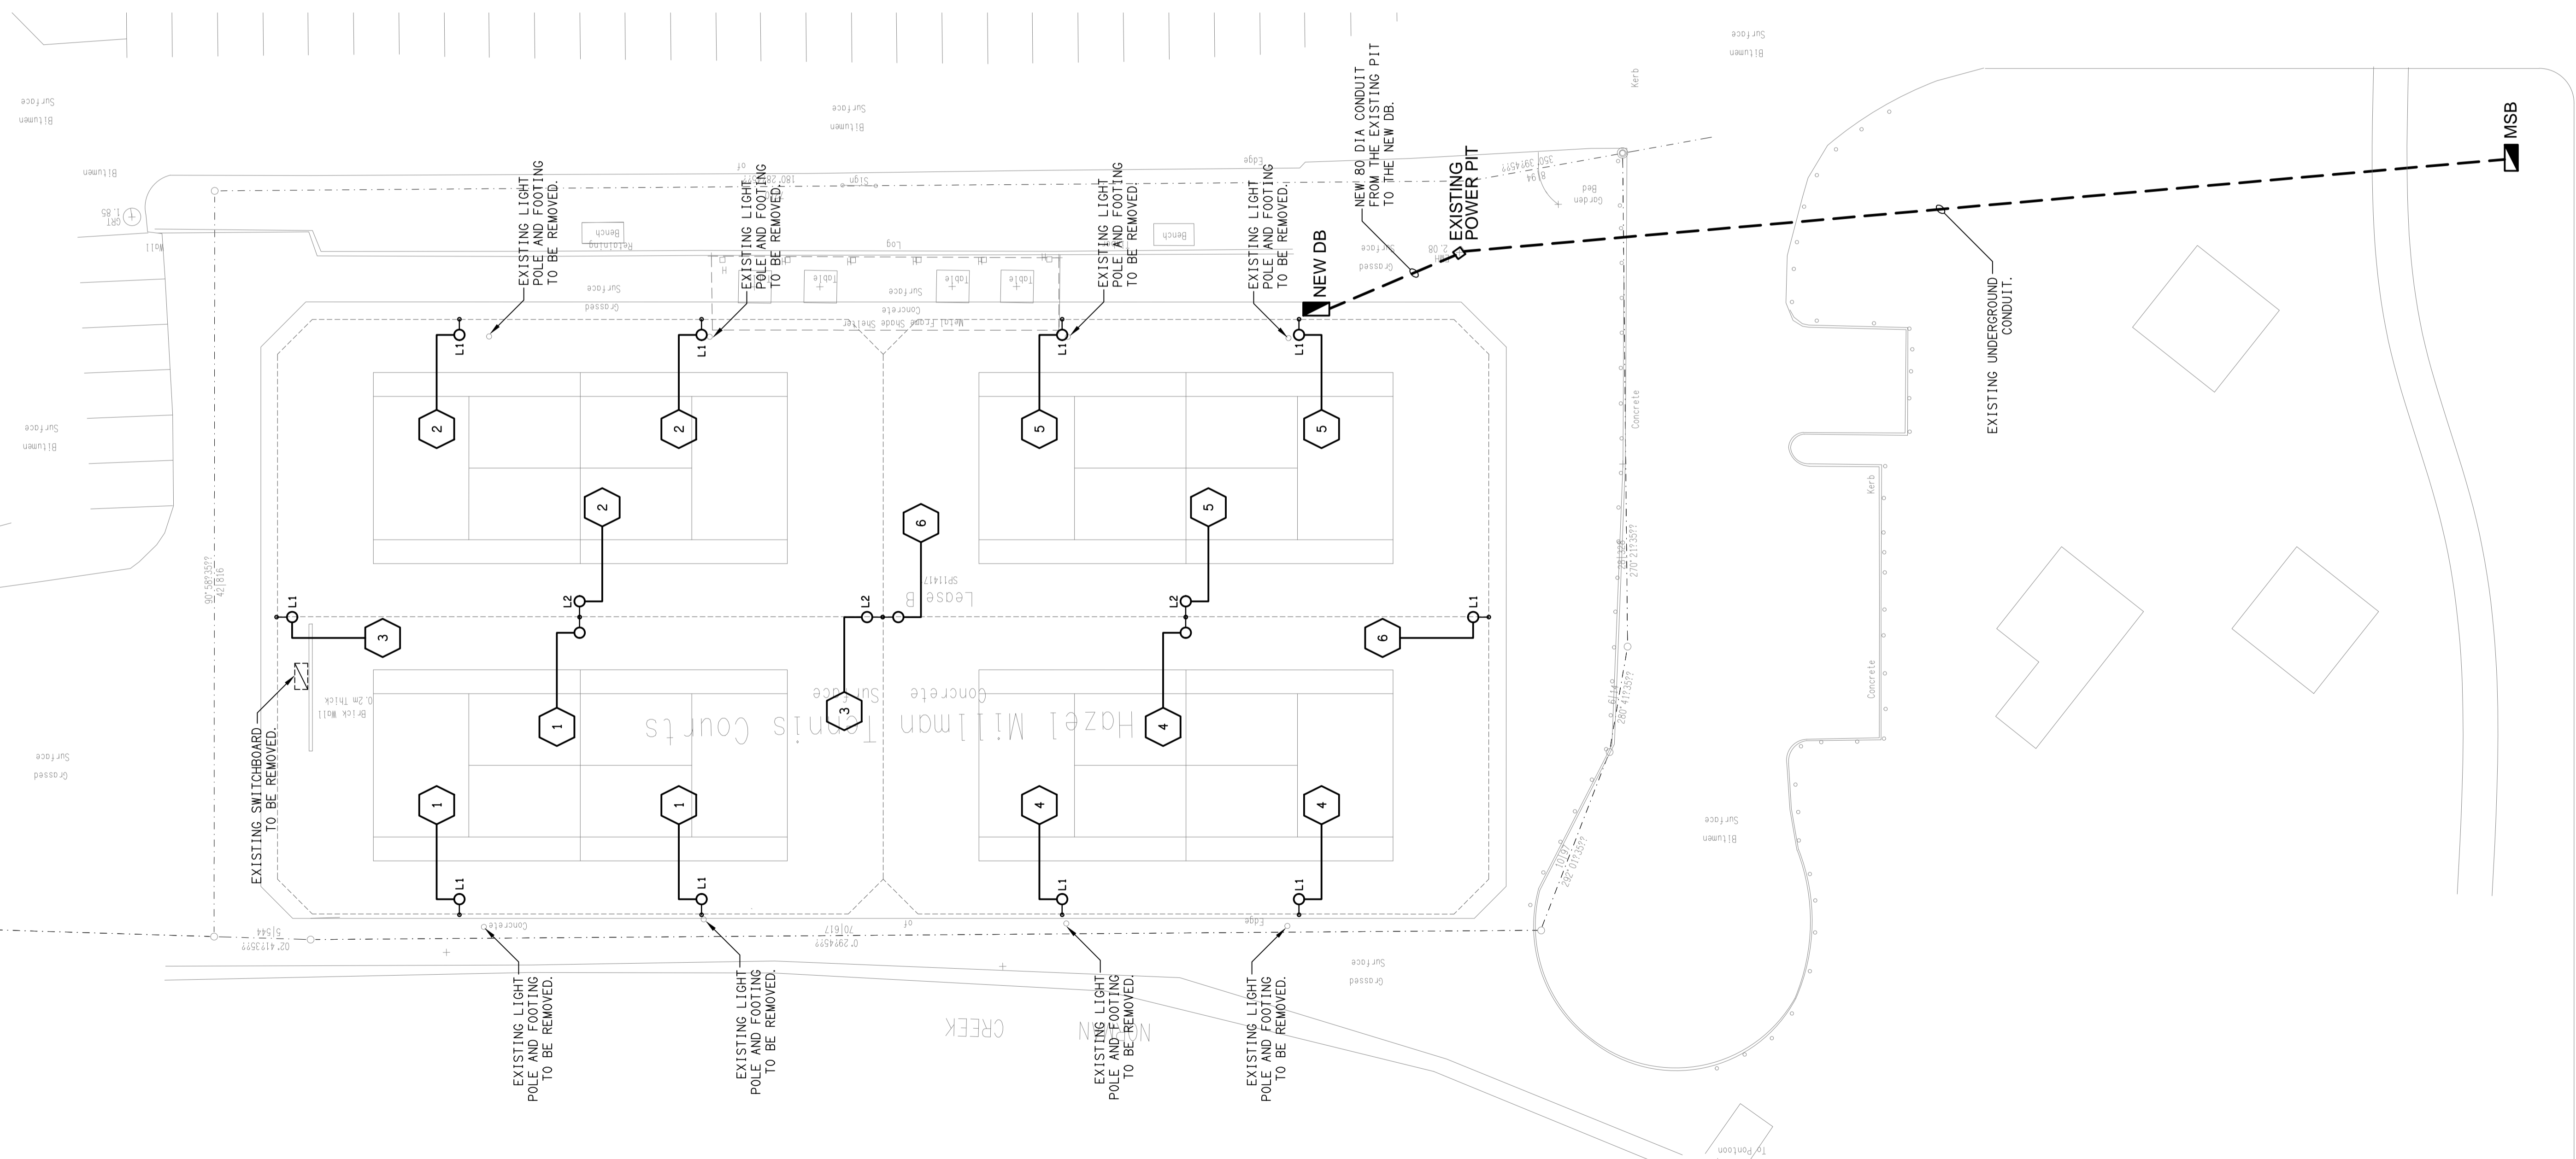COURTS
FLOOR / REFLECTED CEILING PLAN
SCALE 1:200

COVERED AREA
FLOOR / REFLECTED CEILING PLAN
SCALE 1:100

ELECTRICAL DESIGN GROUP BRISBANE
PTY LTD
ACN 092 710 793
TRADING AS:
ELECTRICAL DESIGN GROUP

THE COPYRIGHT OF THIS DRAWING
REMAINS THE PROPERTY OF THE
ELECTRICAL DESIGN GROUP.
USE FIGURED DIMENSIONS
IN PREFERENCE TO SCALE.
ALL DIMENSIONS TO BE
VERIFIED ONSITE.

ELECTRICAL DESIGN GROUP
ELECTRICAL BUILDING SERVICES CONSULTANTS
BRISBANE GOLD COAST
P.O. Box 15, Sherwood Q.4075
Phone: (07) 3278 4375
Email: brisbane@edg.net.au
Web: www.edg.net.au

PROJECT:
**ANGELICAN CHURCH GRAMMAR SCHOOL
HAZEL MILLMAN TENNIS COURTS**
HEATH PARK, HILTON STREET, EAST BRISBANE

C	TENDER	04/09/2020
REV.	DESCRIPTION:	DATE:
DRAWING: ELECTRICAL SERVICES COURTS LIGHTING PLAN		
SCALE: 1:200 & 1:100	AT A1	PROJECT NO: C2226a
		DRAWING NO: E01
		REVISION: C