



DETAIL B
AV WALL ELEVATION 1
SCALE 1:50

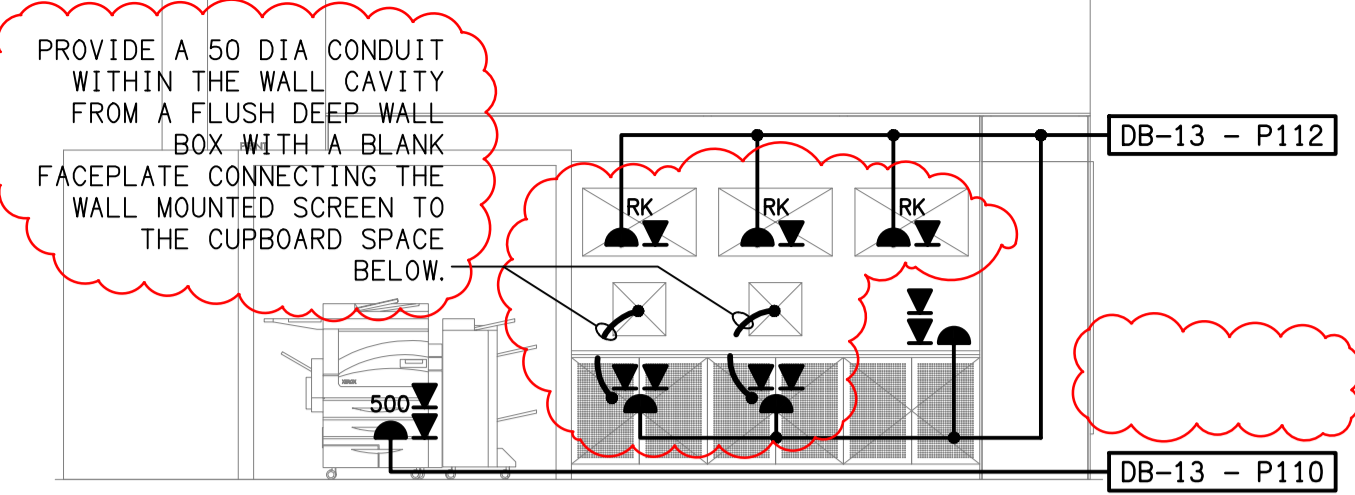

DETAIL C
AV WALL ELEVATION 2
SCALE 1:50

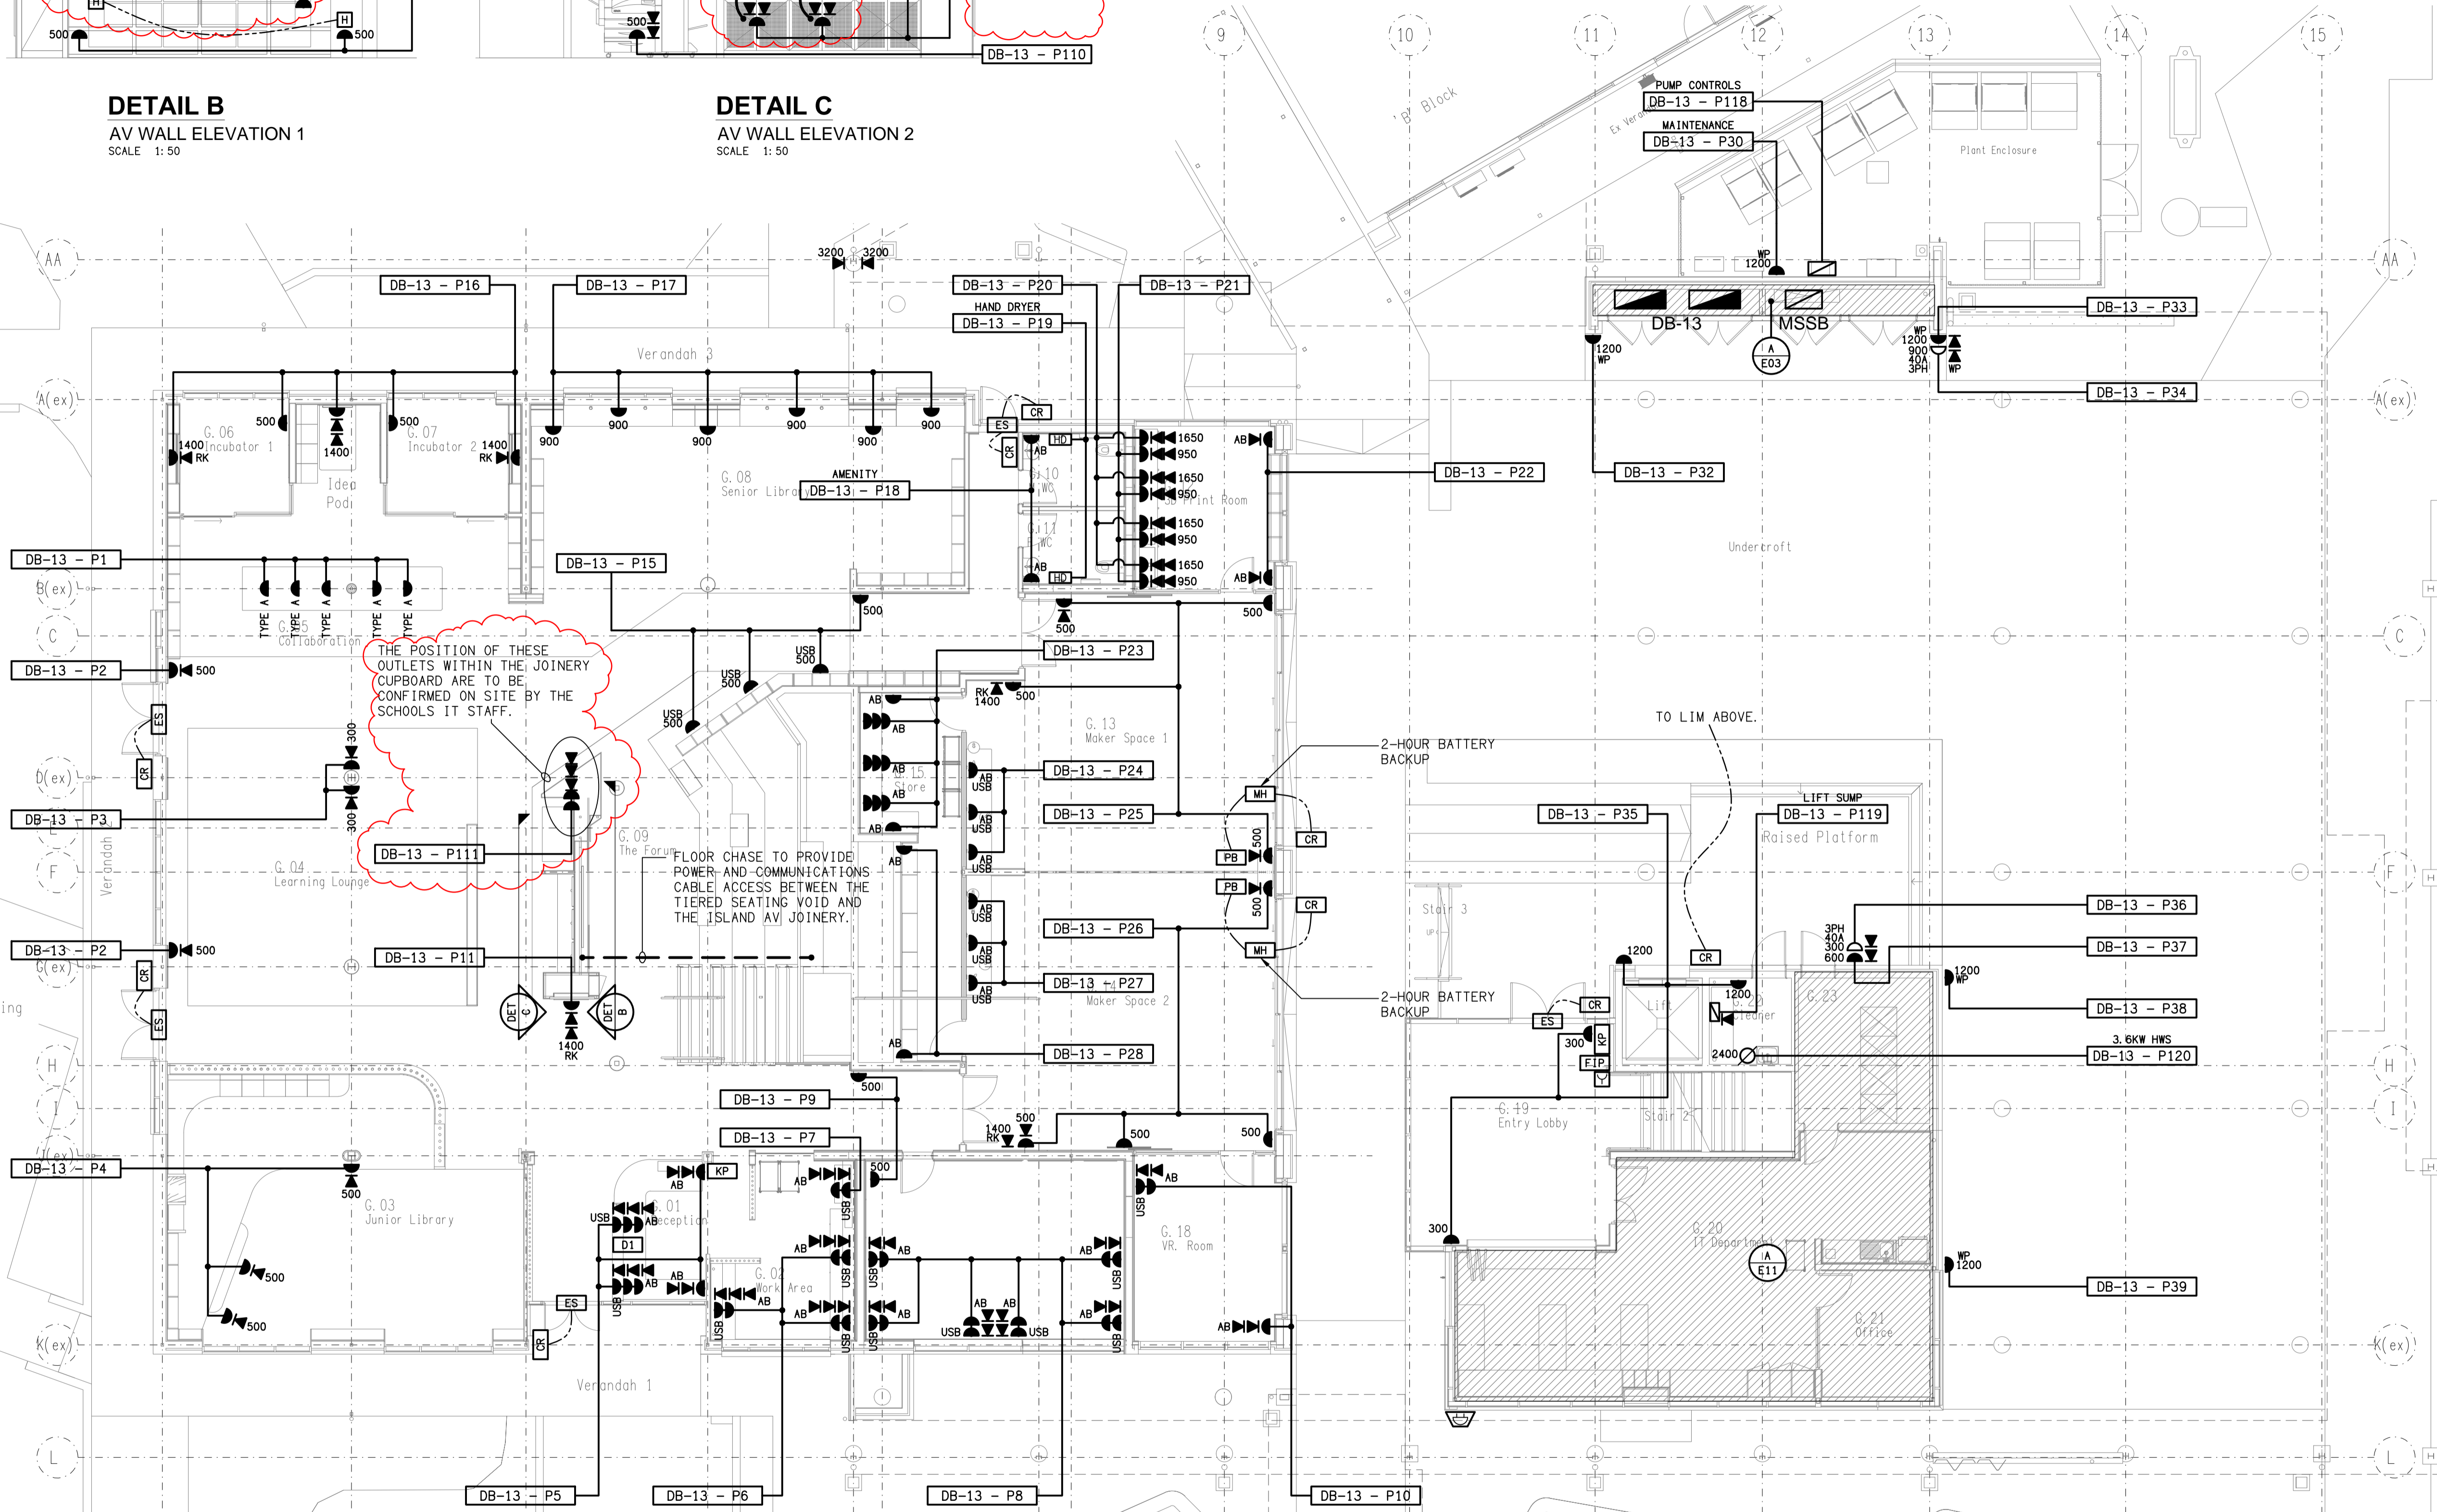

THE POSITION OF THESE OUTLETS WITHIN THE JOINERY CUPBOARD ARE TO BE CONFIRMED ON SITE BY THE SCHOOLS IT STAFF.

FLOOR CHASE TO PROVIDE POWER AND COMMUNICATIONS CABLE ACCESS BETWEEN THE TIERED SEATING VOID AND THE ISLAND AVI JOINERY.

NOTE:
THE POSITION OF ALL ELECTRICAL SERVICES ON THIS DRAWING IS INDICATIVE AND THE FINAL POSITIONS MUST BE TAKEN FROM THE ARCHITECTURAL INTERIOR COORDINATED ELEVATIONS AND CEILING PLANS.

ELECTRICAL DESIGN GROUP BRISBANE
PTY LTD
ACN 092 710 793
TRADING AS:
ELECTRICAL DESIGN GROUP

THE COPYRIGHT OF THIS DRAWING
REMAINS THE PROPERTY OF THE
ELECTRICAL DESIGN GROUP.
USE FIGURED DIMENSIONS
IN PREFERENCE TO SCALE.
ALL DIMENSIONS TO BE
VERIFIED ONSITE.

ELECTRICAL DESIGN GROUP
ELECTRICAL BUILDING SERVICES CONSULTANTS
BRISBANE GOLD COAST

P.O. Box 15, Sherwood Q. 4075
Phone: (07) 3278 4375
Email: brisbane@edg.net.au
Web: www.edg.net.au

PROJECT:
**WHITSUNDAY ANGLICAN SCHOOL
STEAM CENTRE**

2-16 CELEBER DRIVE BEACONSFIELD, MACKAY

L	CONSTRUCTION	31/03/2023
REV:	DESCRIPTION:	DATE:

DRAWING:
**ELECTRICAL SERVICES
GROUND LEVEL FLOOR PLAN**

SCALE: 1:100	AT A1	PROJECT NO: C2237a	DRAWING NO: E05	REVISION: L
-----------------	-------	------------------------------	---------------------------	-----------------------