




EAST ELEVATION

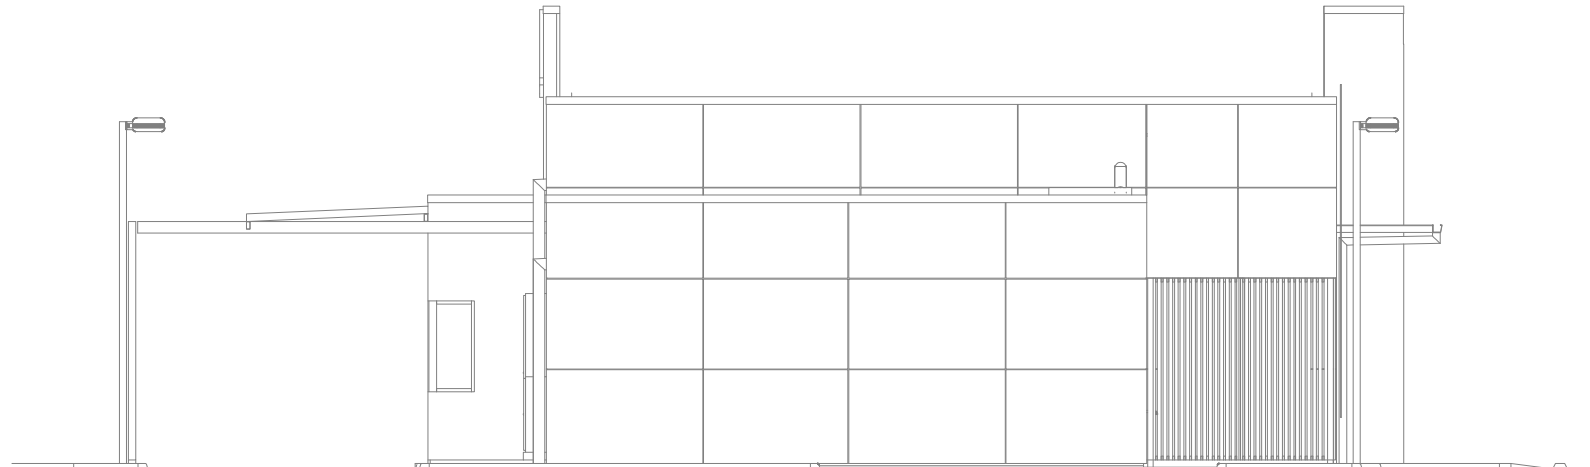

NORTH ELEVATION

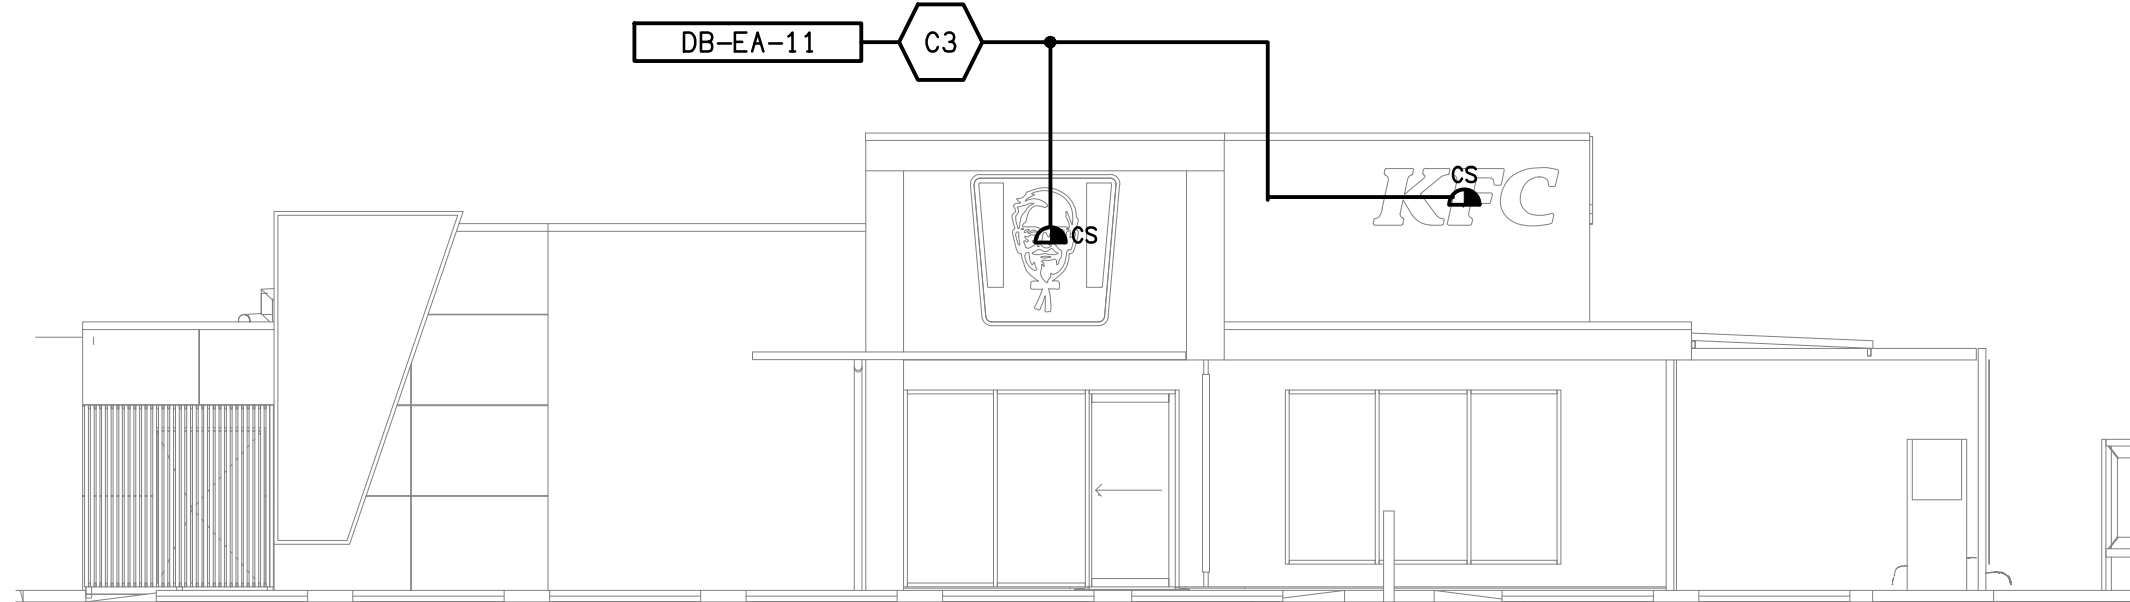


WEST ELEVATION

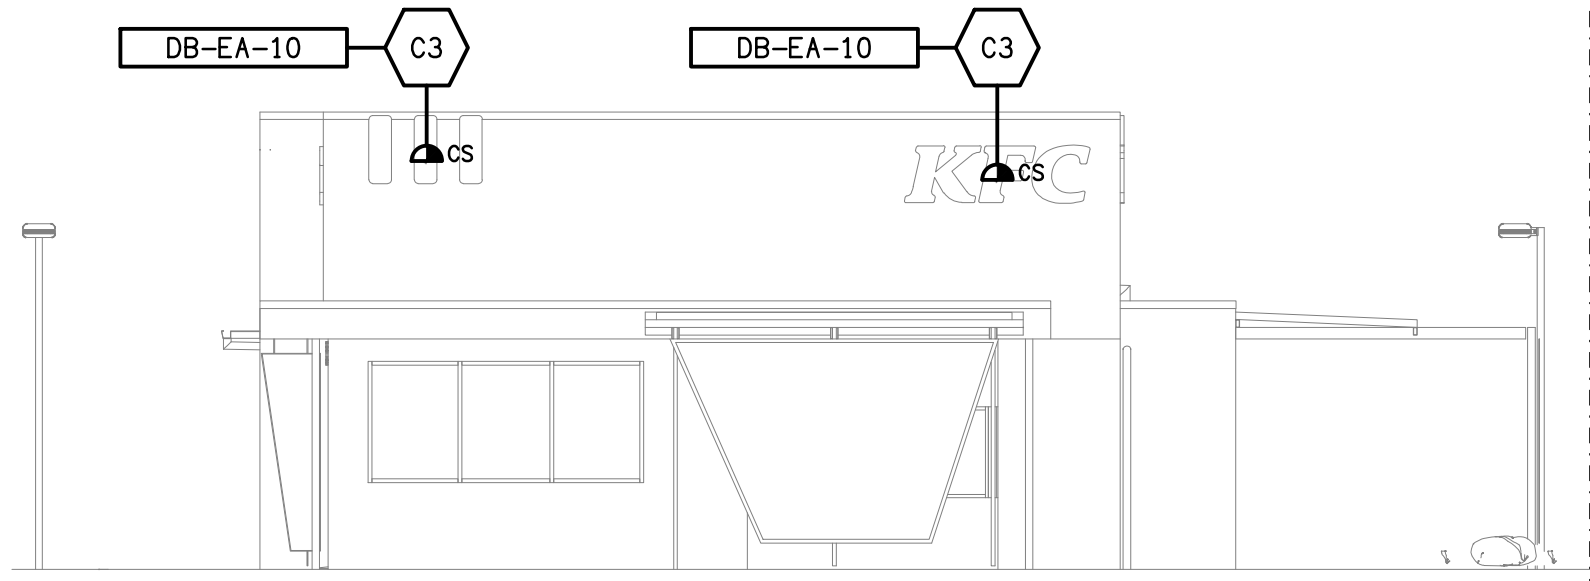

SOUTH ELEVATION

DETAILS  
EXTERNAL BUILDING ELEVATIONS  
SCALE 1: 100

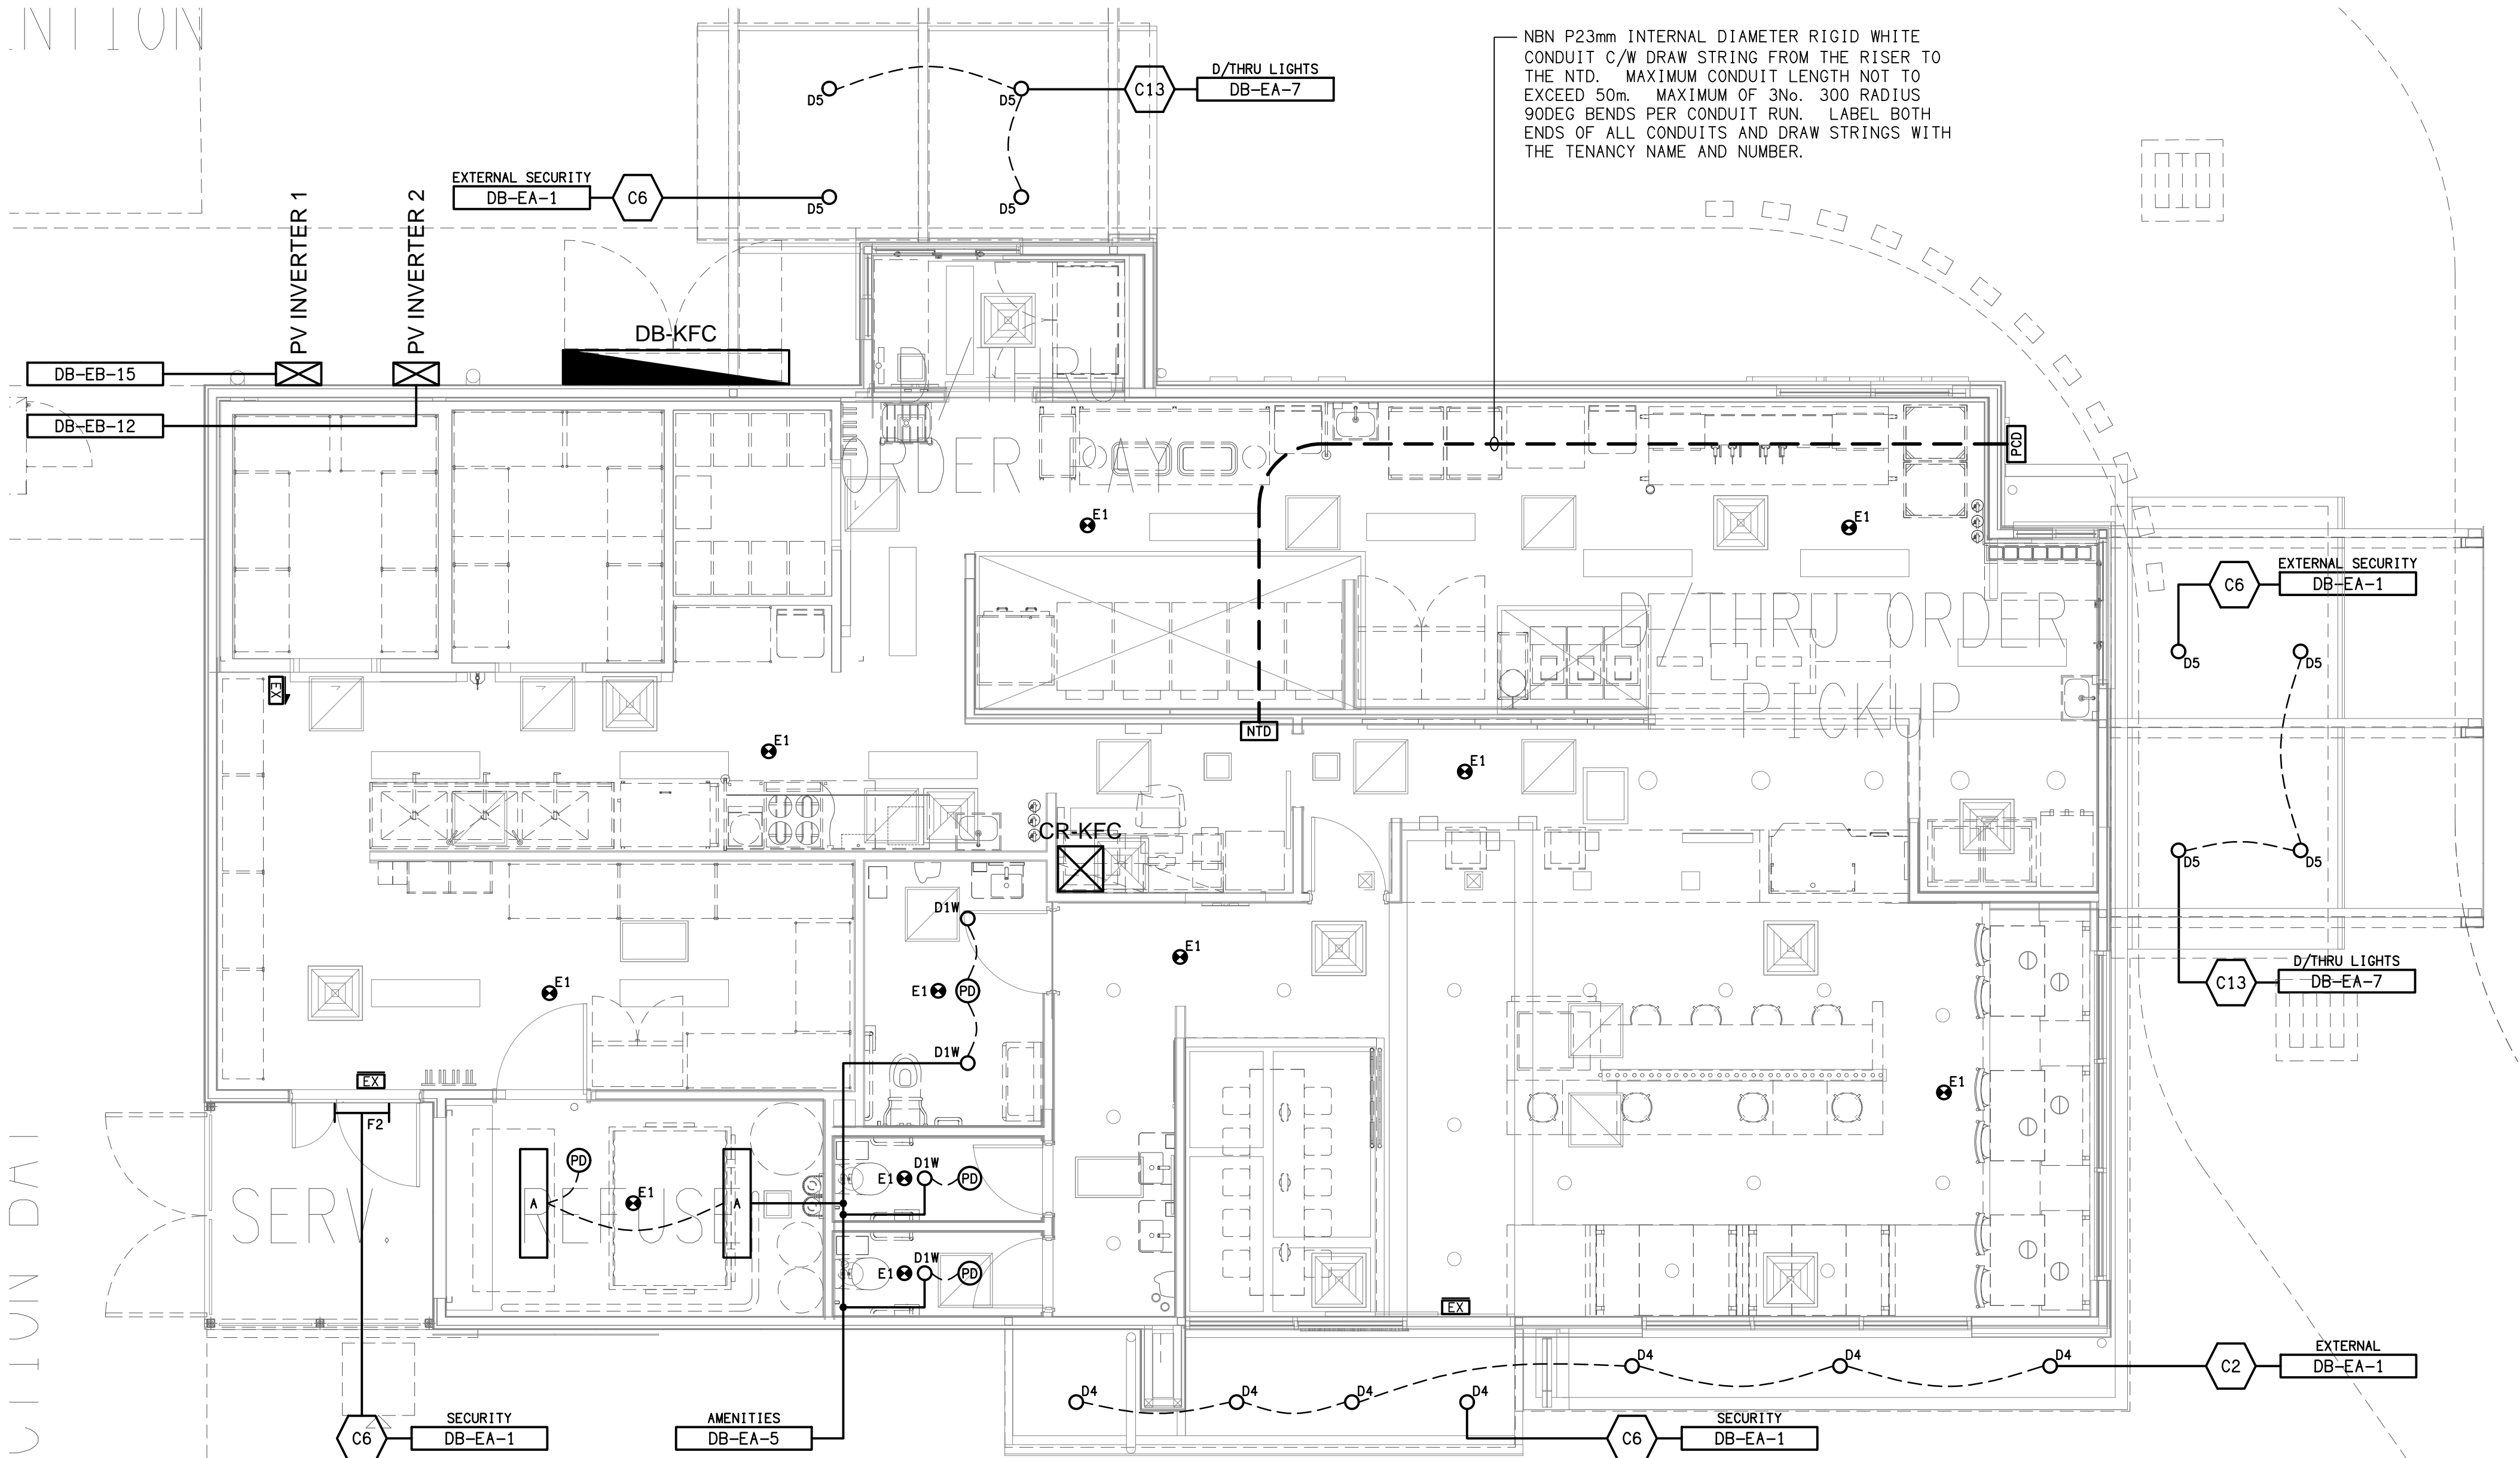

REFLECTED CEILING PLAN  
KFC TENANCY  
SCALE 1: 50

C	CONSTRUCTION	03/12/2020
REV:	DESCRIPTION:	DATE:

**ELECTRICAL DESIGN GROUP**  
ELECTRICAL BUILDING SERVICES CONSULTANTS

BRISBANE: P.O. Box 15, Sherwood Qld 4075  
Phone: (07) 3278 4375  
Email: brisbane@edg.net.au  
Web: www.edg.net.au

ELECTRICAL DESIGN GROUP BRISBANE PTY LTD  
ACN 092 710 793

TRADING AS:  
ELECTRICAL DESIGN  
GROUP

PROJECT:

**KFC  
BURLEIGH CONNECTION  
ROAD**

SITE ADDRESS:  
**219-223 BURLEIGH CONNECTION  
ROAD, BURLEIGH HEADS, GOLD COAST**

SCALE: SHEET SIZE:

1:50 UNO AT A1

DRAWING TITLE:

**ELECTRICAL SERVICES  
REFLECTED CEILING PLAN  
& DETAILS**

PROJECT NO: DRAWING NO: REVISION:

**C2256a E03 C**