



CIRCUIT SCHEDULE

CIRC	PH	CIRCUIT BREAKER (amps)	CONTROL EQUIPMENT	CABLE SIZE (mm2)	CIRCUIT USE
P1	1	20	RCD	2.5	PRINTER
P2	1	20	RCD	2.5	REFRIGERATOR
P3	1	20	RCD	2.5	REFRIGERATOR
P4	1	20	RCD	2.5	MICROWAVE
P5	1	20	RCD	2.5	BAINE MARIE
P6	1	20	RCD	2.5	BAINE MARIE
P7	1	20	RCD	2.5	HEAT SHELF
P8	1	20	RCD	2.5	HEAT SHELF
P9	1	20	RCD	2.5	MICROWAVE
P10	3	20	RCD	2.5	DISH WASHER 9.1KW
P11	1	20	RCD	2.5	POST MIX
P12					
P13	1	20	RCD	2.5	POST MIX
P14					
P15	1	20	RCD	2.5	GPO
P16	1	20	RCD	2.5	15A GPO
P17	1	20	RCD	2.5	REFRIGERATOR
P18	1	32	RCD	6.0	PIZZA OVEN
P19	3	32	RCD	6.0	19.5KW COMBI
P20	1	20	RCD	2.5	SALAMANDER
P21	1	20	RCD	2.5	FREEZER DRAWER
L1	1	20	RCD	2.5	LIGHTING

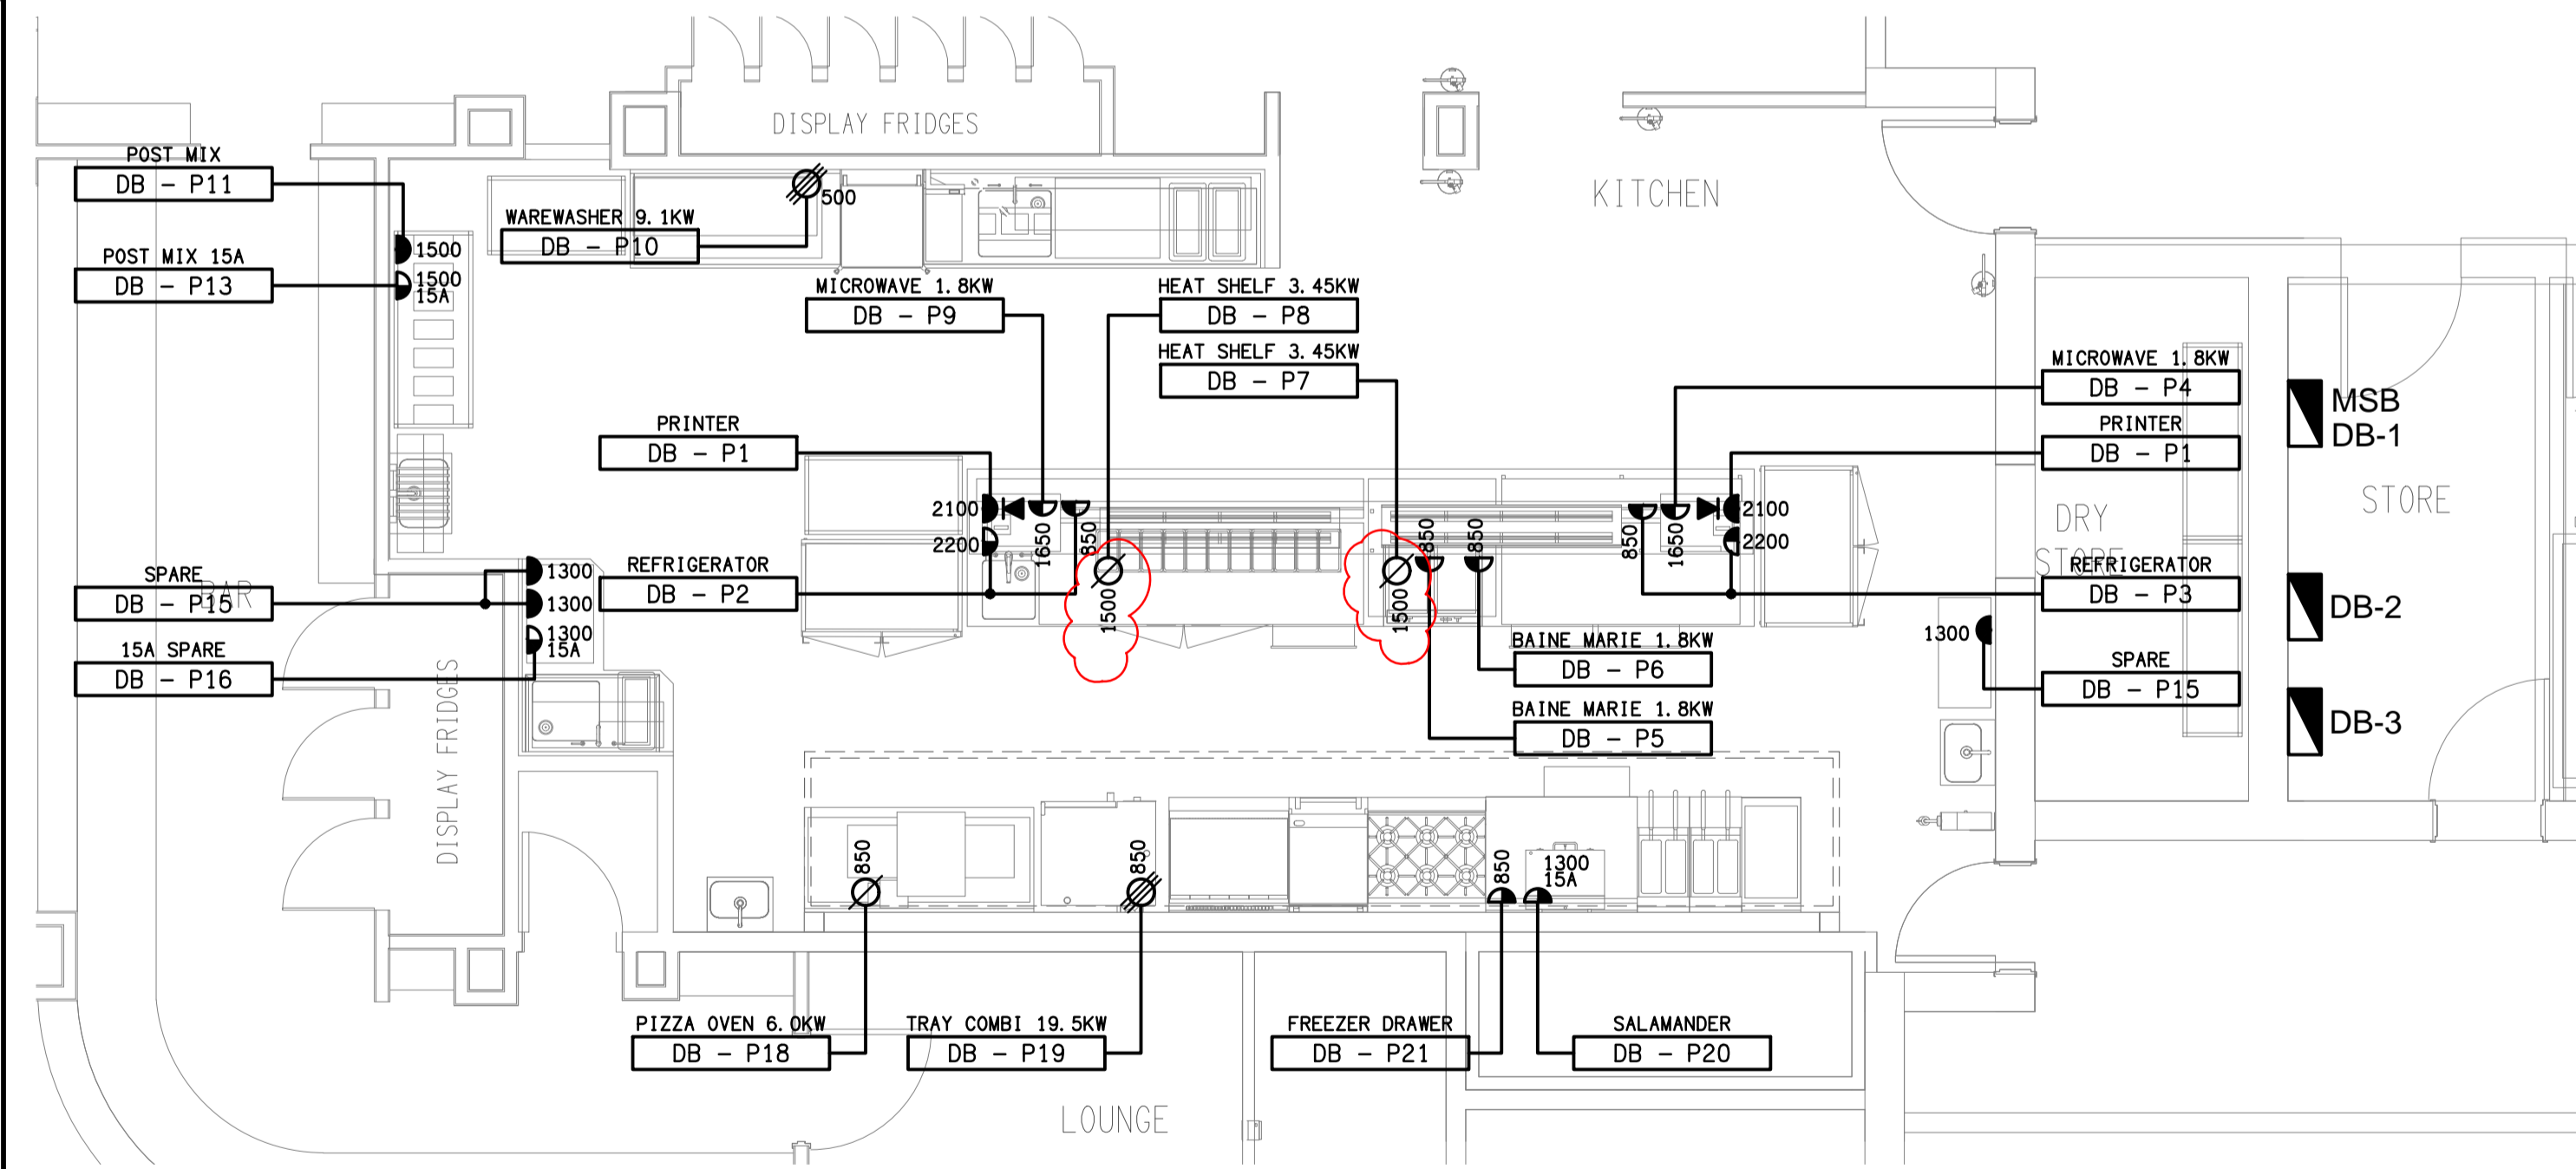

FLOOR PLAN
KITCHEN REFURBISHMENT
SCALE 1:50

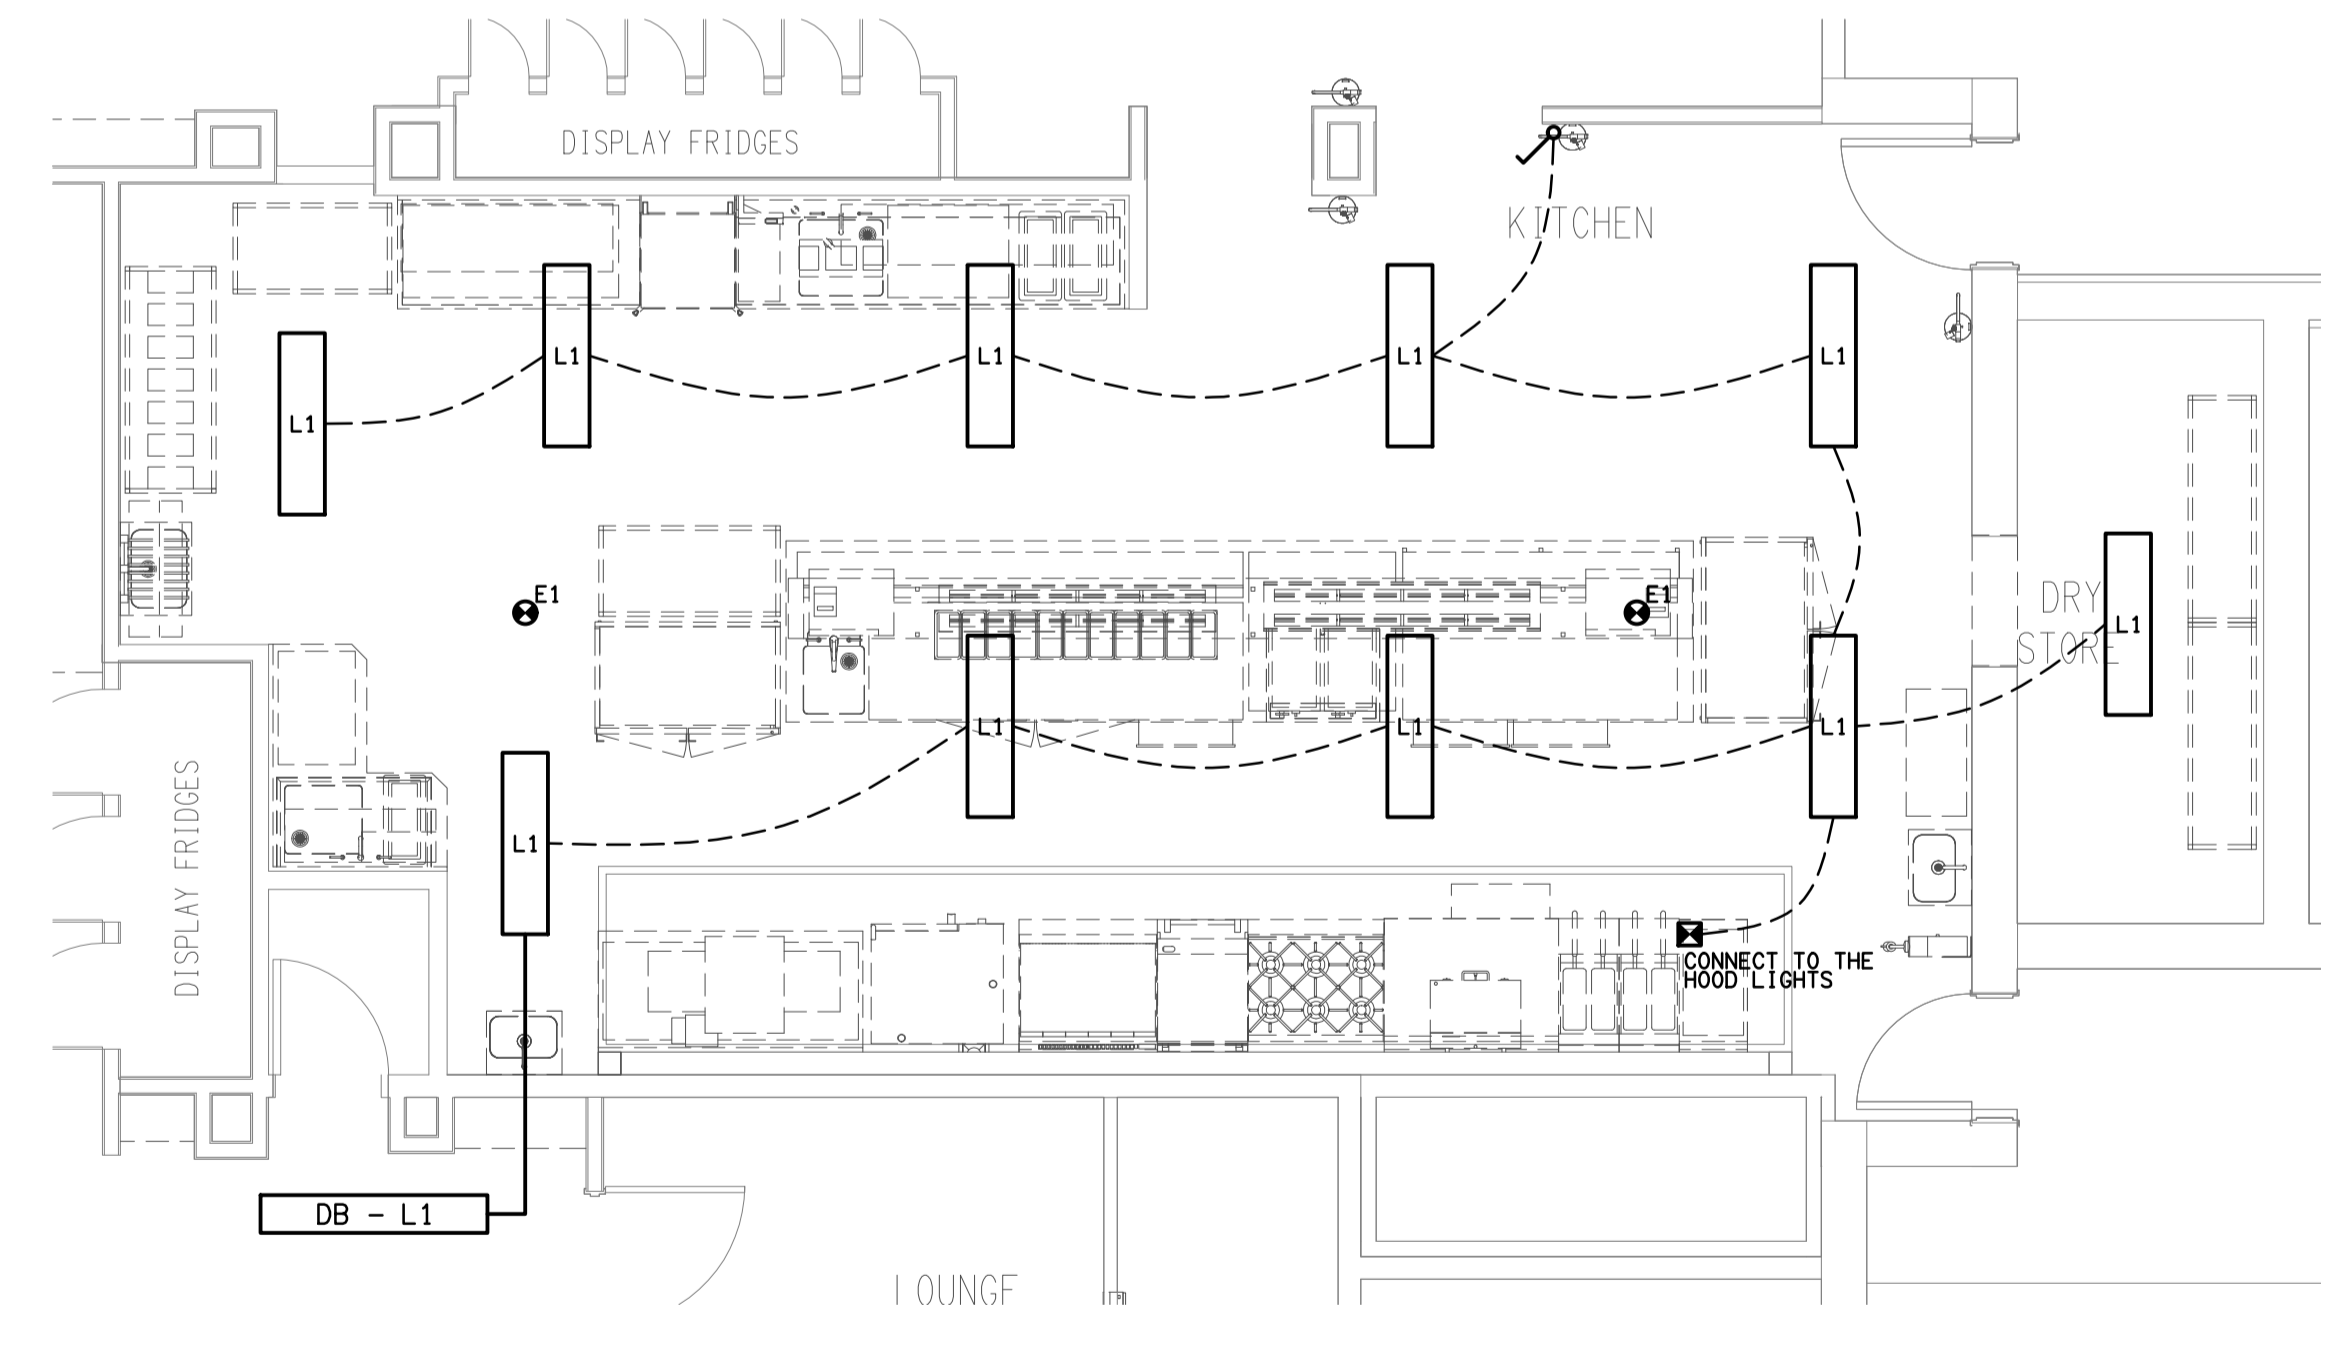

REFLECTED CEILING PLAN
KITCHEN REFURBISHMENT
SCALE 1:50

ELECTRICAL DESIGN GROUP BRISBANE
PTY LTD
ACN 092 710 793
TRADING AS:
ELECTRICAL DESIGN GROUP

THE COPYRIGHT OF THIS DRAWING
REMAINS THE PROPERTY OF THE
ELECTRICAL DESIGN GROUP.
USE FIGURED DIMENSIONS
IN PREFERENCE TO SCALE.
ALL DIMENSIONS TO BE
VERIFIED ONSITE.

ELECTRICAL DESIGN GROUP
ELECTRICAL BUILDING SERVICES CONSULTANTS
BRISBANE GOLD COAST

P.O. Box 15, Sherwood Q.4075
Phone: (07) 3278 4375
Email: brisbane@edg.net.au
Web: www.edg.net.au

PROJECT:
BURPENGARY TAVERN
KITCHEN REFURBISHMENT

262 BRUCE HIGHWAY, EASTERN SERVICE RD, BURPENGARY EAST

C	CONSTRUCTION	13/10/2020
REV:	DESCRIPTION:	DATE:

DRAWING:
ELECTRICAL SERVICES
FLOOR PLAN & REFLECTED CEILING PLAN

SCALE:
1:50

PROJECT NO:
C2259a

DRAWING NO:
E02

REVISION:
C