

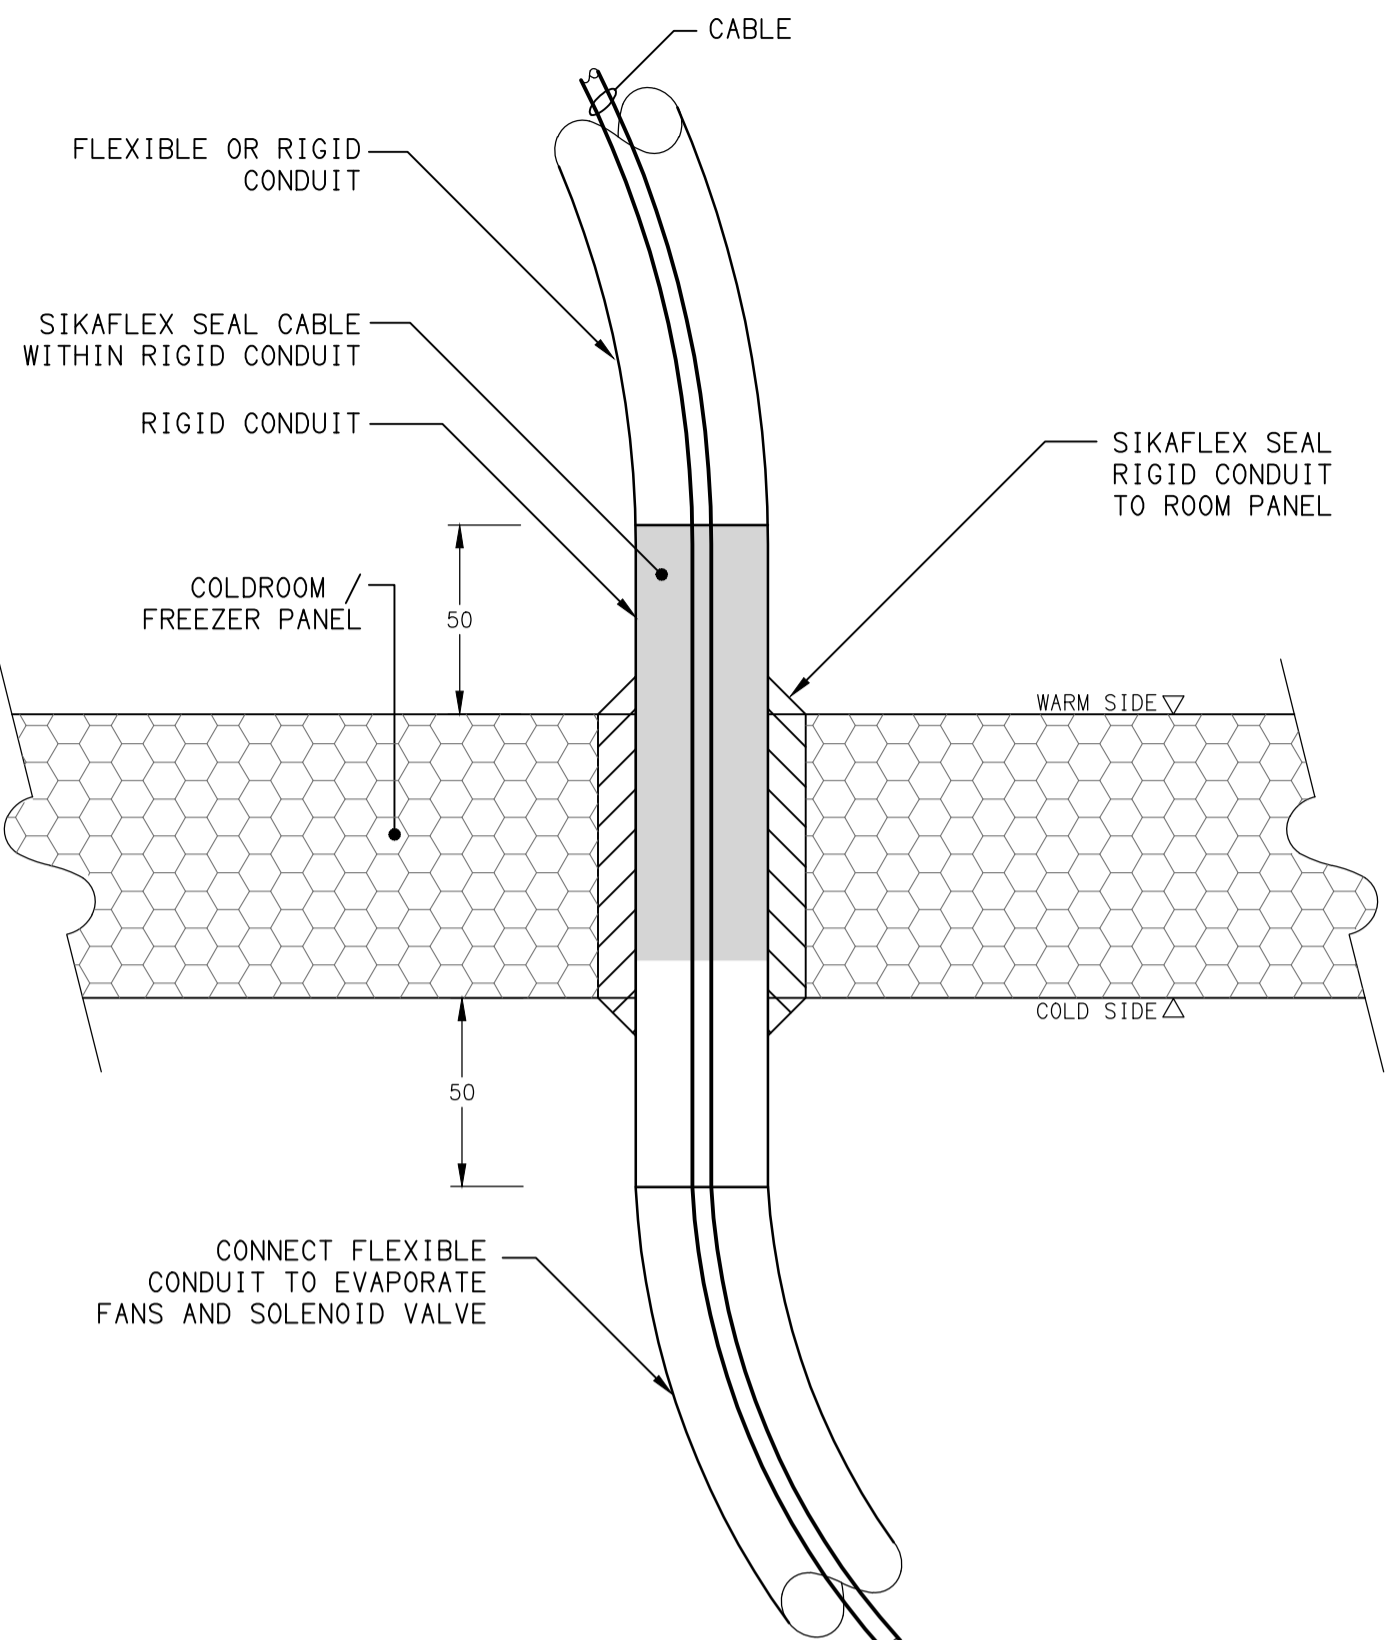


NOTE:
CORRUGATED CONDUIT IS NOT TO BE USED
IN THE AREAS SHOWN ON THIS PLAN.

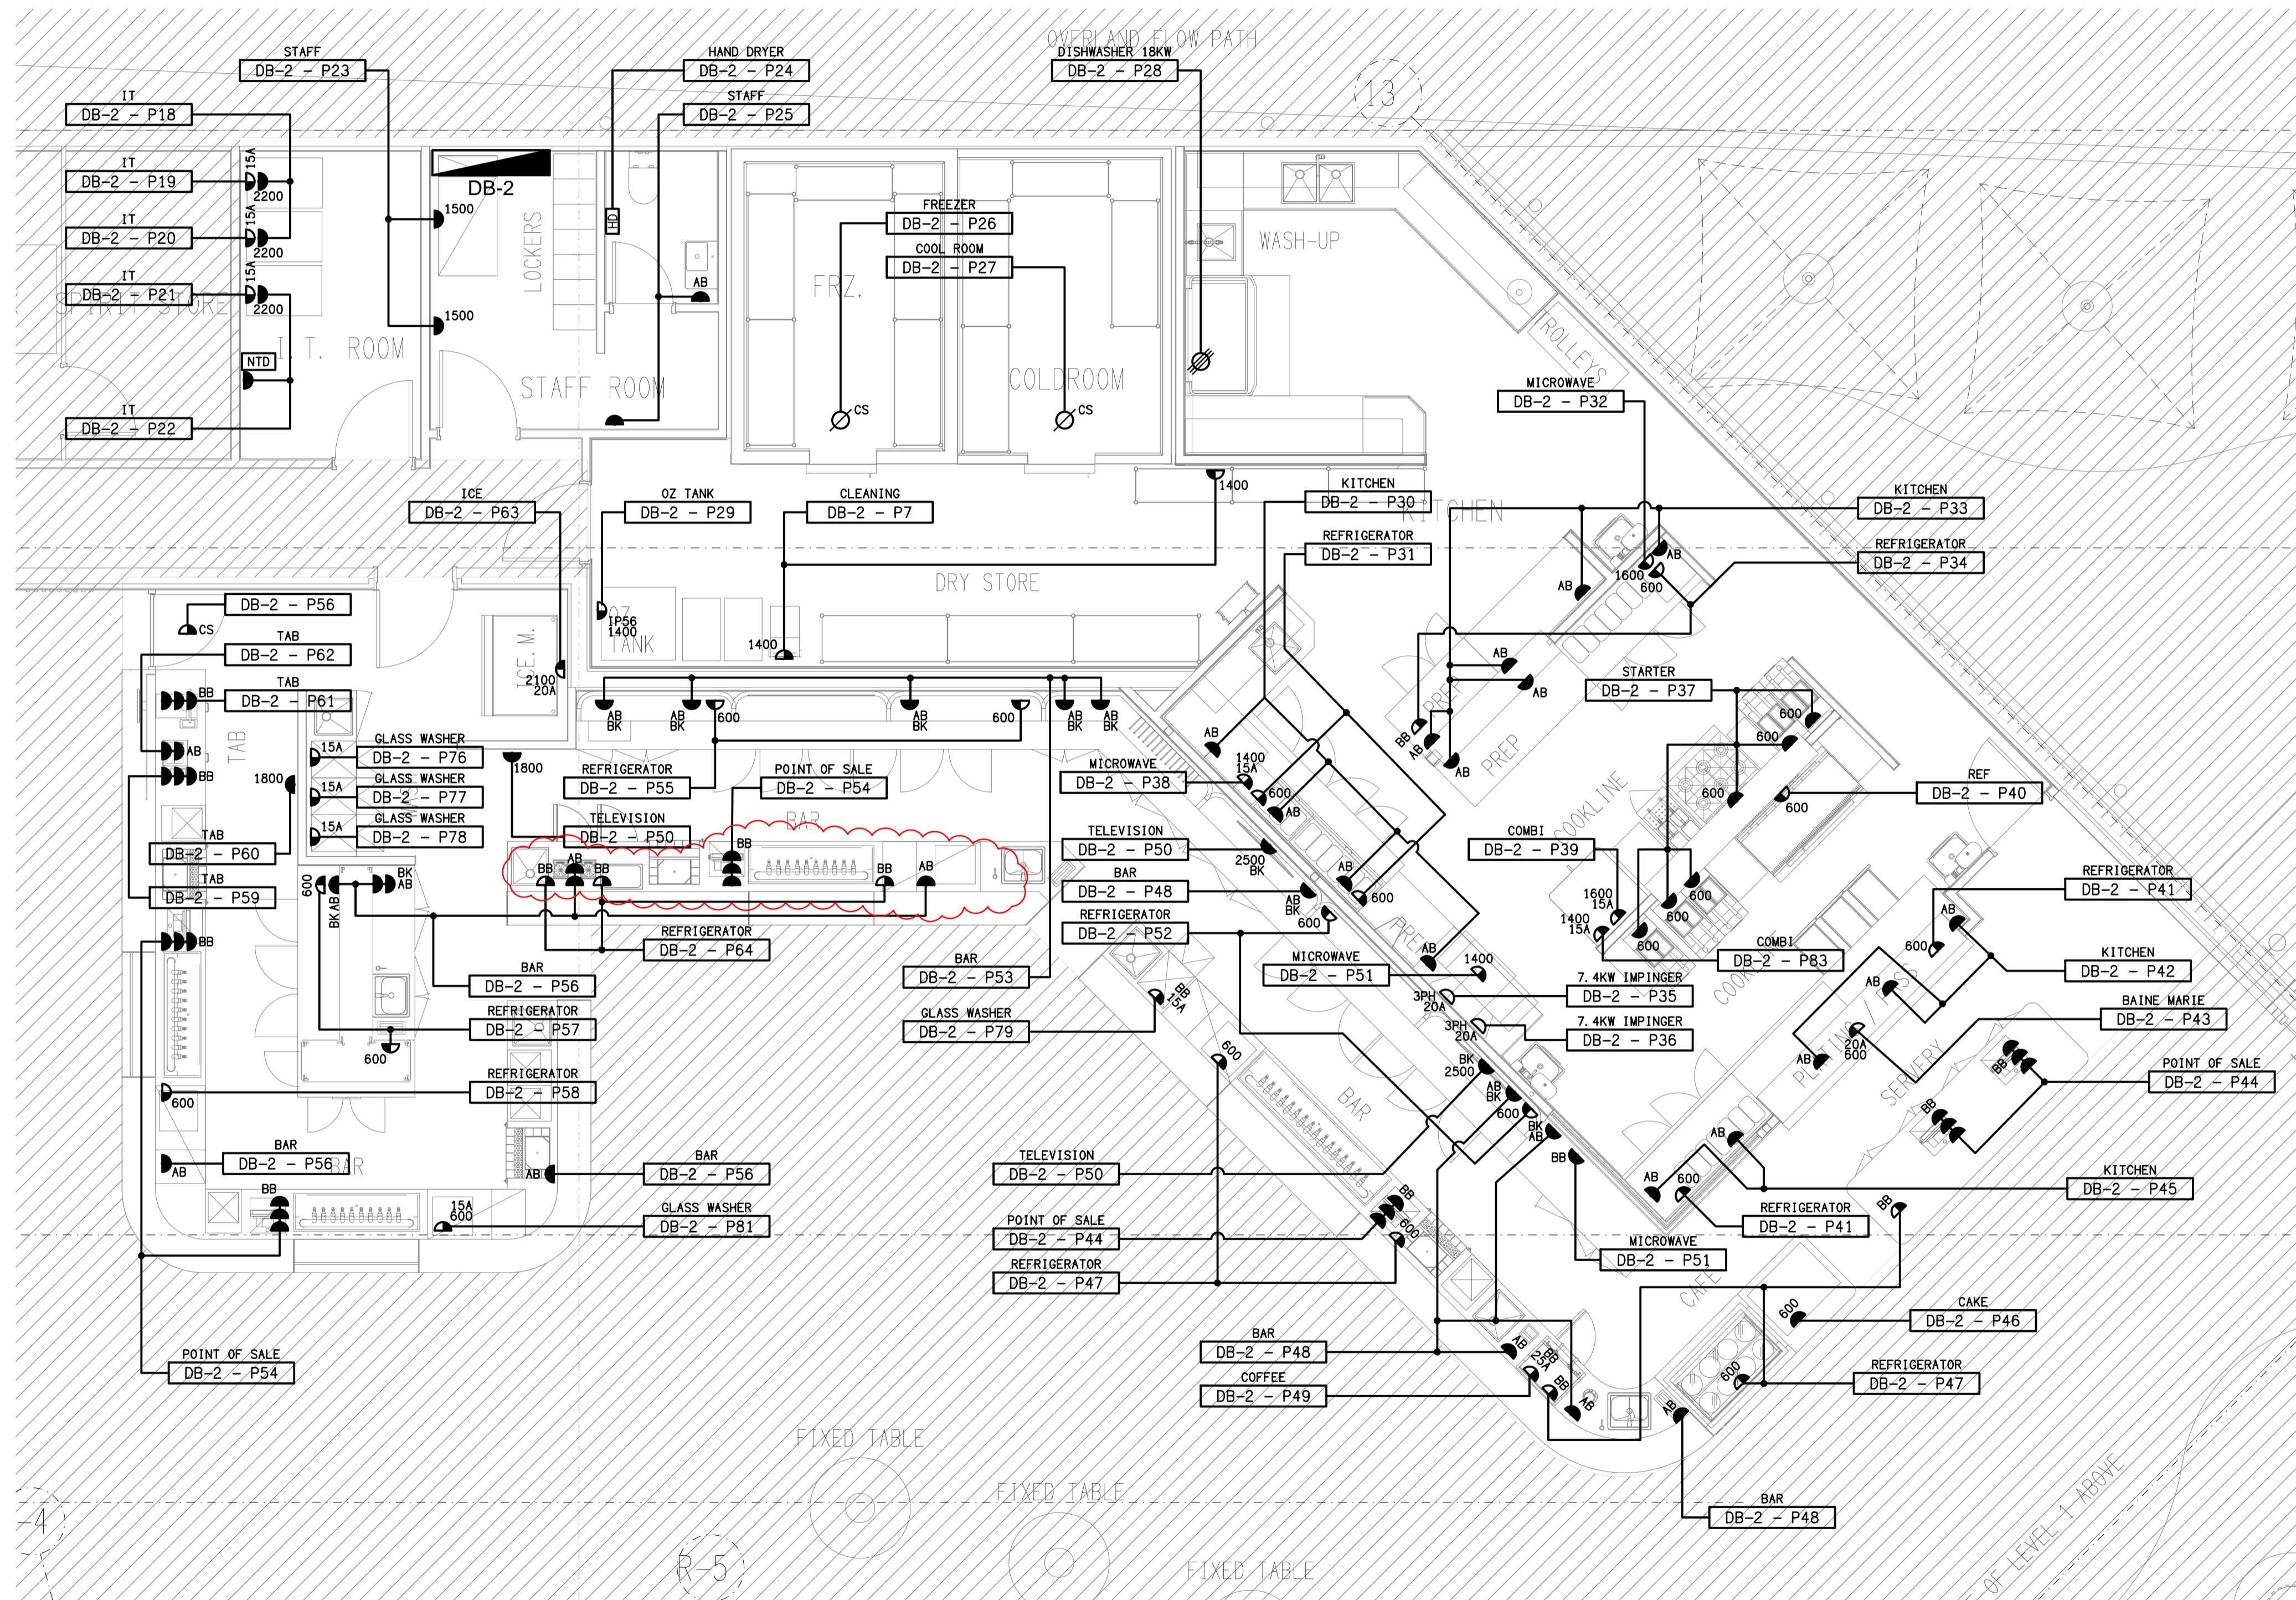

DETAIL
COOL ROOM CONDUIT PENETRATION
NOT TO SCALE

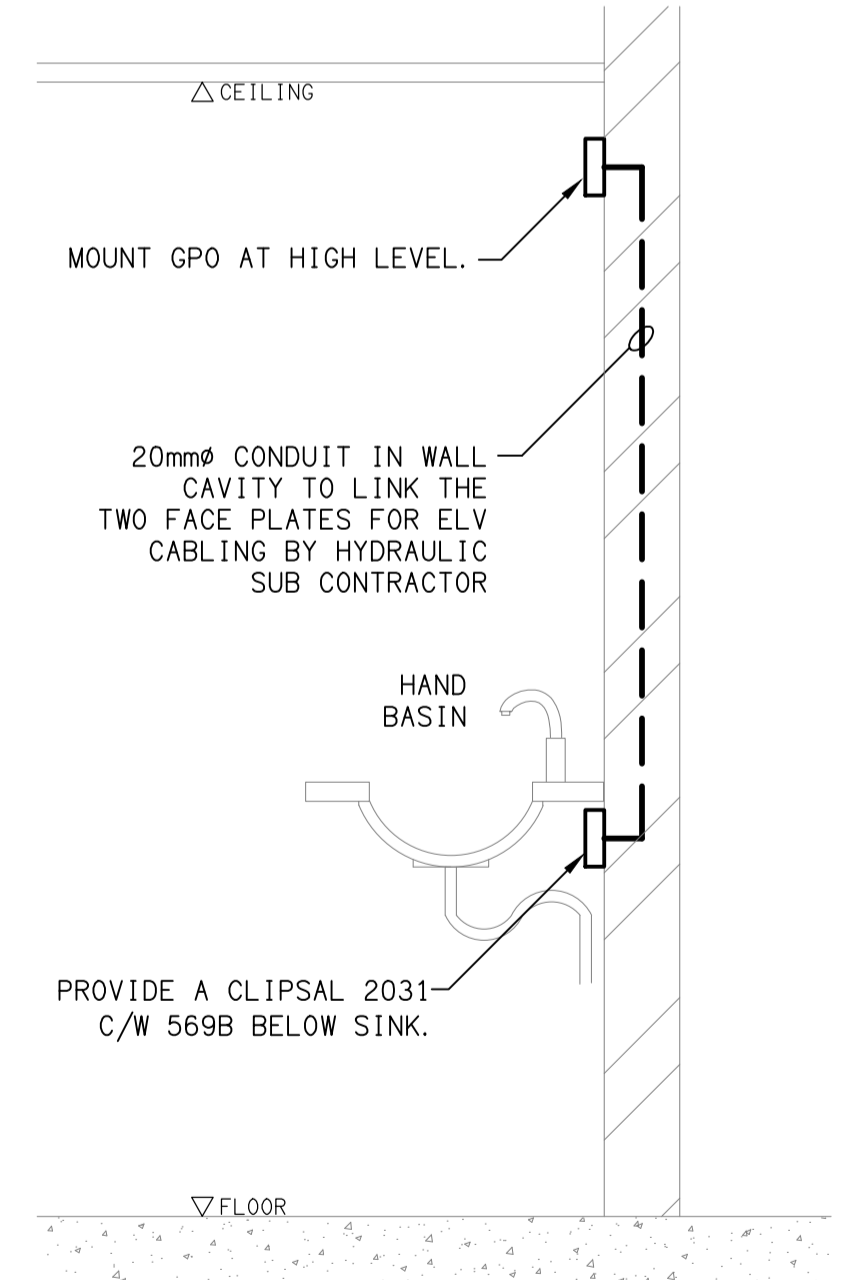

DETAIL
AUTO TAP CONNECTION
NOT TO SCALE

DETAIL B
KITCHEN & BAR FLOOR PLAN
SCALE 1:50

ELECTRICAL DESIGN GROUP BRISBANE
PTY LTD
ACN 092 710 793
TRADING AS:
ELECTRICAL DESIGN GROUP

THE COPYRIGHT OF THIS DRAWING
REMAINS THE PROPERTY OF THE
ELECTRICAL DESIGN GROUP.
USE FIGURED DIMENSIONS
IN PREFERENCE TO SCALE.
ALL DIMENSIONS TO BE
VERIFIED ONSITE.

ELECTRICAL DESIGN GROUP
ELECTRICAL BUILDING SERVICES CONSULTANTS
BRISBANE GOLD COAST

P.O. Box 15, Sherwood Q.4075
Phone: (07) 3278 4375
Email: brisbane@edg.net.au
Web: www.edg.net.au

PROJECT:
THE BROOK HOTEL, MITCHELTON
167 OSBORNE ROAD, MITCHELTON

L	CONSTRUCTION	17/02/2023
REV:	DESCRIPTION:	DATE:

DRAWING:
ELECTRICAL SERVICES
GROUND LEVEL
KITCHEN & BAR FLOOR PLAN
SCALE: 1:50
PROJECT NO: **C2499a**
DRAWING NO: **E07**
REVISION: **L**