


REFER TO GROUND LEVEL FLOOR PLAN PART A ON DRAWING E09

NOTE:
FOR ADDITIONAL FLOOR, JOINERY & WALL LIGHTING
REFER TO DRAWINGS C2499a-E11 & C2499a-E12.

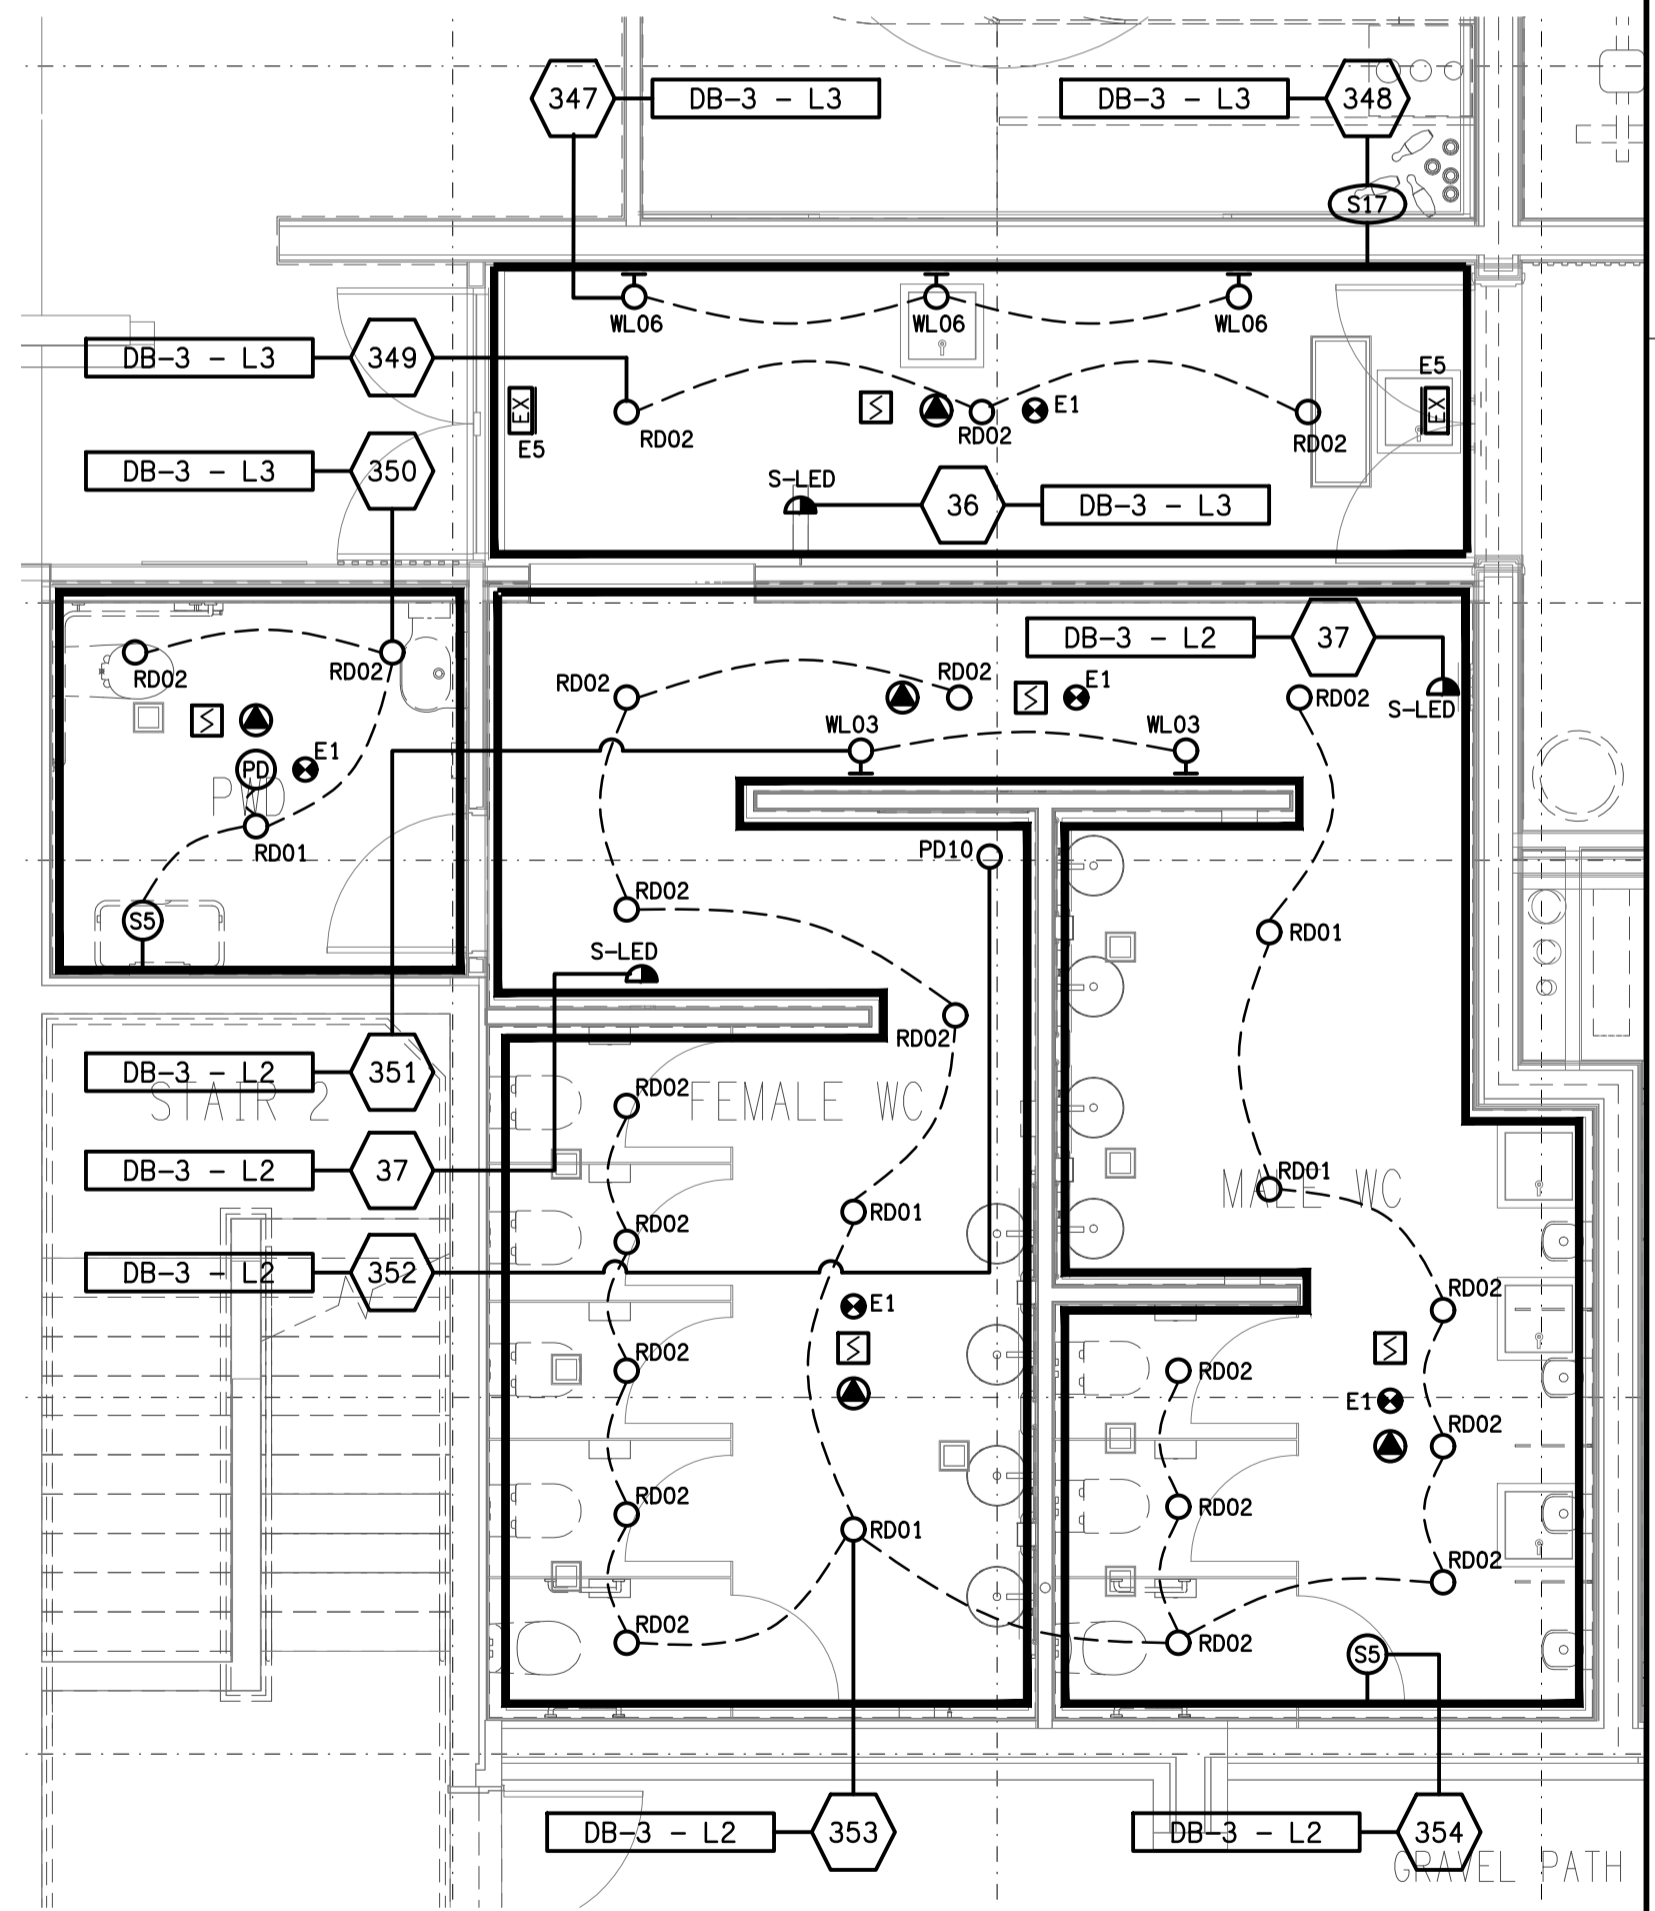

DETAIL A
AMENITIES REFLECTED CEILING PLAN
SCALE 1:50

ELECTRICAL DESIGN GROUP BRISBANE
PTY LTD
ACN 092 710 793
TRADING AS:
ELECTRICAL DESIGN GROUP

THE COPYRIGHT OF THIS DRAWING
REMAINS THE PROPERTY OF THE
ELECTRICAL DESIGN GROUP.
USE FIGURED DIMENSIONS
IN PREFERENCE TO SCALE.
ALL DIMENSIONS TO BE
VERIFIED ONSITE.

ELECTRICAL DESIGN GROUP
ELECTRICAL BUILDING SERVICES CONSULTANTS
BRISBANE GOLD COAST
P.O. Box 15, Sherwood Q. 4075
Phone: (07) 3278 4375
Email: brisbane@edg.net.au
Web: www.edg.net.au

PROJECT:
THE BROOK HOTEL, MITCHELTON
167 OSBORNE ROAD, MITCHELTON

J	CONSTRUCTION	19/04/2023
REV:	DESCRIPTION:	DATE:
DRAWING: ELECTRICAL SERVICES GROUND LEVEL REFLECTED CEILING PLAN PART B		
SCALE: 1:100 UNO	PROJECT NO: AT A1 C2499a	DRAWING NO: E10
		REVISION: J