


**NOTE:**  
REFER TO DRAWING E15 FOR THE TYPICAL UNIT LAYOUTS.

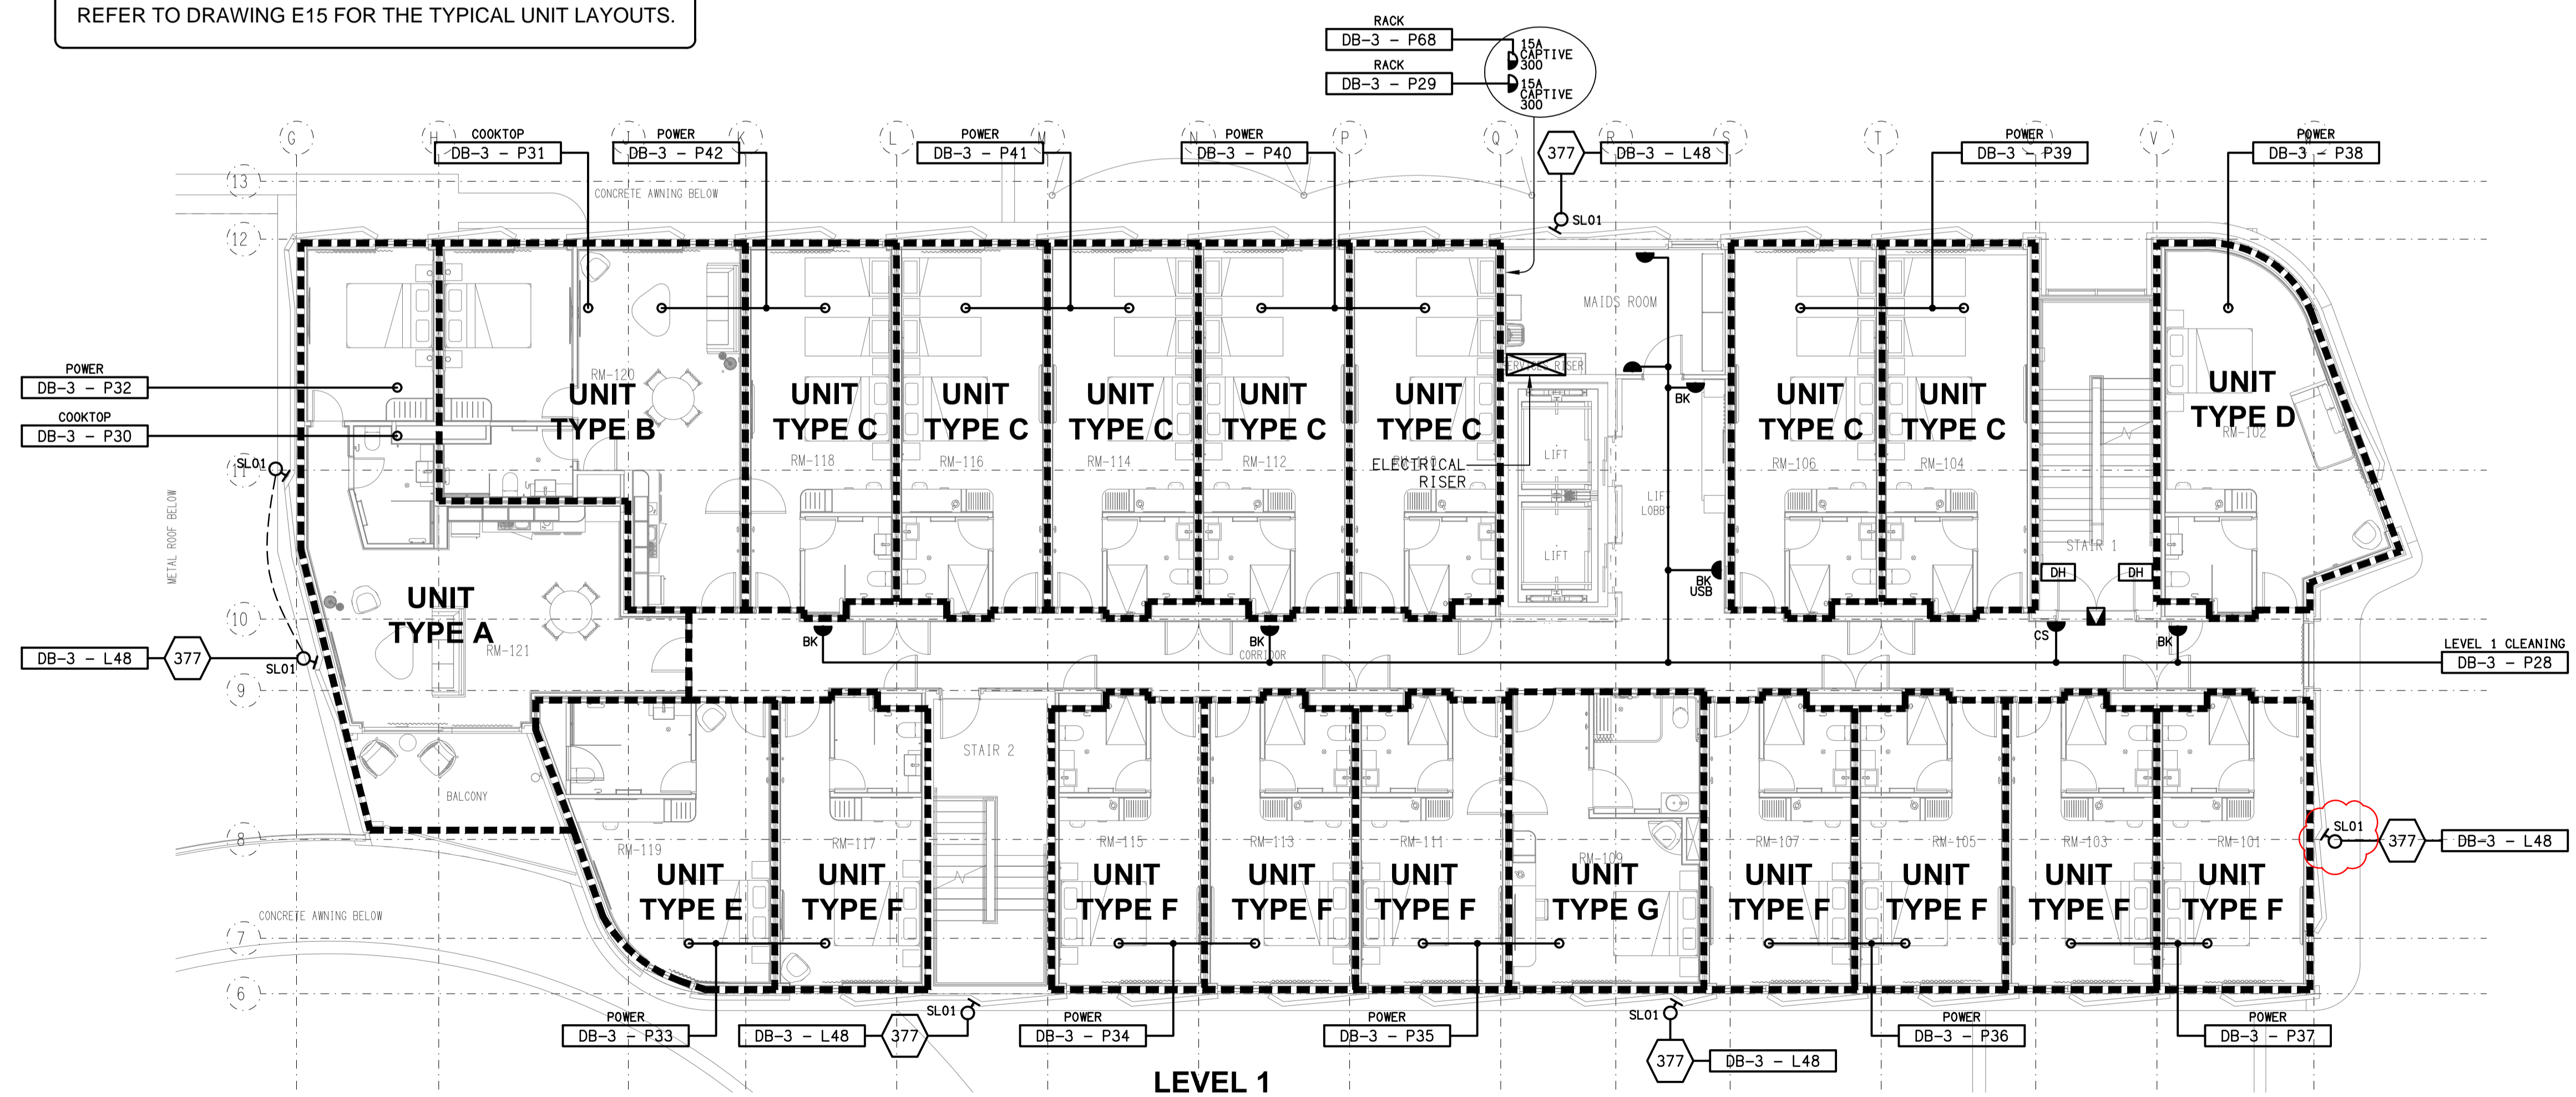

ELECTRICAL DESIGN GROUP BRISBANE  
PTY LTD  
ACN 092 710 793  
TRADING AS:  
ELECTRICAL DESIGN GROUP

THE COPYRIGHT OF THIS DRAWING  
REMAINS THE PROPERTY OF THE  
ELECTRICAL DESIGN GROUP.  
USE FIGURED DIMENSIONS  
IN PREFERENCE TO SCALE.  
ALL DIMENSIONS TO BE  
VERIFIED ONSITE.

**ELECTRICAL DESIGN GROUP**  
ELECTRICAL BUILDING SERVICES CONSULTANTS  
BRISBANE GOLD COAST  
P.O. Box 15, Sherwood Q. 4075  
Phone: (07) 3278 4375  
Email: brisbane@edg.net.au  
Web: www.edg.net.au

PROJECT:  
**THE BROOK HOTEL, MITCHELTON**  
167 OSBORNE ROAD, MITCHELTON

G	CONSTRUCTION	15/03/2023
REV:	DESCRIPTION:	DATE:
DRAWING: <b>ELECTRICAL SERVICES LEVELS 1 &amp; 2 FLOOR PLANS</b>		
SCALE: 1:100	PROJECT NO: <b>C2499a</b>	DRAWING NO: <b>E13</b>
AT A1	REVISION: <b>G</b>	