
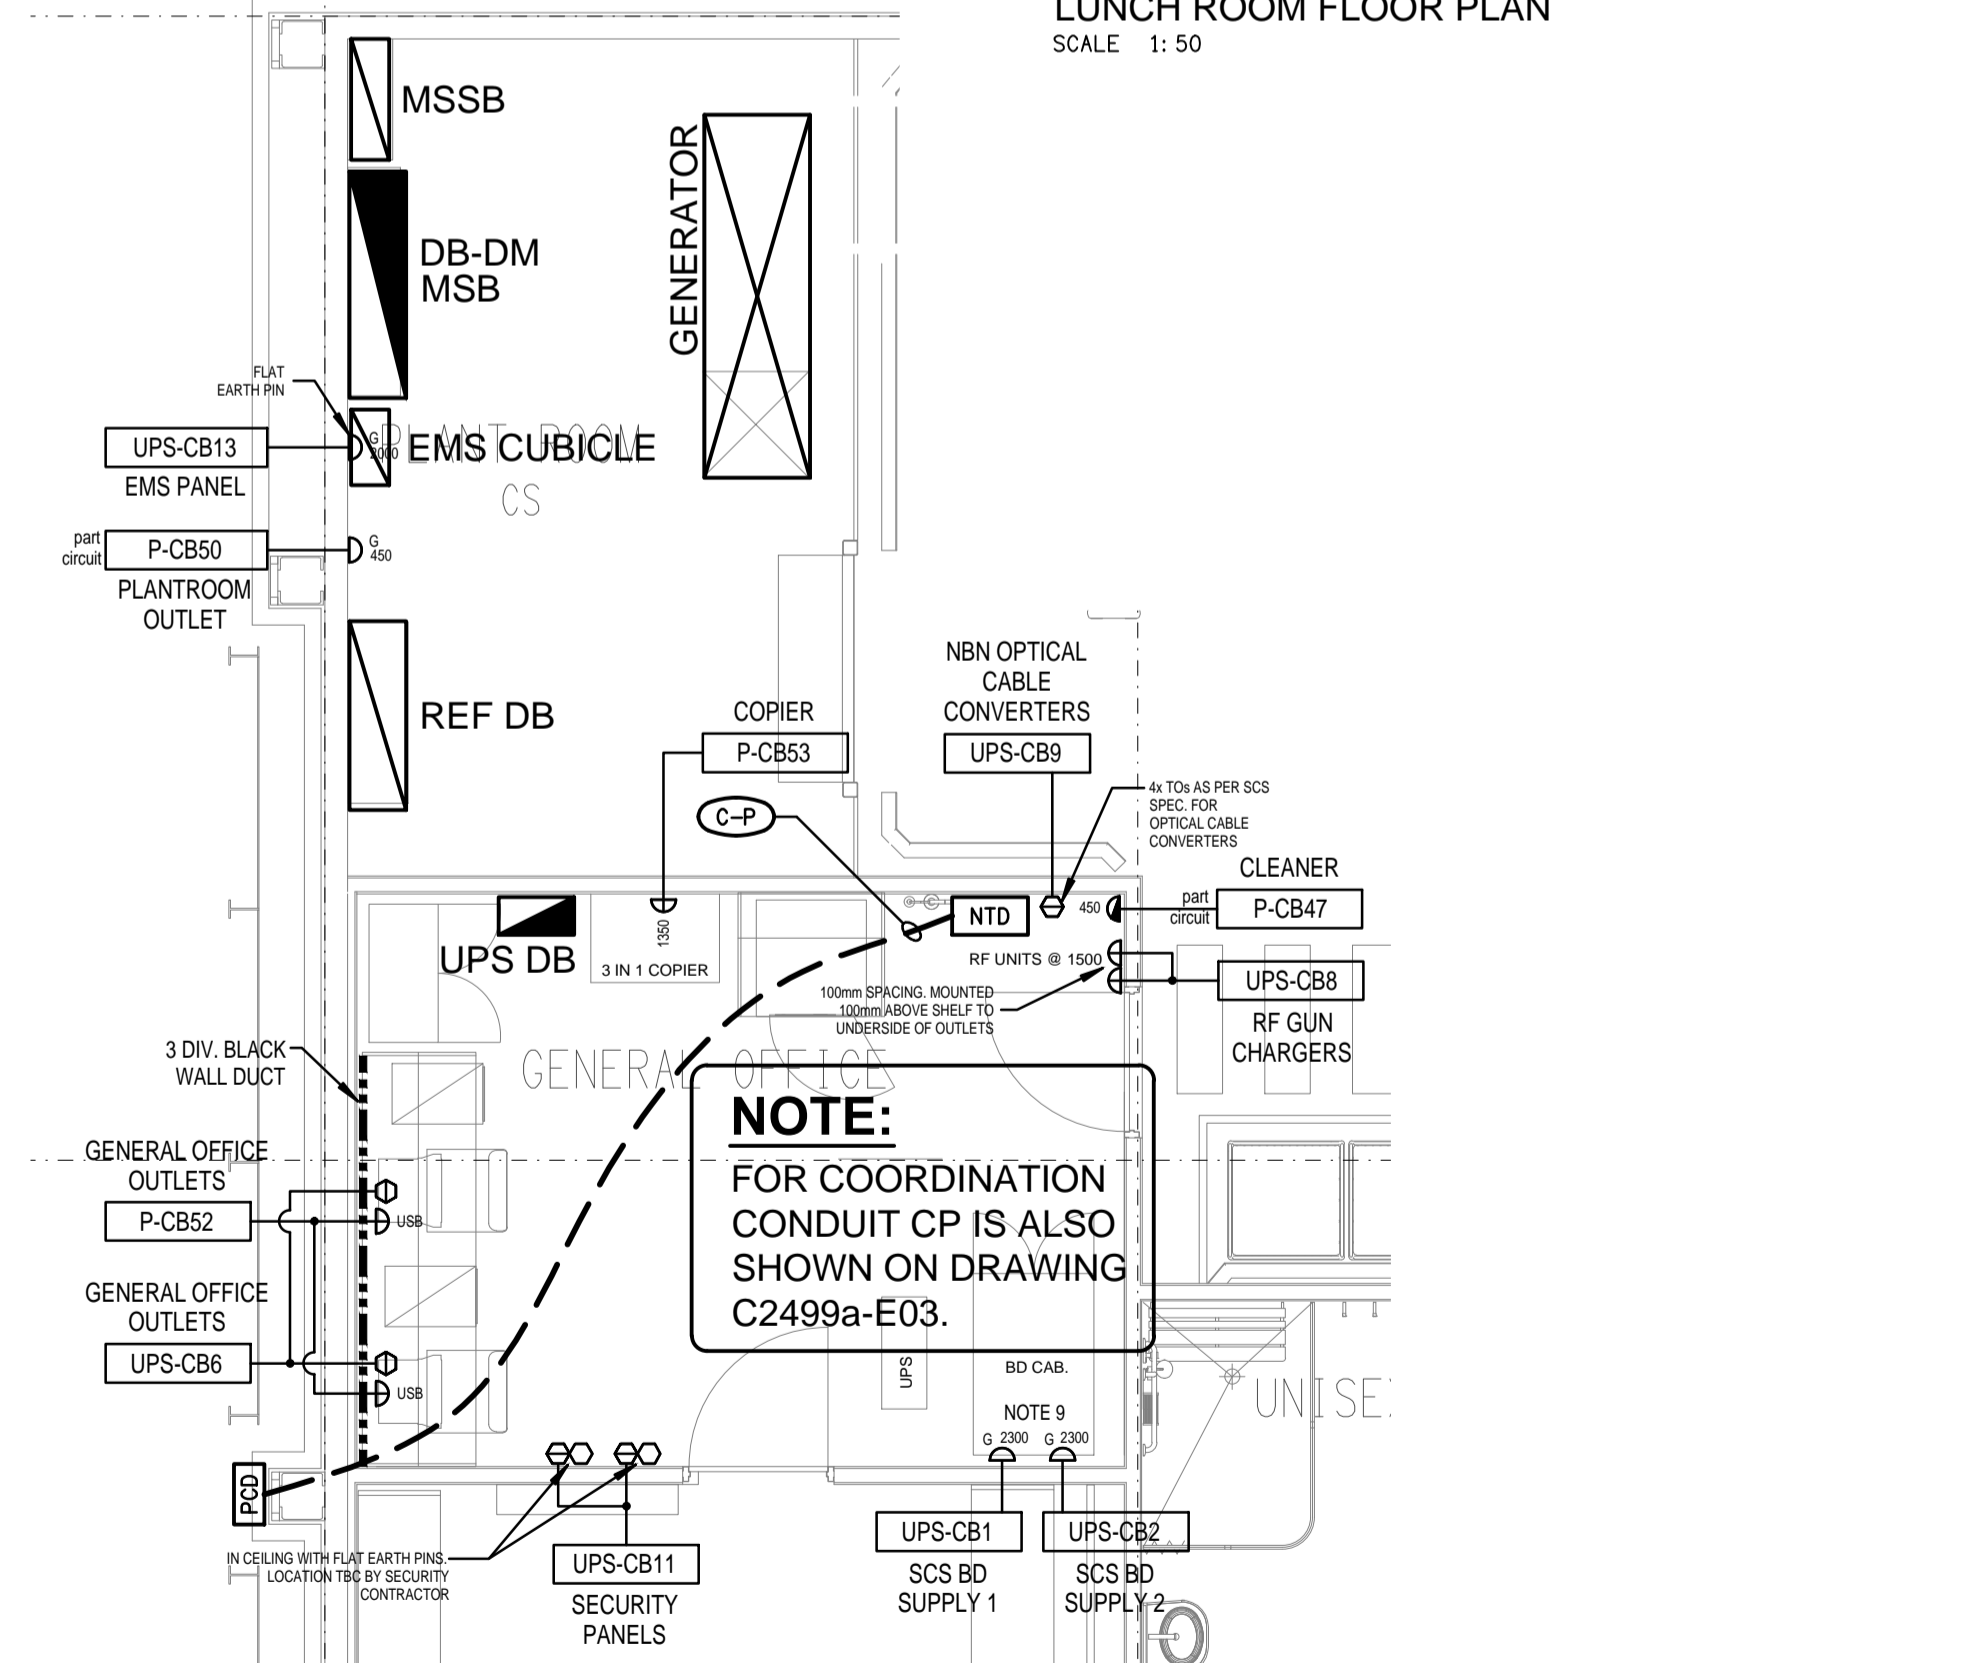
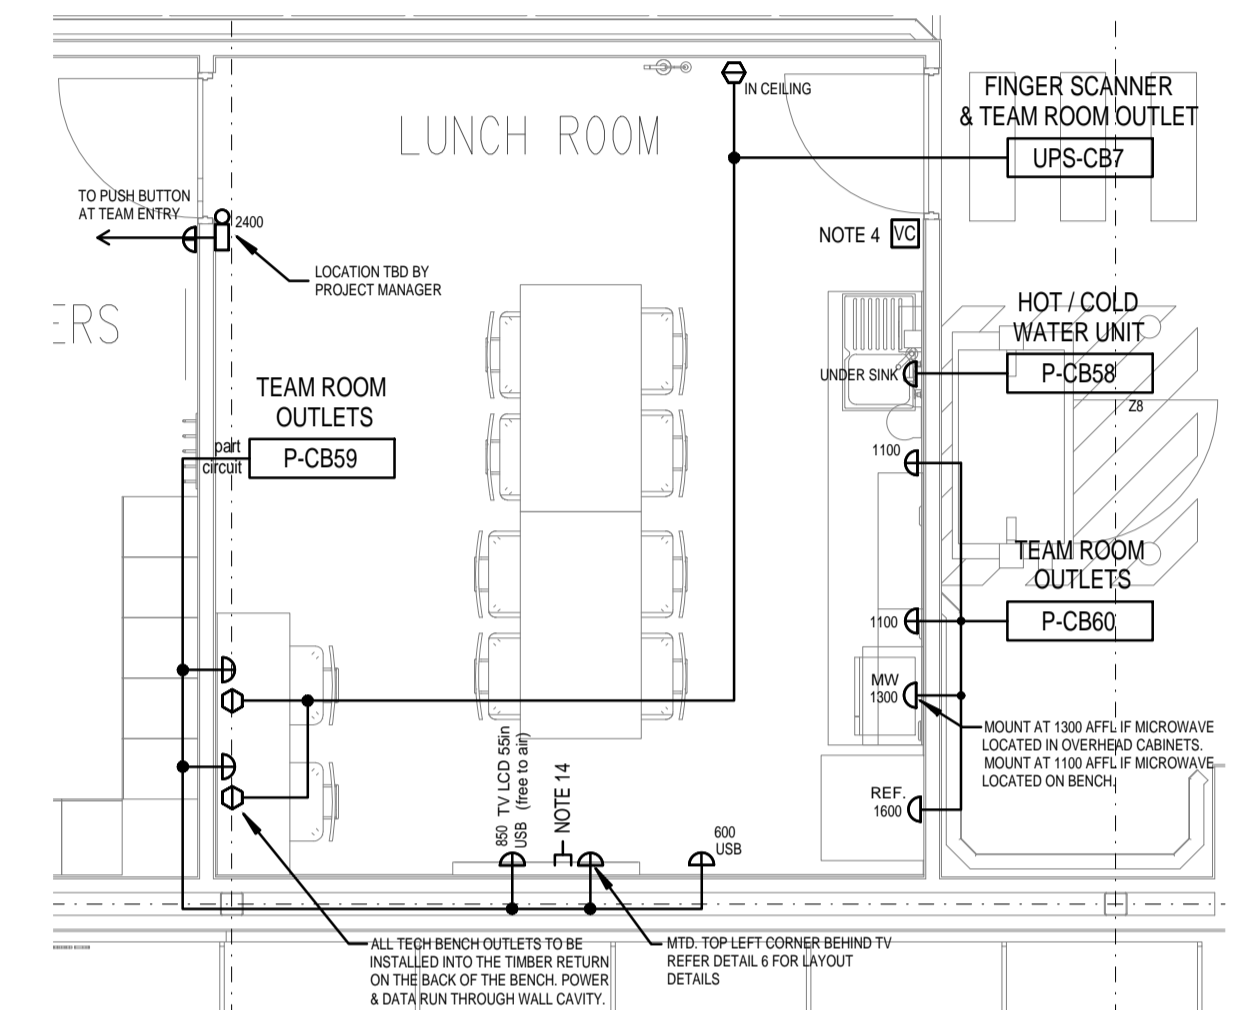
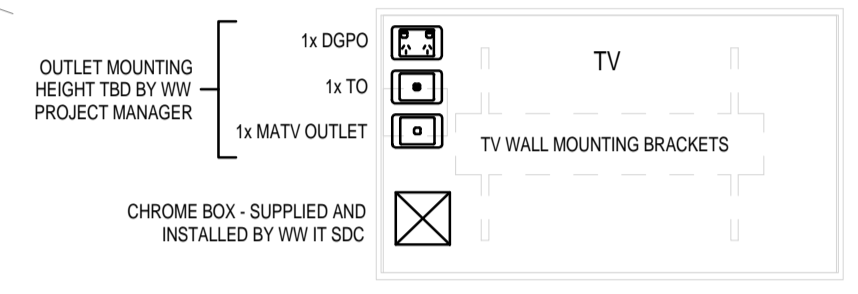
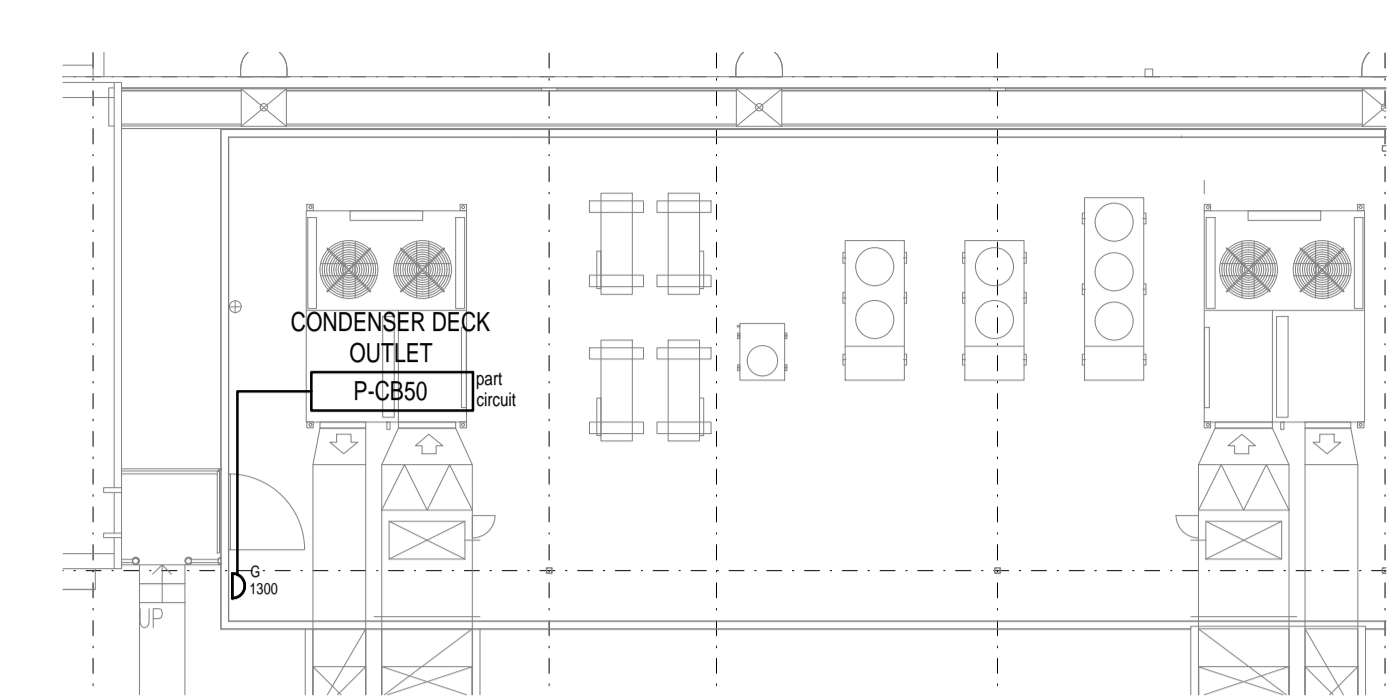
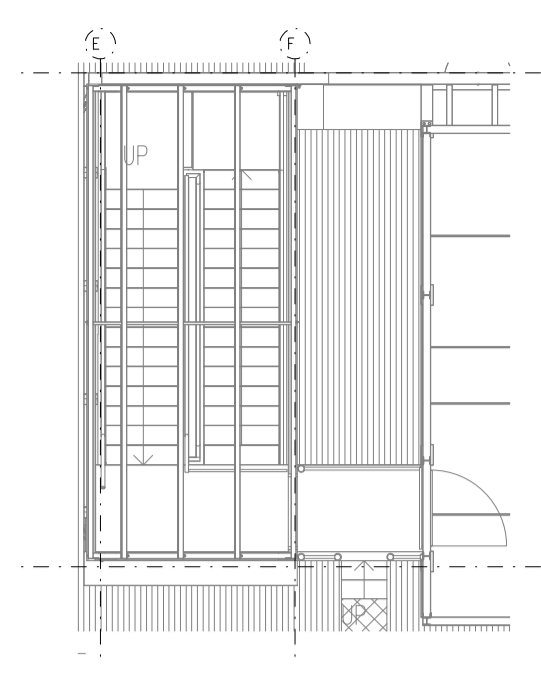


CIRCUIT/CIRCUIT BREAKER NUMBER
DISTRIBUTION SECTION P - POWER

WALL DUCT DETAIL

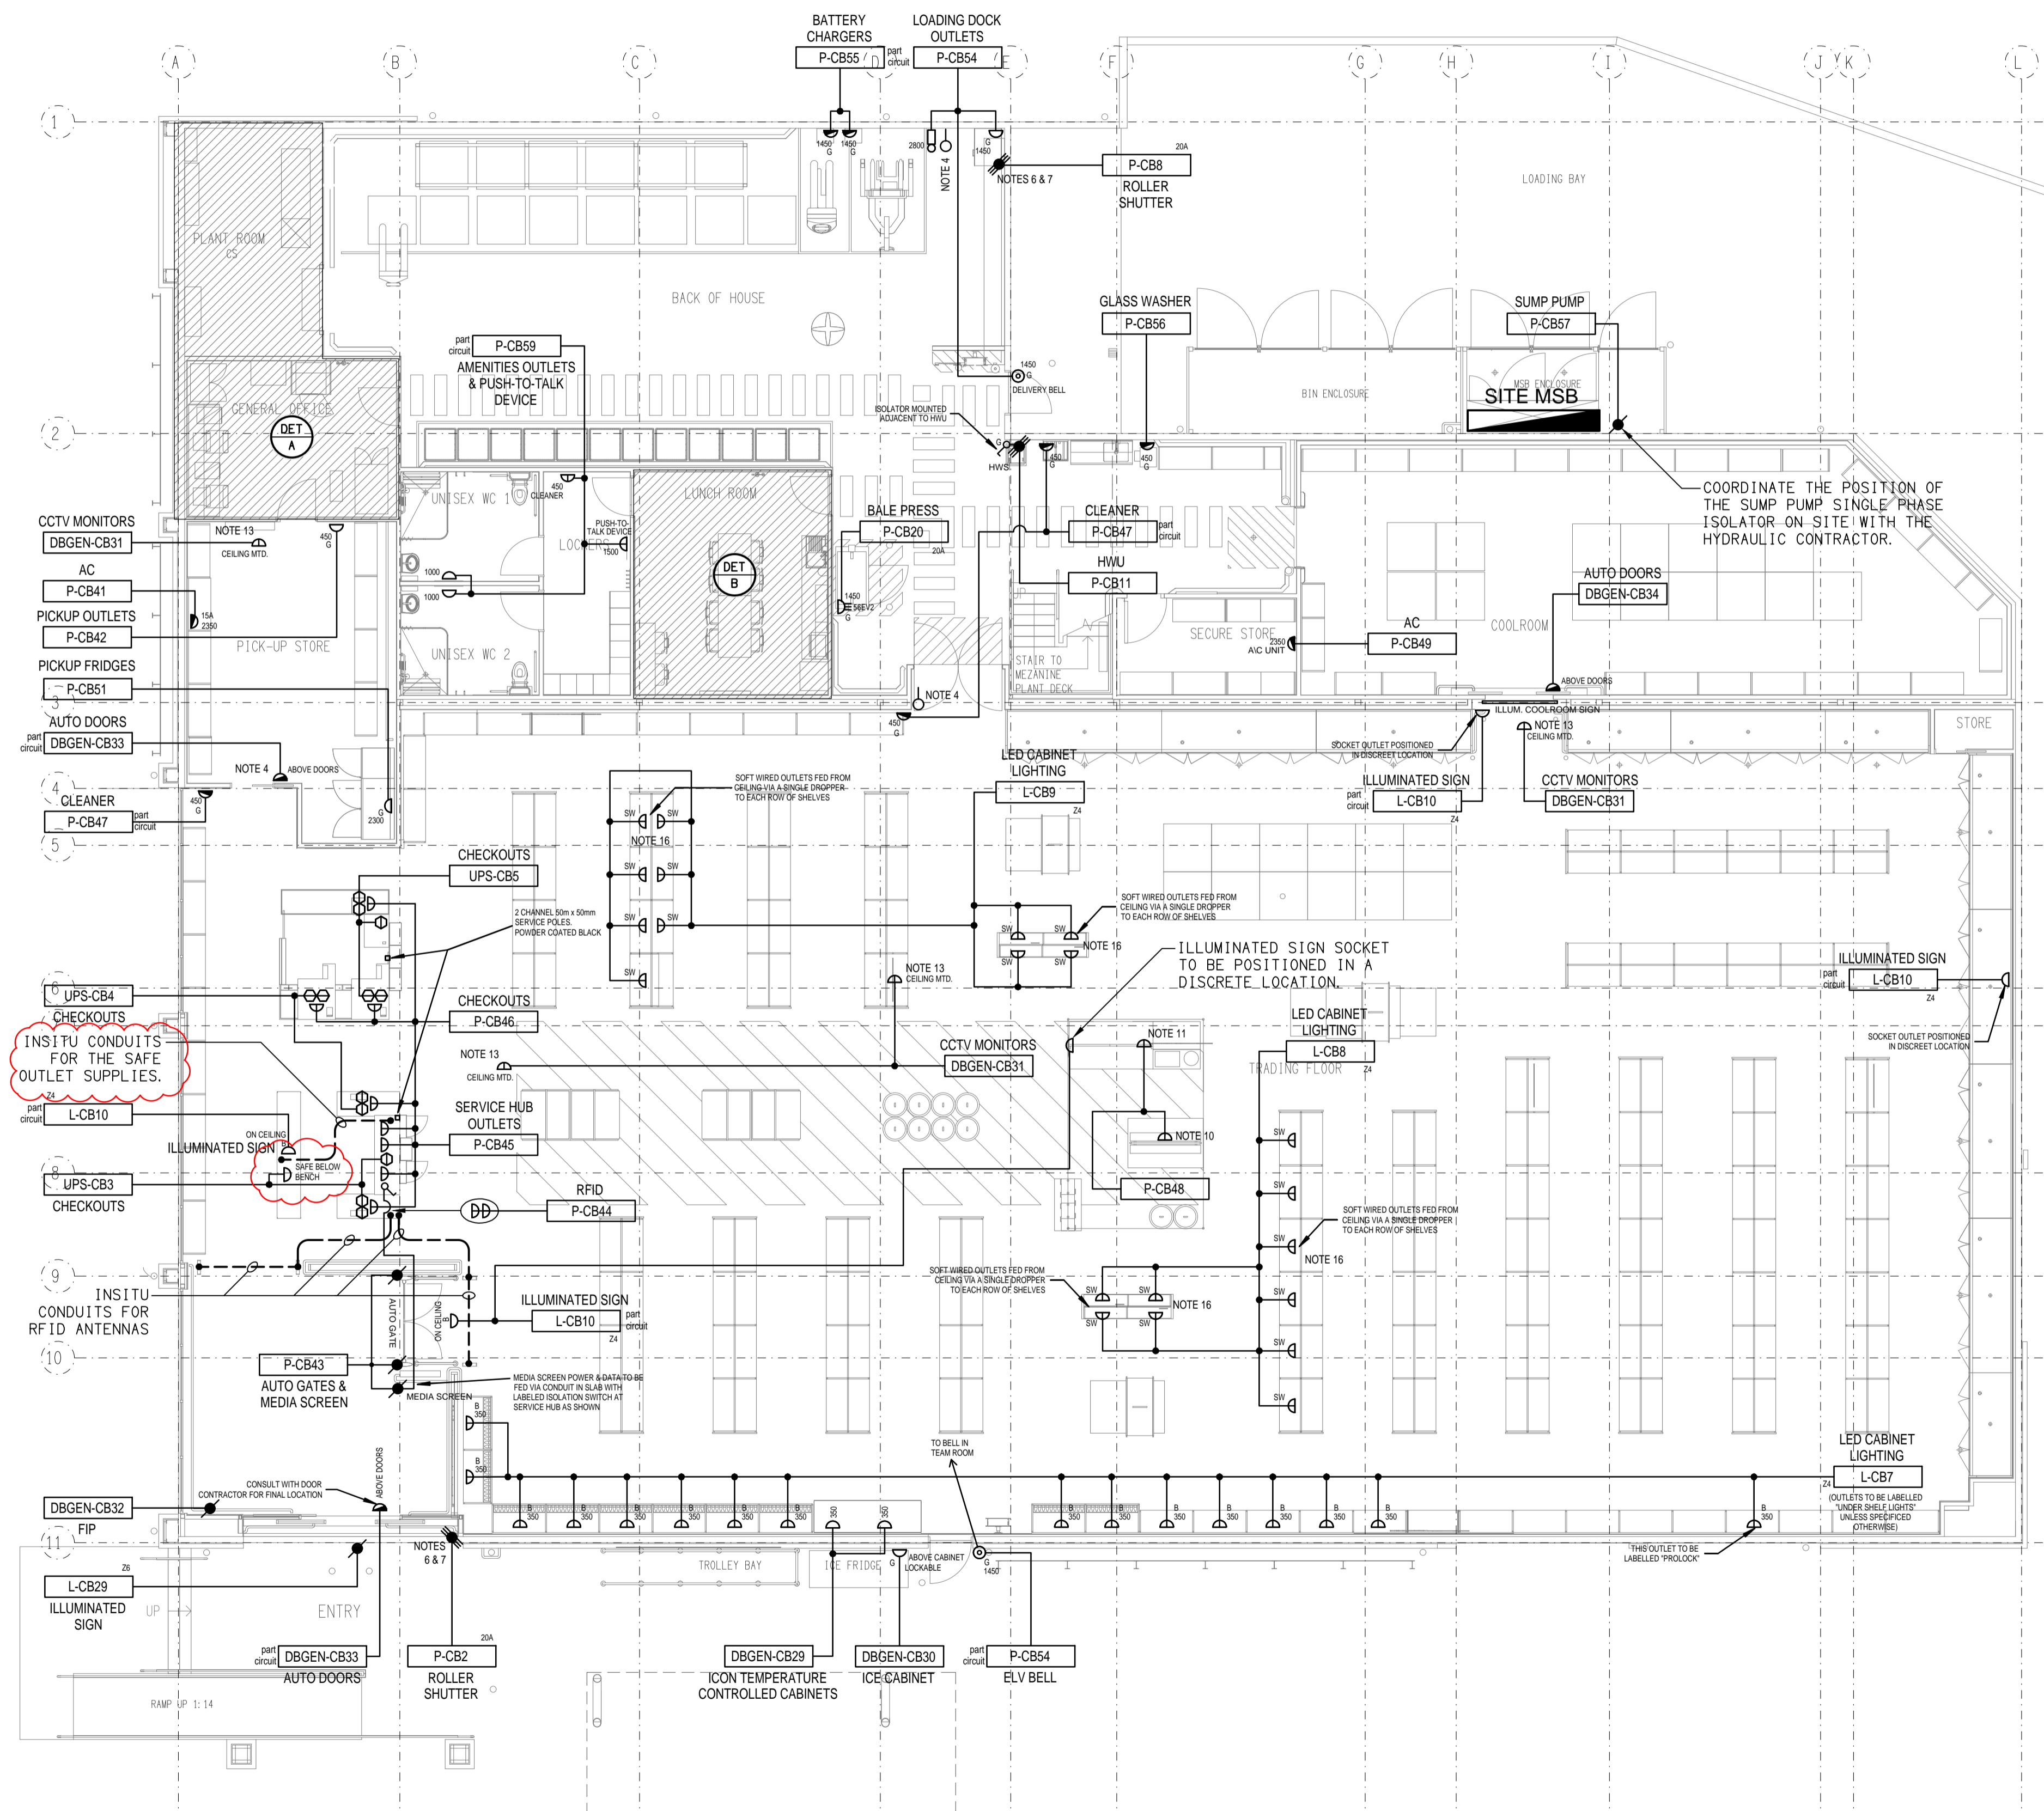

ELECTRICAL DESIGN GROUP BRISBANE
PTY LTD
ACN 092 710 793
TRADING AS:
ELECTRICAL DESIGN GROUP

THE COPYRIGHT OF THIS DRAWING
REMAINS THE PROPERTY OF THE
ELECTRICAL DESIGN GROUP.
USE FIGURED DIMENSIONS
IN PREFERENCE TO SCALE.
ALL DIMENSIONS TO BE
VERIFIED ONSITE.

ELECTRICAL DESIGN GROUP
ELECTRICAL BUILDING SERVICES CONSULTANTS
BRISBANE GOLD COAST

P.O. Box 15, Sherwood Q.4075
Phone: (07) 3278 4375
Email: brisbane@edg.net.au
Web: www.edg.net.au

PROJECT:
THE BROOK HOTEL, MITCHELTON
167 OSBORNE ROAD, MITCHELTON

G	CONSTRUCTION	11/08/2022
REV:	DESCRIPTION:	DATE:
DRAWING: ELECTRICAL SERVICES DAN MURPHY'S GROUND LEVEL FLOOR PLAN		
SCALE: 1:100 UNO	PROJECT NO: AT A1 C2499a	DRAWING NO: E22
		REVISION: G