


GROUND LEVEL
DAN MURPHY'S PLAN
SCALE 1: 100

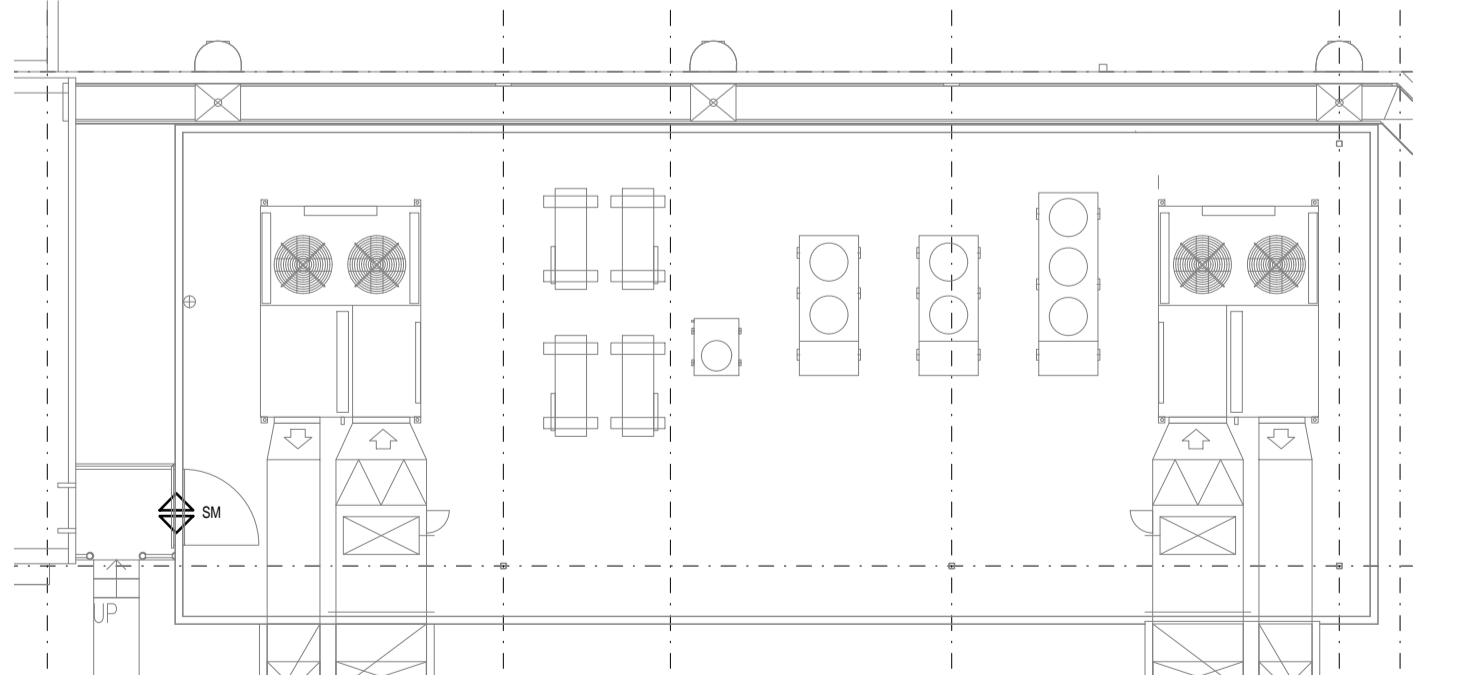

ROOF LEVEL
DAN MURPHY'S PLAN
SCALE 1: 100

CCTV SECURITY LEGEND

	NETWORK VIDEO RECORDER
	6RU CCTV CABINET
	12RU CCTV CABINET
	CCTV SWITCH
	POE EXTENDER
	IP CAMERA DECODER
	FLOOR DISTRIBUTOR
	40\"/>
	32\"/>
	24\"/>
	19\"/>
	PTZ CAMERA
	DOME CAMERA
	IR CAMERA
	FULL BODY CAMERA
	IP CAMERA 360
	IP CAMERA
	DUMMY DOME

29 CAMERA SYSTEM

IP CAMERA LOCATIONS

	STORE ENTRY
	POINT OF SALE 1
	POINT OF SALE 2
	POINT OF SALE 3
	EYE LEVEL EXIT
	PREMIUM WINES FRONT
	PREMIUM WINES REAR
	SPIRITS 1
	SPIRITS CABINET
	SPIRITS 2
	SPIRITS 3
	BULK STACK BEER
	RTD FRIDGE
	CASH OFFICE INTERNAL
	COOLROOM
	STOCKROOM
	DOCK INTERNAL
	STAFF ENTRY
	OUTSIDE FRONT CARPARK LEFT
	DOCK EXTERNAL
	OUTSIDE FRONT CARPARK RIGHT
	SECURITY RESERVE
	LANGTONS
	COOLROOM 2
	WINE REAR
	WINE FRONT
	WINE OVERVIEW
	TASTING AREA
	OUTSIDE EXTERNAL LEFT SIDE

ALARM SECURITY LEGEND

	ROLLER SHUTTER REED SWITCHES
	CONCEALED MAGNETIC REED SWITCHES
	SURFACE MOUNT REED SWITCHES
	DAY ALARM SIREN C/W COVER
	WIDE ANGLE MOVEMENT DETECTOR
	LONG RANGE MOVEMENT DETECTOR
	360 CEILING MOVEMENT DETECTOR
	ENTRY / EXIT BUZZER
	GLASS BREAK
	STROBE
	HOLD UP BUTTON
	RADIO DURESS RECEIVER UNIT
	INTERNAL SIREN
	EXTERNAL SATELLITE SIREN
	SECURITY PANEL
	DATA GATHERING PANEL
	ELECTRIC STRIKE
	ELECTRO-MAGNETIC LOCK
	INTERCOM MASTER UNIT
	INTERCOM DOOR UNIT
	ALARM OVER IP BACKUP UNIT
	GSM BACKUP UNIT
	POWER SUPPLY UNIT
	LIGHTING CONTROL INTERFACE
	ROLLER SHUTTER INTERFACE UNIT
	REFRIGERATION ALARM
	UPS INPUT POWER FAILURE
	8 AREA REMOTE ARMING STATION
	16 AREA REMOTE ARMING STATION
	EXTERNAL REMOTE ARMING STATION
	SMOKE DETECTOR
	CARD READER

MONITOR LOCATIONS

	STORE ENTRY 40\"/>
	SPIRITS 40\"/>
	COOLROOM 40\"/>

CCTV & SECURITY NOTES

1. SECURITY AND CCTV LAYOUT IS INDICATIVE ONLY. ELECTRICAL CONTRACTOR IS TO REFER TO SECURITY CONTRACTOR'S SITE SPECIFIC DESIGN TO ALLOW FOR POWER AND DATA OUTLETS AND ALL NECESSARY CONCEALED CONDUITS / WALL BOXES.

ELECTRICAL DESIGN GROUP BRISBANE
PTY LTD
ACN 092 710 793
TRADING AS:
ELECTRICAL DESIGN GROUP

THE COPYRIGHT OF THIS DRAWING
REMAINS THE PROPERTY OF THE
ELECTRICAL DESIGN GROUP.
USE FIGURED DIMENSIONS
IN PREFERENCE TO SCALE.
ALL DIMENSIONS TO BE
VERIFIED ONSITE.

ELECTRICAL DESIGN GROUP
ELECTRICAL BUILDING SERVICES CONSULTANTS
BRISBANE GOLD COAST
P.O. Box 15, Sherwood Q.4075
Phone: (07) 3278 4375
Email: brisbane@edg.net.au
Web: www.edg.net.au

PROJECT:
THE BROOK HOTEL, MITCHELTON
167 OSBORNE ROAD, MITCHELTON

C	CONSTRUCTION	27/01/2022
REV:	DESCRIPTION:	DATE:
DRAWING: ELECTRICAL SERVICES DAN MURPHY'S CCTV & SECURITY		
SCALE: 1:100	PROJECT NO: C2499a	DRAWING NO: E27
AT A1	REVISION: C	