


DATA LEGEND


TO	SCS TELECOMMUNICATIONS OUTLET REG = REGISTER, PC = COMPUTER, TEL = PHONE, SEC = SECURITY, PR = PRINTER, SAFE = INTELLISAFE, FAX = FAX MACHINE, TV = TV / DIGITAL DISPLAY, EAS = EAS OUTLET, EMS = EMS OUTLET, FS = FINGER SCAN, FIP = FIP OUTLET, UPS = UPS OUTLET
RF TO	RF OUTLET - REFER TO PREDICTIVE SURVEY REPORT FOR LOCATIONS. QUANTITIES ARE INDICATIVE ONLY.
BD	SCS BUILDING DISTRIBUTOR
---	BLACK 3-CHANNEL METAL DUCT, 150mm X 50mm, ECD OR CABLEWAY

DATA NOTES

- SCS DATA SYSTEM TO BE INSTALLED AS PER WOOLWORTHS STORES SCS SPECIFICATION.
- DATA CONTRACTOR TO LIAISE WITH ELECTRICAL CONTRACTOR FOR POWER AND CABLE WAY REQUIREMENTS.

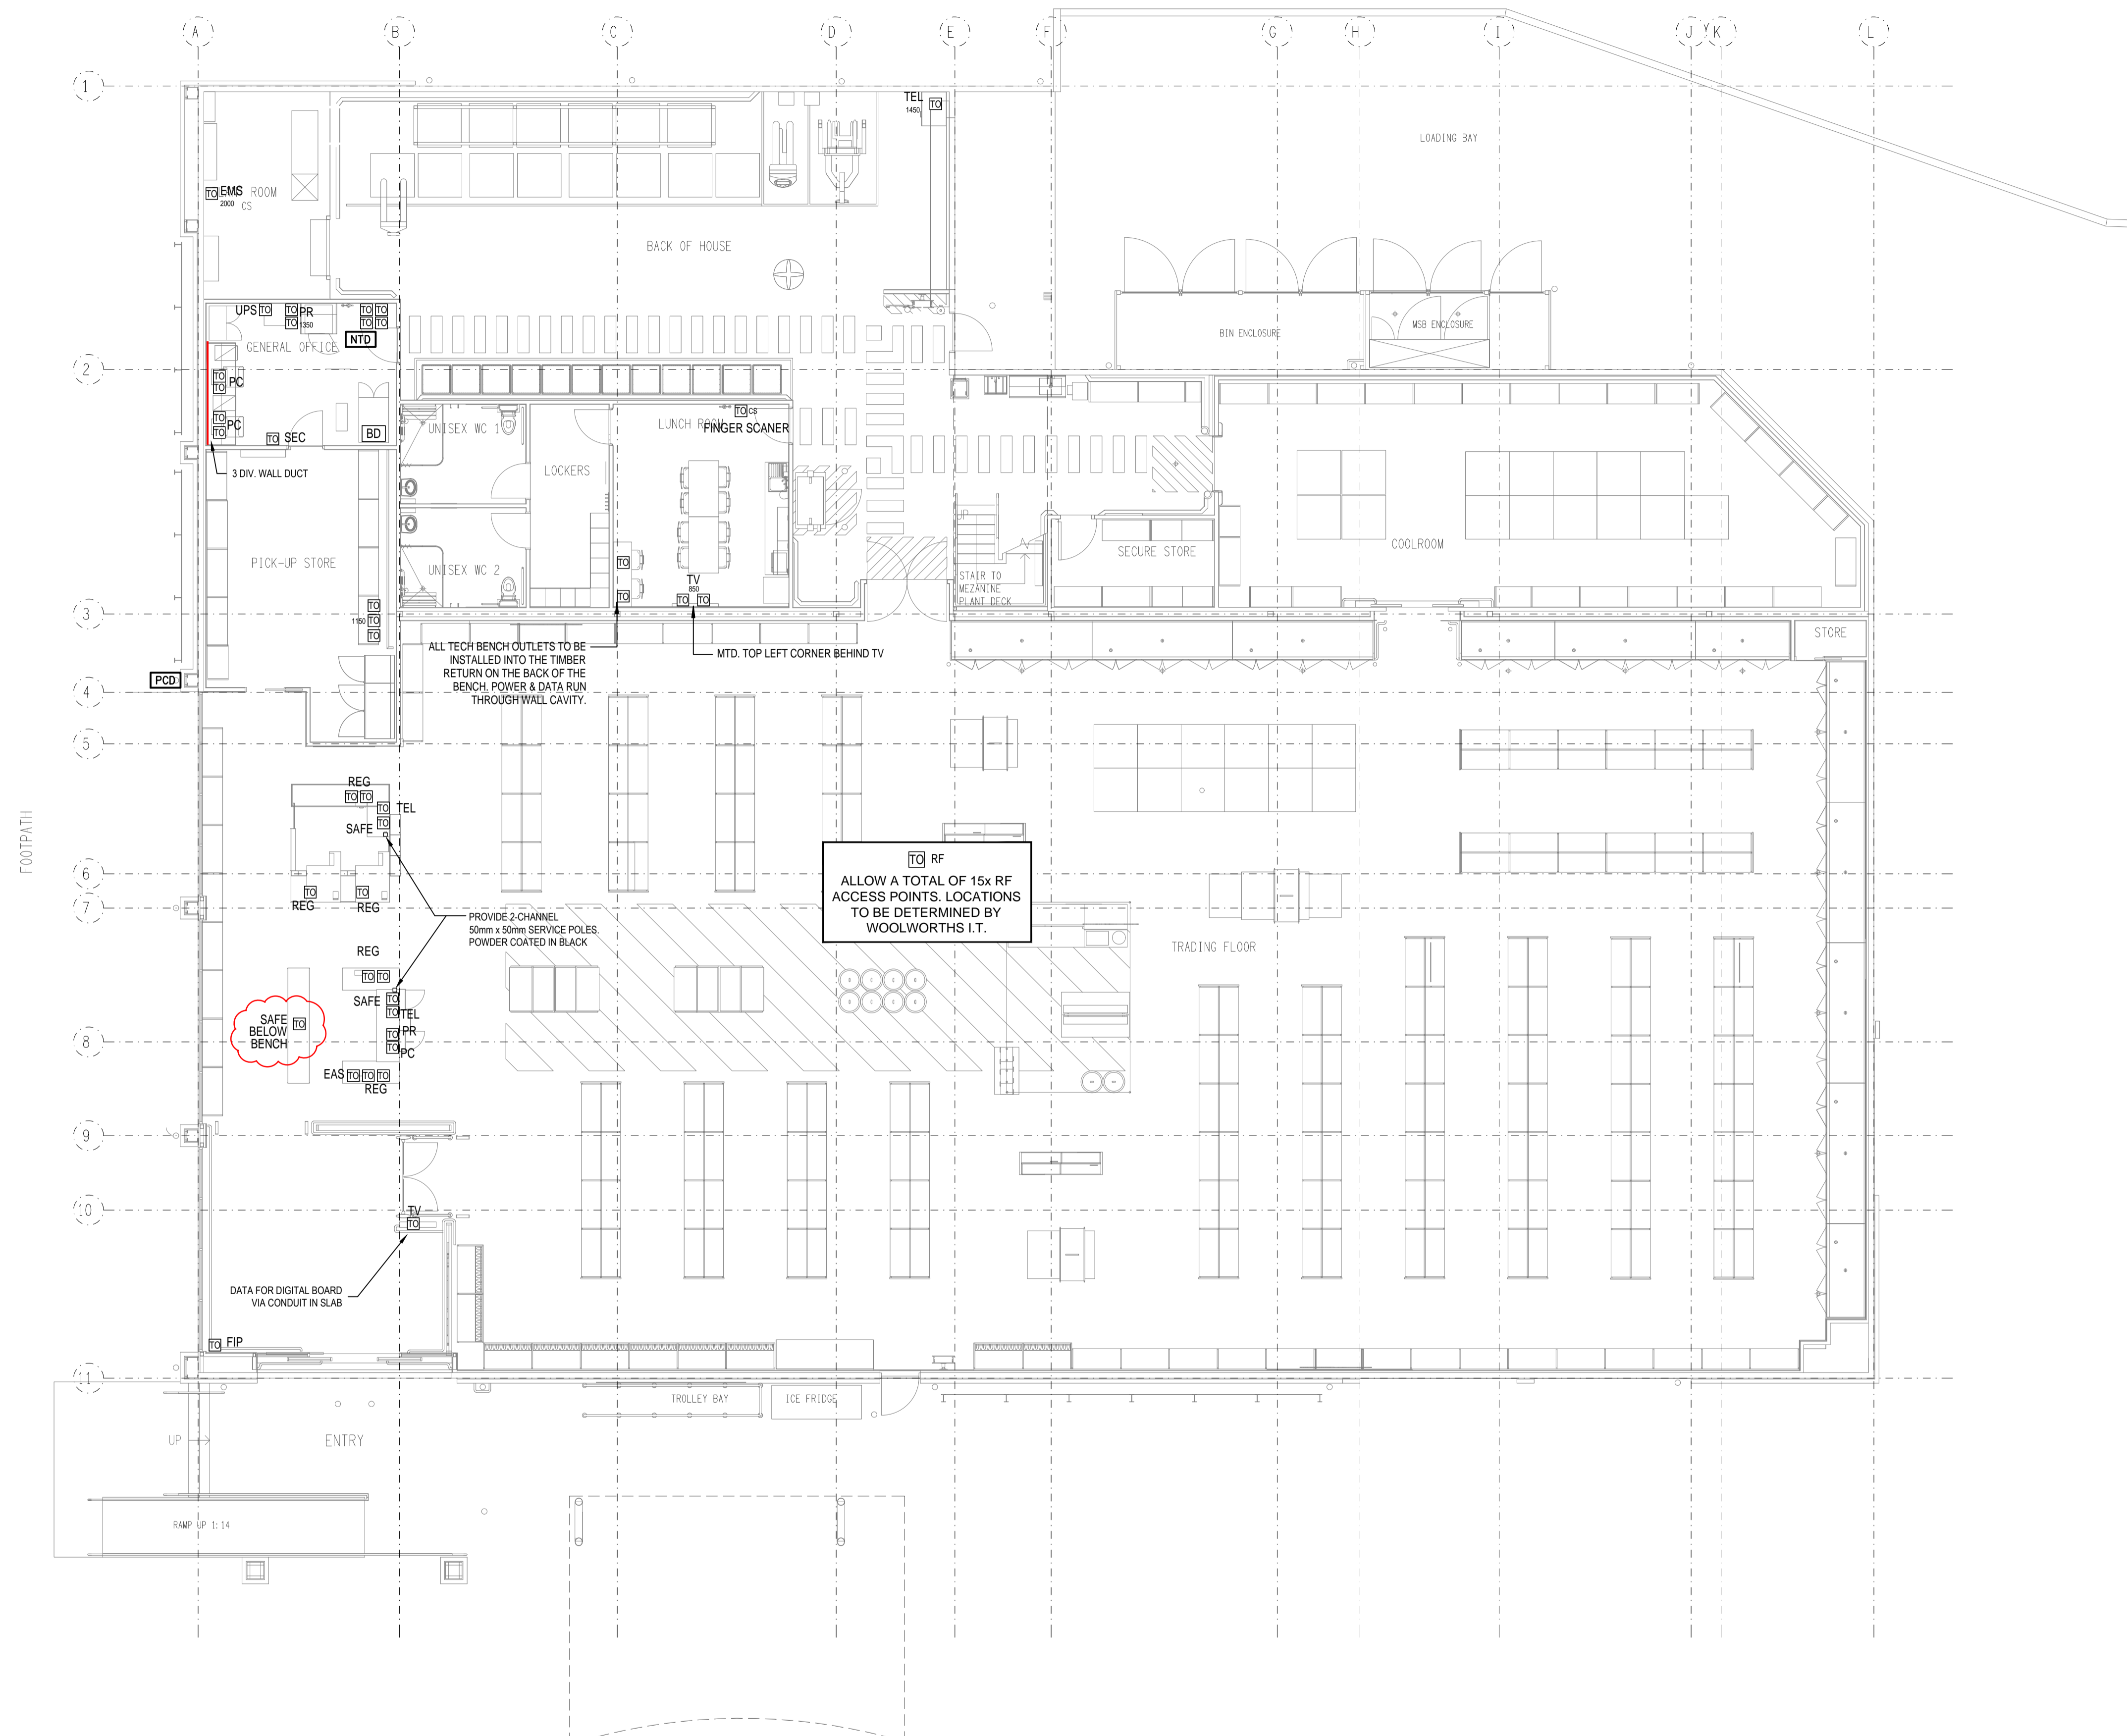

"POWER" OR "TO" PLATE

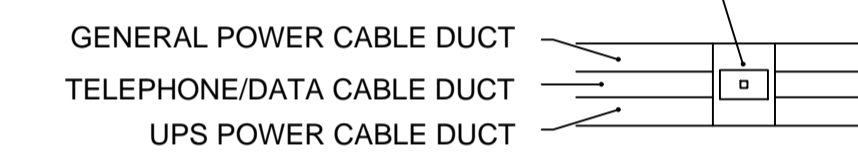

ELECTRICAL CONTRACTOR IS TO INSTALL 3-CHANNEL DUCTING. HEIGHT TO UNDERSIDE OF DUCT ABOVE BENCH TO BE 60mm IN OFFICE

WALL DUCT DETAIL

ELECTRICAL DESIGN GROUP BRISBANE PTY LTD
ACN 092 710 793
TRADING AS:
ELECTRICAL DESIGN GROUP

THE COPYRIGHT OF THIS DRAWING REMAINS THE PROPERTY OF THE ELECTRICAL DESIGN GROUP.
USE FIGURED DIMENSIONS IN PREFERENCE TO SCALE.
ALL DIMENSIONS TO BE VERIFIED ONSITE.

ELECTRICAL DESIGN GROUP
ELECTRICAL BUILDING SERVICES CONSULTANTS
BRISBANE GOLD COAST
P.O. Box 15, Sherwood Q.4075
Phone: (07) 3278 4375
Email: brisbane@edg.net.au
Web: www.edg.net.au

PROJECT:
THE BROOK HOTEL, MITCHELTON
167 OSBORNE ROAD, MITCHELTON

D	CONSTRUCTION	11/08/2022
REV.	DESCRIPTION:	DATE:
DRAWING: ELECTRICAL SERVICES DAN MURPHY'S DATA LAYOUT		
SCALE: 1:100	PROJECT NO: C2499a	DRAWING NO: E29
AT A1	REVISION: D	