



PLAN

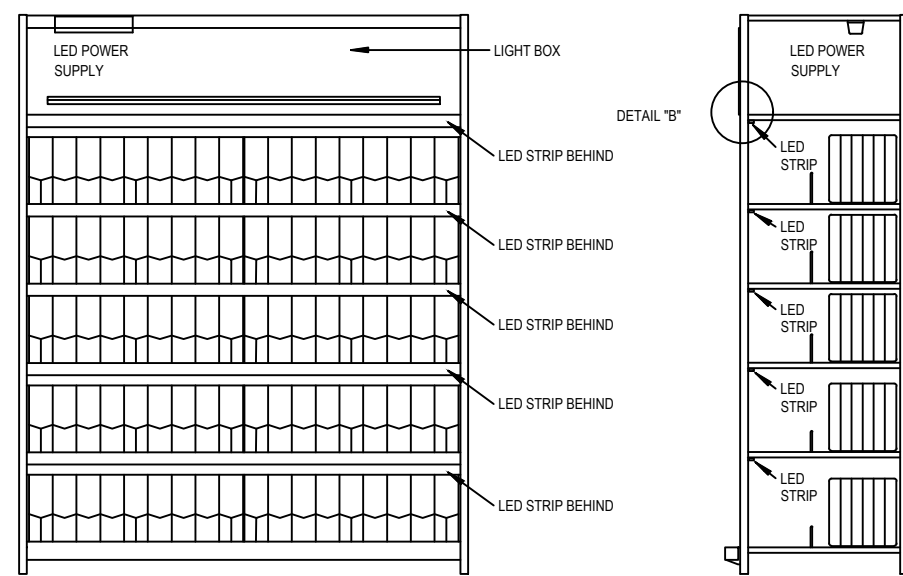


FRONT ELEVATION

SECTION

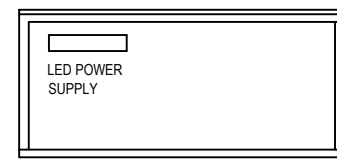


PLAN

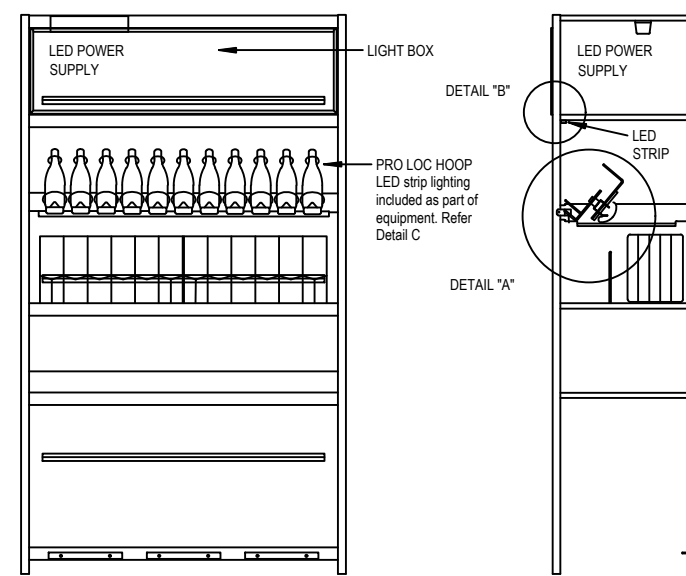


FRONT ELEVATION

SECTION

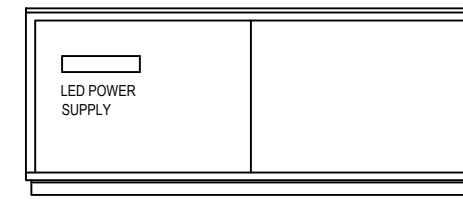


PLAN

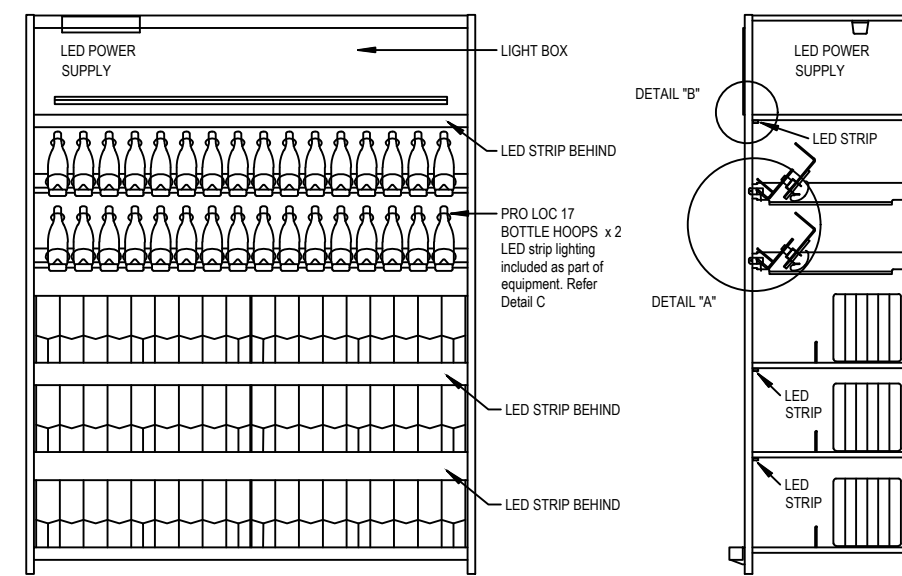


FRONT ELEVATION

SECTION

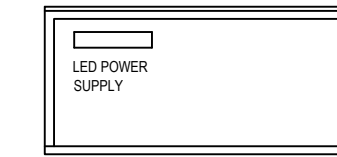


PLAN

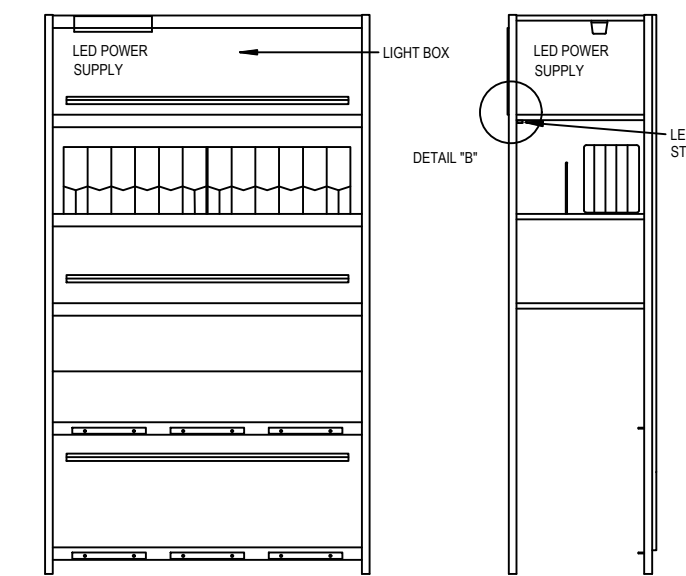

FRONT ELEVATION

SECTION

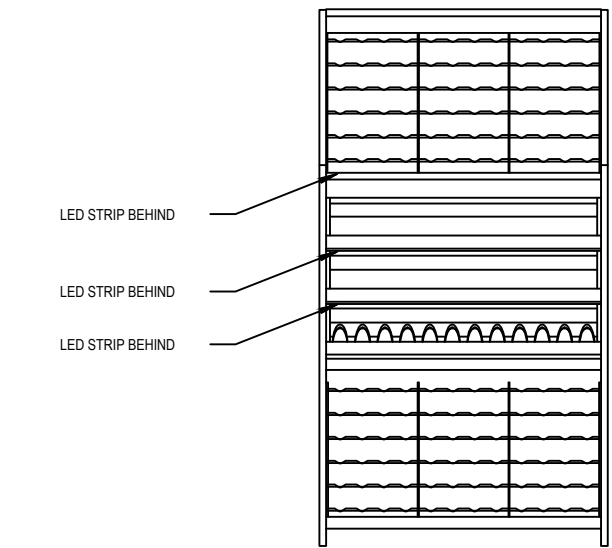

FRONT ELEVATION

SECTION


**B2 CABINET - LED LIGHTING**

ELECTRICAL CONTRACTOR TO SUPPLY AND INSTALL LIGHTING

SUPPLIER: TREND LIGHTING  
 ORDER CODE: XF24120B3-EXM  
 DESCRIPTION: 5 x 1740mm LONG, 24V 8W/m LOW WATTAGE LED STRIP, 3000K  
 c/w ALUMINIUM MAGNETIC EXTRUSION, OPAL DIFFUSER, LED DRIVER, 3m LEAD

**DETAIL 1**

LED 1  
 NTS

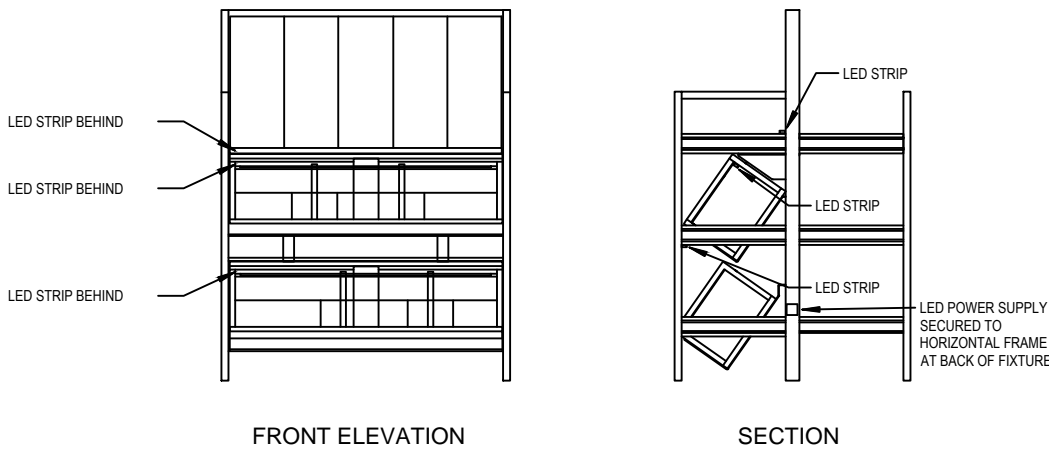

FRONT ELEVATION

SECTION


**M WALL BAYS - WOTW - LED LIGHTING**

ELECTRICAL CONTRACTOR TO SUPPLY AND INSTALL LIGHTING

SUPPLIER: TREND LIGHTING  
 ORDER CODE: XF24120B3-EXM  
 DESCRIPTION: 1 x 1240mm LONG, 24V 8W/m LOW WATTAGE LED STRIP, 3000K  
 c/w ALUMINIUM MAGNETIC EXTRUSION, OPAL DIFFUSER, LED DRIVER, 3m LEAD

**DETAIL 2**

LED 2  
 NTS

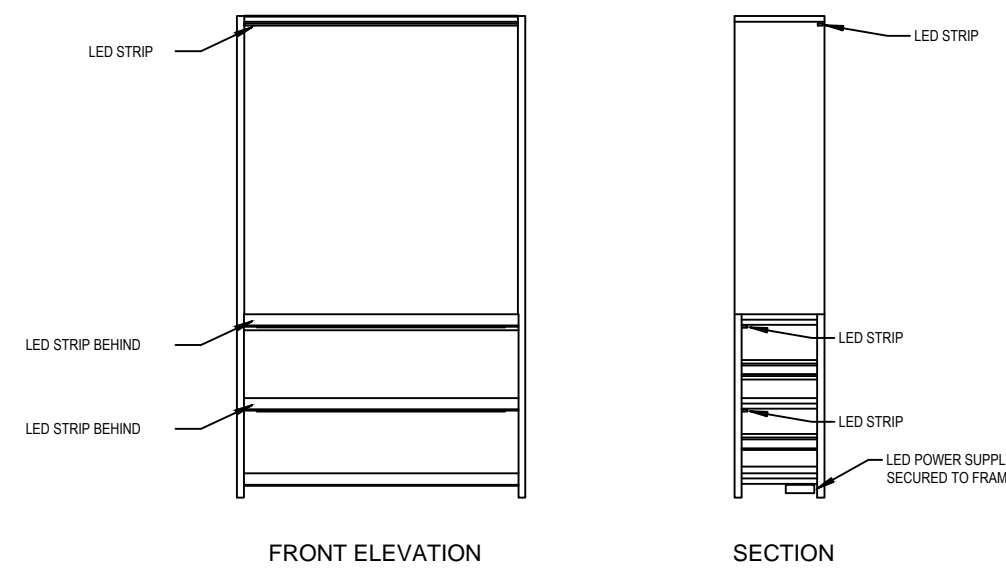

FRONT ELEVATION

SECTION


**B28 CABINET - LED LIGHTING**

ELECTRICAL CONTRACTOR TO SUPPLY AND INSTALL LIGHTING

SUPPLIER: TREND LIGHTING  
 ORDER CODE: XF24120B3-EXM  
 DESCRIPTION: 3 x 1740mm LONG, 24V 8W/m LOW WATTAGE LED STRIP, 3000K  
 c/w ALUMINIUM MAGNETIC EXTRUSION, OPAL DIFFUSER, LED DRIVER, 3m LEAD

**DETAIL 3**

LED 3  
 NTS

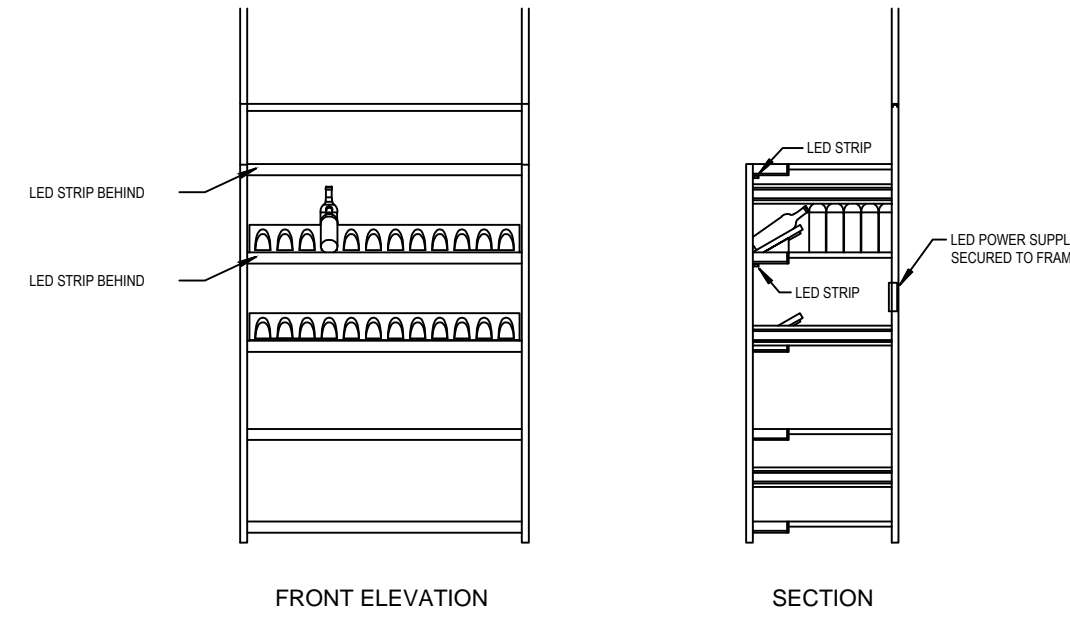

FRONT ELEVATION

SECTION


**M WALL BAYS - LED LIGHTING**

ELECTRICAL CONTRACTOR TO SUPPLY AND INSTALL LIGHTING

SUPPLIER: TREND LIGHTING  
 ORDER CODE: XF24120B3-EXM  
 DESCRIPTION: 1 x 1240mm LONG, 24V 8W/m LOW WATTAGE LED STRIP, 3000K  
 c/w ALUMINIUM MAGNETIC EXTRUSION, OPAL DIFFUSER, LED DRIVER, 3m LEAD

**DETAIL 4**

LED 4  
 NTS

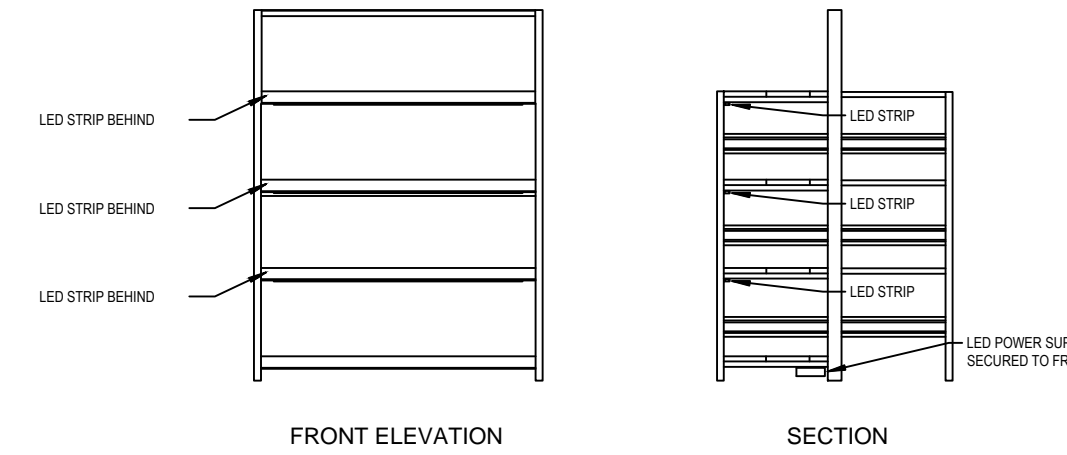

FRONT ELEVATION

SECTION


**FINE WINE SECURITY WALL BAY - TYPE B**

ELECTRICAL CONTRACTOR TO SUPPLY AND INSTALL LIGHTING

SUPPLIER: TREND LIGHTING  
 ORDER CODE: XF24120B3-EXM  
 DESCRIPTION: 3 x 1240mm LONG, 24V 8W/m LOW WATTAGE LED STRIP, 3000K  
 c/w ALUMINIUM MAGNETIC EXTRUSION, OPAL DIFFUSER, LED DRIVER, 3m LEAD

**DETAIL 5**

LED 5  
 NTS

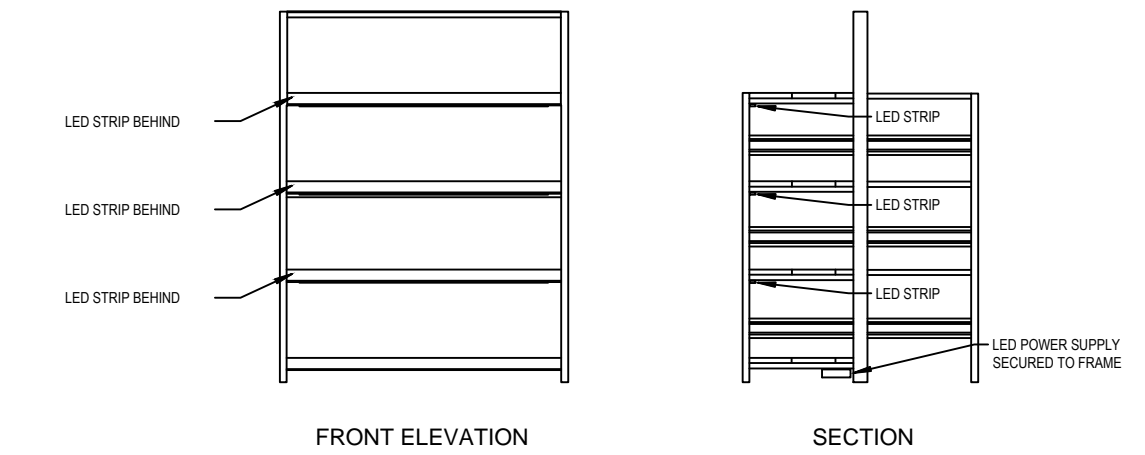

FRONT ELEVATION

SECTION


**CELLAR RELEASE BAY**

CABINET MANUFACTURER TO SUPPLY LIGHTS,  
 INSTALLATION BY ELECTRICAL CONTRACTOR

SUPPLIER: TREND LIGHTING  
 ORDER CODE: XF24120B3-EXM  
 DESCRIPTION: 3 x 1240mm LONG, 24V 8W/m LOW WATTAGE LED STRIP, 3000K  
 c/w ALUMINIUM MAGNETIC EXTRUSION, OPAL DIFFUSER, LED DRIVER, 3m LEAD

**DETAIL 6**

LED 6  
 NTS

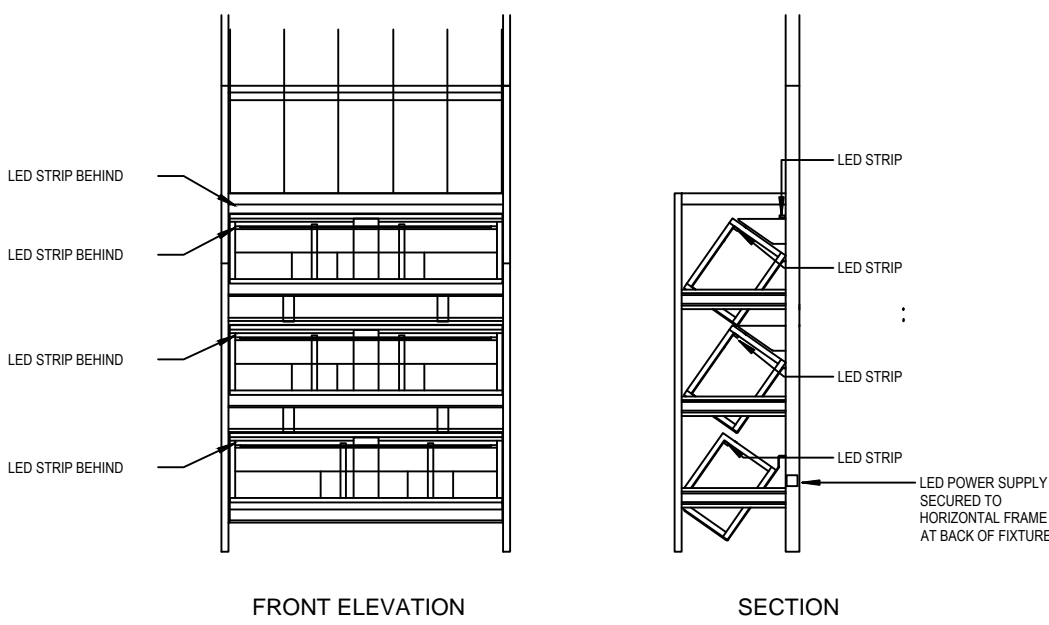

FRONT ELEVATION

SECTION


**MID FLOOR WARDROBE BAY**

CABINET MANUFACTURER TO SUPPLY LIGHTS,  
 INSTALLATION BY ELECTRICAL CONTRACTOR

SUPPLIER: TREND LIGHTING  
 ORDER CODE: XF24120B3-EXM  
 DESCRIPTION: 3 x 760mm LONG, 24V 8W/m LOW WATTAGE LED STRIP, 3000K  
 c/w ALUMINIUM MAGNETIC EXTRUSION, OPAL DIFFUSER, LED DRIVER, 3m LEAD

**DETAIL 7**

LED 7  
 NTS

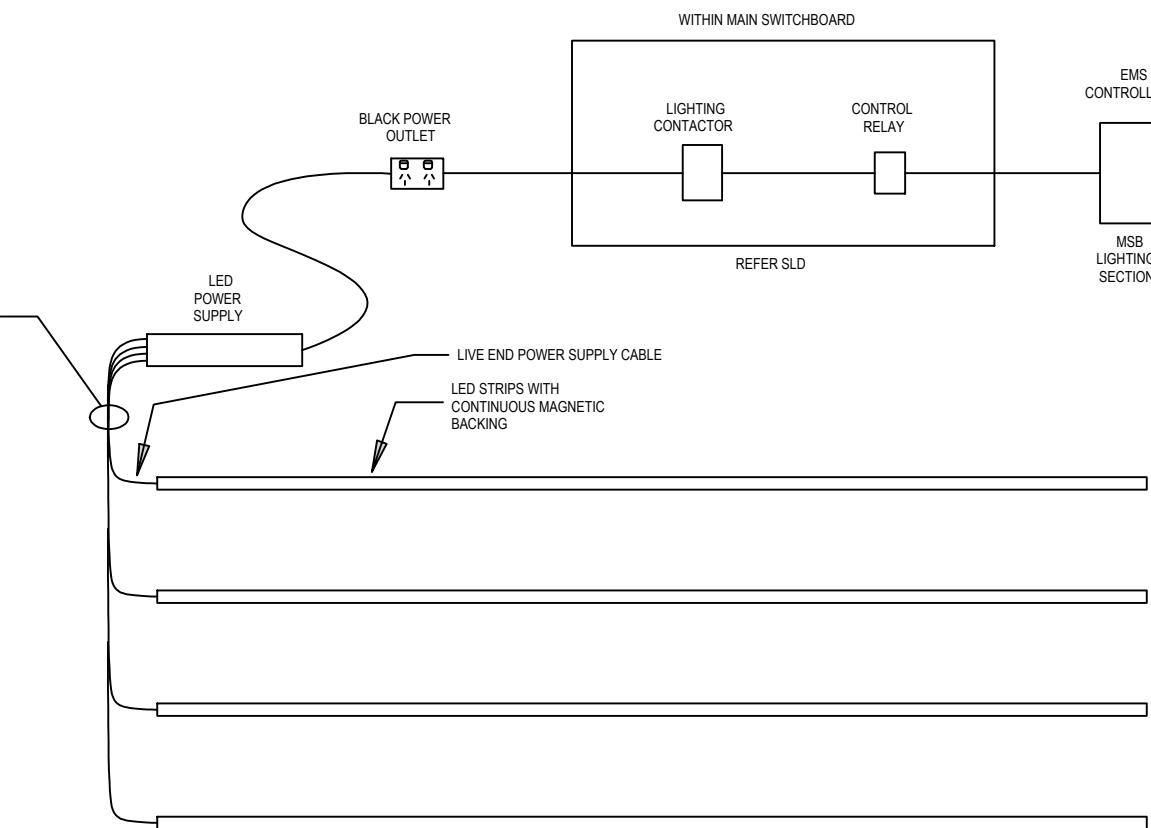

**DETAIL 12**

TYPICAL ARRANGEMENT  
 NTS


**FINE WINE WALL BAY - TYPE A**

ELECTRICAL CONTRACTOR TO SUPPLY AND INSTALL LIGHTING

SUPPLIER: TREND LIGHTING  
 ORDER CODE: XF24120B3-EXM  
 DESCRIPTION: 2 x 1180mm LONG, 24V 8W/m LOW WATTAGE LED STRIP, 3000K  
 c/w ALUMINIUM MAGNETIC EXTRUSION, OPAL DIFFUSER, LED DRIVER, 3m LEAD

**DETAIL 8**

LED 8  
 NTS

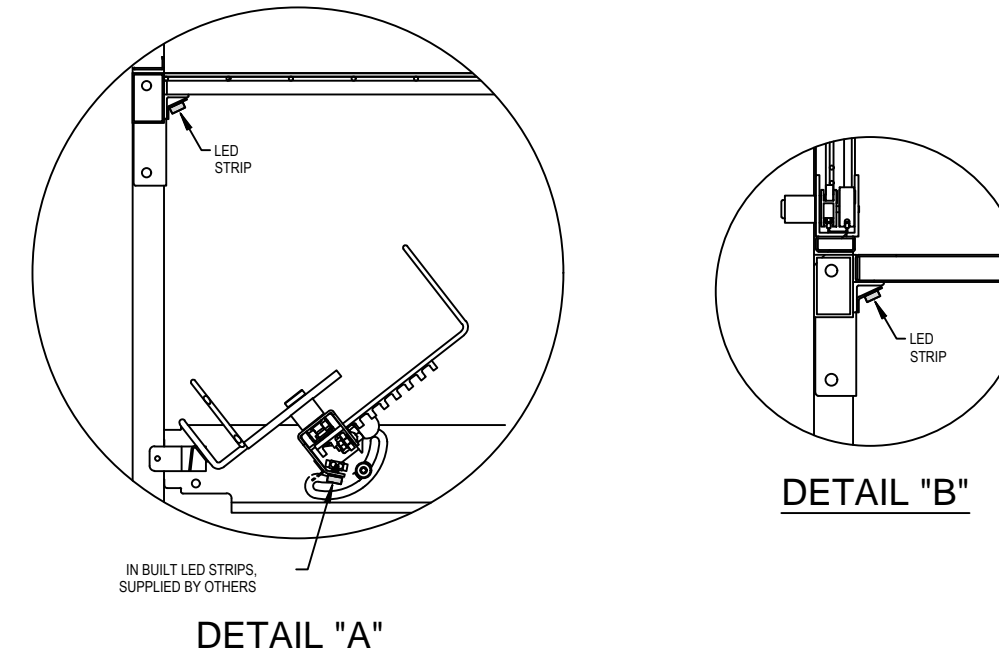

DETAIL "A"

DETAIL "B"


**COCKTAIL MIXOLOGY BAY**

CABINET MANUFACTURER TO SUPPLY LIGHTS,  
 INSTALLATION BY ELECTRICAL CONTRACTOR

SUPPLIER: TREND LIGHTING  
 ORDER CODE: XF24120B3-EXM  
 DESCRIPTION: 3 x 1180mm LONG, 24V 8W/m LOW WATTAGE LED STRIP, 3000K  
 c/w ALUMINIUM MAGNETIC EXTRUSION, OPAL DIFFUSER, LED DRIVER, 3m LEAD

**DETAIL 9**

LED 9  
 NTS

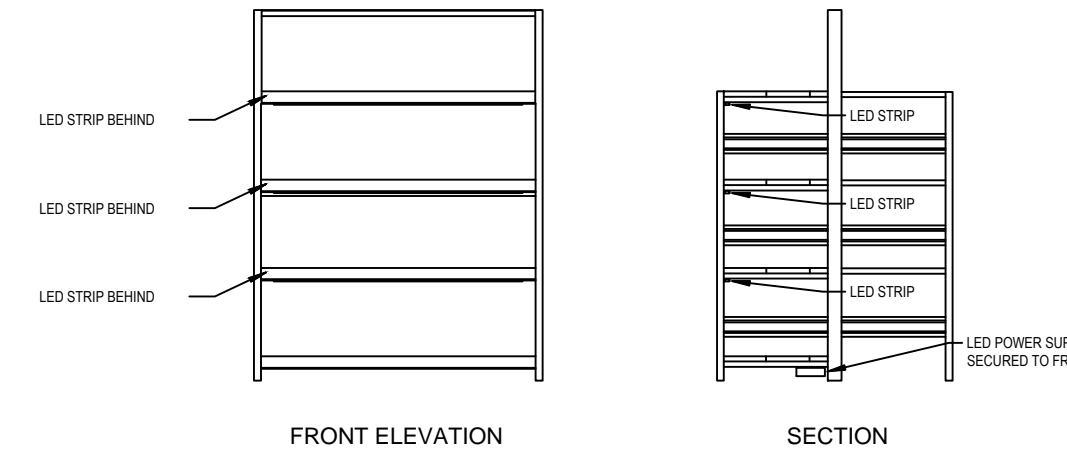

FRONT ELEVATION

SECTION


**CELLAR RELEASE - WALL BAY**

CABINET MANUFACTURER TO SUPPLY LIGHTS,  
 INSTALLATION BY ELECTRICAL CONTRACTOR

SUPPLIER: TREND LIGHTING  
 ORDER CODE: XF24120B3-EXM  
 DESCRIPTION: 4 x 1240mm LONG, 24V 8W/m LOW WATTAGE LED STRIP, 3000K  
 c/w ALUMINIUM MAGNETIC EXTRUSION, OPAL DIFFUSER, LED DRIVER, 3m LEAD

**DETAIL 11**

LED 11  
 NTS

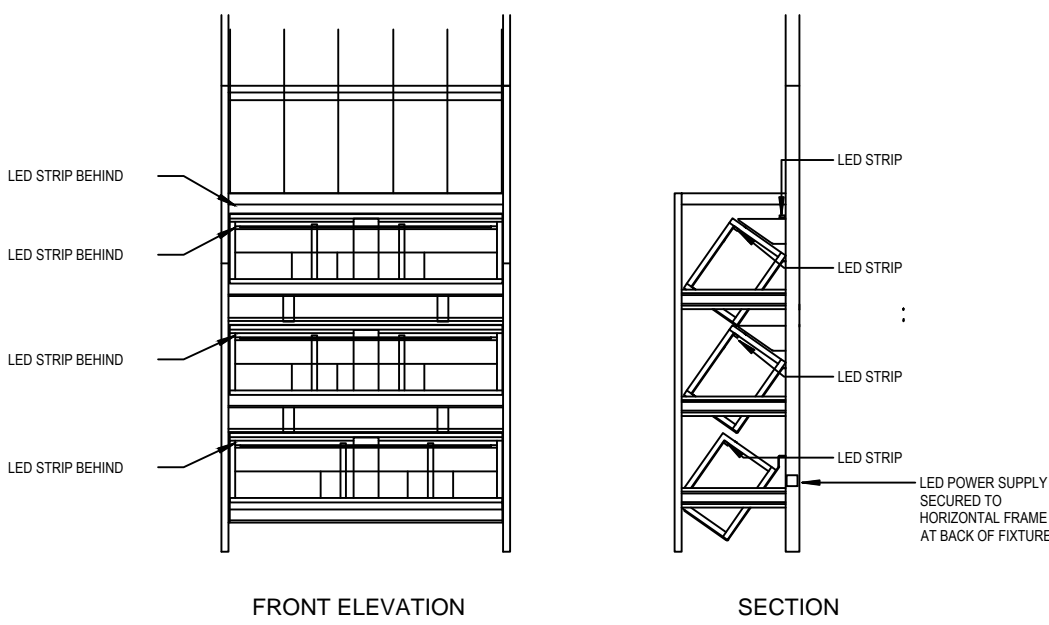


FRONT ELEVATION

SECTION

**GENERAL NOTES**

1. ELECTRICAL CONTRACTOR TO SUPPLY AND / OR INSTALL UNDERSHELF LED STRIP LIGHTS AS DETAILED FOR EACH CABINET TYPE. INCLUDED IN THE SCOPE IS THE PROVISION OF POWER OUTLETS FOR UNDERSHELF LIGHTS.
2. REFER STORE SPECIFIC ARCHITECTURAL DRAWINGS FOR CABINET TYPES AND QUANTITIES REQUIRED.

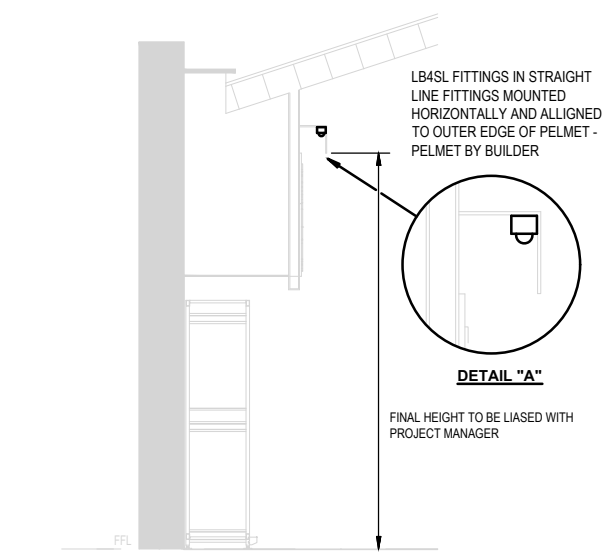

TYPICAL PELMET DETAIL

REFER TO DM STANDARD DWG 009 FOR PELMET DETAILS

ELECTRICAL DESIGN GROUP BRISBANE PTY LTD  
 ACN 092 710 793  
 TRADING AS:  
 ELECTRICAL DESIGN GROUP

THE COPYRIGHT OF THIS DRAWING REMAINS THE PROPERTY OF THE ELECTRICAL DESIGN GROUP.

USE FIGURED DIMENSIONS IN PREFERENCE TO SCALE.

ALL DIMENSIONS TO BE VERIFIED ONSITE.

**ELECTRICAL DESIGN GROUP**  
 ELECTRICAL BUILDING SERVICES CONSULTANTS  
 BRISBANE GOLD COAST

P.O. Box 15, Sherwood Q.4075  
 Phone: (07) 3278 4375  
 Email: brisbane@edg.net.au  
 Web: www.edg.net.au

PROJECT:  
**THE BROOK HOTEL, MITCHELTON**

167 OSBORNE ROAD, MITCHELTON

B	CONSTRUCTION	27/01/2022
REV.	DESCRIPTION:	DATE:
DRAWING: <b>ELECTRICAL SERVICES</b> <b>DAN MURPHY'S</b> <b>LED CABINET DETAILS</b>		
SCALE: NOT TO SCALE AT A1	PROJECT NO: <b>C2499a</b>	DRAWING NO: <b>E31</b>
		REVISION: <b>B</b>