



DETAIL A
KITCHEN & BAR FLOOR PLAN
SCALE 1:50

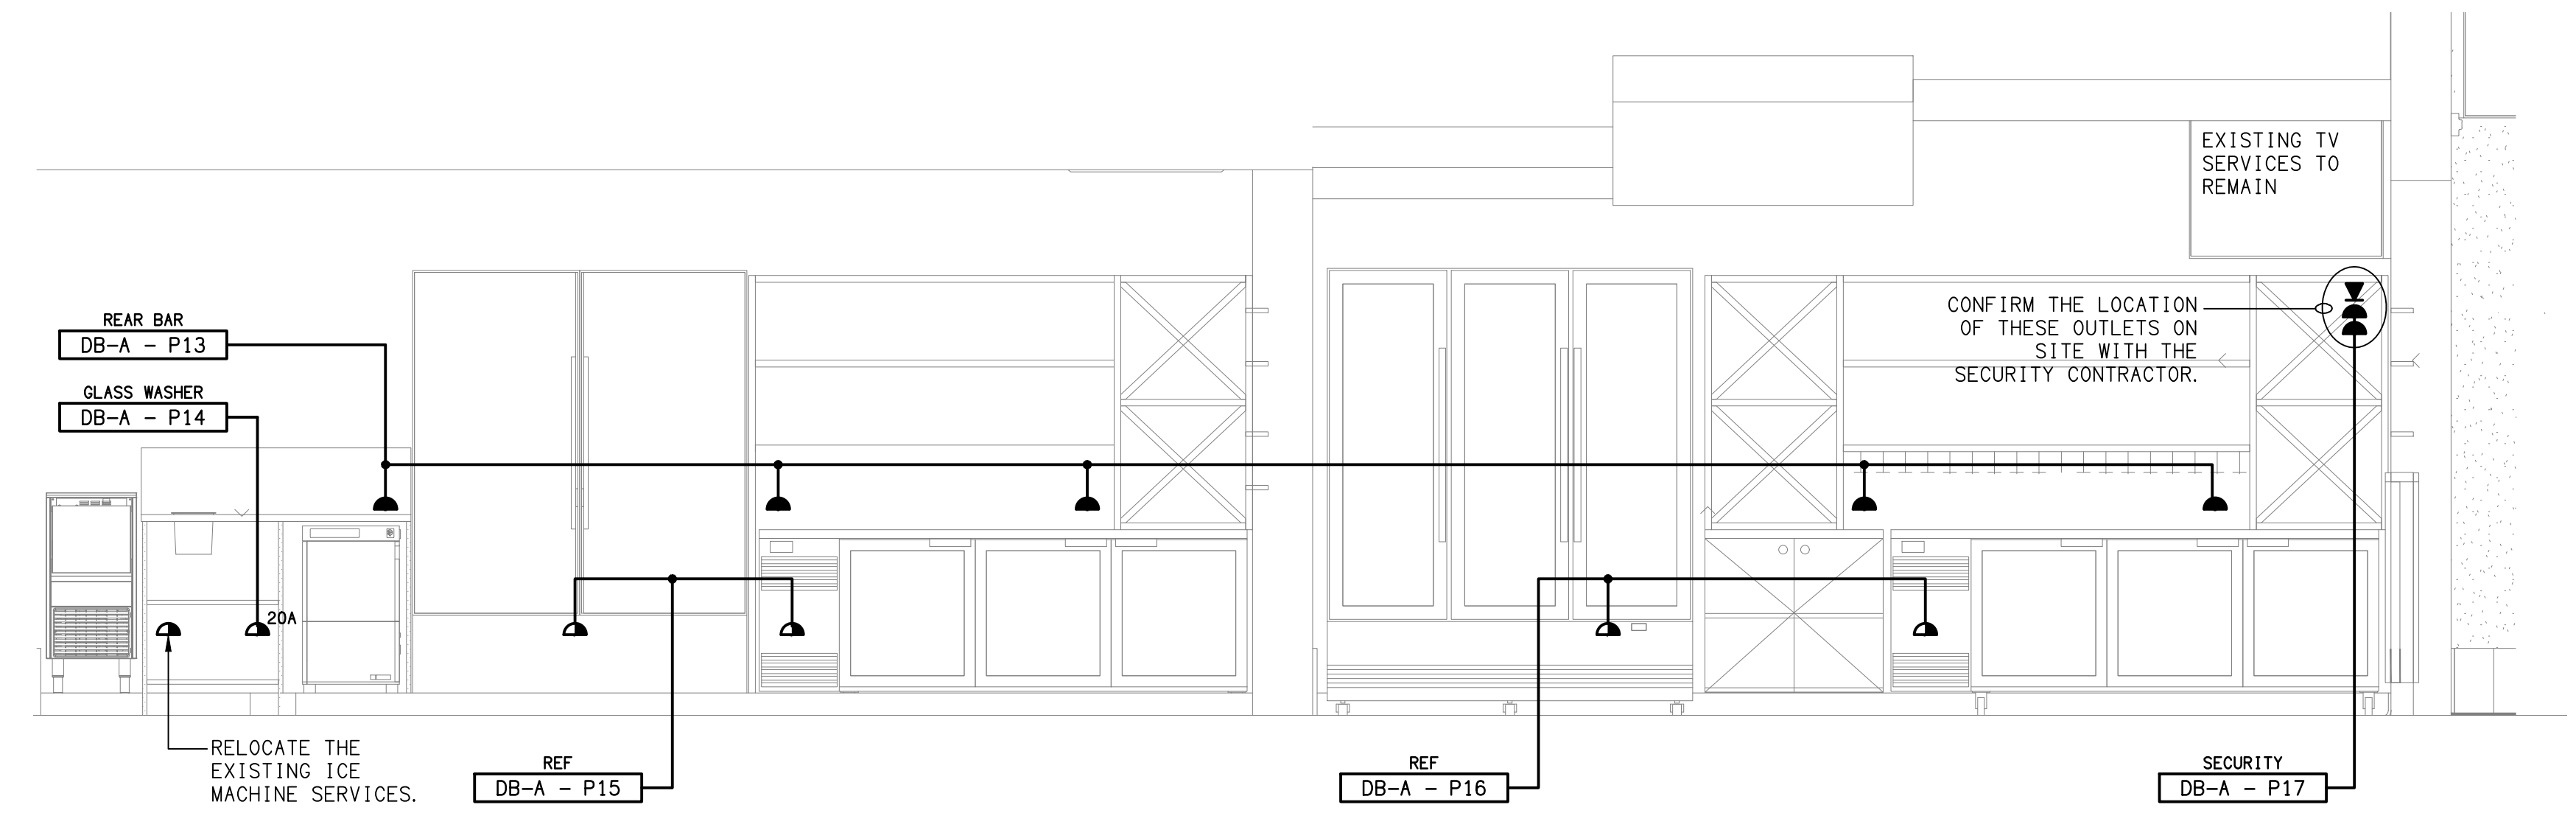

DETAIL C
REAR BAR ELEVATION
SCALE 1:25

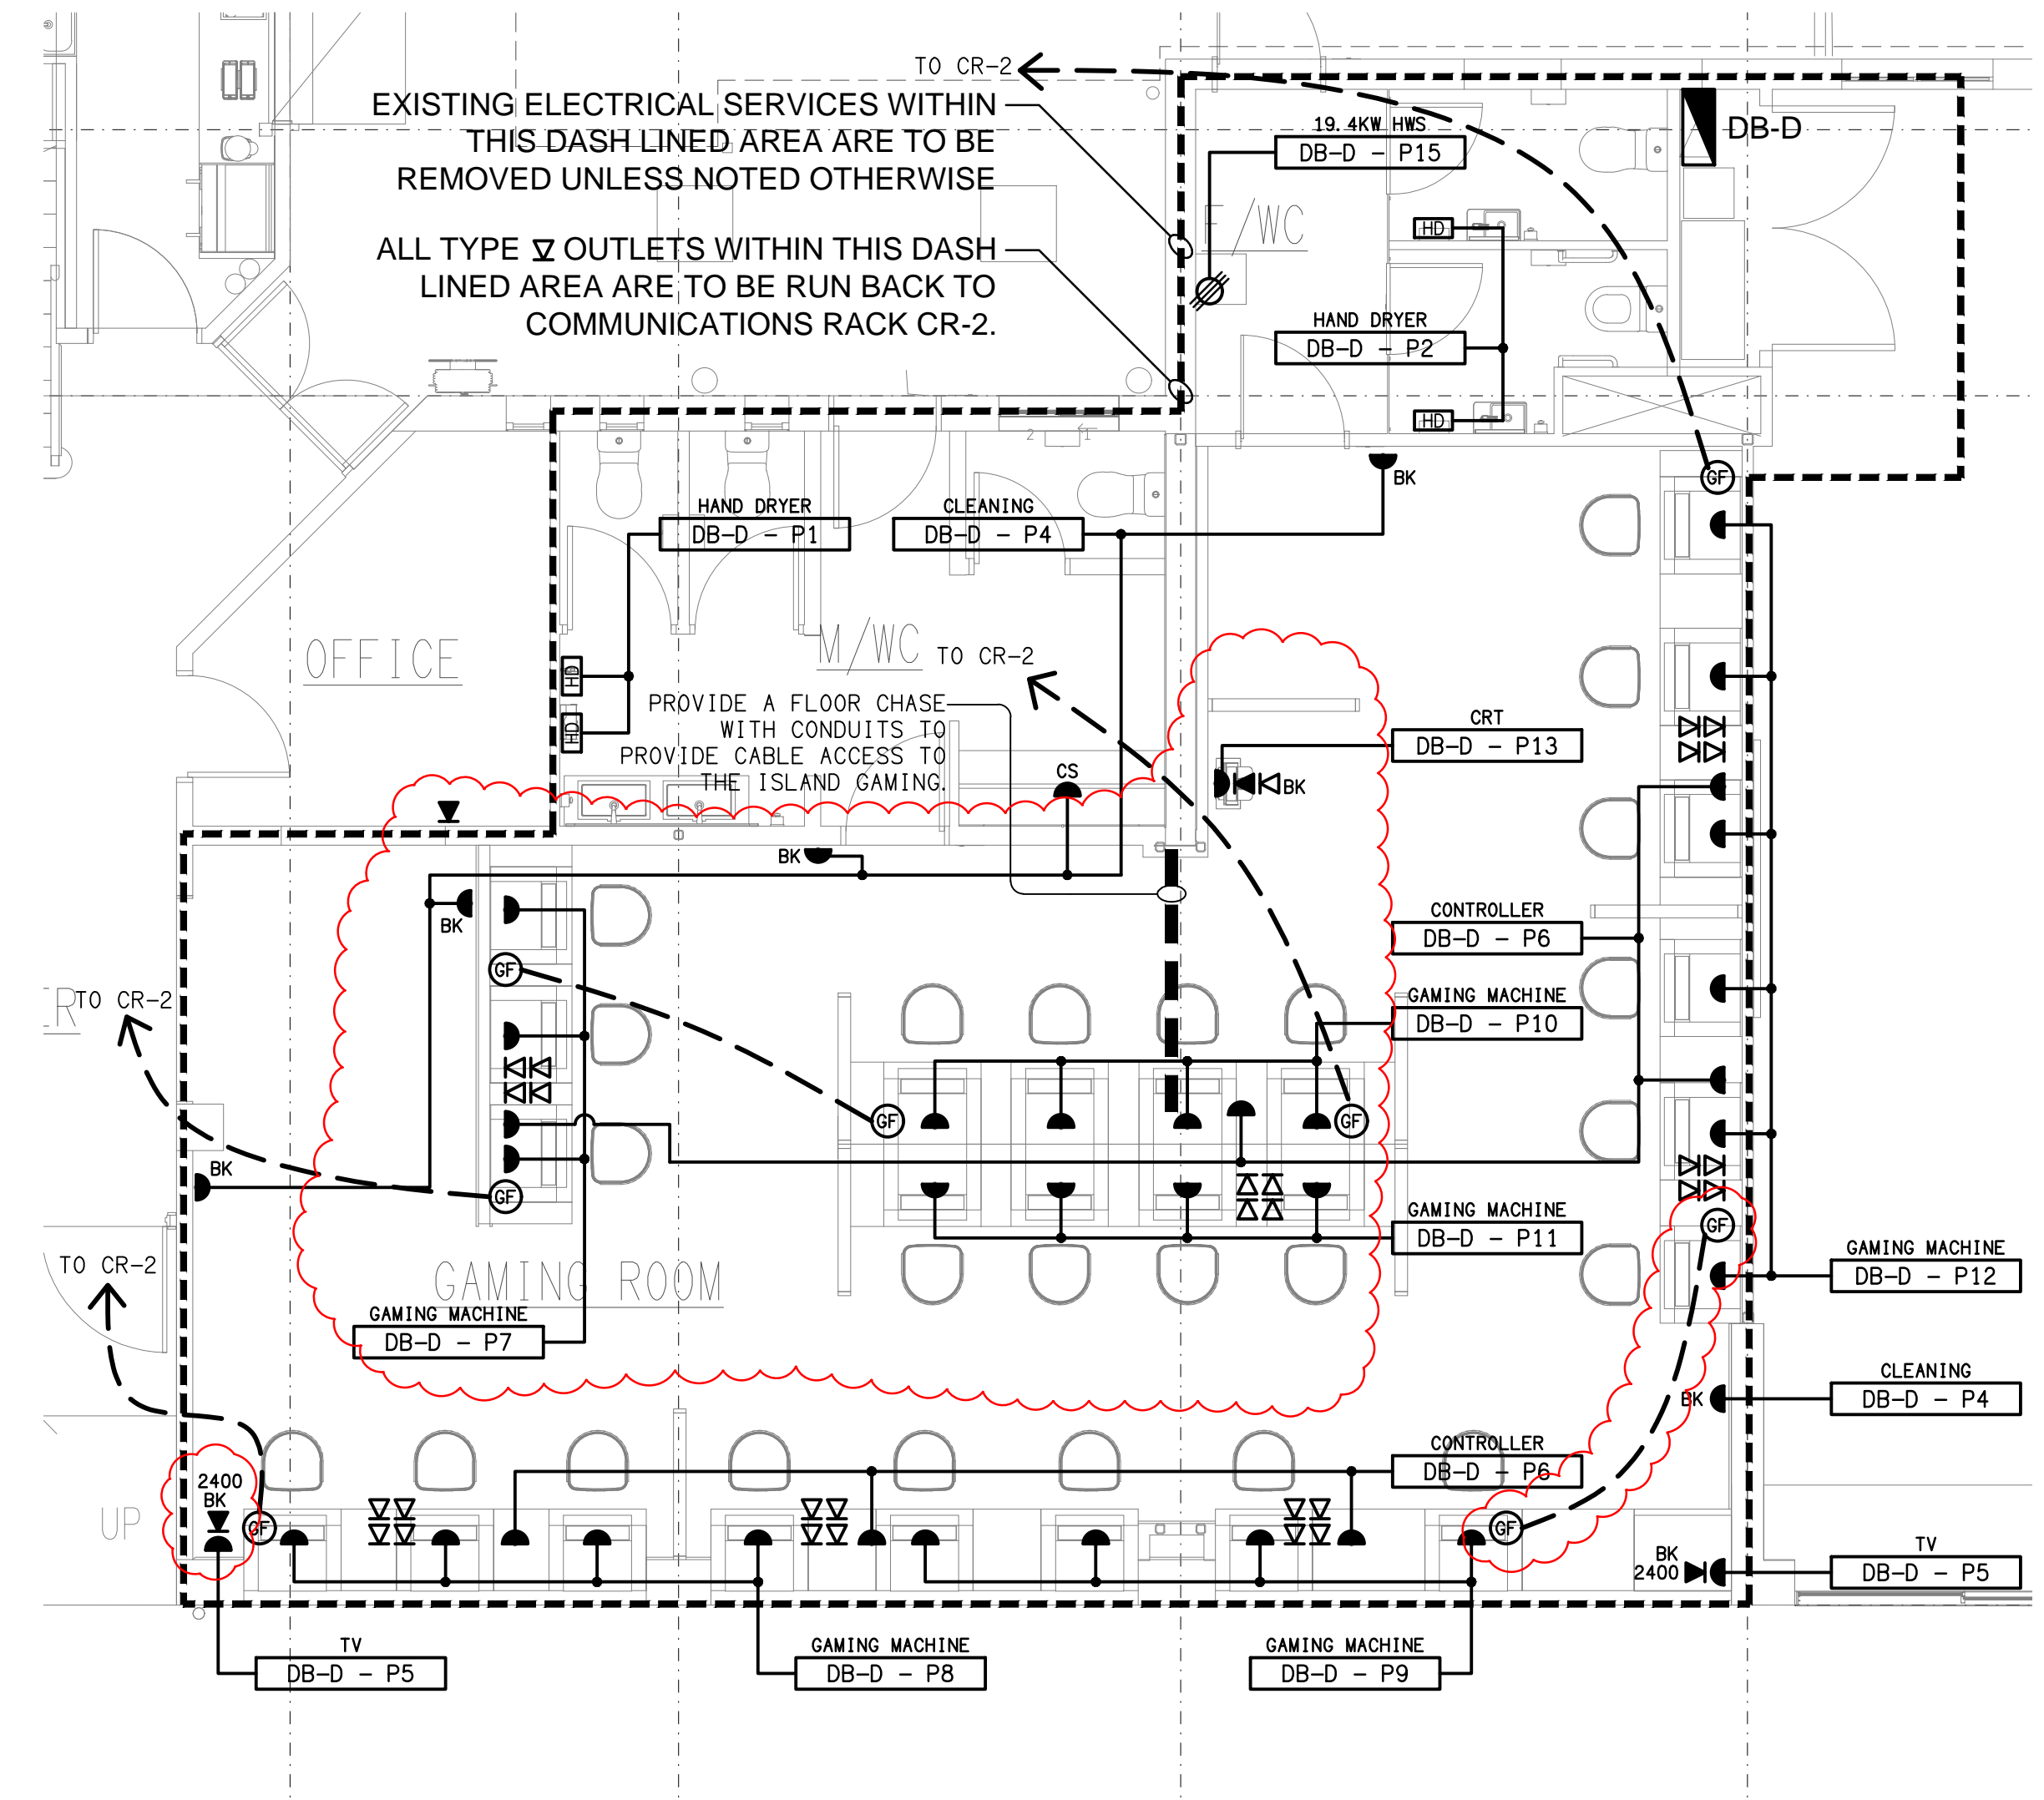

DETAIL B
GAMING ROOM FLOOR PLAN
SCALE 1:50

ELECTRICAL DESIGN GROUP BRISBANE
PTY LTD
ACN 092 710 793
TRADING AS:
ELECTRICAL DESIGN GROUP

THE COPYRIGHT OF THIS DRAWING
REMAINS THE PROPERTY OF THE
ELECTRICAL DESIGN GROUP.
USE FIGURED DIMENSIONS
IN PREFERENCE TO SCALE.
ALL DIMENSIONS TO BE
VERIFIED ONSITE.

ELECTRICAL DESIGN GROUP
ELECTRICAL BUILDING SERVICES CONSULTANTS
BRISBANE GOLD COAST
P.O. Box 15, Sherwood Q.4075
Phone: (07) 3278 4375
Email: brisbane@edg.net.au
Web: www.edg.net.au

PROJECT:
COMMERCIAL HOTEL, KINGAROY - STAGE 1
167-177 HALY STREET, KINGAROY

K	CONSTRUCTION	23/02/2024
REV.	DESCRIPTION:	DATE:

DRAWING:
**ELECTRICAL SERVICES
GROUND LEVEL DETAIL PLANS**
SCALE:
1:50
PROJECT NO:
C2549a
DRAWING NO:
E03
REVISION:
K