
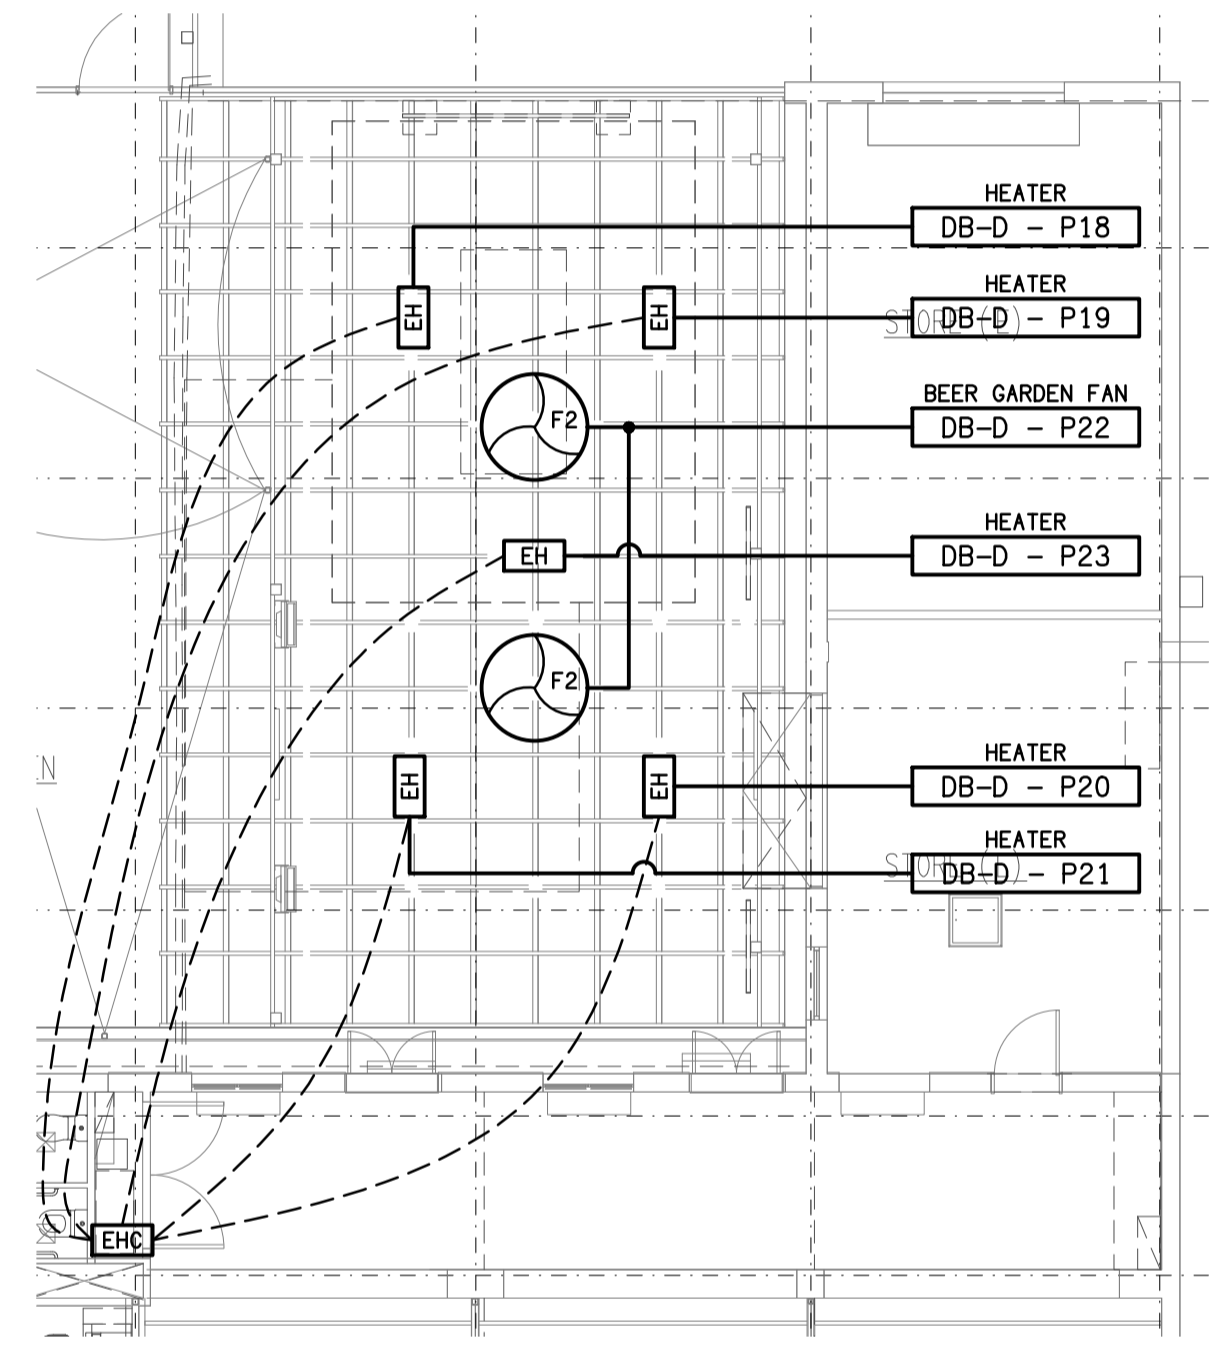


NOTE:
 1. EXISTING ELECTRICAL SERVICES WITHIN THE DASH LINED AREAS ARE TO BE REMOVED UNLESS NOTED OTHERWISE.
 2. ALL ELECTRICAL SERVICES WITHIN THE GAMING ROOM ARE TO BE BLACK IN COLOUR.

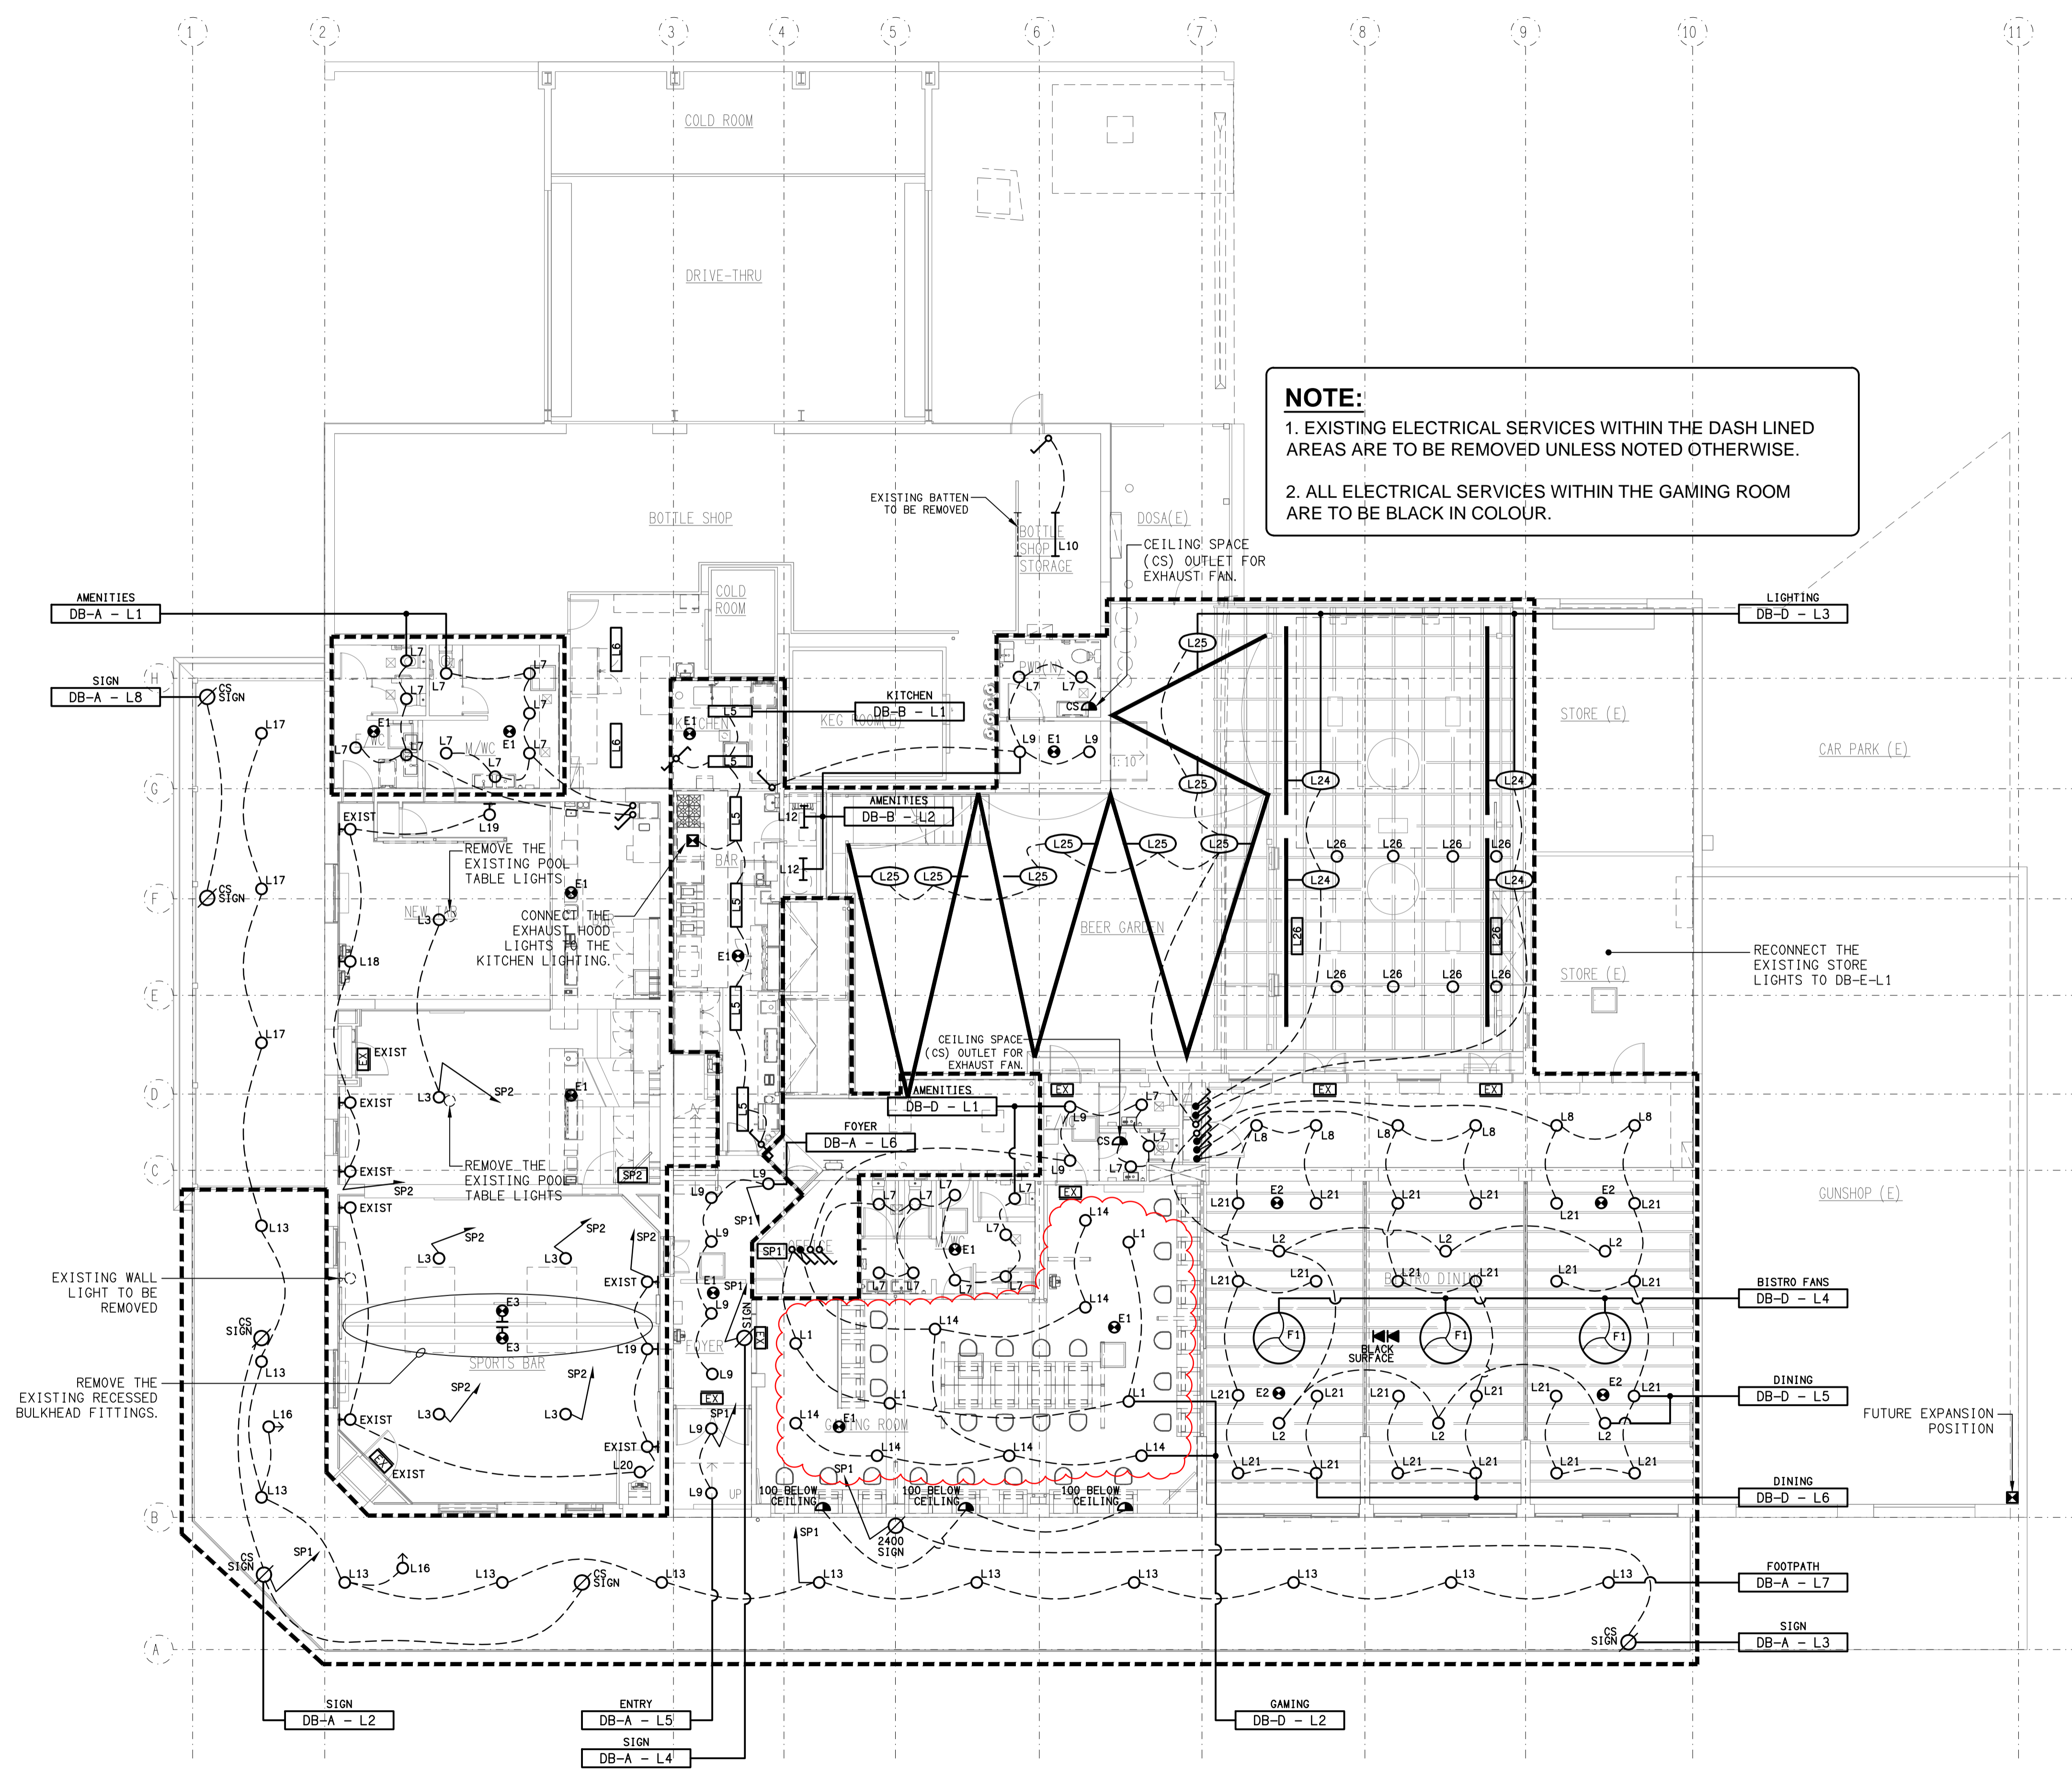

DETAIL
 BEER GARDEN FANS & HEATERS
 SCALE 1:100

ELECTRICAL DESIGN GROUP BRISBANE
 PTY LTD
 ACN 092 710 793
 TRADING AS:
 ELECTRICAL DESIGN GROUP

THE COPYRIGHT OF THIS DRAWING
 REMAINS THE PROPERTY OF THE
 ELECTRICAL DESIGN GROUP.
 USE FIGURED DIMENSIONS
 IN PREFERENCE TO SCALE.
 ALL DIMENSIONS TO BE
 VERIFIED ONSITE.

ELECTRICAL DESIGN GROUP
 ELECTRICAL BUILDING SERVICES CONSULTANTS
 BRISBANE GOLD COAST
 P.O. Box 15, Sherwood Q.4075
 Phone: (07) 3278 4375
 Email: brisbane@edg.net.au
 Web: www.edg.net.au

PROJECT:
COMMERCIAL HOTEL, KINGAROY - STAGE 1
 167-177 HALY STREET, KINGAROY

M	CONSTRUCTION	26/02/2023
REV:	DESCRIPTION:	DATE:
DRAWING: ELECTRICAL SERVICES GROUND LEVEL REFLECTED CEILING PLAN		
SCALE: 1:100	PROJECT NO: C2549a	DRAWING NO: E04
AT A1	REVISION: M	