

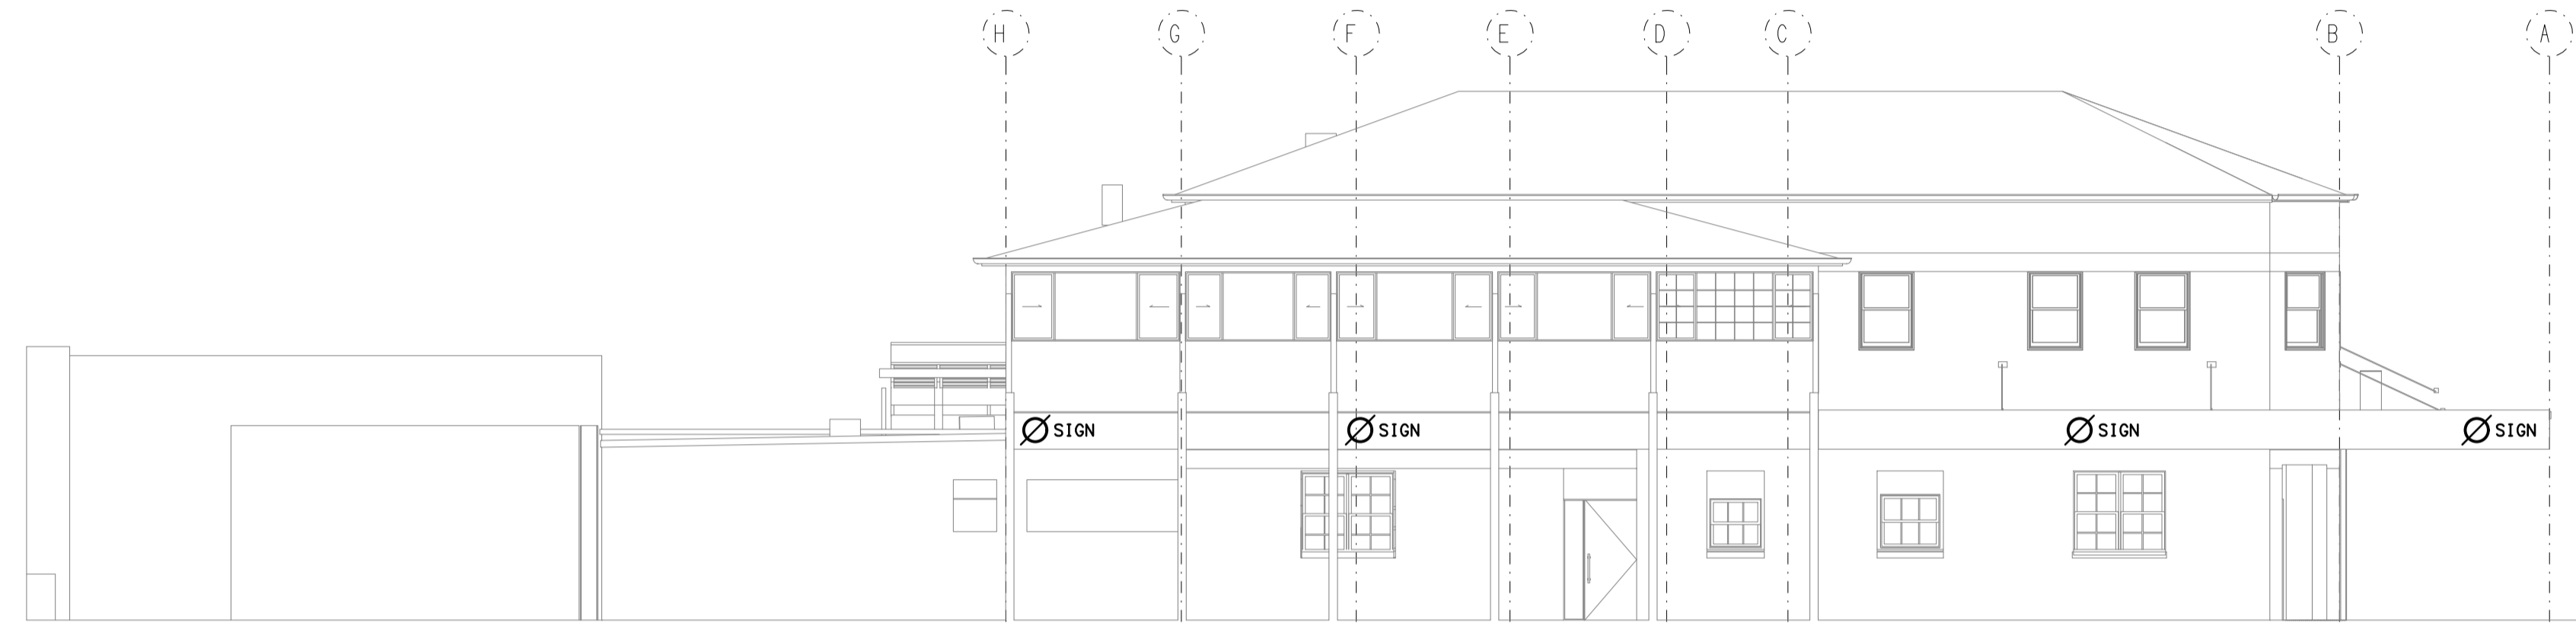
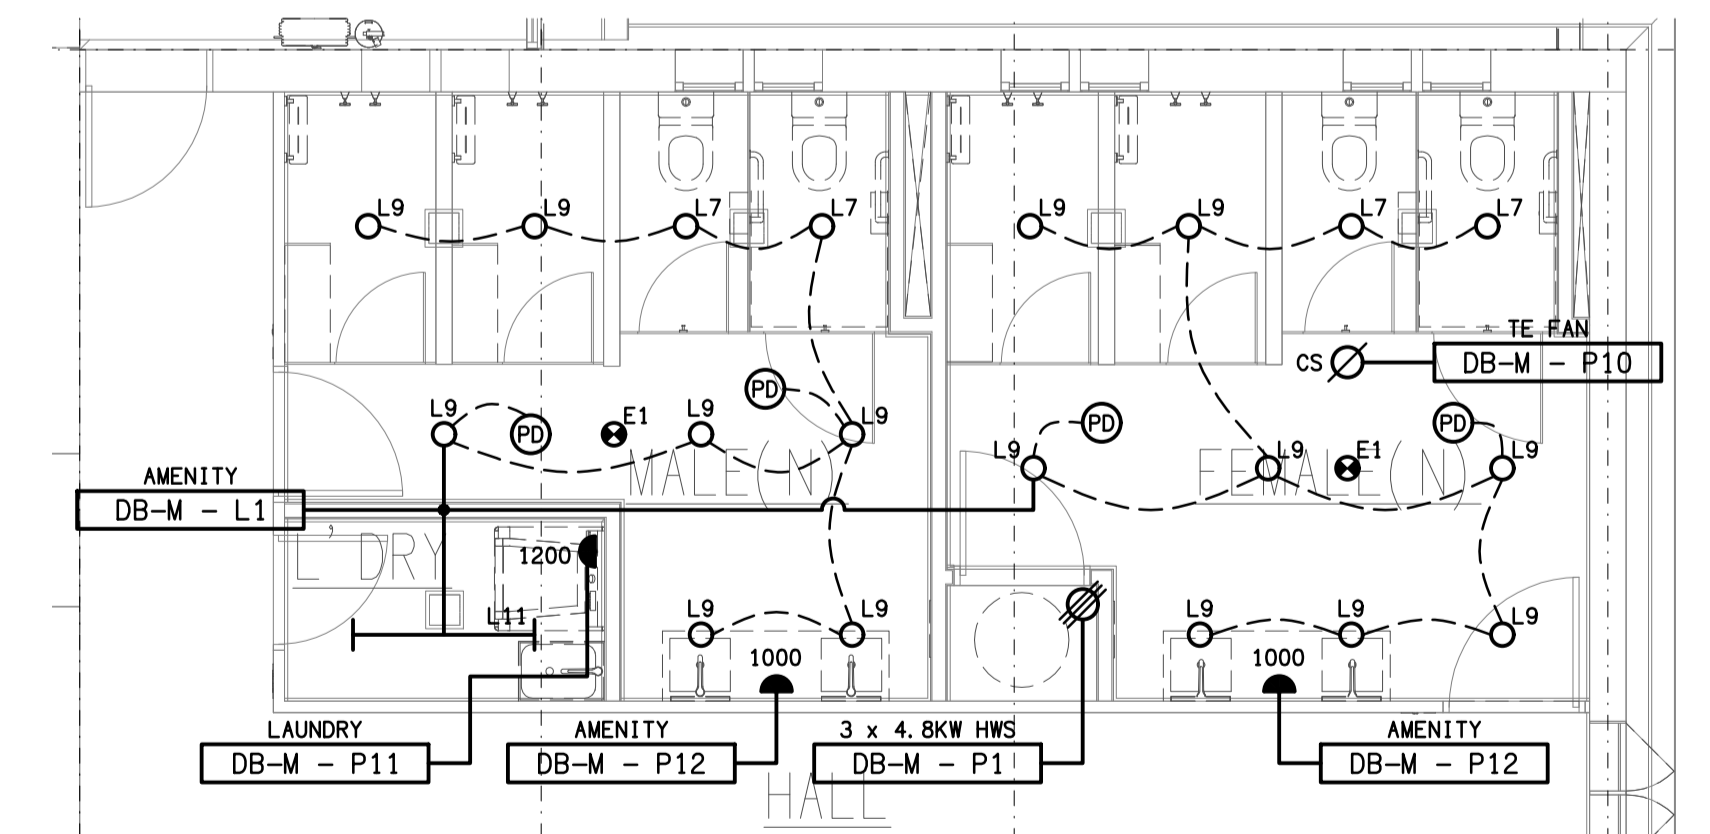


**NORTH ELEVATION**  
EXTERNAL BUILDING  
SCALE 1:100

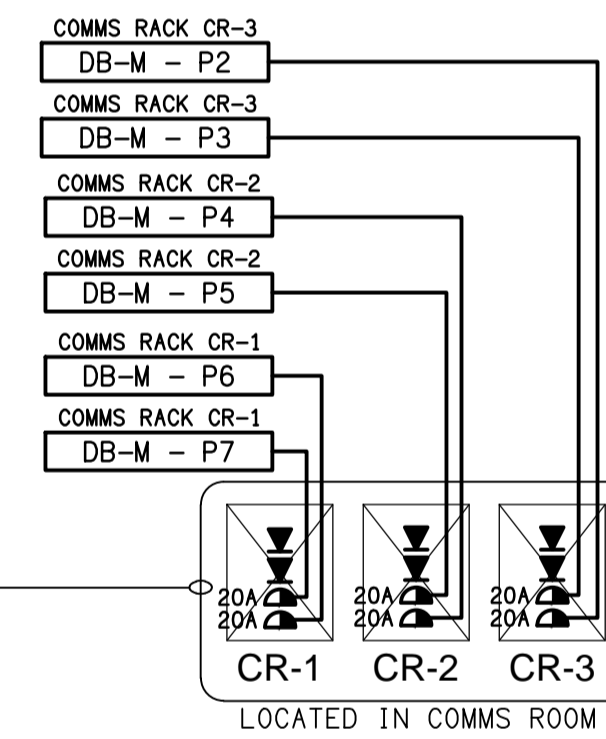

**EAST ELEVATION**  
EXTERNAL BUILDING  
SCALE 1:100

**NOTE:**  
FOR COORDINATION THE AWNING SIGNAGE  
OUTLETS ARE DETAILED AND CIRCUITED ON  
THE REFLECTED CEILING PLAN.

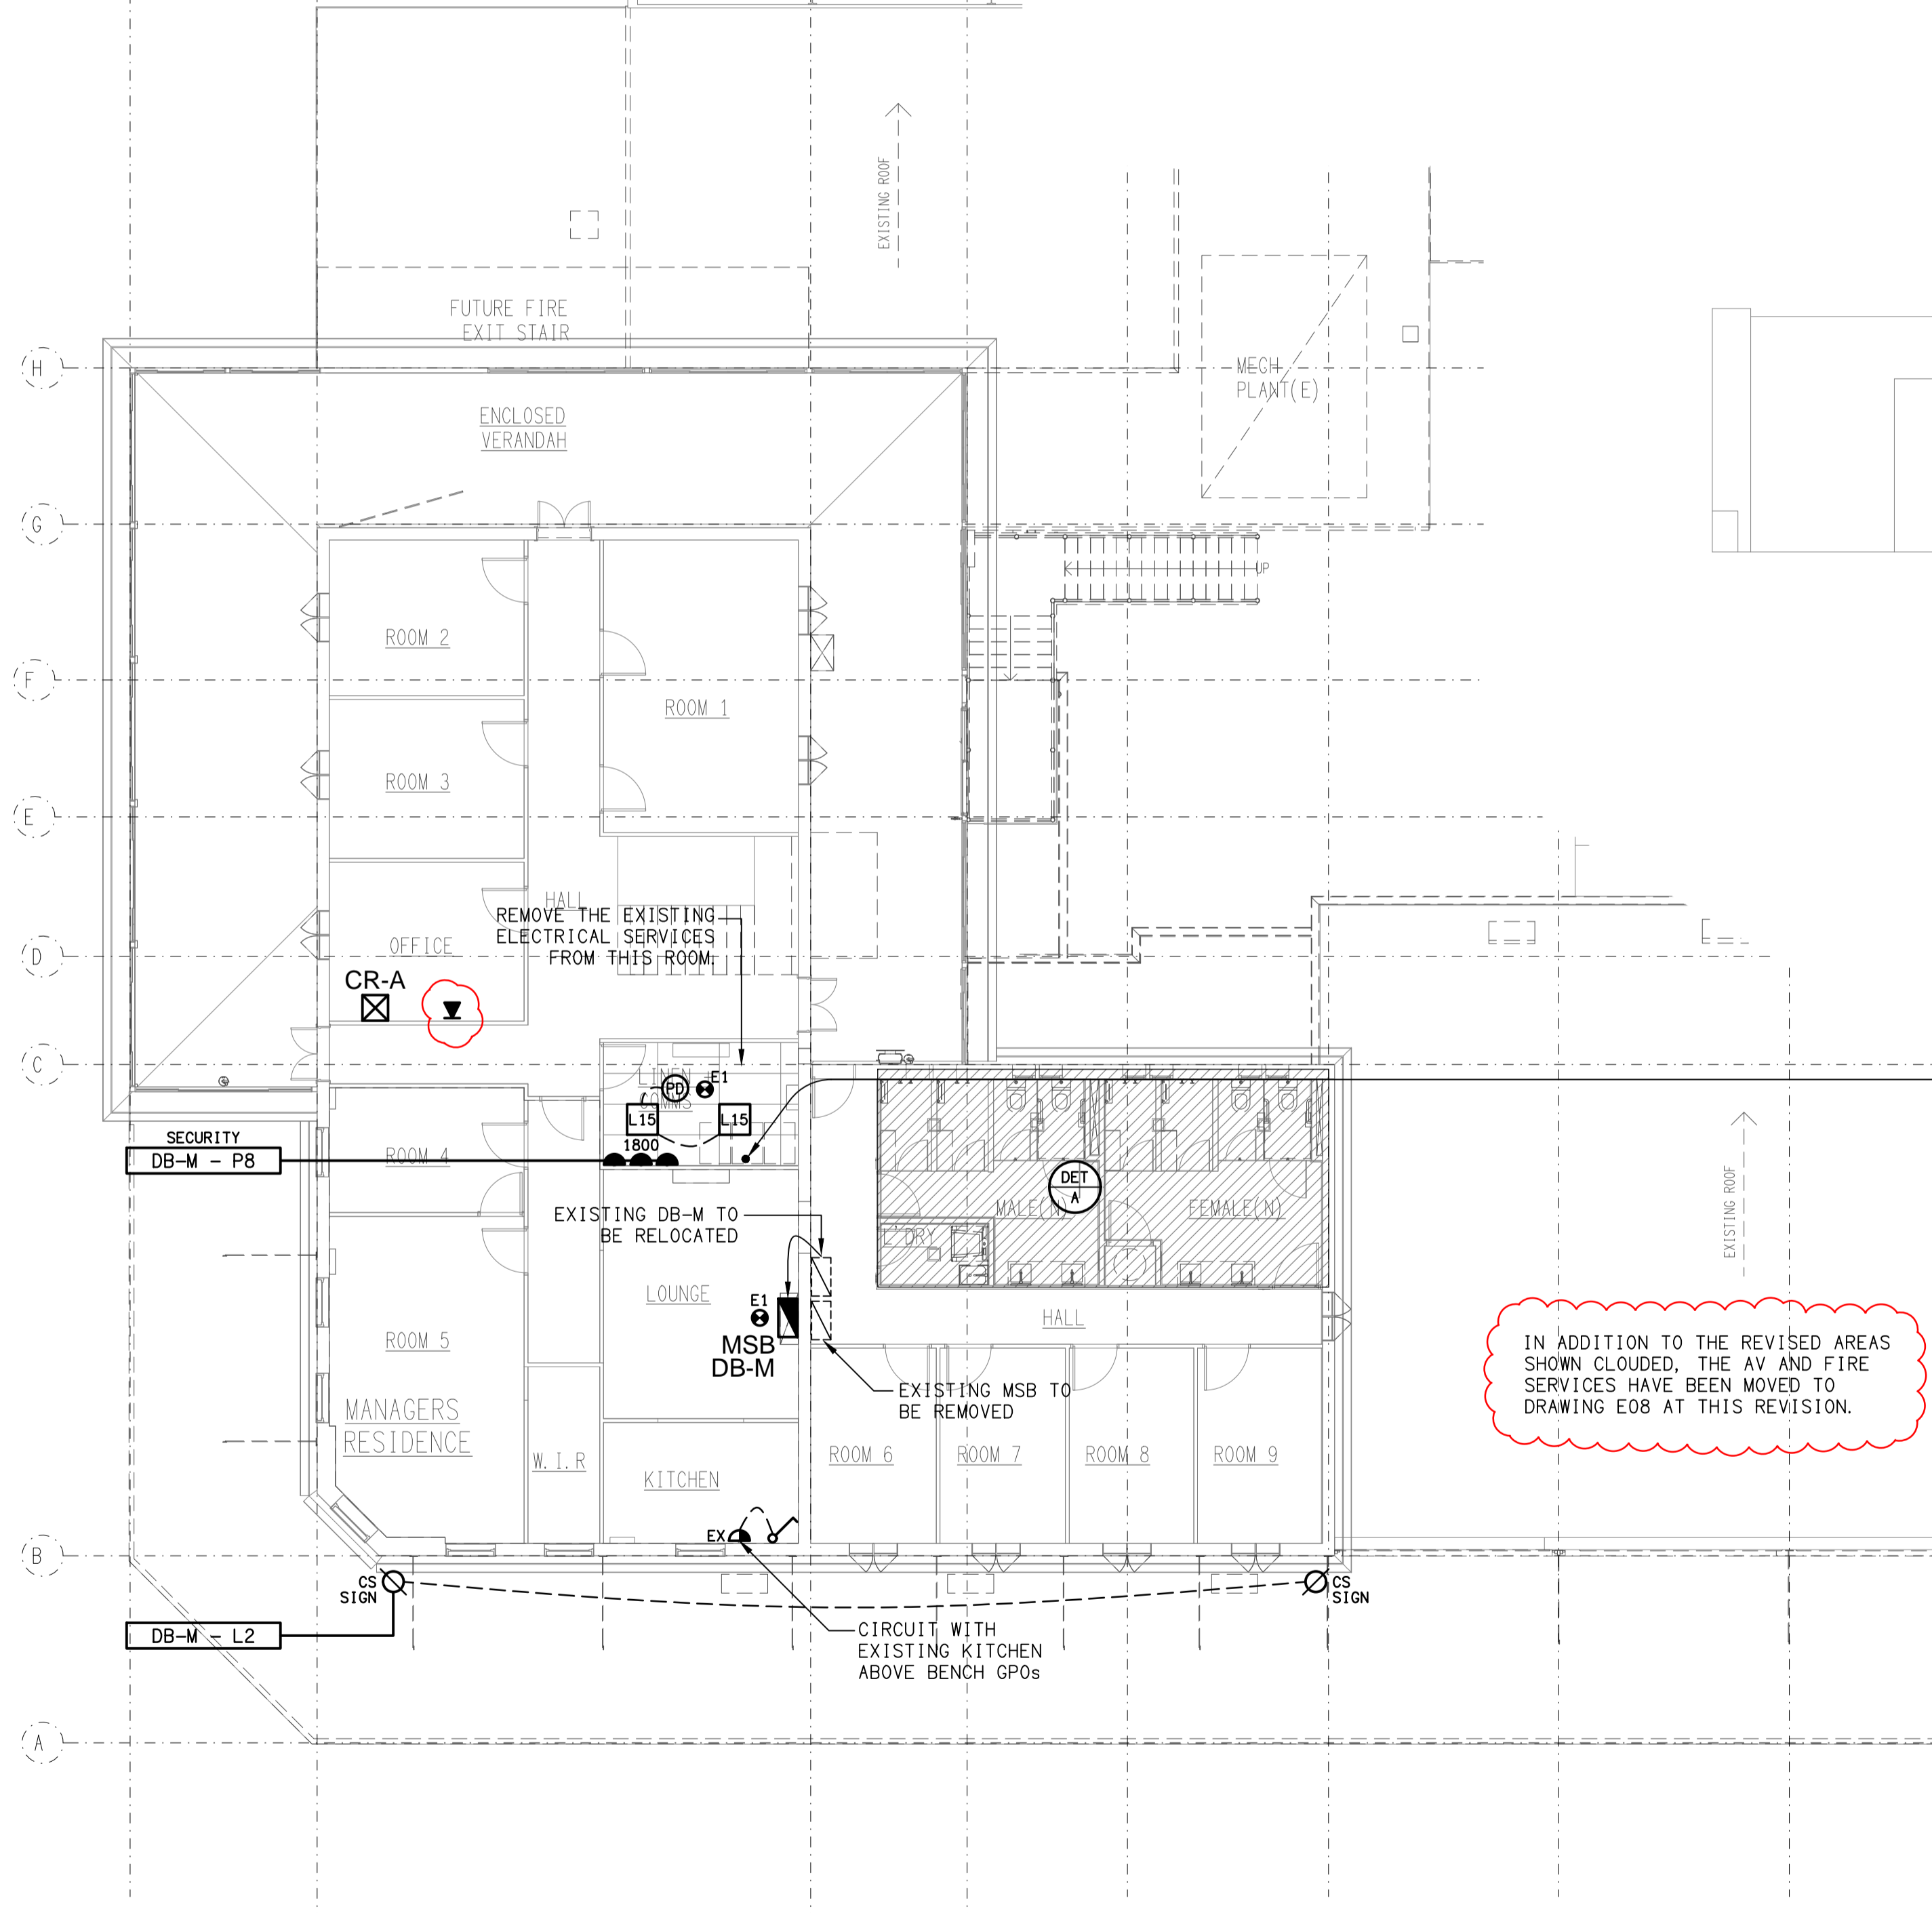

**DETAIL A**  
AMENITIES FLOOR / CEILING PLAN  
SCALE 1:50

ELECTRICAL DESIGN GROUP BRISBANE  
PTY LTD  
ACN 092 710 793  
TRADING AS:  
ELECTRICAL DESIGN GROUP

THE COPYRIGHT OF THIS DRAWING  
REMAINS THE PROPERTY OF THE  
ELECTRICAL DESIGN GROUP.  
USE FIGURED DIMENSIONS  
IN PREFERENCE TO SCALE.  
ALL DIMENSIONS TO BE  
VERIFIED ONSITE.

**ELECTRICAL DESIGN GROUP**  
ELECTRICAL BUILDING SERVICES CONSULTANTS  
BRISBANE GOLD COAST

P.O. Box 15, Sherwood Q.4075  
Phone: (07) 3278 4375  
Email: brisbane@edg.net.au  
Web: www.edg.net.au

PROJECT:  
**COMMERCIAL HOTEL, KINGAROY - STAGE 1**

167-177 HALY STREET, KINGAROY

J	CONSTRUCTION	20/12/2023
REV:	DESCRIPTION:	DATE:

DRAWING:  
**ELECTRICAL SERVICES**  
LEVEL 1 FLOOR / REFLECTED CEILING PLAN

SCALE:  
1:100 AT A1 PROJECT NO:  
**C2549a** DRAWING NO:  
**E05** REVISION:  
**J**