


**EXISTING ELECTRICAL SERVICES
WITHIN THIS DASH LINED AREA
ARE TO REMAIN AS IS UNLESS
NOTED OTHERWISE.**

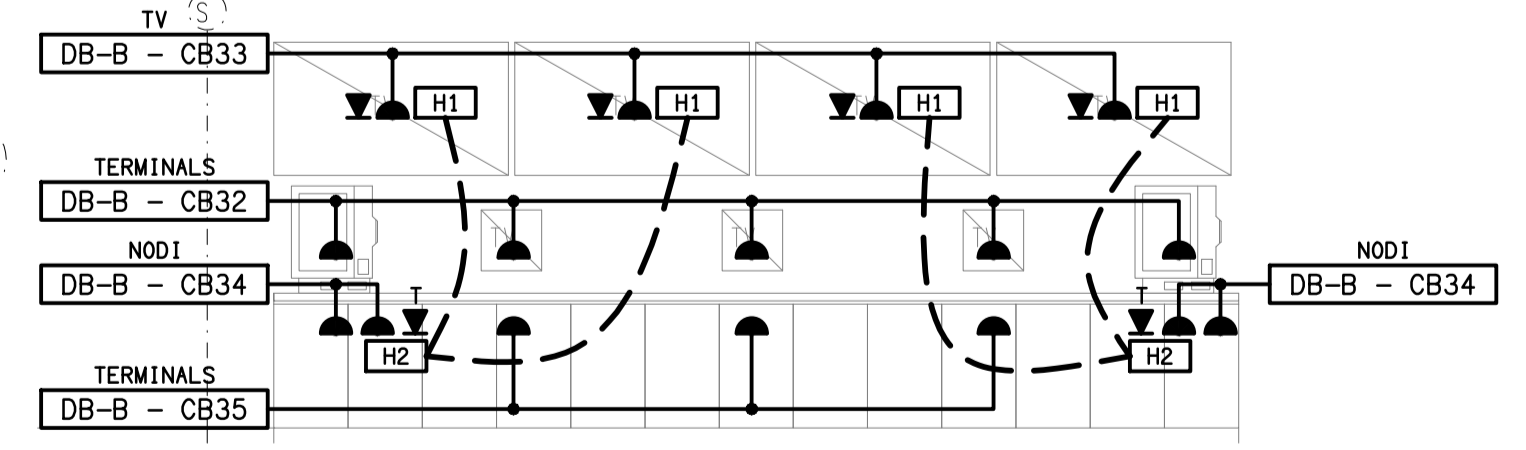

DETAIL A
TAB WALL ELEVATION
SCALE 1:50

ELECTRICAL DESIGN GROUP BRISBANE
PTY LTD
ACN 092 710 793
TRADING AS:
ELECTRICAL DESIGN GROUP

THE COPYRIGHT OF THIS DRAWING
REMAINS THE PROPERTY OF THE
ELECTRICAL DESIGN GROUP.
USE FIGURED DIMENSIONS
IN PREFERENCE TO SCALE.
ALL DIMENSIONS TO BE
VERIFIED ONSITE.

WFM Electrical Services
QLD Elec Contractors Lic: 8068
NSW Elec Contractors Lic: 261033C
ABN: 30 010 891 068
Phone | 07 3274 2558
4/29 Hugo Place, Mansfield QLD 4122
www.wfmelectrical.com.au

ELECTRICAL DESIGN GROUP
ELECTRICAL BUILDING SERVICES CONSULTANTS
BRISBANE GOLD COAST
P.O. Box 15, Sherwood Q.4075
Phone: (07) 3278 4375
Email: brisbane@edg.net.au
Web: www.edg.net.au

PROJECT:
THE BELVEDERE HOTEL
26 OXLEY AVENUE, WOODY POINT, QUEENSLAND.

E	AS CONSTRUCTED	24/10/2023
REV:	DESCRIPTION:	DATE:
DRAWING: ELECTRICAL SERVICES GROUND LEVEL FLOOR PLAN		
SCALE: 1:100	PROJECT NO: C2559a	DRAWING NO: E03
AT A1	REVISION: E	