


EXISTING ELECTRICAL SERVICES WITHIN THIS DASH LINED AREA ARE TO REMAIN AS IS UNLESS NOTED OTHERWISE.

THE EXISTING ELECTRICAL SERVICES WITHIN THIS SHADED AREA THAT ARE AFFECTED BY THE WORKS WERE REINSTATED WITH NEW CONTROLS / CONNECTIONS AS REQUIRED.

NOTE:
REFER TO DRAWING C2559a-E06.dwg FOR THE ADDITIONAL GROUND LEVEL AND JOINERY LIGHTING PLAN.

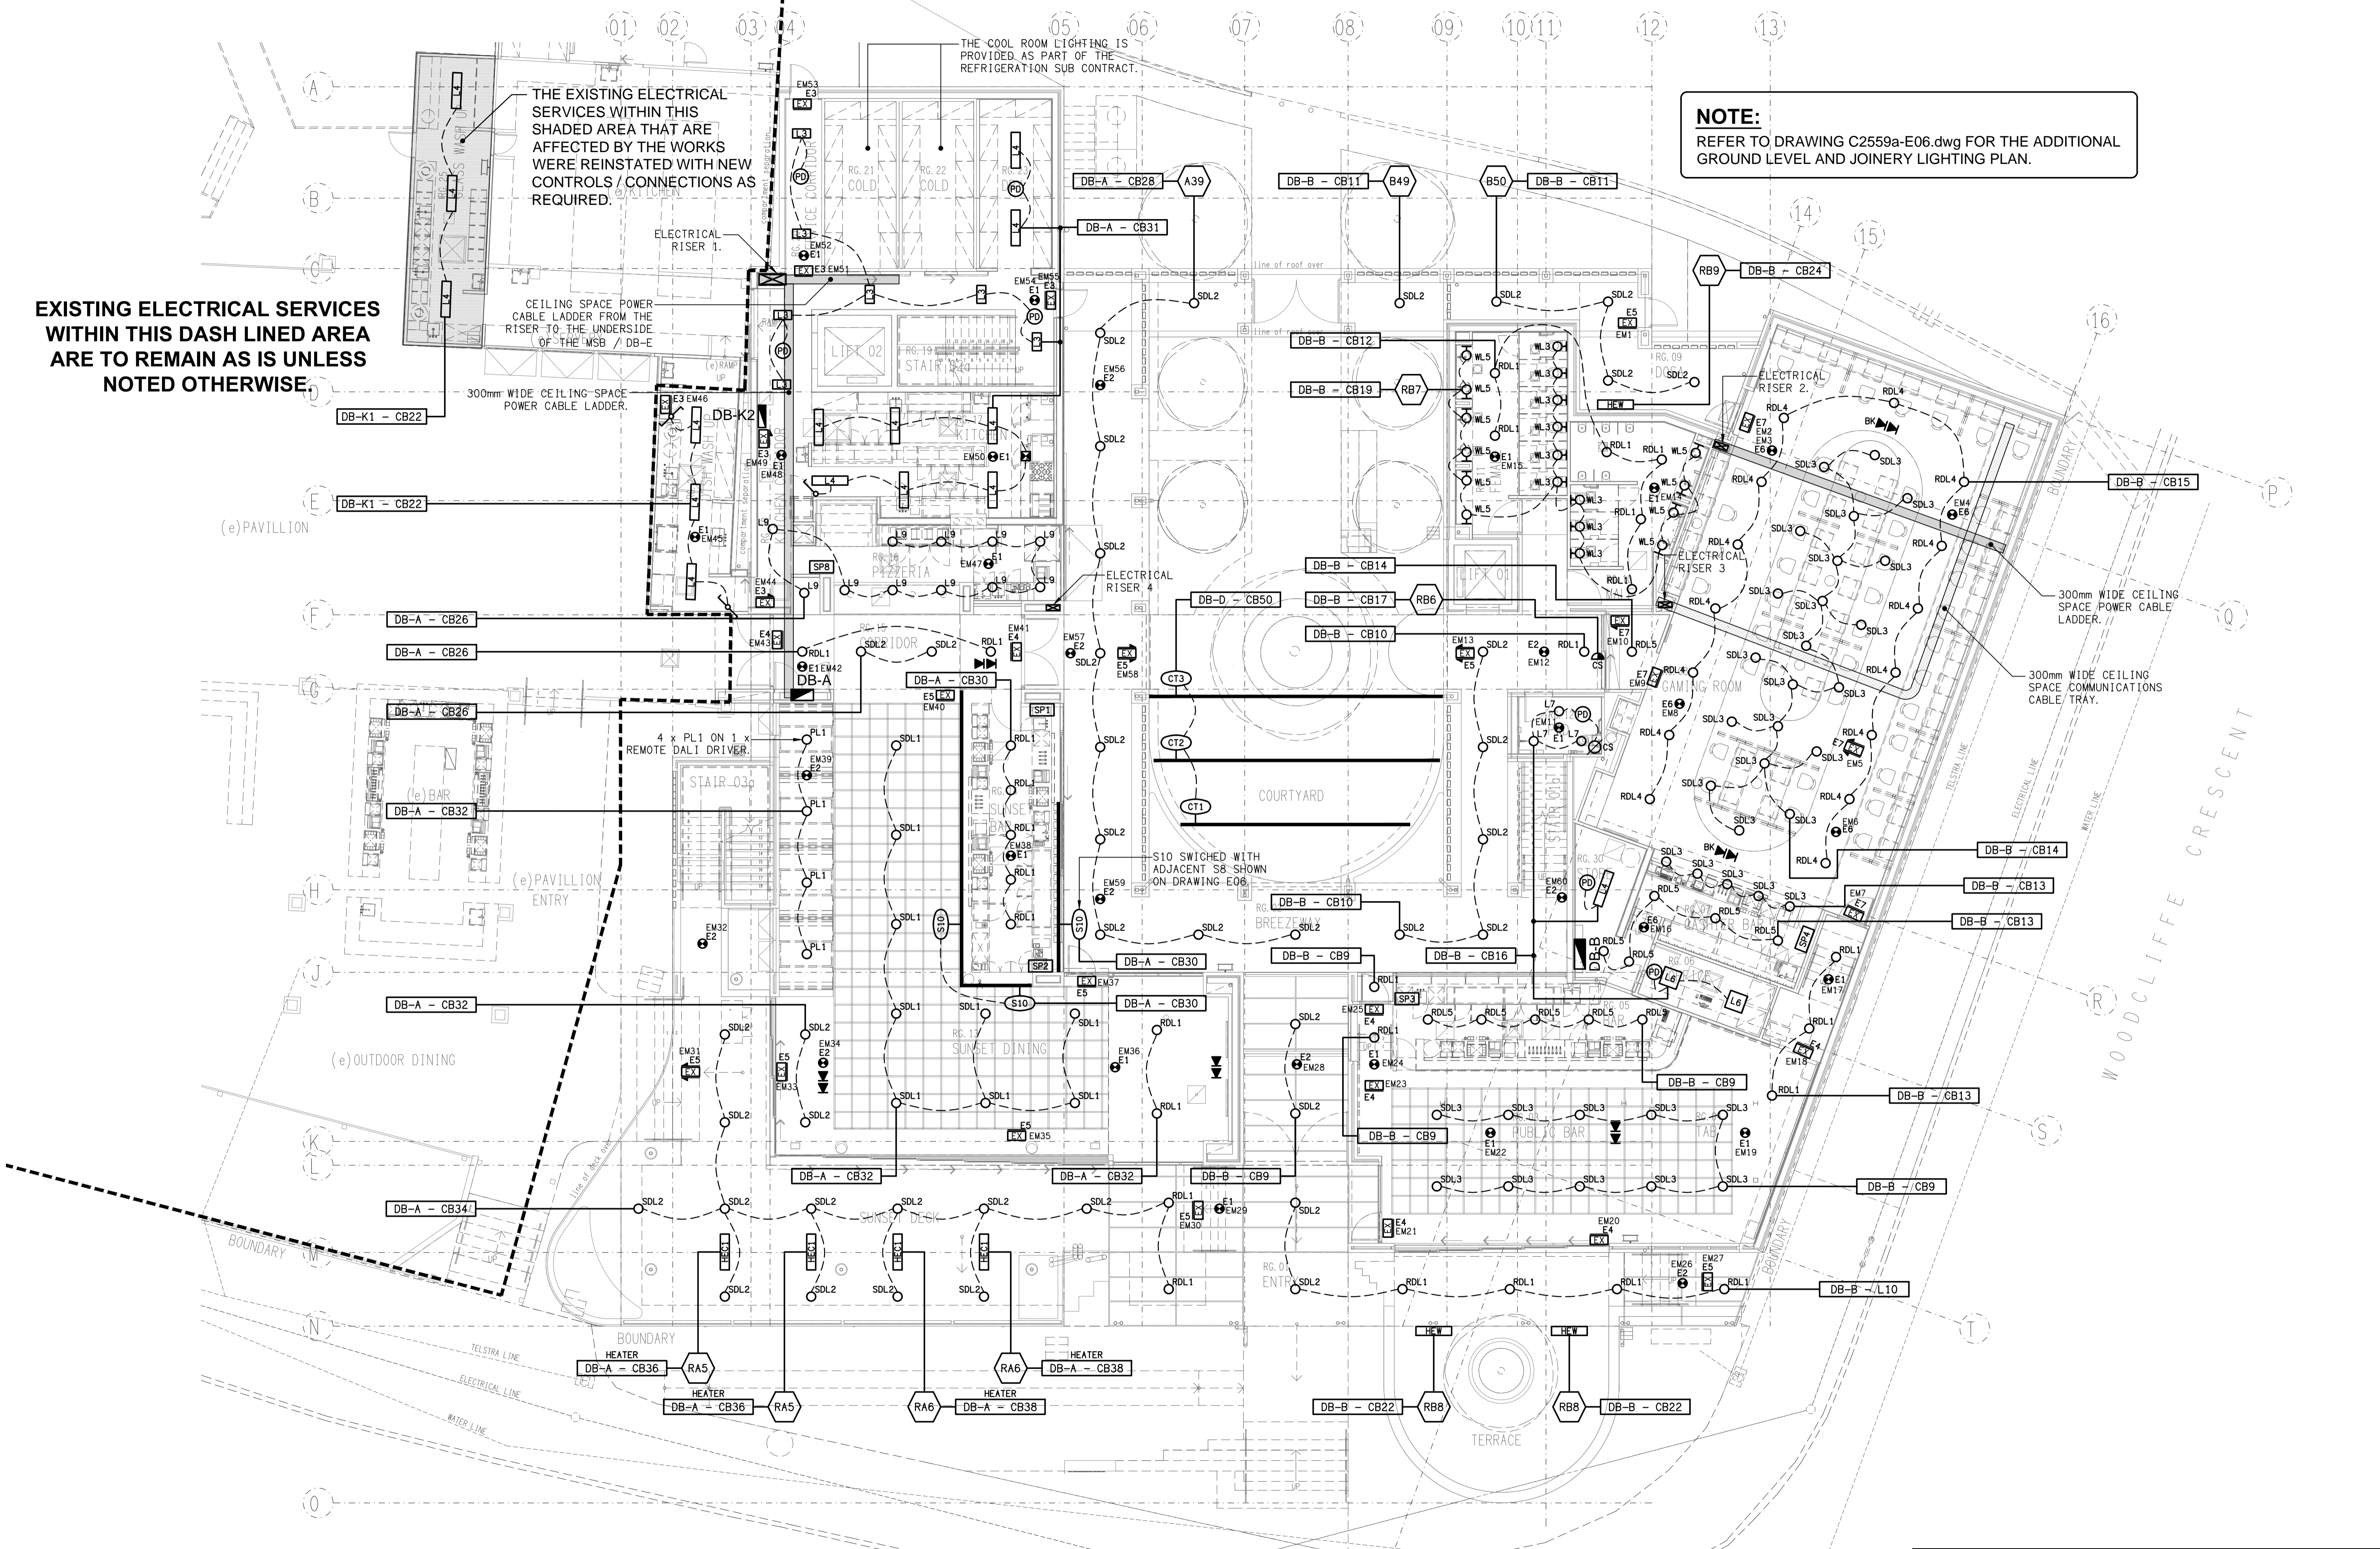

ELECTRICAL DESIGN GROUP BRISBANE
PTY LTD
ACN 092 710 793
TRADING AS:
ELECTRICAL DESIGN GROUP

THE COPYRIGHT OF THIS DRAWING REMAINS THE PROPERTY OF THE ELECTRICAL DESIGN GROUP.
USE FIGURED DIMENSIONS IN PREFERENCE TO SCALE.
ALL DIMENSIONS TO BE VERIFIED ONSITE.

WFM Electrical Services
QLD Elec Contractors Lic: 8068
NSW Elec Contractors Lic: 261933C
ABN: 30 010 891 068
Phone | 07 3274 2558
4/29 Hugo Place, Mansfield QLD 4122
www.wfmelectrical.com.au

ELECTRICAL DESIGN GROUP
ELECTRICAL BUILDING SERVICES CONSULTANTS
BRISBANE GOLD COAST
P.O. Box 15, Sherwood Q. 4075
Phone: (07) 3278 4375
Email: brisbane@edg.net.au
Web: www.edg.net.au

PROJECT:
THE BELVEDERE HOTEL
26 OXLEY AVENUE, WOODY POINT, QUEENSLAND.

F	AS CONSTRUCTED	24/10/2023
REV:	DESCRIPTION:	DATE:
DRAWING: ELECTRICAL SERVICES GROUND LEVEL REFLECTED CEILING PLAN		
SCALE: 1:100	PROJECT NO: C2559a	DRAWING NO: E05
AT A1	REVISION: F	