


(e) PAVILLION
**EXISTING ELECTRICAL SERVICES
 WITHIN THIS DASH LINED AREA
 ARE TO REMAIN AS IS UNLESS
 NOTED OTHERWISE.**

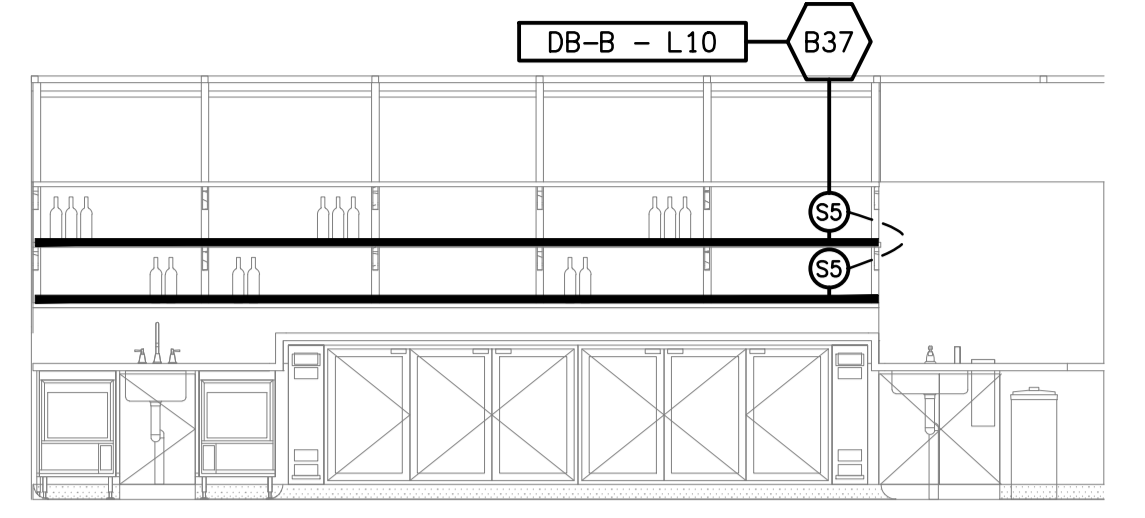

DETAIL A
 PUBLIC BAR REAR SHELVING ELEVATION
 SCALE 1:50

ELECTRICAL DESIGN GROUP BRISBANE
 PTY LTD
 ACN 092 710 793
 TRADING AS:
 ELECTRICAL DESIGN GROUP

THE COPYRIGHT OF THIS DRAWING
 REMAINS THE PROPERTY OF THE
 ELECTRICAL DESIGN GROUP.
 USE FIGURED DIMENSIONS
 IN PREFERENCE TO SCALE.
 ALL DIMENSIONS TO BE
 VERIFIED ONSITE.

ELECTRICAL DESIGN GROUP
 ELECTRICAL BUILDING SERVICES CONSULTANTS
 BRISBANE GOLD COAST

P.O. Box 15, Sherwood Q. 4075
 Phone: (07) 3278 4375
 Email: brisbane@edg.net.au
 Web: www.edg.net.au

PROJECT:
THE BELVEDERE HOTEL

26 OXLEY AVENUE, WOODY POINT, QUEENSLAND.

D	CONSTRUCTION	05/09/2022
REV.	DESCRIPTION:	DATE:

DRAWING:
**ELECTRICAL SERVICES
 GROUND LOW LEVEL LIGHTING PLAN**

SCALE: 1:100	AT A1	PROJECT NO: C2559a	DRAWING NO: E06	REVISION: D
-----------------	-------	------------------------------	---------------------------	-----------------------