


DETAIL A
GLASS WASH UP LAYOUT
SCALE 1:50

DETAIL B
ROOF TOP BAR LAYOUT
SCALE 1:50

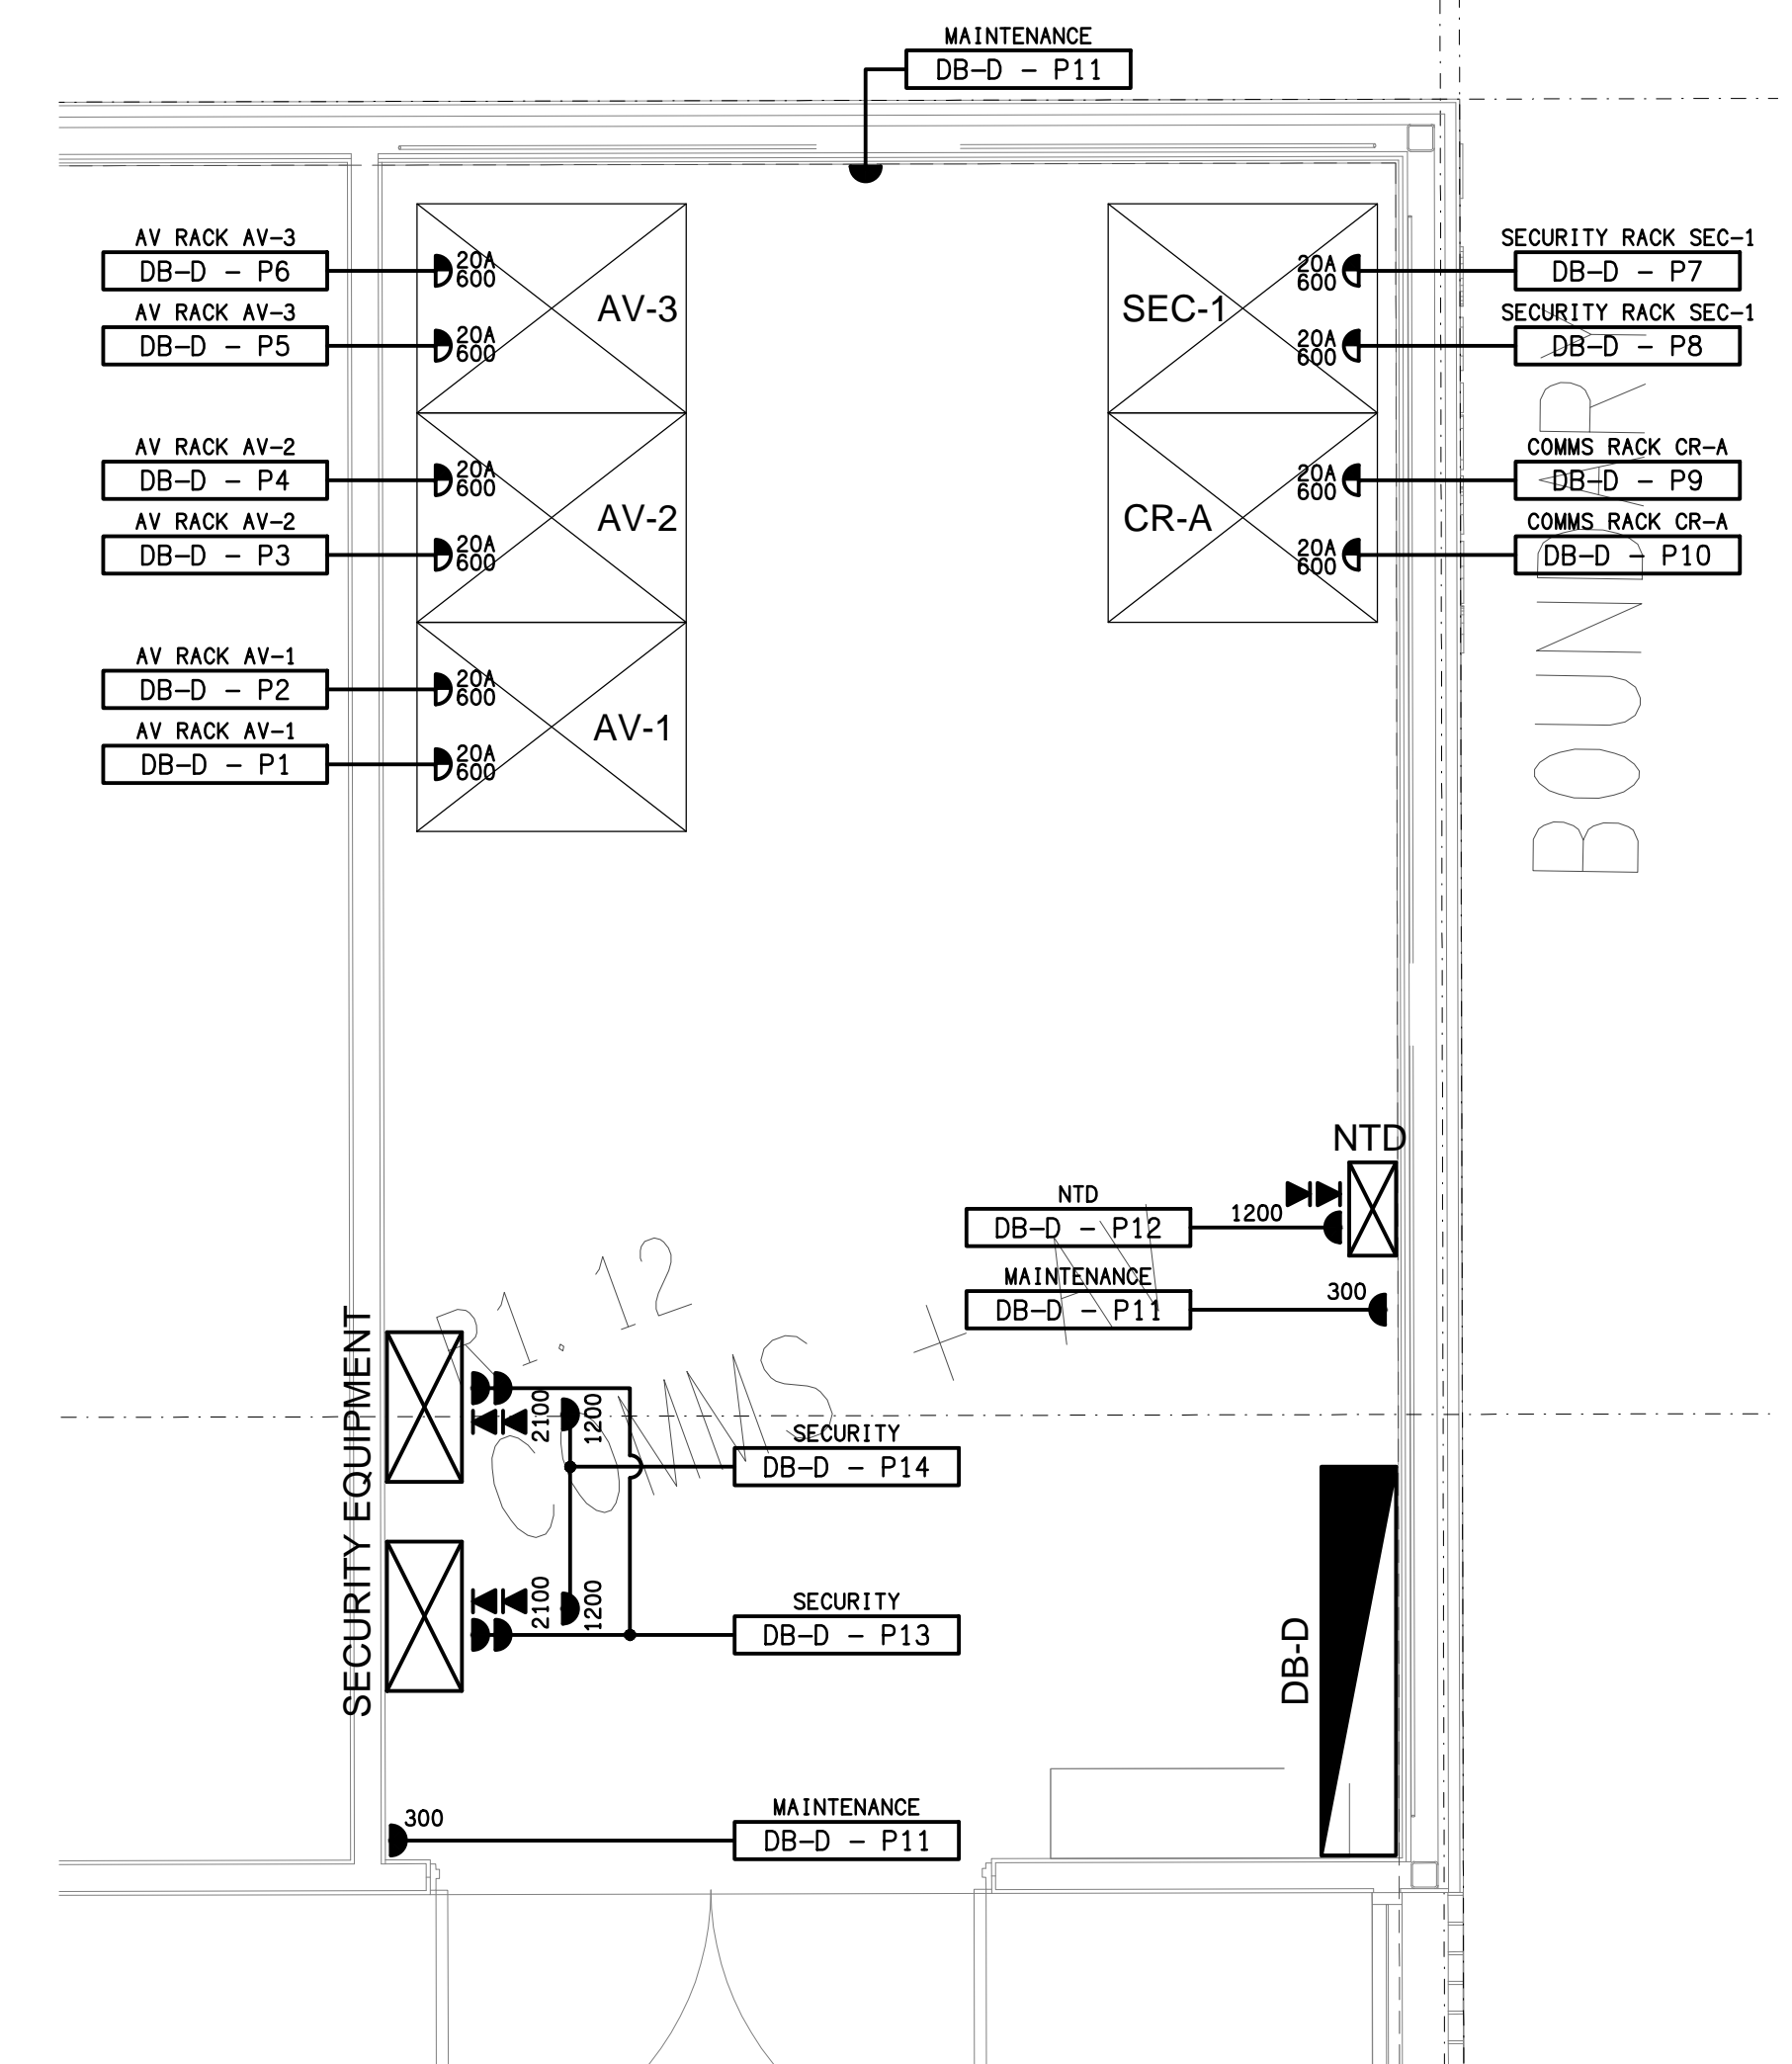

DETAIL C
COMMUNICATIONS / AV LAYOUT
SCALE 1:25

ELECTRICAL DESIGN GROUP BRISBANE
PTY LTD
ACN 092 710 793
TRADING AS:
ELECTRICAL DESIGN GROUP

THE COPYRIGHT OF THIS DRAWING
REMAINS THE PROPERTY OF THE
ELECTRICAL DESIGN GROUP.
USE FIGURED DIMENSIONS
IN PREFERENCE TO SCALE.
ALL DIMENSIONS TO BE
VERIFIED ONSITE.

ELECTRICAL DESIGN GROUP
ELECTRICAL BUILDING SERVICES CONSULTANTS
BRISBANE GOLD COAST

P.O. Box 15, Sherwood Q.4075
Phone: (07) 3278 4375
Email: brisbane@edg.net.au
Web: www.edg.net.au

PROJECT:
THE BELVEDERE HOTEL

26 OXLEY AVENUE, WOODY POINT, QUEENSLAND.

D	CONSTRUCTION	05/09/2022
REV:	DESCRIPTION:	DATE:

DRAWING:
**ELECTRICAL SERVICES
LEVEL 1 FLOOR PLAN**

SCALE:
1:100 AT A1
PROJECT NO:
C2559a
DRAWING NO:
E07
REVISION:
D