


**WELFARE OFFICE.
REFER DETAIL A.**

**CAFE, KITCHEN & BAR ON
DRAWINGS E03 & E04.**


**SPORTS BAR
ON DRAWINGS
E05 & E06**

**MEMORIAL GARDEN ON
DRAWING E08**

SITE PLAN
EXTENT OF WORKS
SCALE 1:200

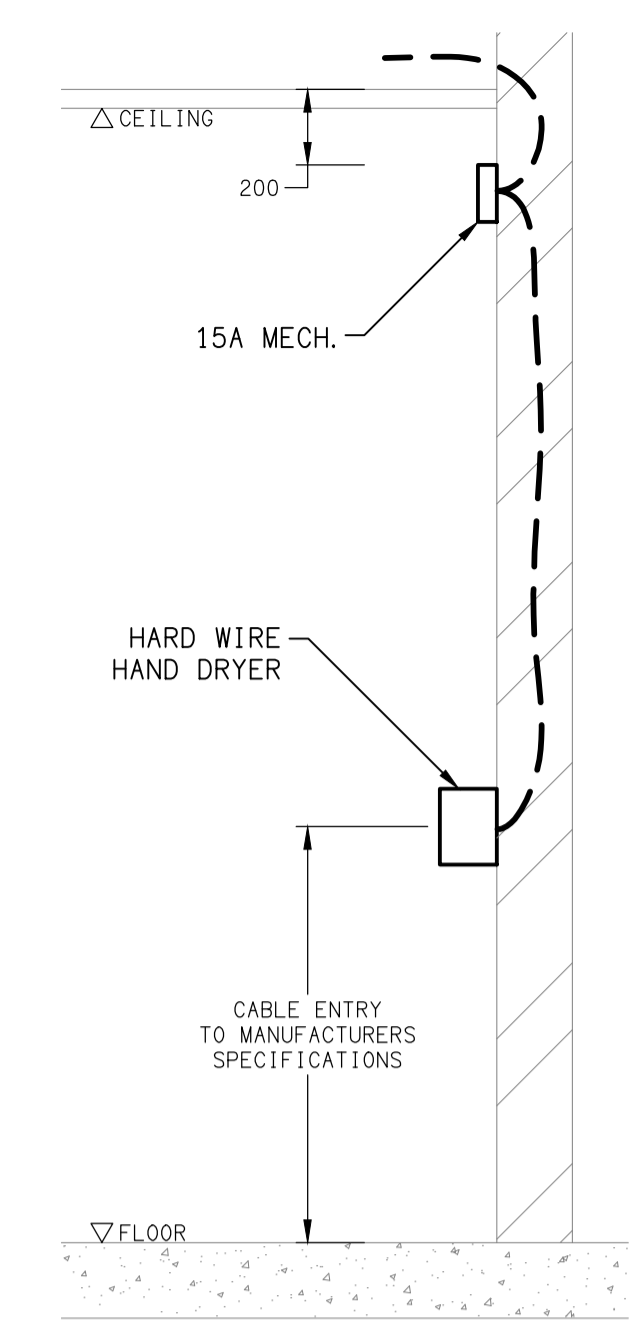


DETAIL
HAND DRYER CONNECTION
NOT TO SCALE

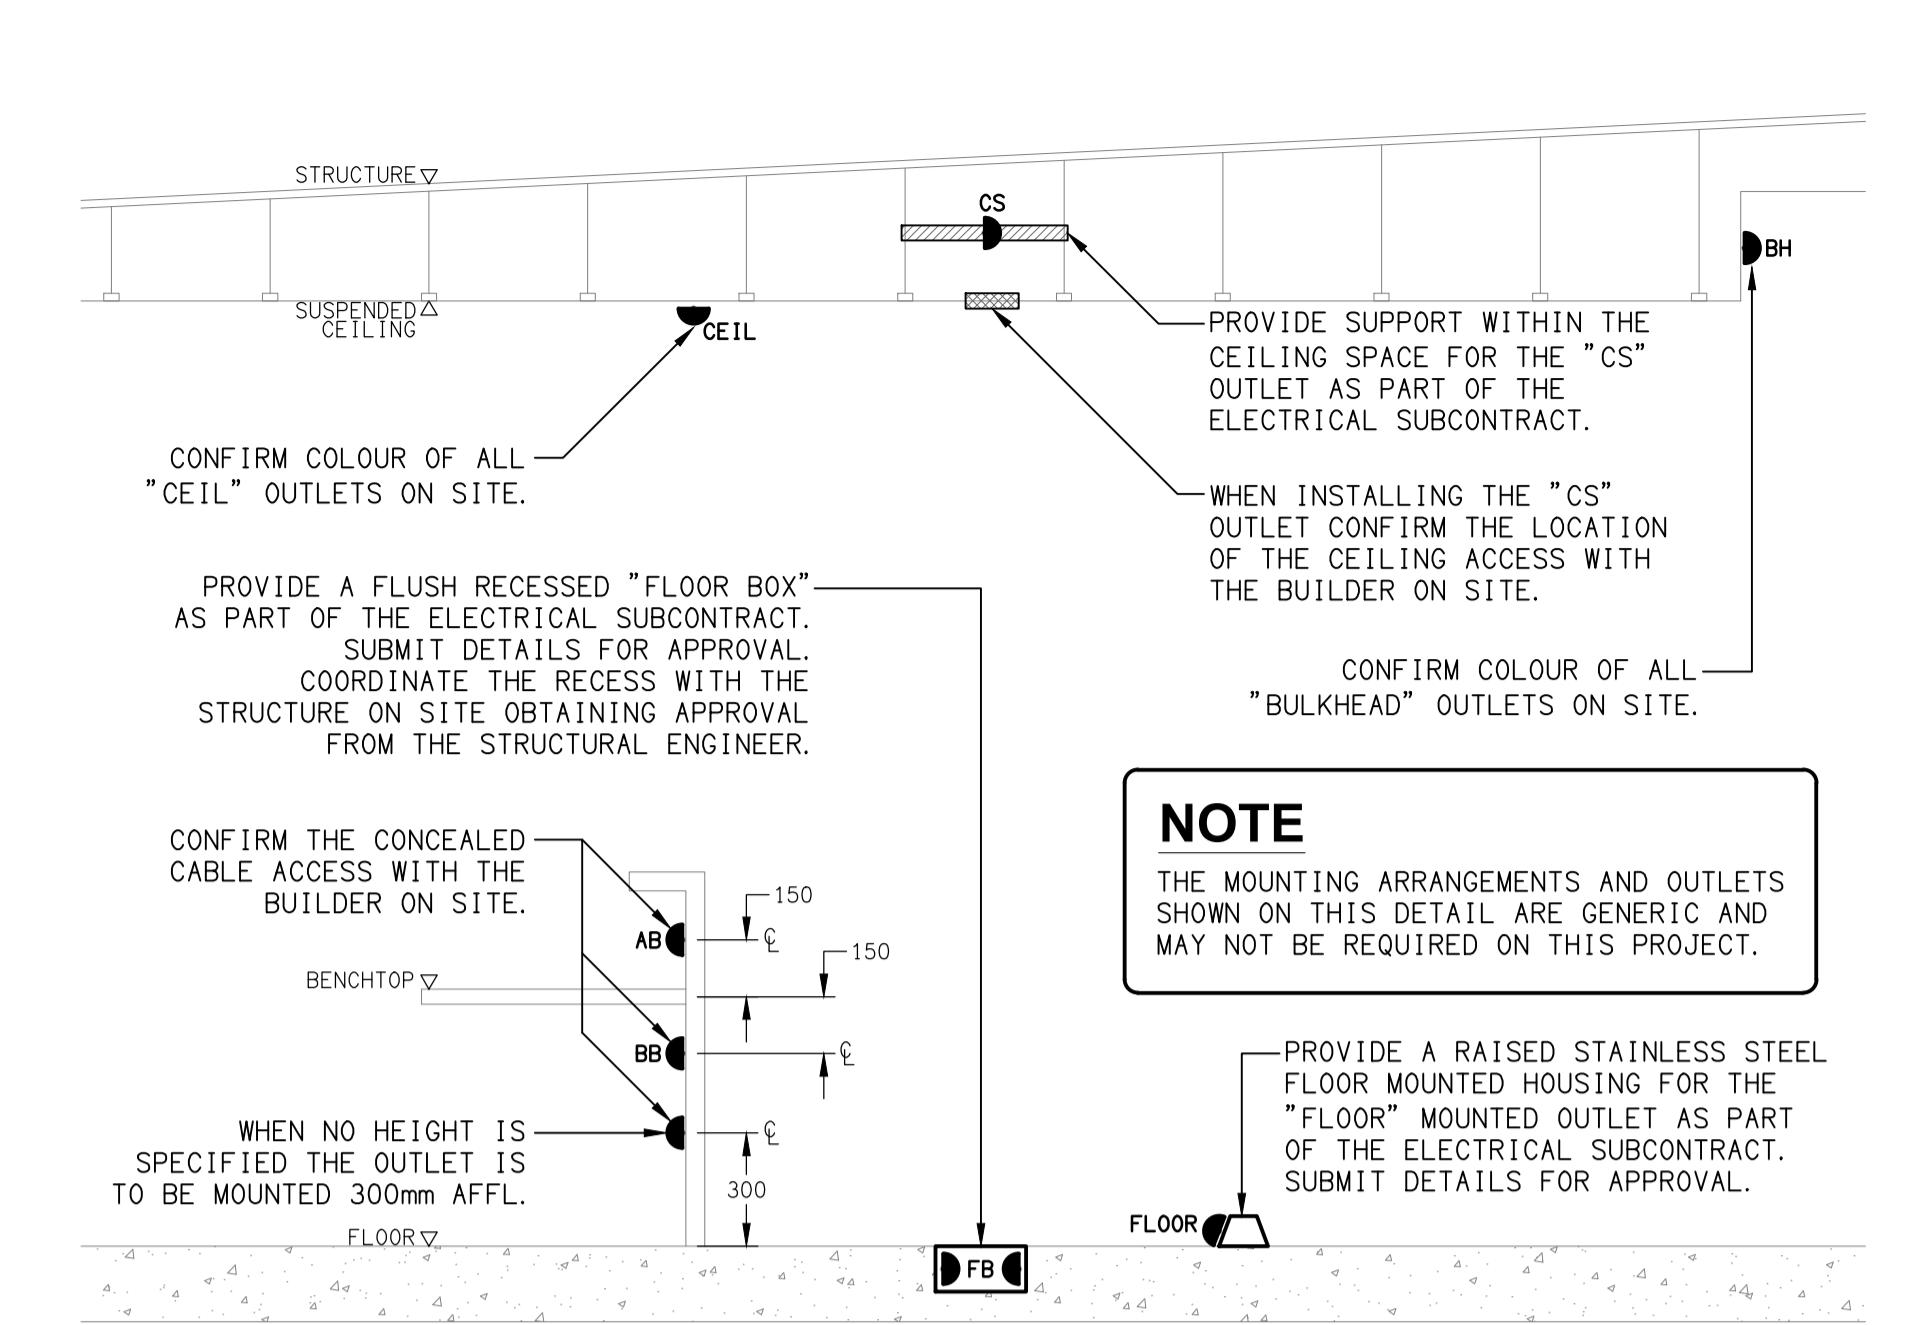

DETAIL
TYPICAL OUTLET MOUNTINGS
NOT TO SCALE

NOTE
THE MOUNTING ARRANGEMENTS AND OUTLETS SHOWN ON THIS DETAIL ARE GENERIC AND MAY NOT BE REQUIRED ON THIS PROJECT.

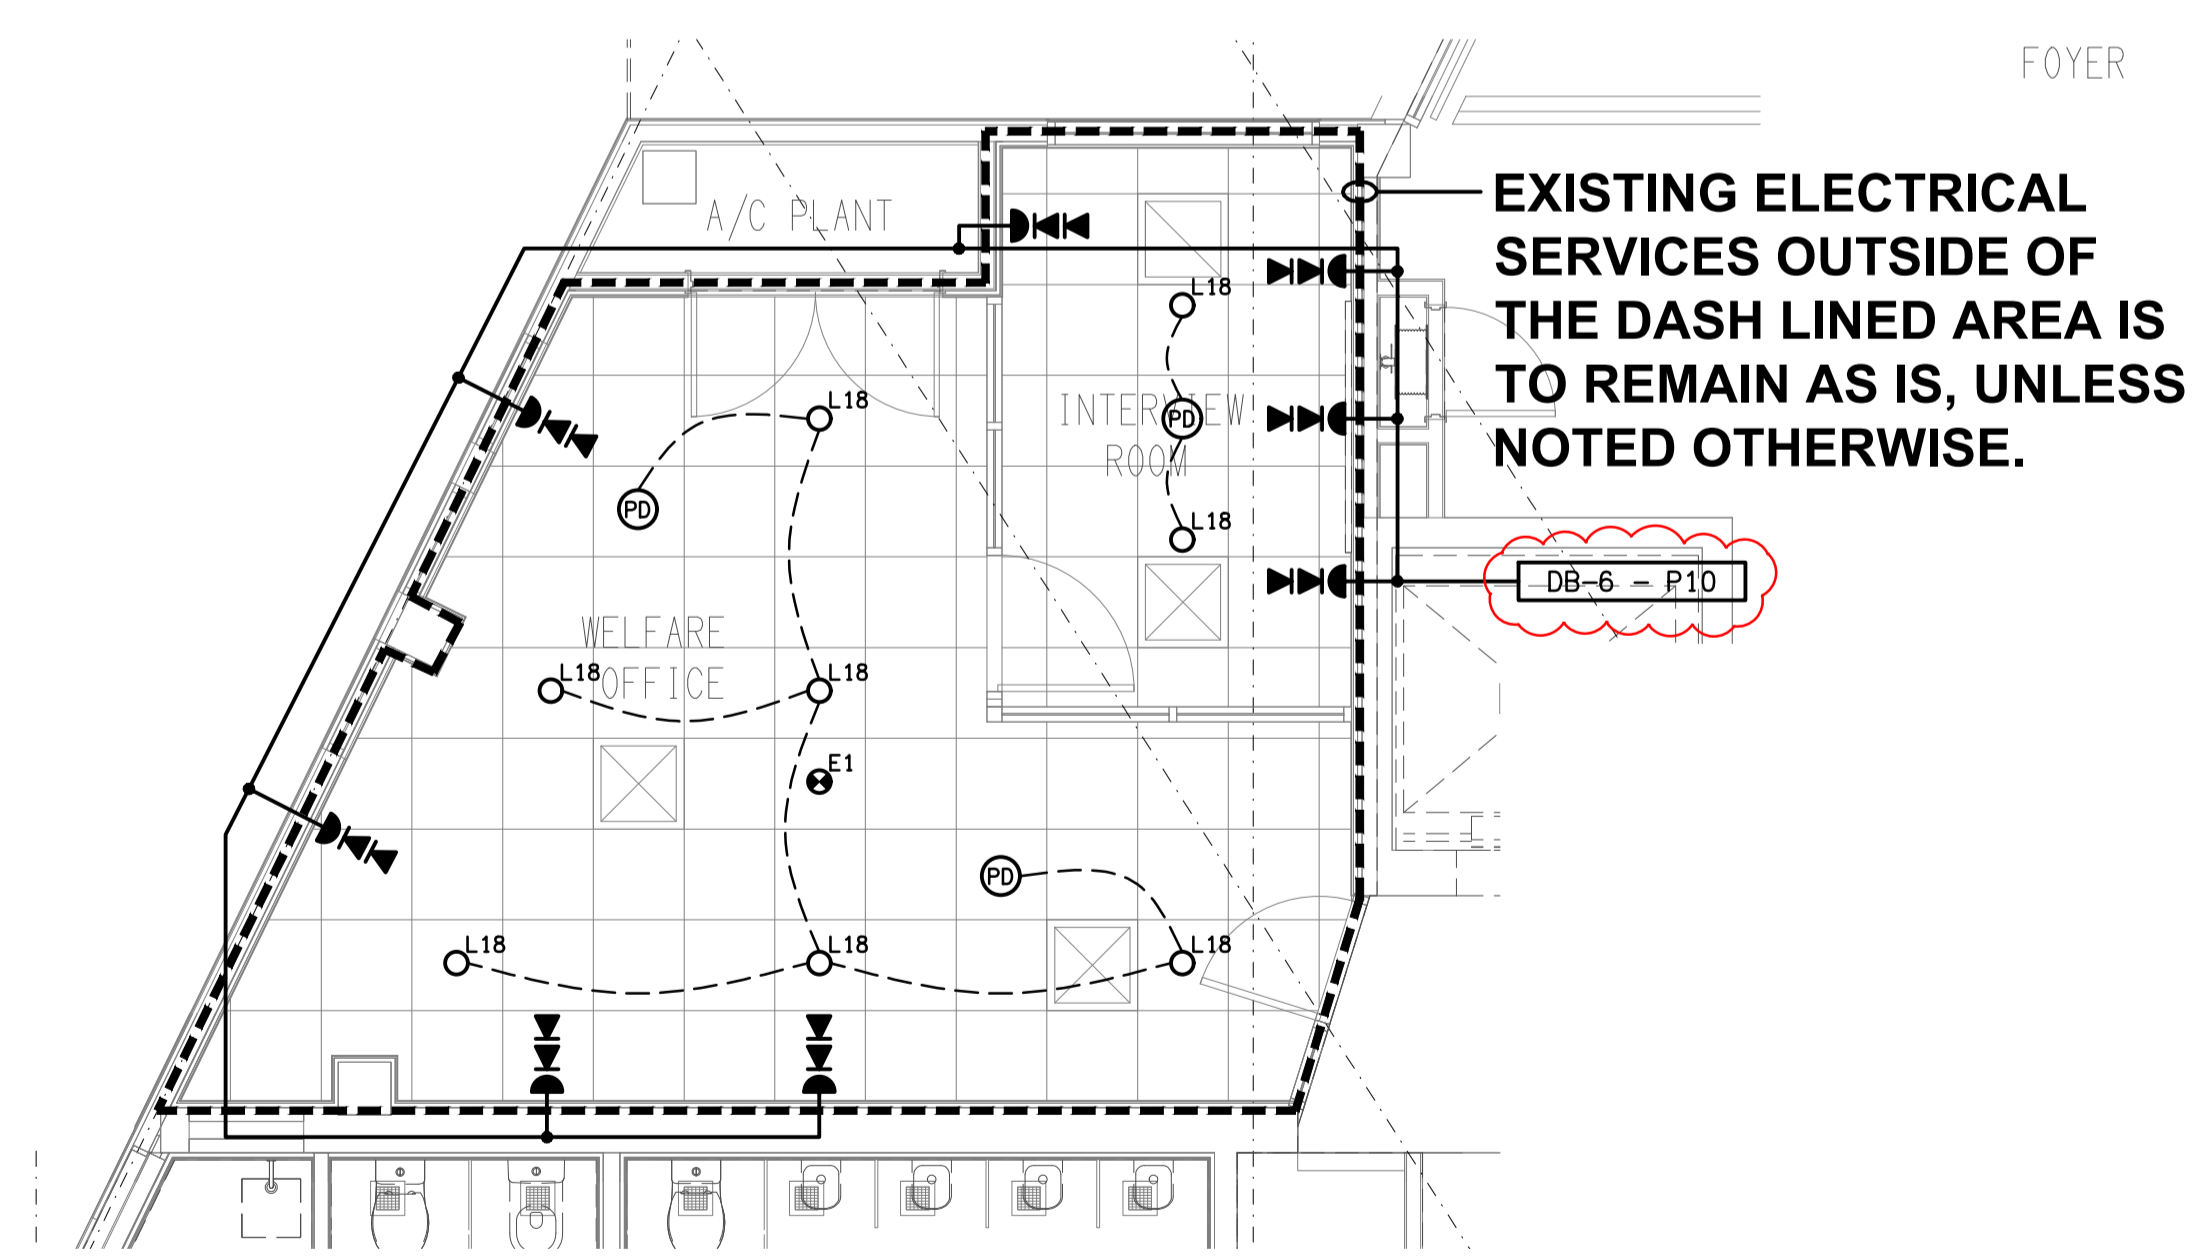

DETAIL A
WELFARE OFFICE CEILING PLAN
SCALE 1:50

ELECTRICAL DESIGN GROUP BRISBANE
PTY LTD
ACN 092 710 793
TRADING AS:
ELECTRICAL DESIGN GROUP

THE COPYRIGHT OF THIS DRAWING
REMAINS THE PROPERTY OF THE
ELECTRICAL DESIGN GROUP.
USE FIGURED DIMENSIONS
IN PREFERENCE TO SCALE.
ALL DIMENSIONS TO BE
VERIFIED ONSITE.

ELECTRICAL DESIGN GROUP
ELECTRICAL BUILDING SERVICES CONSULTANTS
BRISBANE GOLD COAST
P.O. Box 15, Sherwood Q.4075
Phone: (07) 3278 4375
Email: brisbane@edg.net.au
Web: www.edg.net.au

PROJECT:
GEEBUNG RSL
323 NEWMAN ROAD, GEEBUNG

G	CONSTRUCTION	06/09/2023
REV:	DESCRIPTION:	DATE:
DRAWING: ELECTRICAL SERVICES SITE PLAN		
SCALE: 1:200	AT A1	PROJECT NO: C2741a
		DRAWING NO: E02
		REVISION: G