


EXISTING ELECTRICAL SERVICES OUTSIDE OF THE DASH LINED AREA IS TO REMAIN AS IS, UNLESS NOTED OTHERWISE.

EXISTING ELECTRICAL SERVICES OUTSIDE OF THE DASH LINED AREA IS TO REMAIN AS IS, UNLESS NOTED OTHERWISE.

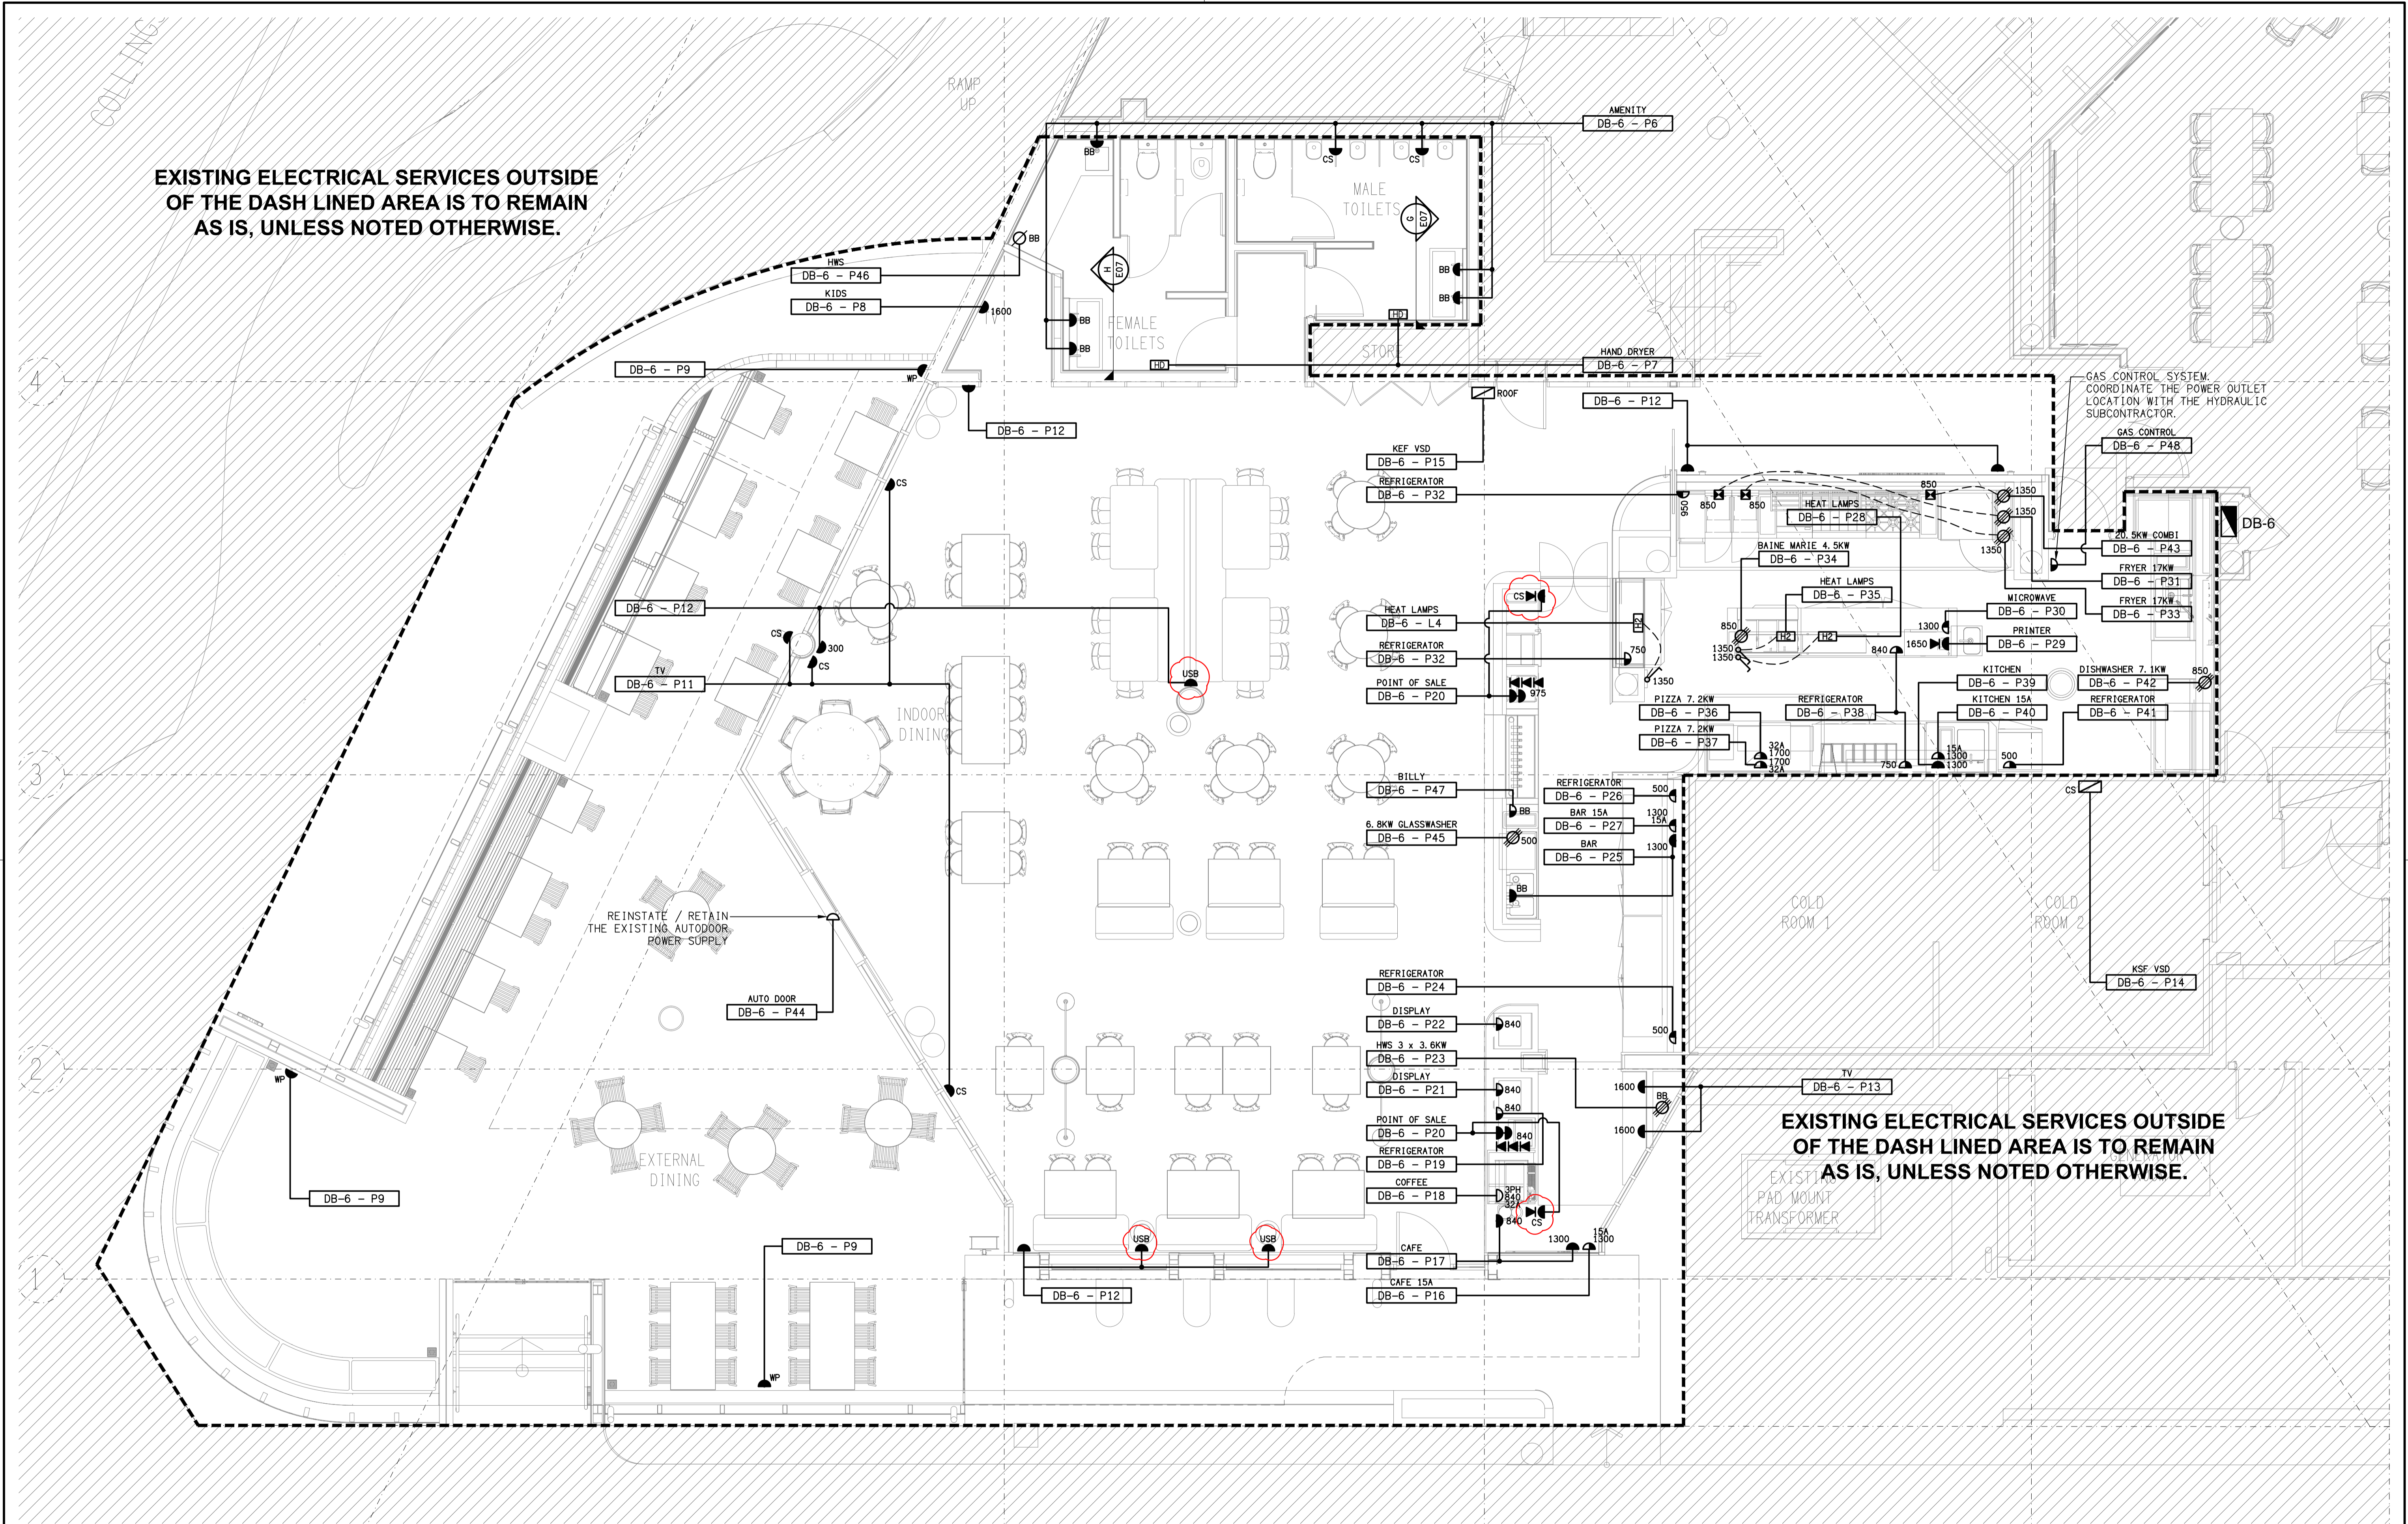

ELECTRICAL DESIGN GROUP BRISBANE  
PTY LTD  
ACN 092 710 793  
TRADING AS:  
ELECTRICAL DESIGN GROUP

THE COPYRIGHT OF THIS DRAWING  
REMAINS THE PROPERTY OF THE  
ELECTRICAL DESIGN GROUP.  
USE FIGURED DIMENSIONS  
IN PREFERENCE TO SCALE.  
ALL DIMENSIONS TO BE  
VERIFIED ONSITE.

**ELECTRICAL DESIGN GROUP**  
ELECTRICAL BUILDING SERVICES CONSULTANTS  
BRISBANE GOLD COAST  
P.O. Box 15, Sherwood Q.4075  
Phone: (07) 3278 4375  
Email: brisbane@edg.net.au  
Web: www.edg.net.au

PROJECT:  
**GEEBUNG RSL**  
323 NEWMAN ROAD, GEEBUNG

N	CONSTRUCTION	13/10/2023
REV:	DESCRIPTION:	DATE:
DRAWING: <b>ELECTRICAL SERVICES CAFE, BAR &amp; KITCHEN FLOOR PLAN</b>		
SCALE: 1:50	AT A1	PROJECT NO: <b>C2741a</b>
		DRAWING NO: <b>E03</b>
		REVISION: <b>N</b>