


EXISTING ELECTRICAL SERVICES OUTSIDE OF THE DASH LINED AREA IS TO REMAIN AS IS, UNLESS NOTED OTHERWISE.

NOTE:
REFER TO C2741a-E07.dwg JOINERY LIGHTING ELEVATIONS DRAWING FOR ADDITIONAL LIGHTING AND ANY LIGHT FITTING NOT SHOWN SWITCHED OR CIRCUITED ON THIS DRAWING.

EXISTING ELECTRICAL SERVICES OUTSIDE OF THE DASH LINED AREA IS TO REMAIN AS IS, UNLESS NOTED OTHERWISE.

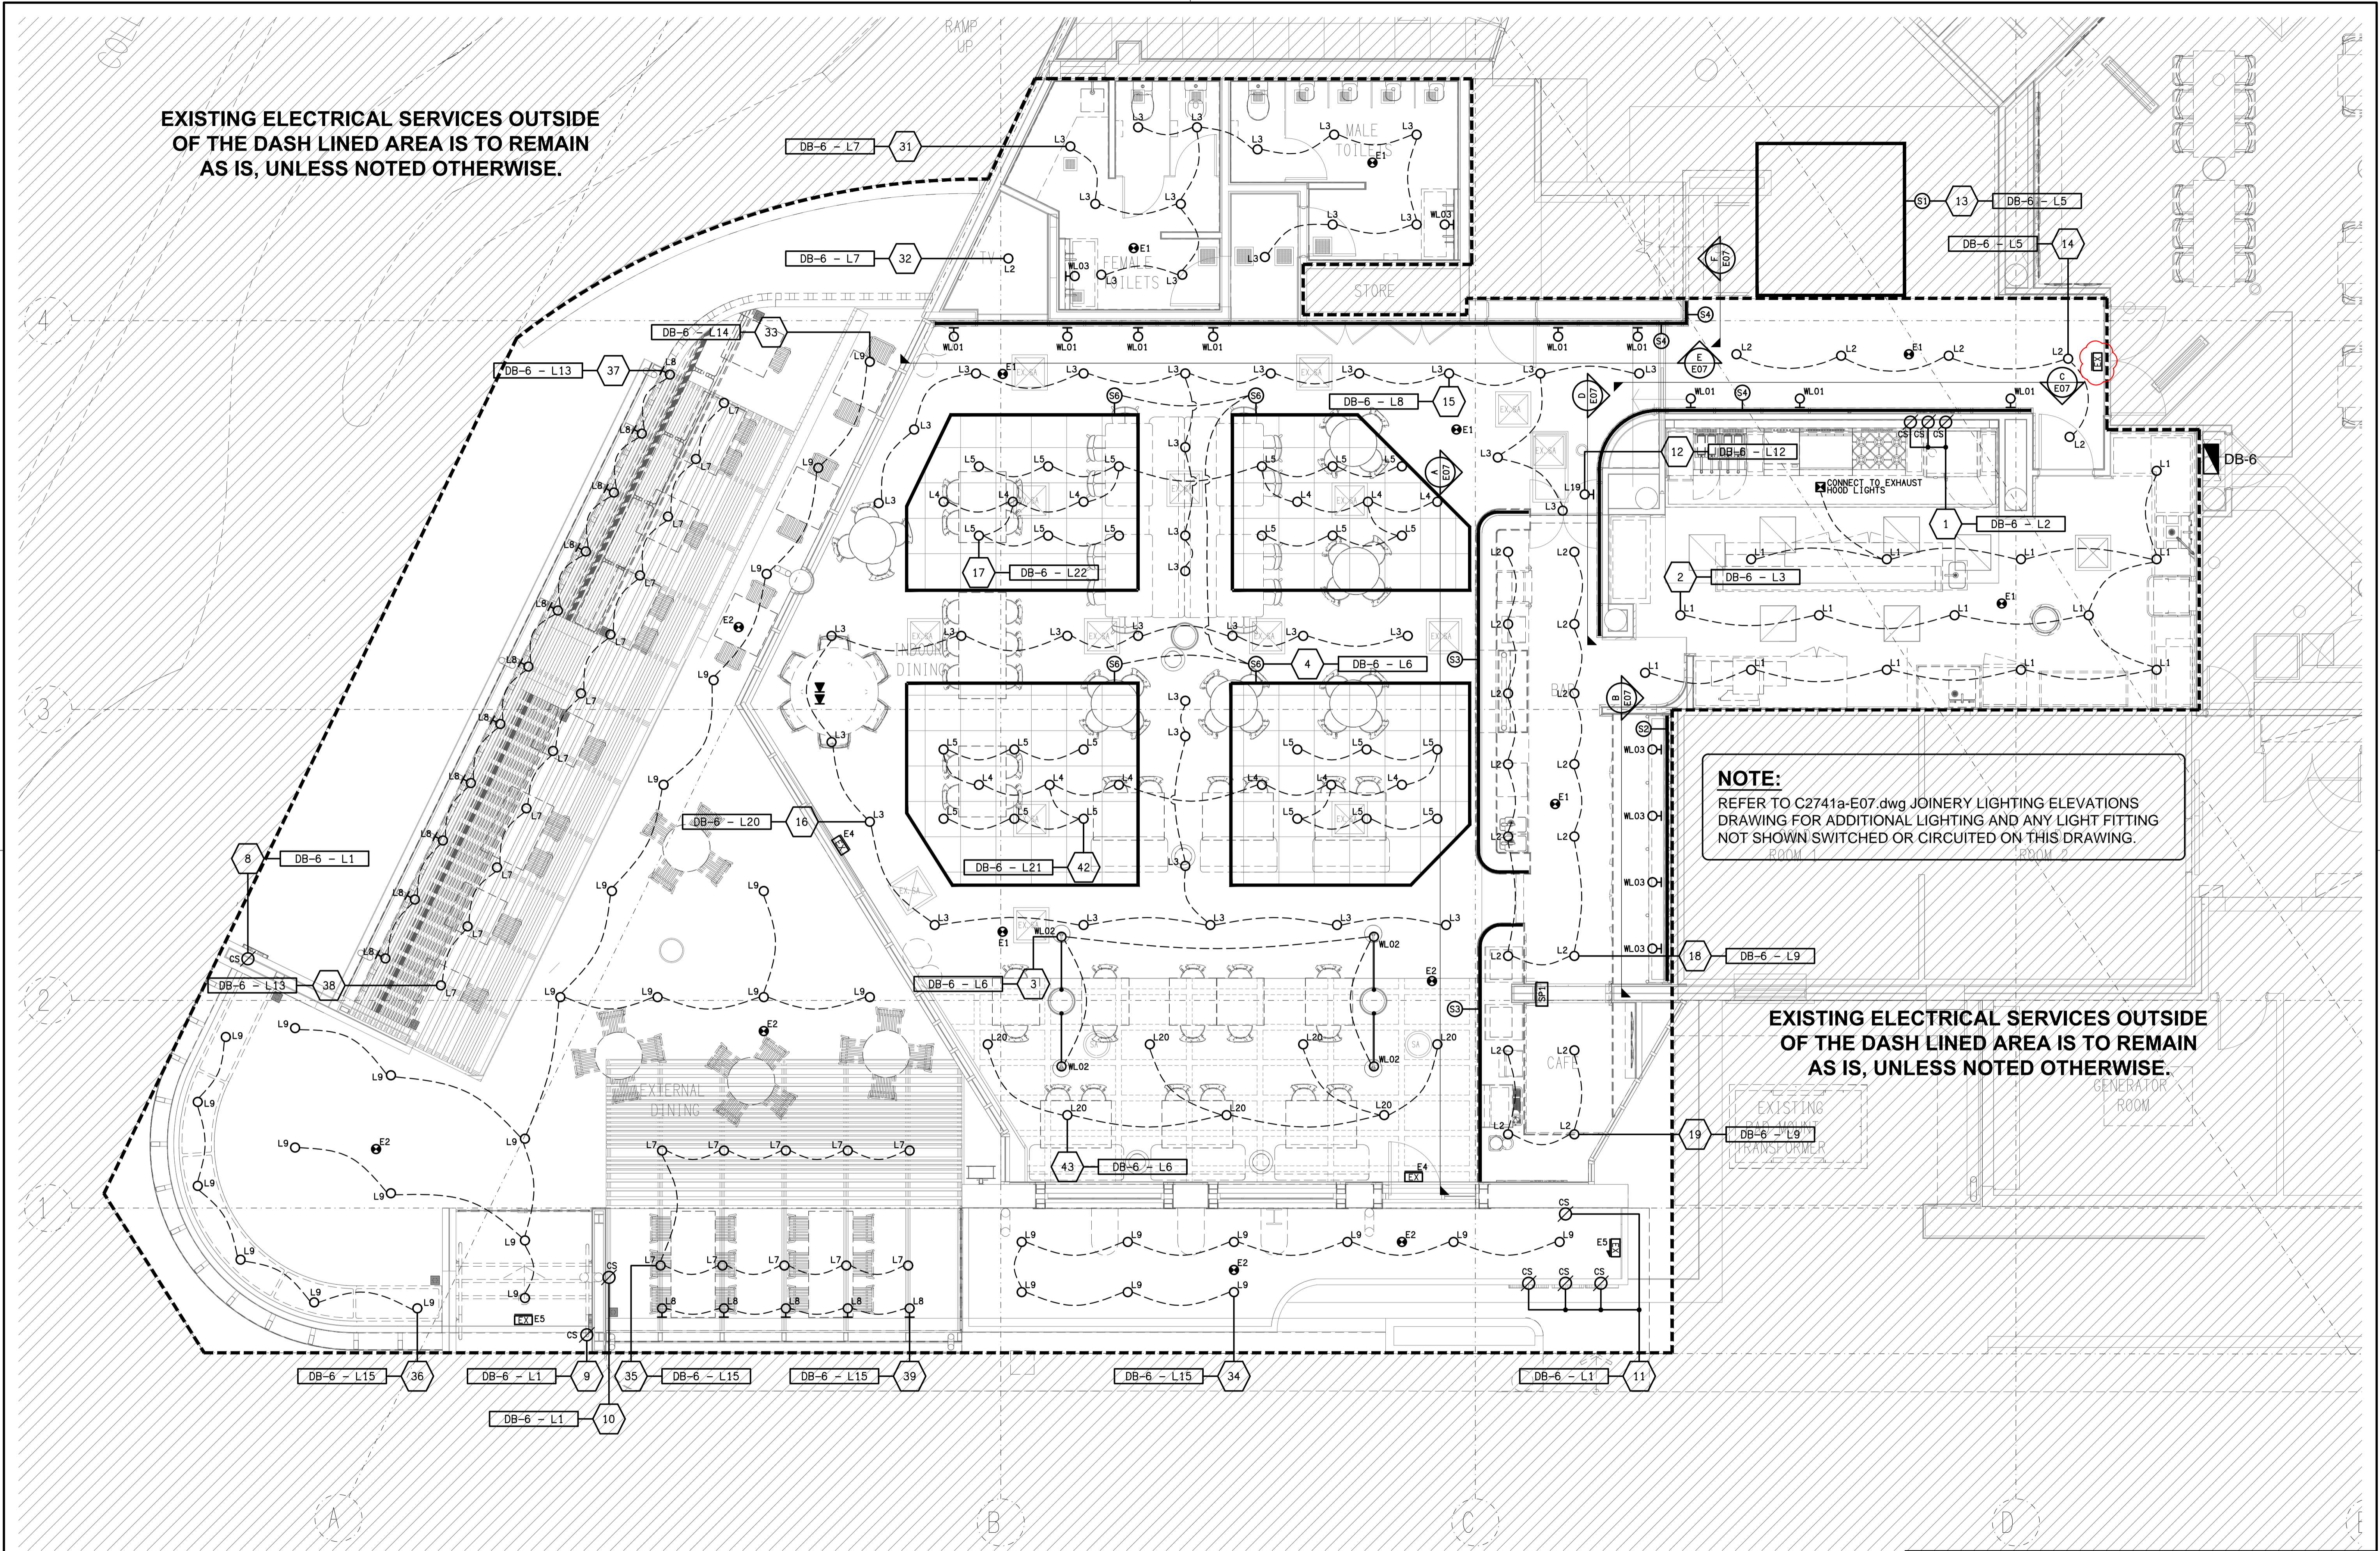

ELECTRICAL DESIGN GROUP BRISBANE
PTY LTD
ACN 092 710 793
TRADING AS:
ELECTRICAL DESIGN GROUP

THE COPYRIGHT OF THIS DRAWING
REMAINS THE PROPERTY OF THE
ELECTRICAL DESIGN GROUP.
USE FIGURED DIMENSIONS
IN PREFERENCE TO SCALE.
ALL DIMENSIONS TO BE
VERIFIED ONSITE.

ELECTRICAL DESIGN GROUP
ELECTRICAL BUILDING SERVICES CONSULTANTS
BRISBANE GOLD COAST
P.O. Box 15, Sherwood Q.4075
Phone: (07) 3278 4375
Email: brisbane@edg.net.au
Web: www.edg.net.au

PROJECT:
GEEBUNG RSL
323 NEWMAN ROAD, GEEBUNG

K	CONSTRUCTION	13/10/2023
REV:	DESCRIPTION:	DATE:
DRAWING: ELECTRICAL SERVICES CAFE, BAR & KITCHEN REFLECTED CEILING PLAN		
SCALE: 1:50	PROJECT NO: C2741a	DRAWING NO: E04
AT A1	REVISION: K	