



EXISTING ELECTRICAL SERVICES OUTSIDE OF THE DASH LINED AREA IS TO REMAIN AS IS, UNLESS NOTED OTHERWISE.

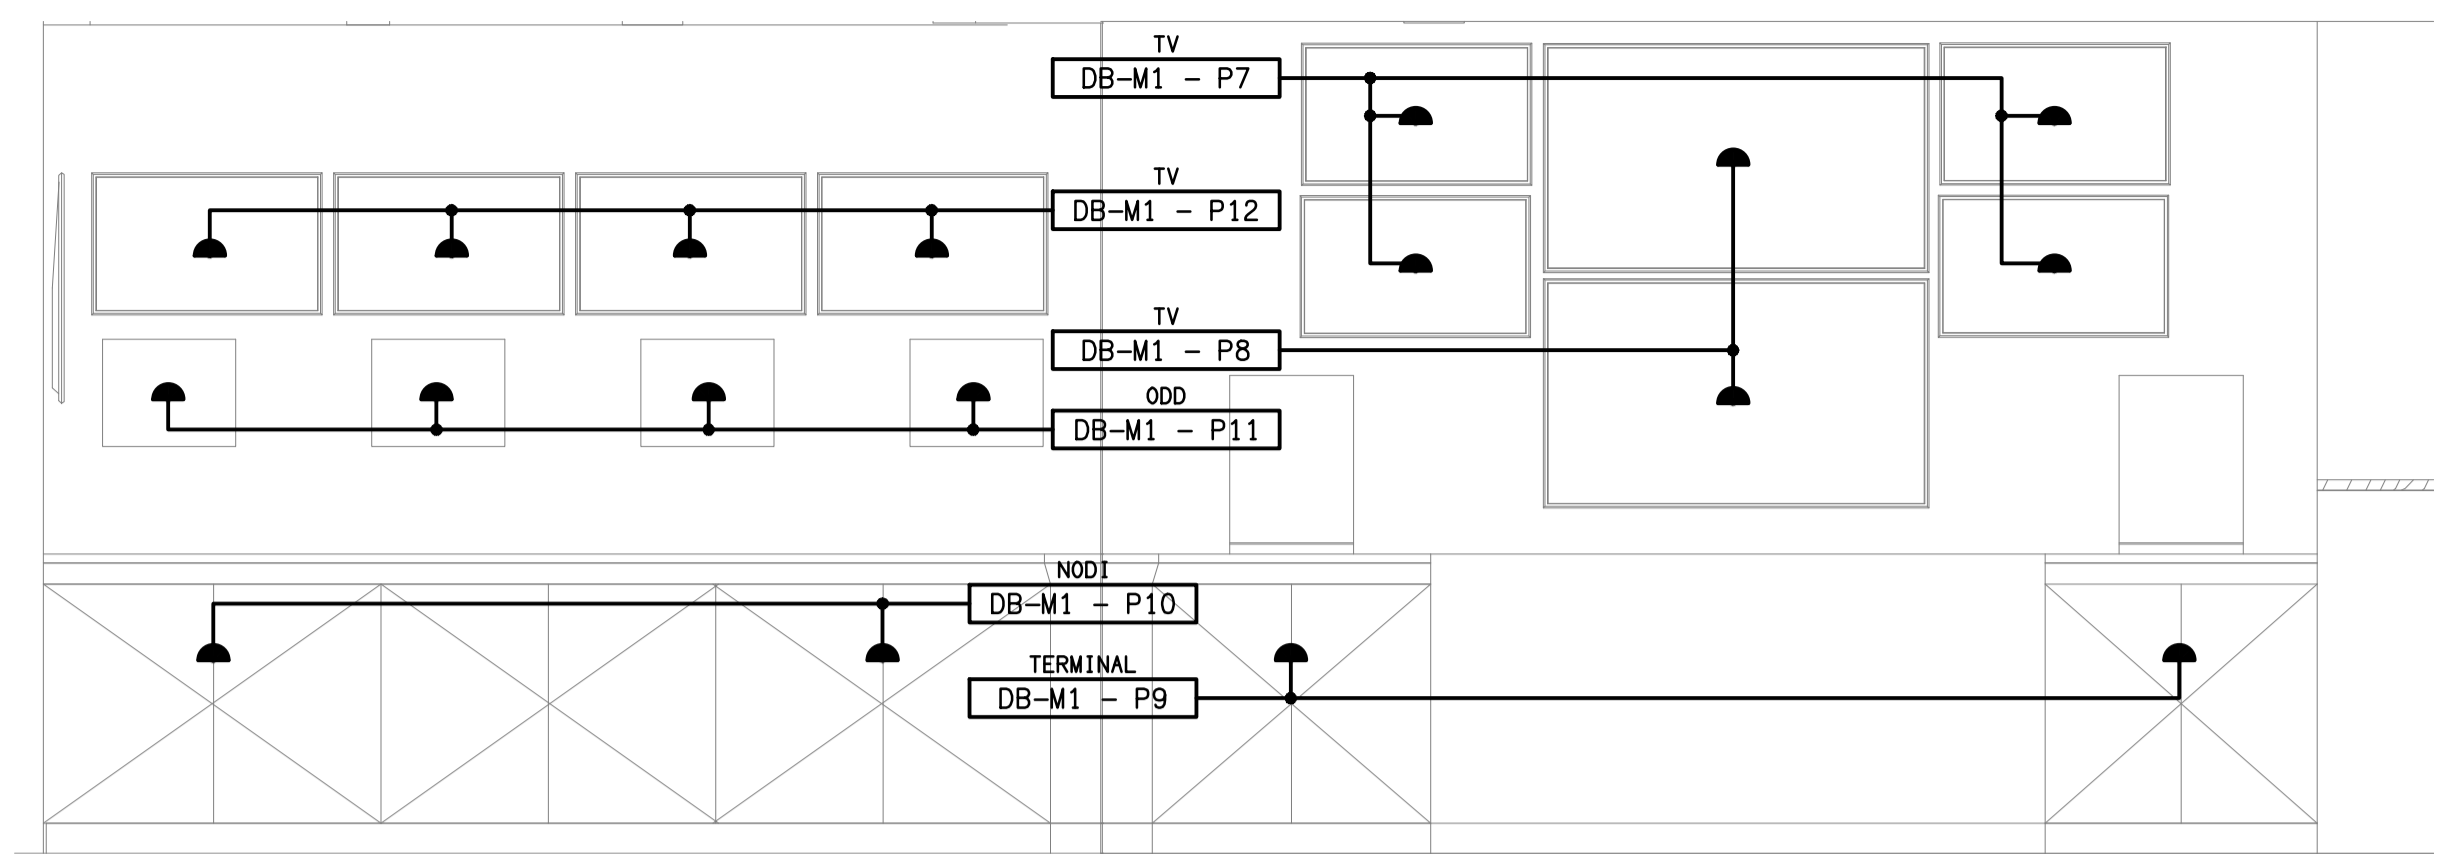

**DETAIL 1**  
TAB WALL ELEVATION  
SCALE: 1:25

EXISTING ELECTRICAL SERVICES OUTSIDE OF THE DASH LINED AREA IS TO REMAIN AS IS, UNLESS NOTED OTHERWISE.

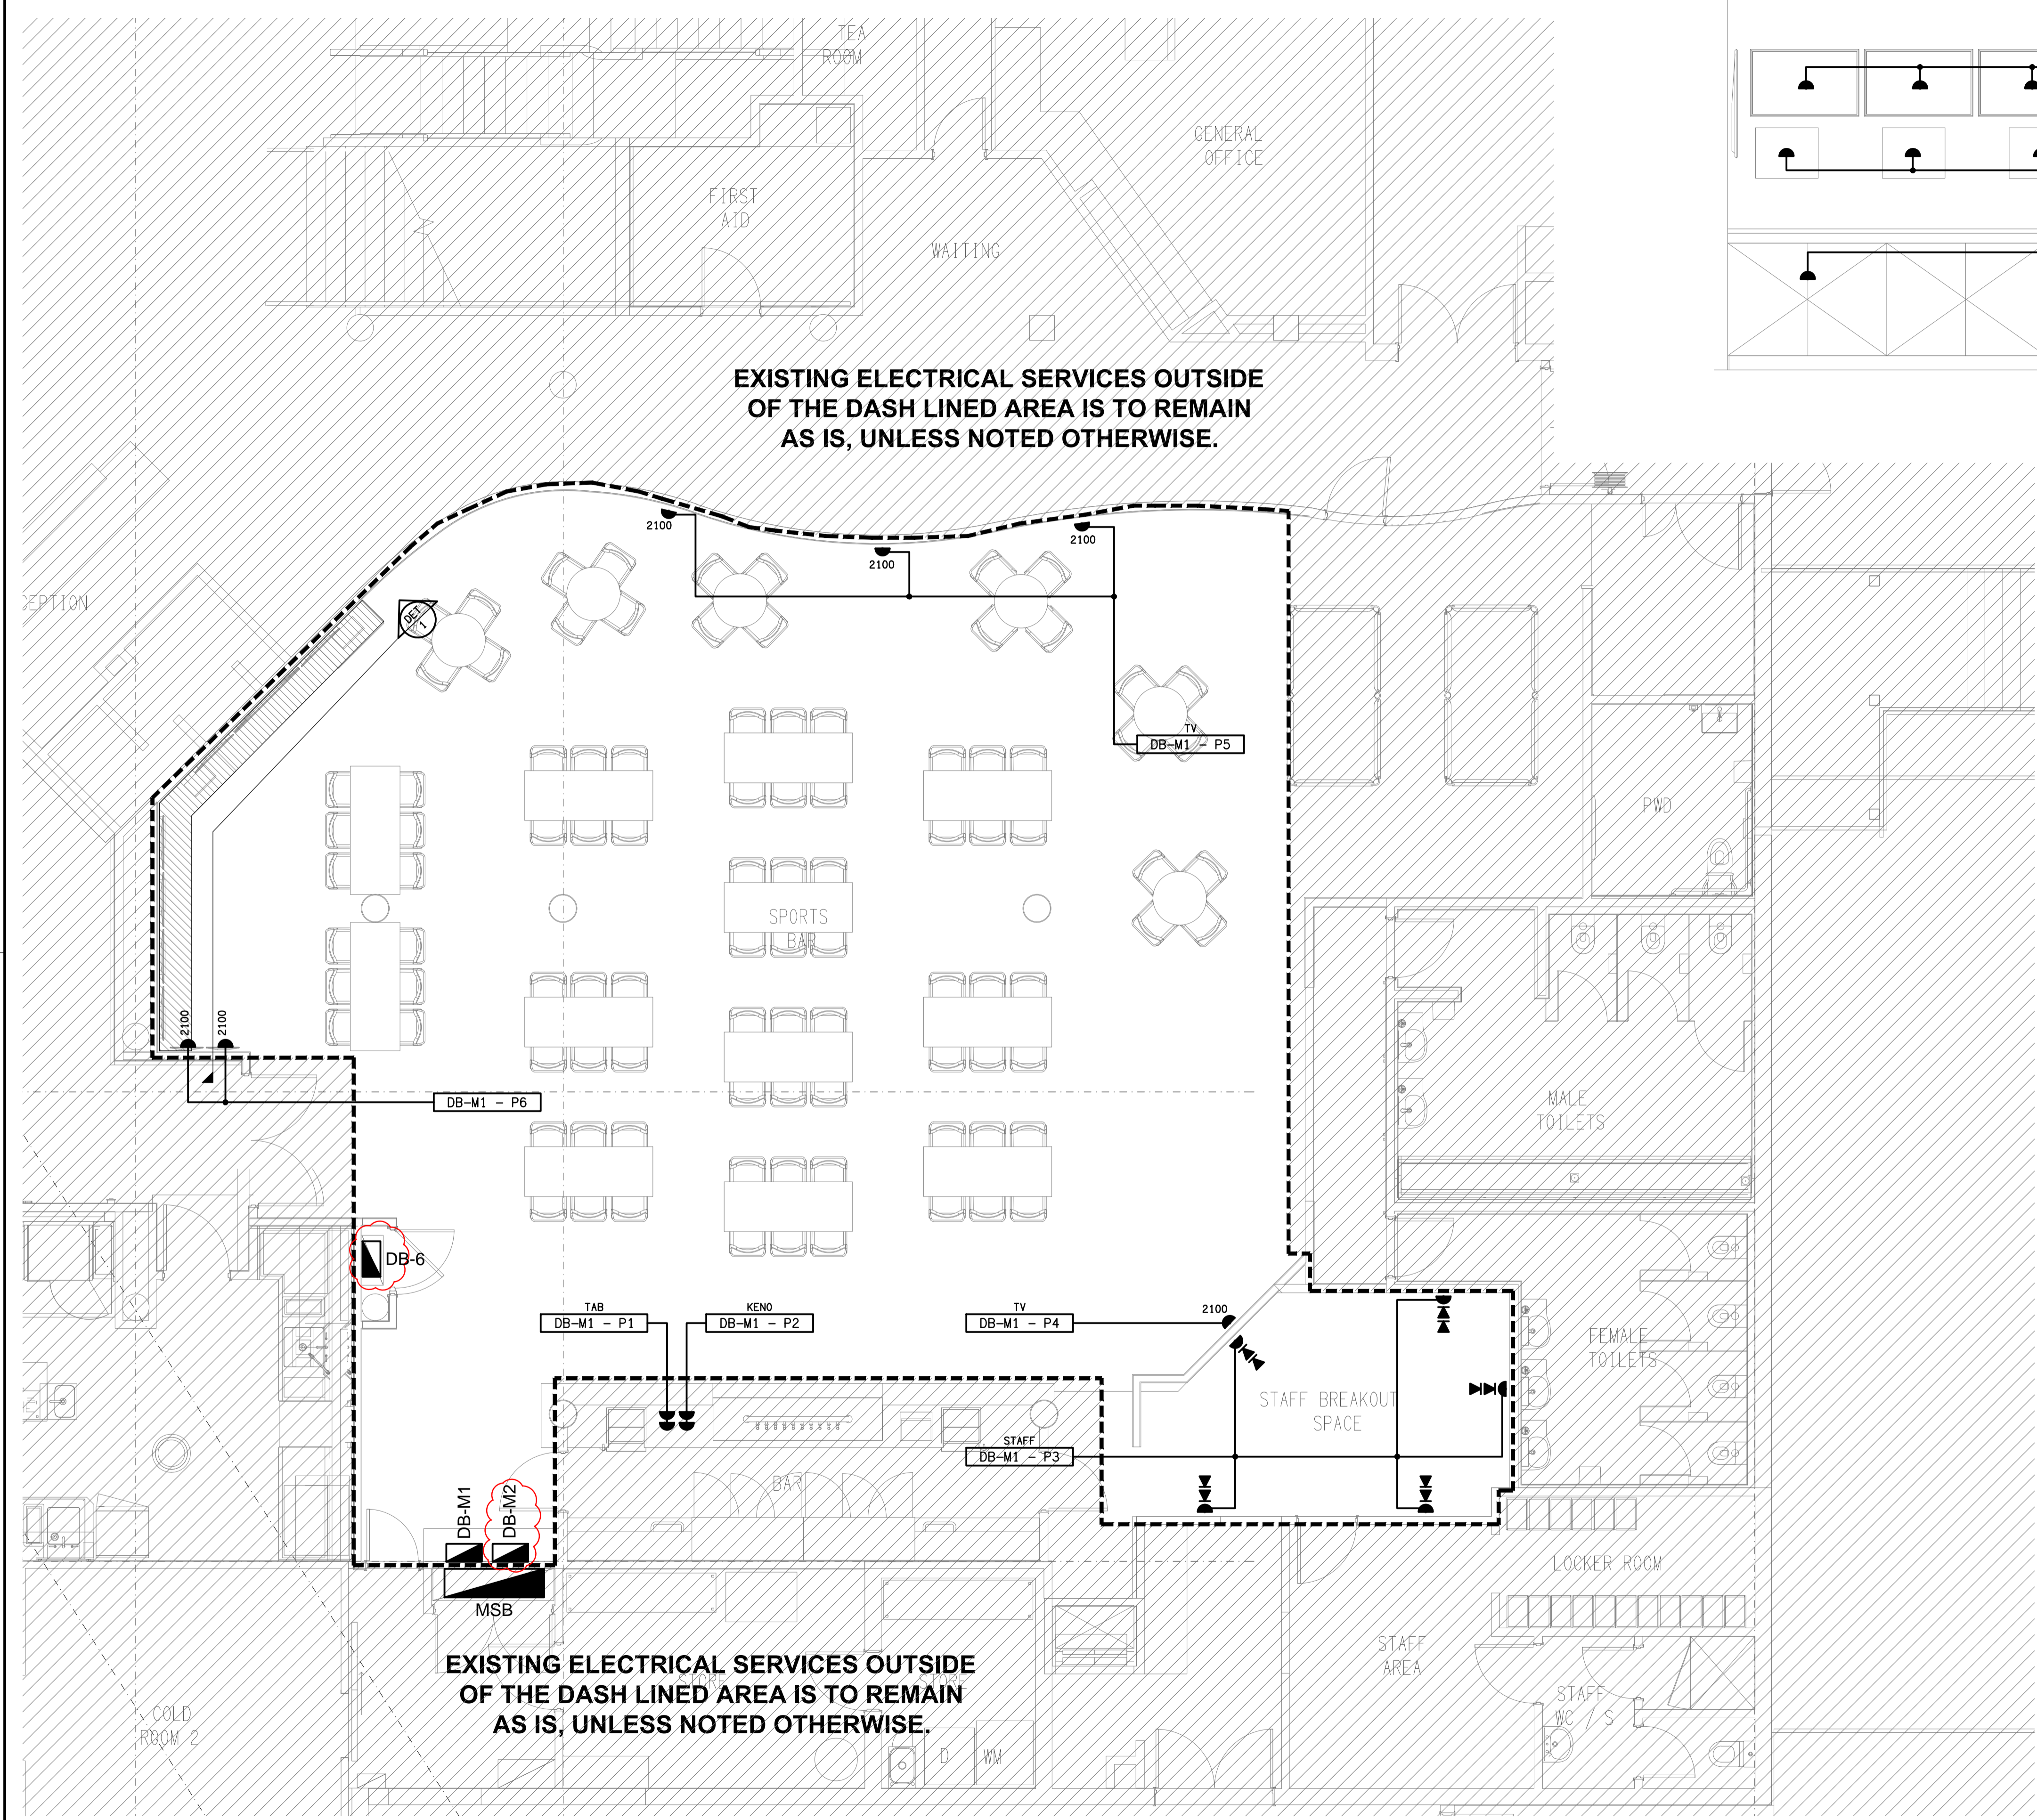

ELECTRICAL DESIGN GROUP BRISBANE  
PTY LTD  
ACN 092 710 793  
TRADING AS:  
ELECTRICAL DESIGN GROUP

THE COPYRIGHT OF THIS DRAWING  
REMAINS THE PROPERTY OF THE  
ELECTRICAL DESIGN GROUP.  
USE FIGURED DIMENSIONS  
IN PREFERENCE TO SCALE.  
ALL DIMENSIONS TO BE  
VERIFIED ONSITE.

**ELECTRICAL DESIGN GROUP**  
ELECTRICAL BUILDING SERVICES CONSULTANTS  
BRISBANE GOLD COAST

P.O. Box 15, Sherwood Q.4075  
Phone: (07) 3278 4375  
Email: brisbane@edg.net.au  
Web: www.edg.net.au

PROJECT:  
**GEEBUNG RSL**  
323 NEWMAN ROAD, GEEBUNG

F	CONSTRUCTION	06/09/2023
REV:	DESCRIPTION:	DATE:

DRAWING:  
**ELECTRICAL SERVICES  
SPORTS BAR FLOOR PLAN**

SCALE: 1:50	AT A1	PROJECT NO: <b>C2741a</b>	DRAWING NO: <b>E05</b>	REVISION: <b>F</b>
----------------	-------	------------------------------	---------------------------	-----------------------