


**LEGEND**

- ELECTRICAL SERVICES SWITCHBOARD.
- SWITCHBOARD / CONTROL PANEL NOT PROVIDED AS PART OF THE ELECTRICAL SUBCONTRACT.
- SINGLE POWER OUTLET.
- DOUBLE POWER OUTLET.
- SPECIAL PURPOSE POWER OUTLET.
- SINGLE PHASE ISOLATOR.
- THREE PHASE ISOLATOR.
- SIGN CONNECTION.
- CONDUIT ROUTE.
- x DENOTES CONDUIT TYPE.
- ELECTRICAL PIT, TYPE AS NOTED.
- HAND DRYER CONNECTION.
- LIGHTING PRESENCE DETECTOR SWITCH.
- LIGHTING CONTROL SWITCH PANEL, TYPE AS NOTED.
- ONE-WAY LIGHT SWITCH.
- TWO-WAY LIGHT SWITCH.
- CIRCUIT LINE.
- SWITCH LINE.
- DB-x - Py POWER CIRCUIT DESIGNATION. DENOTES DB AND CIRCUIT.
- xx LIGHTING CONTROL CHANNEL REFERENCE.
- ELECTRICAL EQUIPMENT AS NOTED.
- RJ45 COMMUNICATIONS OUTLET ALL TO CR-1.
- RJ45 GAMING LINK OUTLET.
- NBN PREMISES CONNECTION DEVICE.
- NBN NETWORK TERMINATION DEVICE.
- GAMING FIBRE.
- NO LONGER REQUIRED.
- SECURITY CAMERA.
- REVENUE METER.
- FUSE.
- SINGLE PHASE.
- THREE PHASE.
- CURRENT TRANSFORMER C/W REMOVABLE LINK.
- FUSE LINK.
- COMBINED FUSE SWITCH.
- CIRCUIT BREAKER.
- ISOLATOR.
- RESIDUAL CURRENT DEVICE.
- CONTACTOR - NORMALLY OPEN.
- CONTACTOR - NORMALLY CLOSED.
- TV TELEVISION POSITION.

**LEGEND**

- REFER TO DETAIL NOTED FOR THE AREA SHOWN HATCHED. ADDITIONAL OUTLETS & FITTINGS MAY BE SHOWN ON DETAIL.
- E1: GENERAL LED EMERGENCY LIGHT.
- EX: EMERGENCY LED EXIT LIGHT.
- Lx: LIGHT FITTING C/W NON-MAINTAINED EMERGENCY BATTERY PACK. TYPE AS NOTED.
- L1: 600 X 300 LED FLAT PANEL.
- L2: 1200 X 300 LED FLAT PANEL.
- L3: LOADING DOCK FLOOD LIGHT.
- L4: AMENITY RECESSED DALI DOWNLIGHT.
- L5: 1200 LONG LED BATTEN C/W SENSOR.
- L6: 6M POLE FORWARD THROW CARPARK LIGHT.
- L7: NO LONGER REQUIRED.
- L8: 600 LONG LED BATTEN.
- LP1: EXISTING GREEN LIGHT POLE REFURBISHED.
- LP2: EXISTING ENTRY STATEMENT SPHERE TO BE REPLACED.
- LP3: LED BOLLARD LIGHT.
- LP4: LIGHT POLE AND SPHERE.
- CAT: CATENARY FESTOON LIGHTING.
- SDL1: SURFACE MOUNTED CAN DALI DOWNLIGHT.
- SDL2: SURFACE MOUNTED CAN DALI DOWNLIGHT.
- SDL3: 500DIA DALI SPHERE.
- RDL1: RECESSED DALI WHITE DOWNLIGHT.
- RDL2: RECESSED DALI BLACK DOWNLIGHT.
- RDL3: RECESSED ADJUSTABLE DALI WHITE DOWNLIGHT.
- PL1: DECORATIVE DALI PENDANT.
- PL2A: DECORATIVE DALI PENDANT.
- PL2B: DECORATIVE DALI PENDANT.
- PL2C: DECORATIVE DALI PENDANT.
- TRK1: 8400 LONG 8 FITTING DALI TRACK.
- TRK2: 9200 LONG 10 FITTING DALI TRACK.
- TL1: TABLE LAMP.
- WL1: WALL MOUNTED DALI UP DOWN LIGHT.
- WL2: WALL MOUNTED DECORATIVE LIGHT.
- UP1: NO LONGER REQUIRED.
- UP2: INGROUND DALI UPLIGHT.
- S1: RECESSED DALI STAIR HANDRAIL LIGHT.
- S2: REAR BAR DALI LED STRIP LIGHTS.
- S3: COUNTER DALI LED STRIP LIGHT.
- S4: REAR BAR DALI LED STRIP LIGHTS.
- H1: KITCHEN PASS OUT HEAT LAMPS.
- CF: CEILING FAN.

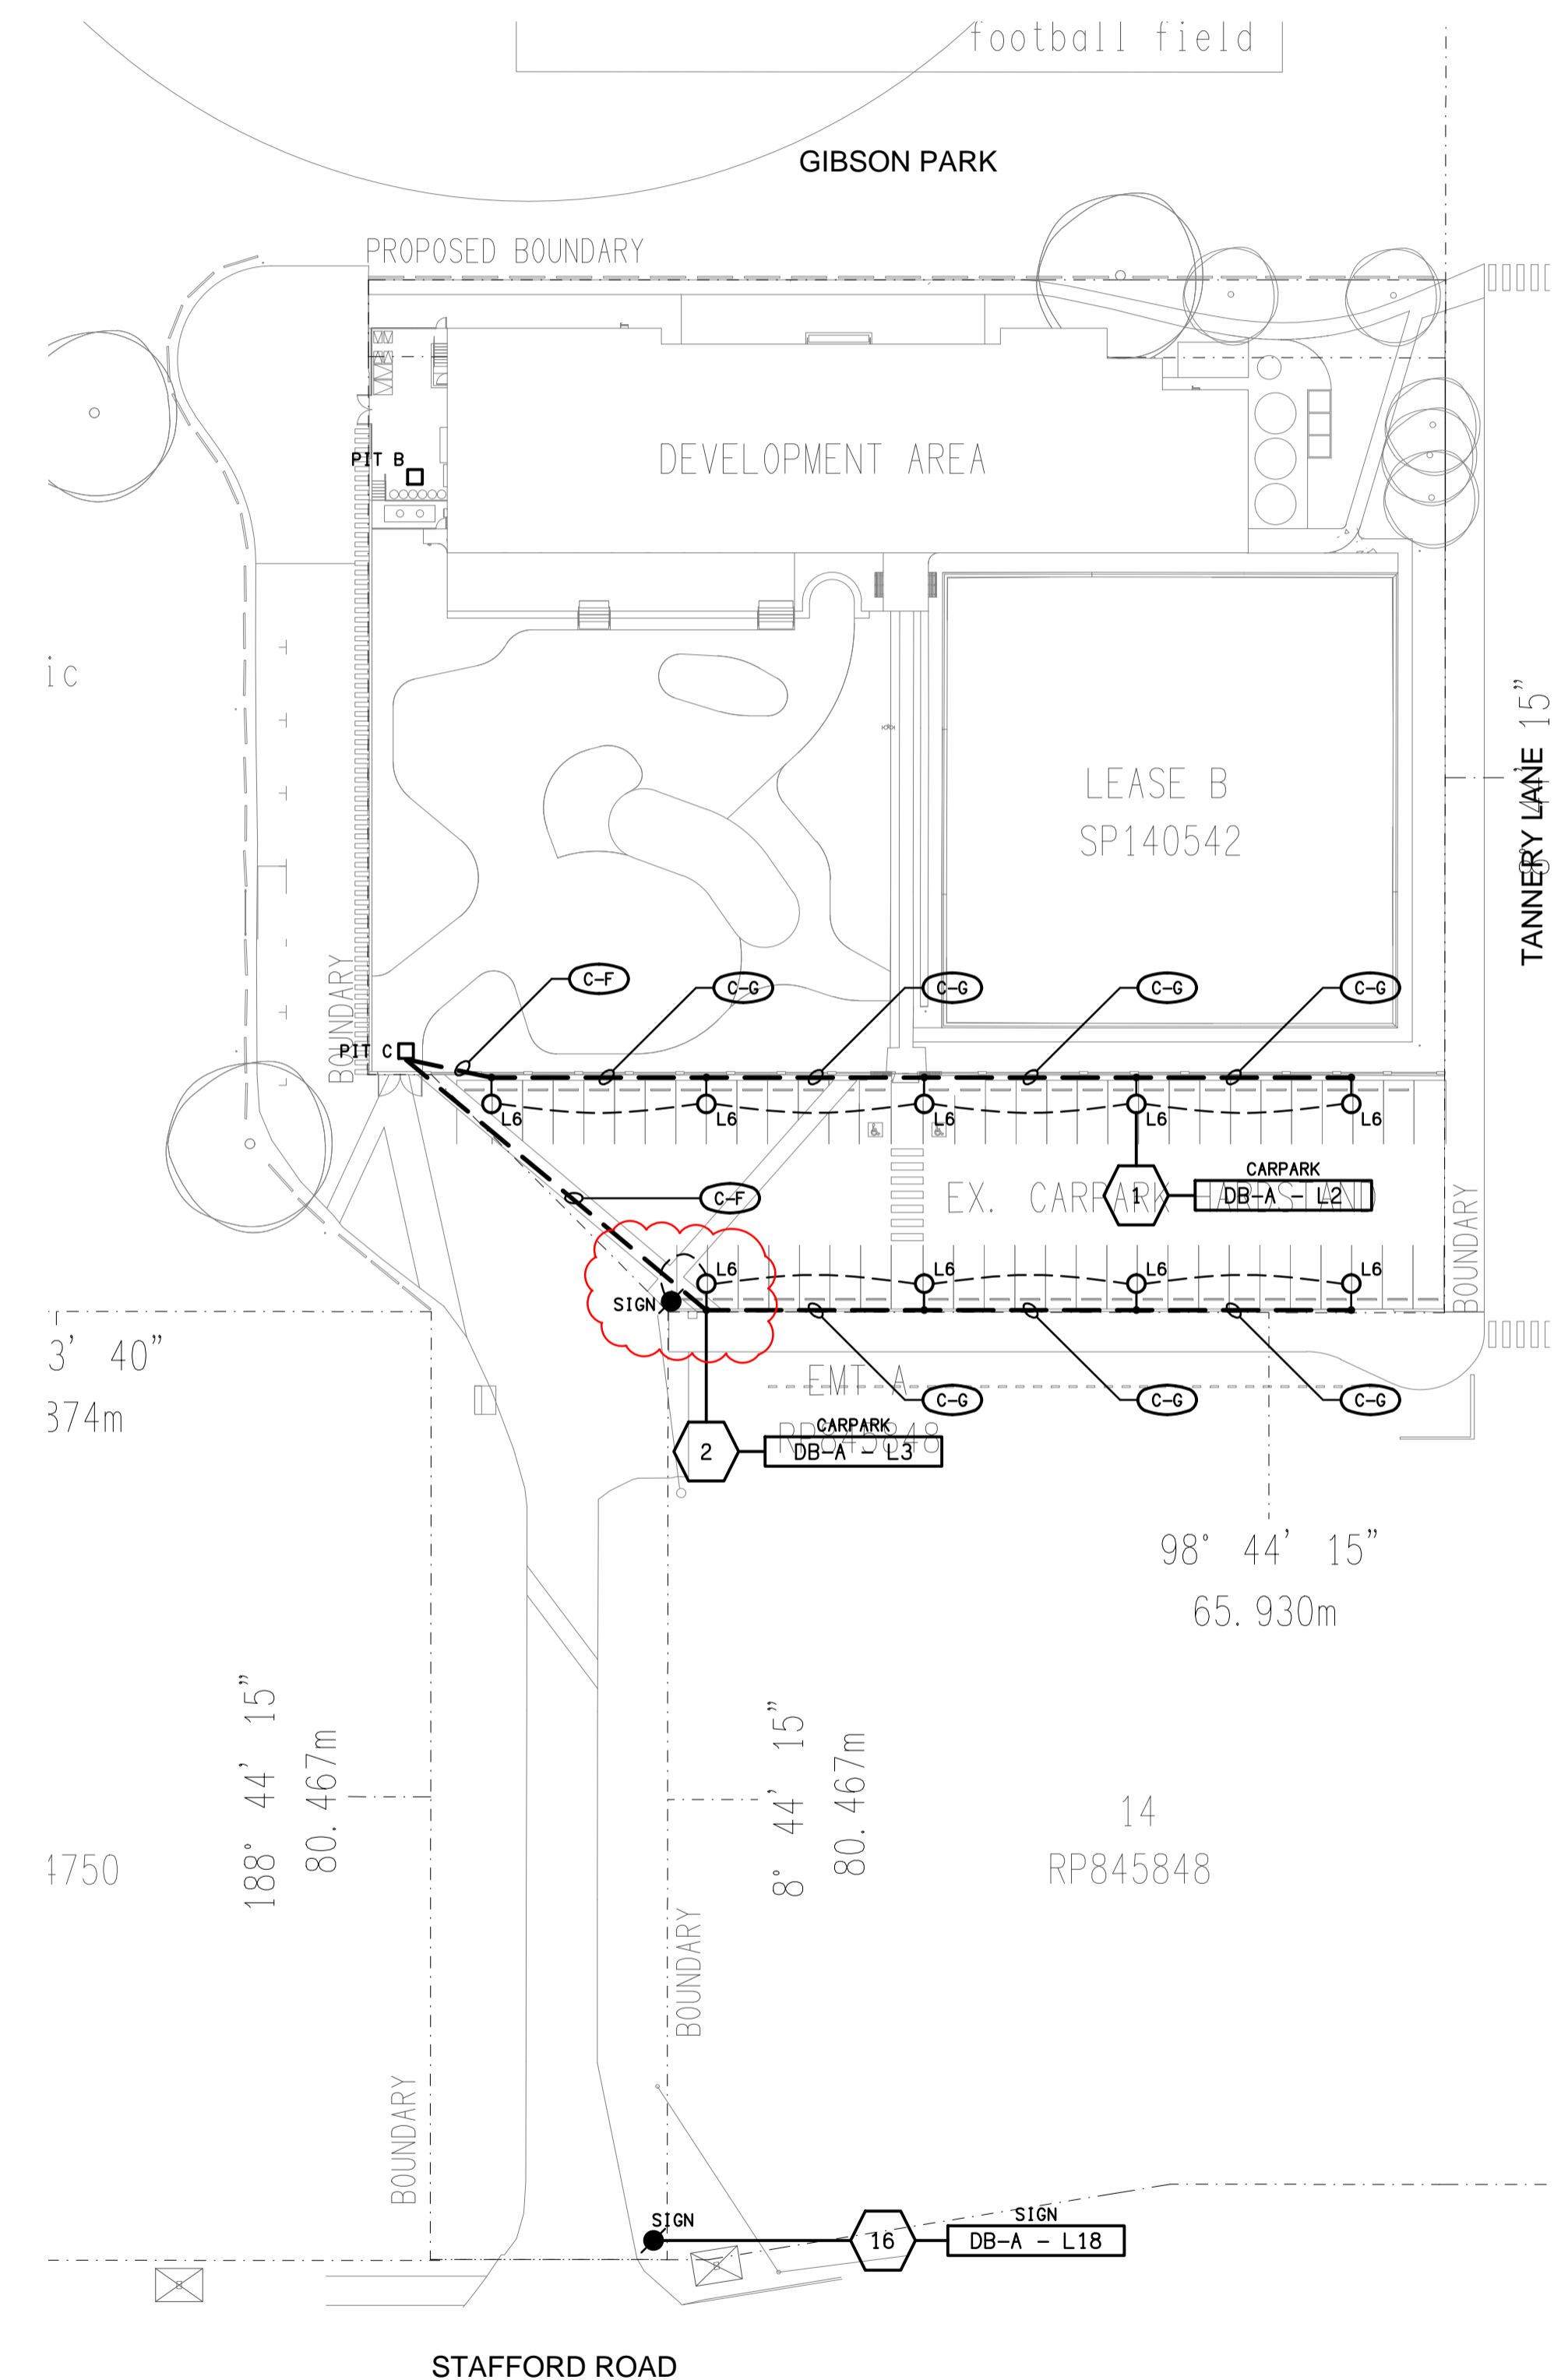

**SITE PLAN**  
CARPARK & DRIVEWAY LIGHTING  
SCALE 1: 500

ELECTRICAL DESIGN GROUP BRISBANE  
PTY LTD  
ACN 092 710 793  
TRADING AS:  
ELECTRICAL DESIGN GROUP

THE COPYRIGHT OF THIS DRAWING  
REMAINS THE PROPERTY OF THE  
ELECTRICAL DESIGN GROUP.  
USE FIGURED DIMENSIONS  
IN PREFERENCE TO SCALE.  
ALL DIMENSIONS TO BE  
VERIFIED ONSITE.

**ELECTRICAL DESIGN GROUP**  
ELECTRICAL BUILDING SERVICES CONSULTANTS  
BRISBANE GOLD COAST  
P.O. Box 15, Sherwood Q.4075  
Phone: (07) 3278 4375  
Email: brisbane@edg.net.au  
Web: www.edg.net.au

PROJECT:  
**STAFFORD COMMUNITY CLUB**  
352 STAFFORD ROAD, STAFFORD

G	CONSTRUCTION	07/03/2024
REV:	DESCRIPTION:	DATE:
DRAWING: <b>ELECTRICAL SERVICES LEGEND &amp; LIGHTING SITE PLAN</b>		
SCALE: 1:500	PROJECT NO: <b>C2791a</b>	DRAWING NO: <b>E01</b>
AT A1	REVISION: <b>G</b>	