


REFER DRAWING C2791a-E09 FOR CONTINUATION OF CONDUITS

PART SITE PLAN
 BOLLARD OUTLETS, PIT & CONDUITS
 SCALE 1:200

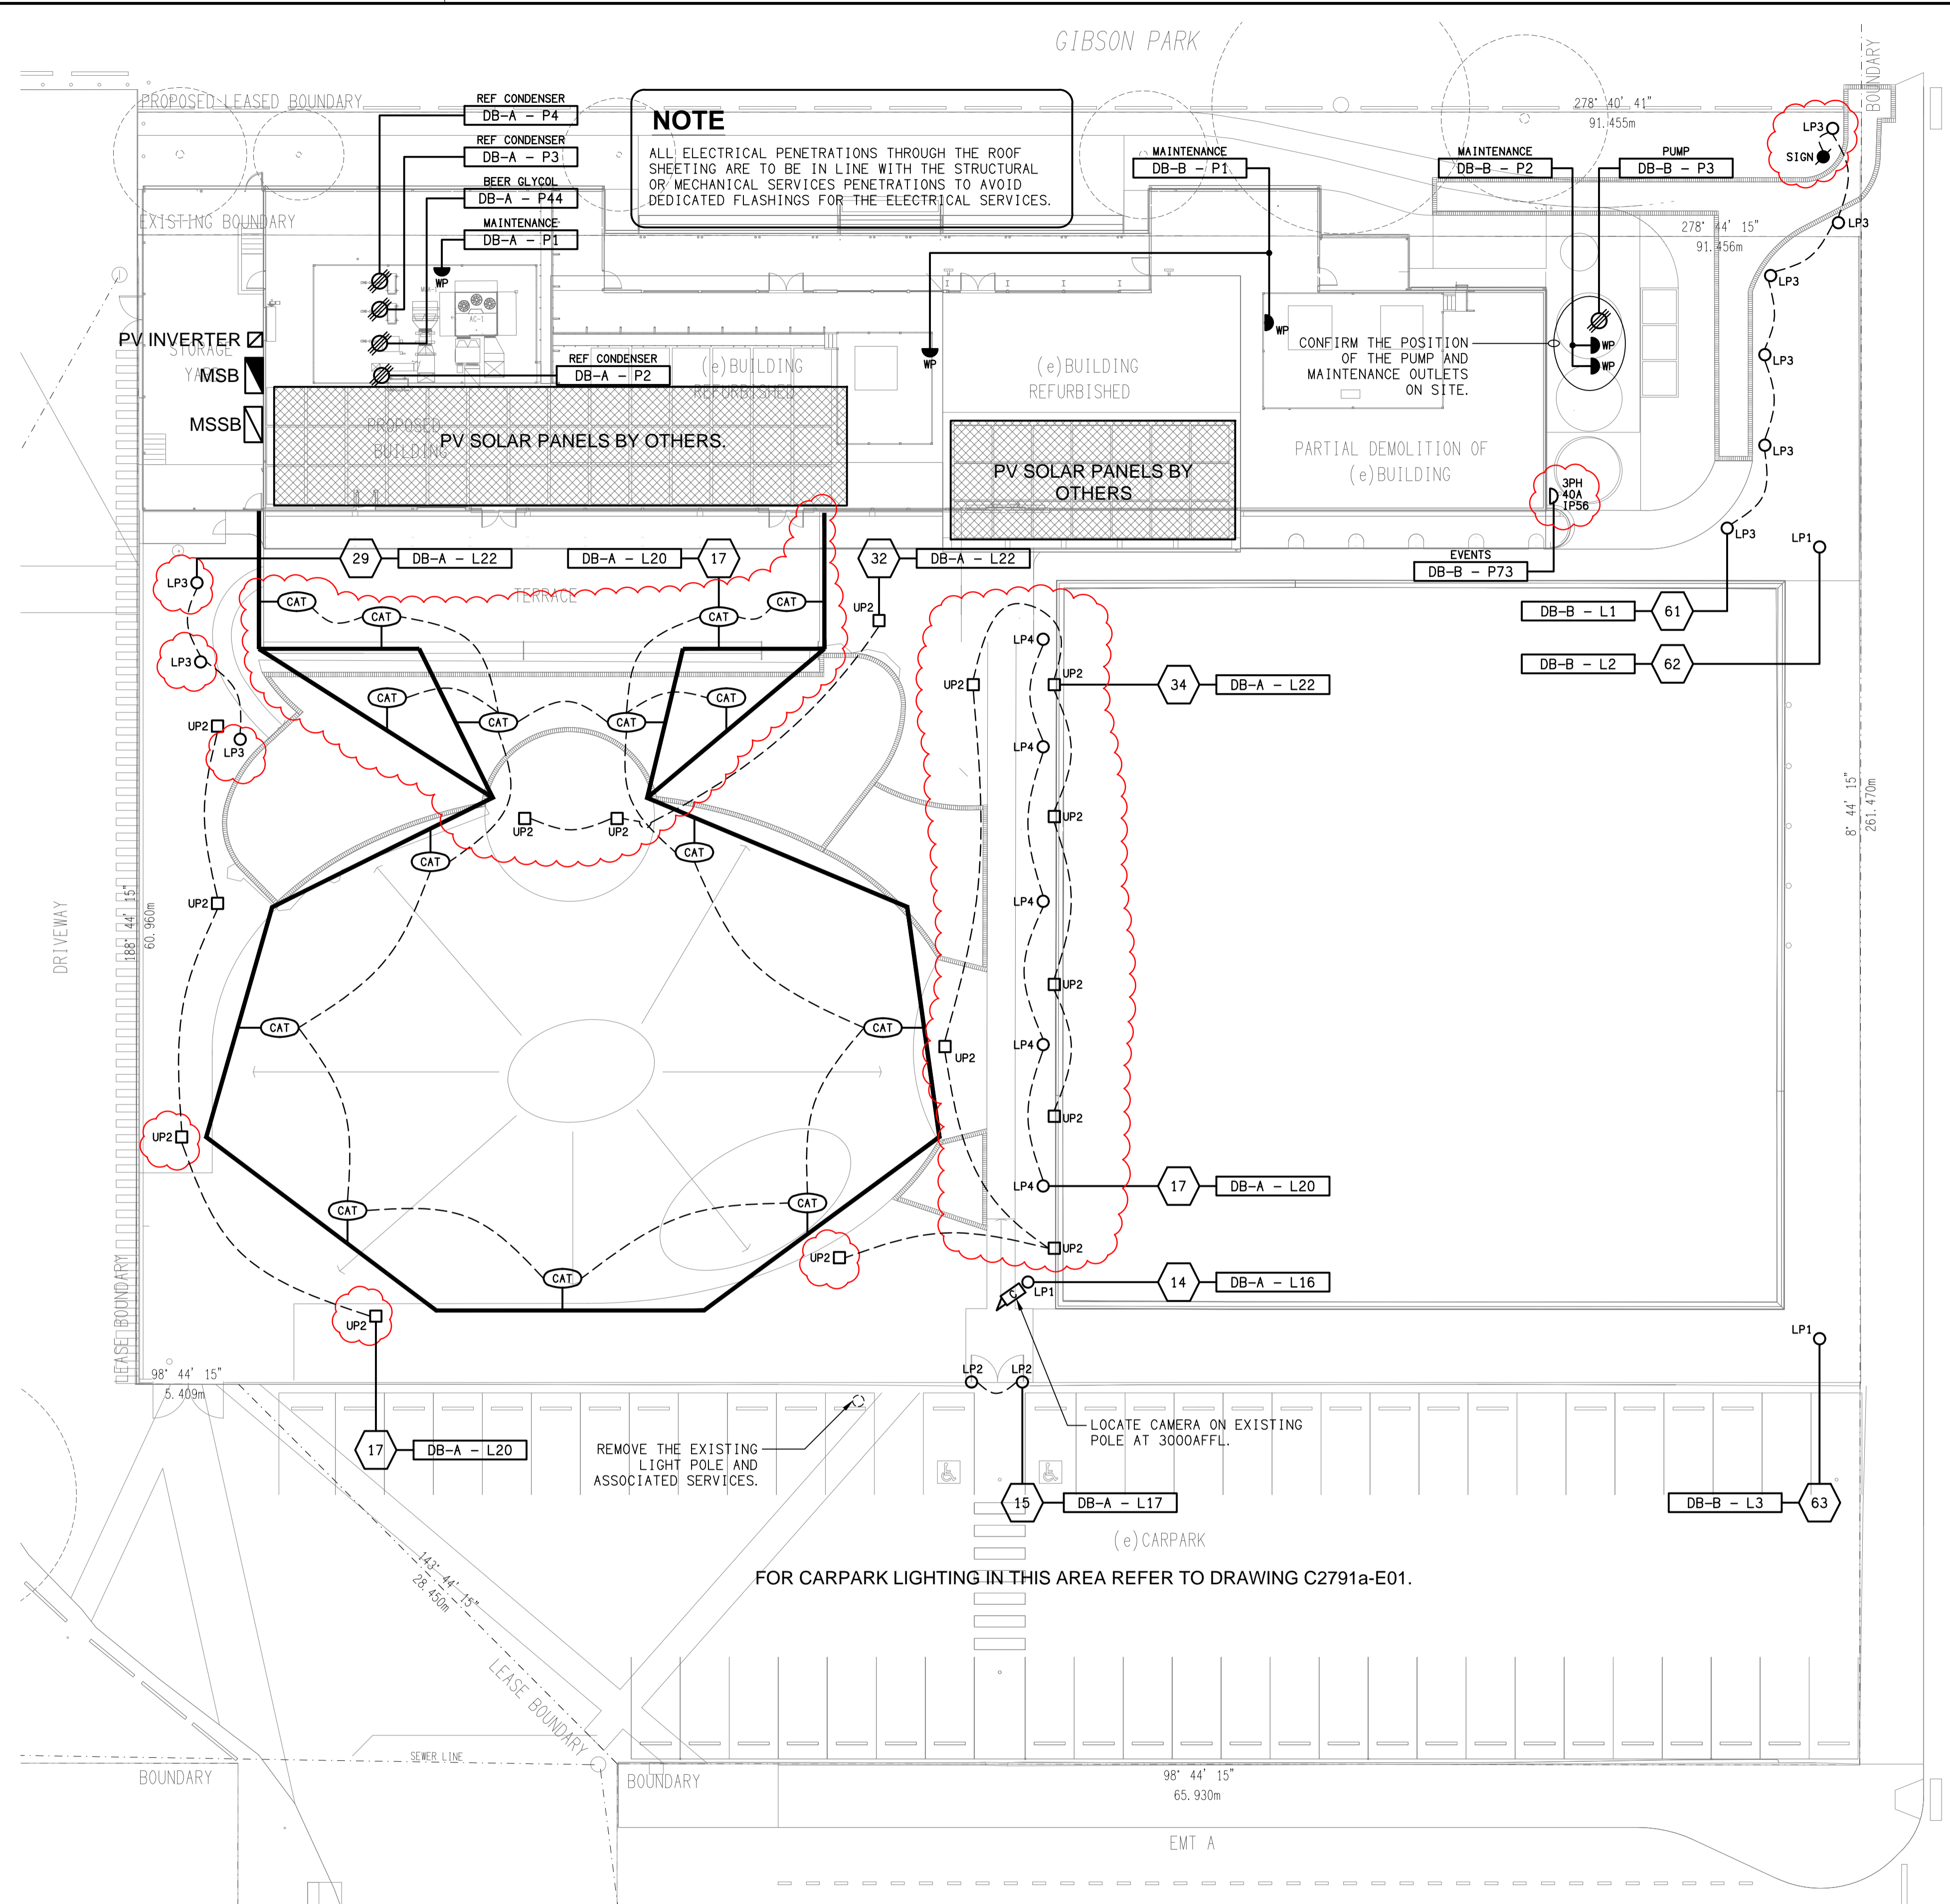

SITE PLAN
 LANDSCAPE LIGHTING & ROOF
 SCALE 1:200

ELECTRICAL DESIGN GROUP BRISBANE PTY LTD
 ACN 092 710 793
 TRADING AS:
 ELECTRICAL DESIGN GROUP

THE COPYRIGHT OF THIS DRAWING REMAINS THE PROPERTY OF THE ELECTRICAL DESIGN GROUP.
 USE FIGURED DIMENSIONS IN PREFERENCE TO SCALE.
 ALL DIMENSIONS TO BE VERIFIED ONSITE.

ELECTRICAL DESIGN GROUP
 ELECTRICAL BUILDING SERVICES CONSULTANTS
 BRISBANE GOLD COAST
 P.O. Box 15, Sherwood Q.4075
 Phone: (07) 3278 4375
 Email: brisbane@edg.net.au
 Web: www.edg.net.au

PROJECT:
STAFFORD COMMUNITY CLUB
 352 STAFFORD ROAD, STAFFORD

K	CONSTRUCTION	07/03/2024
REV:	DESCRIPTION:	DATE:
DRAWING: ELECTRICAL SERVICES SITE PLAN		
SCALE: 1:200	PROJECT NO: C2791a	DRAWING NO: E02
AT A1	REVISION: K	