


DETAIL A
ELECTRICAL EQUIPMENT ELEVATION
SCALE 1:50

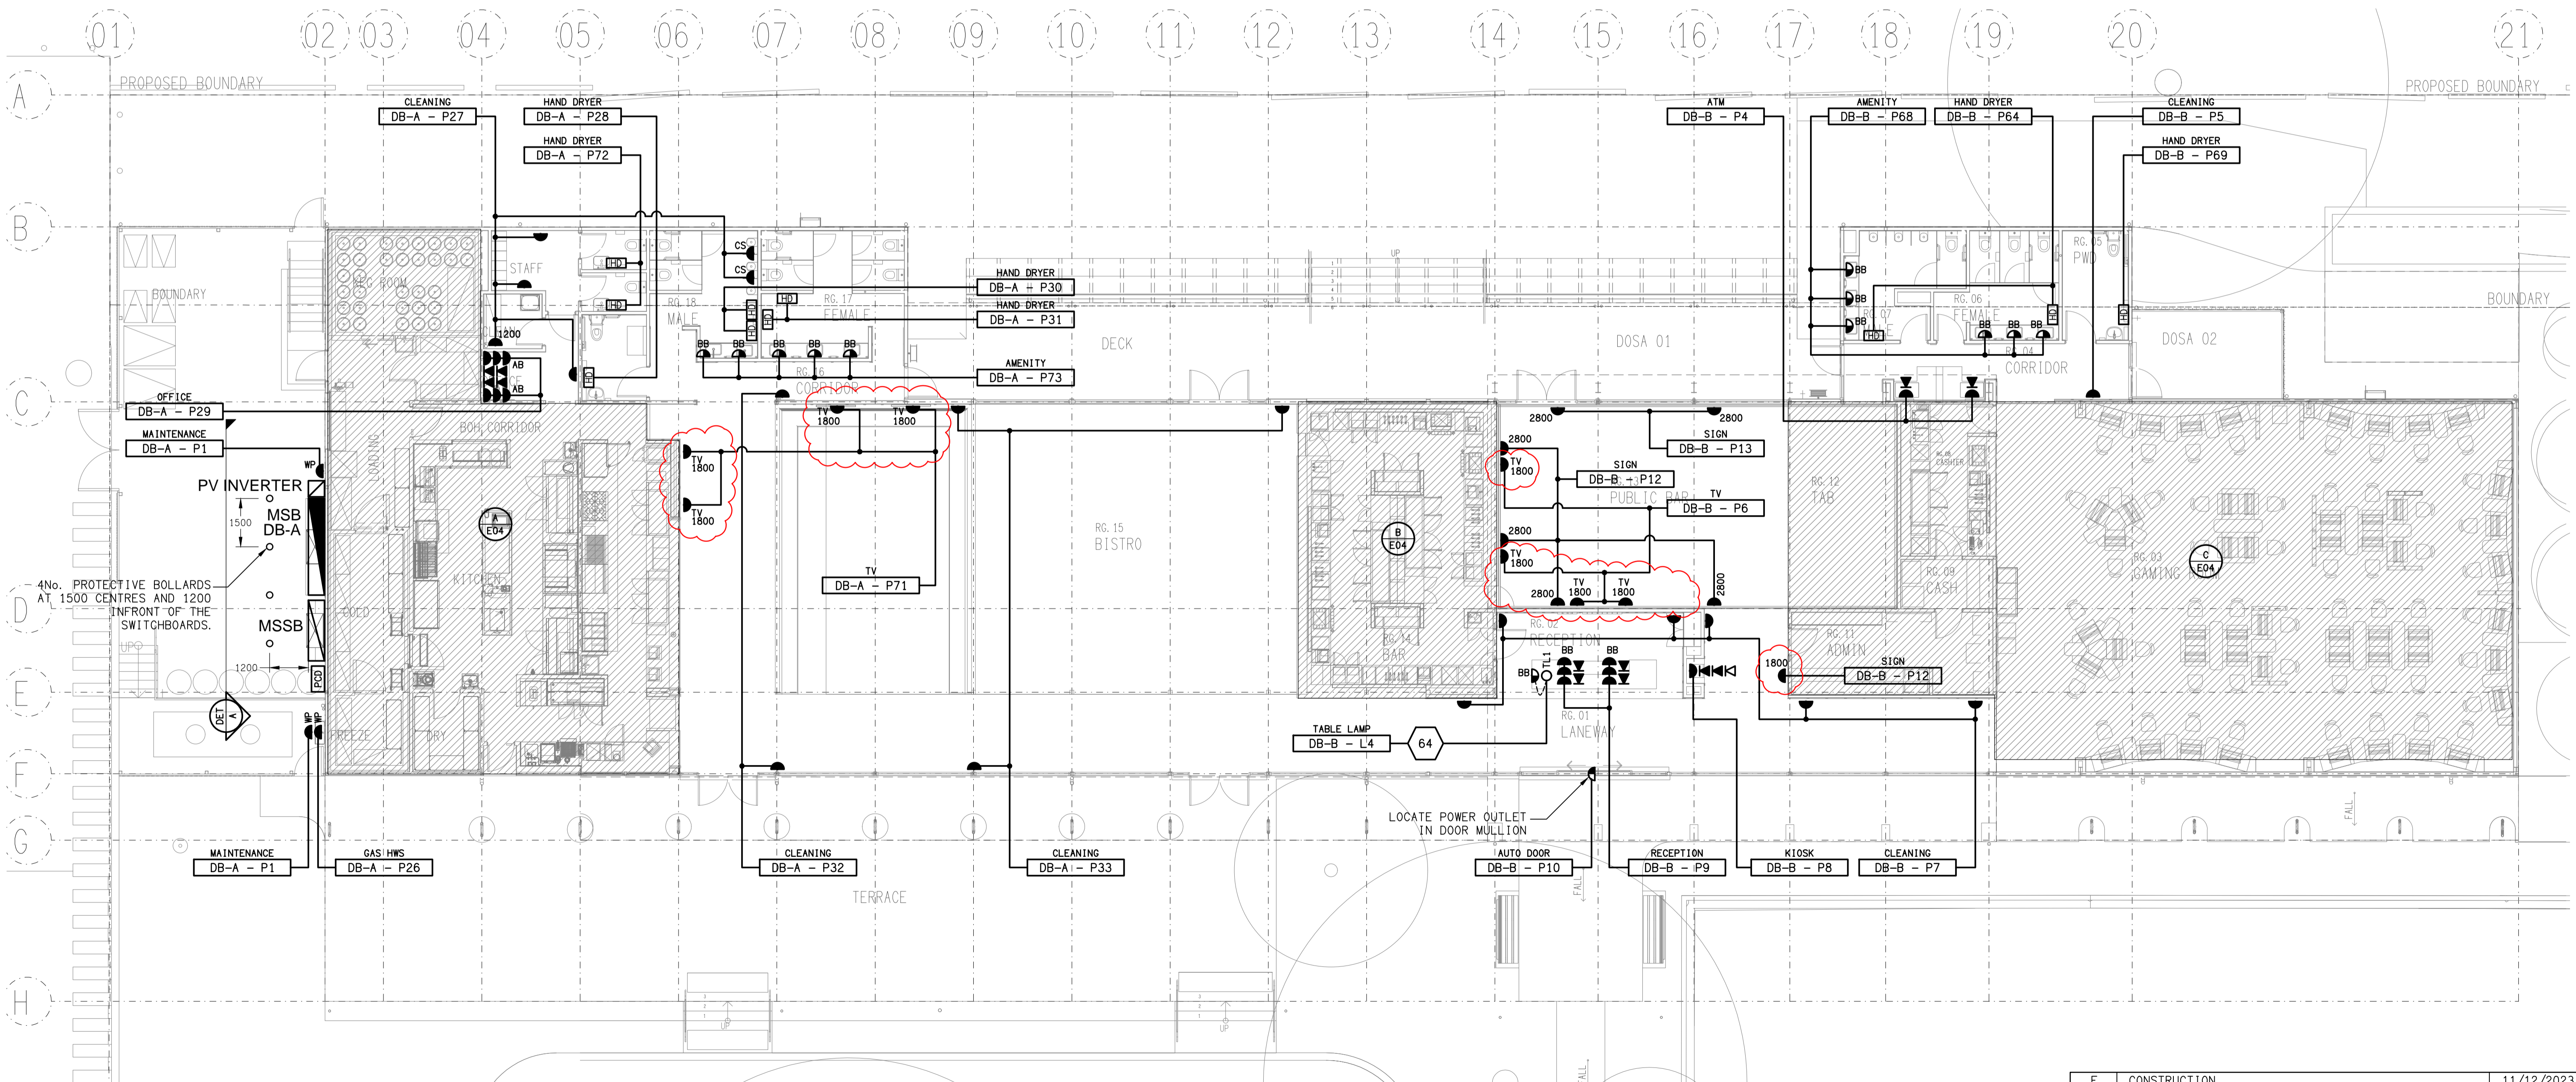

ELECTRICAL DESIGN GROUP BRISBANE
PTY LTD
ACN 092 710 793
TRADING AS:
ELECTRICAL DESIGN GROUP

THE COPYRIGHT OF THIS DRAWING
REMAINS THE PROPERTY OF THE
ELECTRICAL DESIGN GROUP.
USE FIGURED DIMENSIONS
IN PREFERENCE TO SCALE.
ALL DIMENSIONS TO BE
VERIFIED ONSITE.

ELECTRICAL DESIGN GROUP
ELECTRICAL BUILDING SERVICES CONSULTANTS
BRISBANE GOLD COAST
P.O. Box 15, Sherwood Q.4075
Phone: (07) 3278 4375
Email: brisbane@edg.net.au
Web: www.edg.net.au

PROJECT:
STAFFORD COMMUNITY CLUB
352 STAFFORD ROAD, STAFFORD

E	CONSTRUCTION	11/12/2023
REV.	DESCRIPTION:	DATE:
DRAWING: ELECTRICAL SERVICES FLOOR PLAN		
SCALE: 1:100 UNO	AT A1	PROJECT NO: C2791a
		DRAWING NO: E03
		REVISION: E