
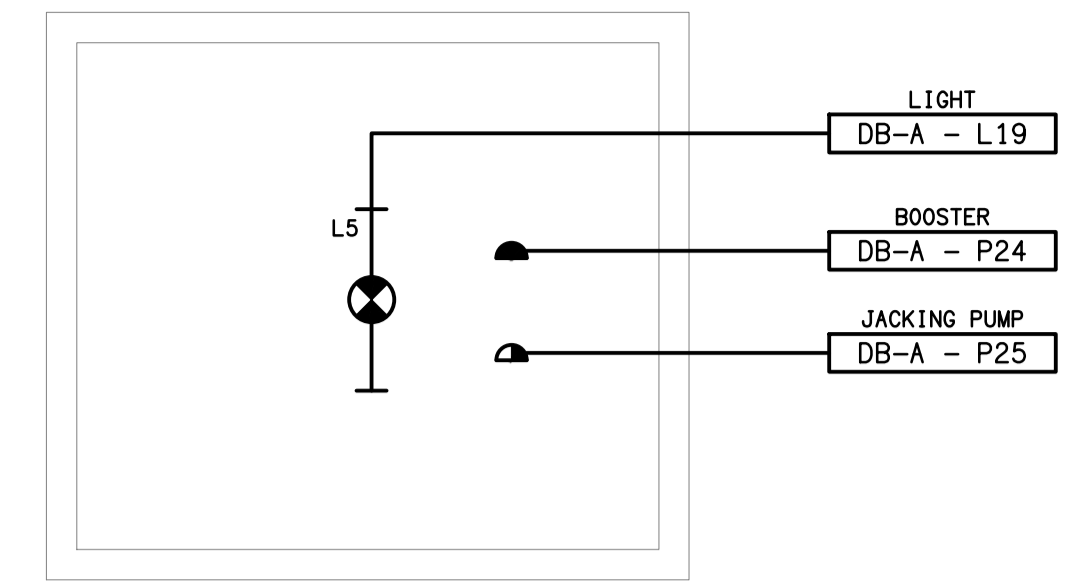


THEODORE STREET

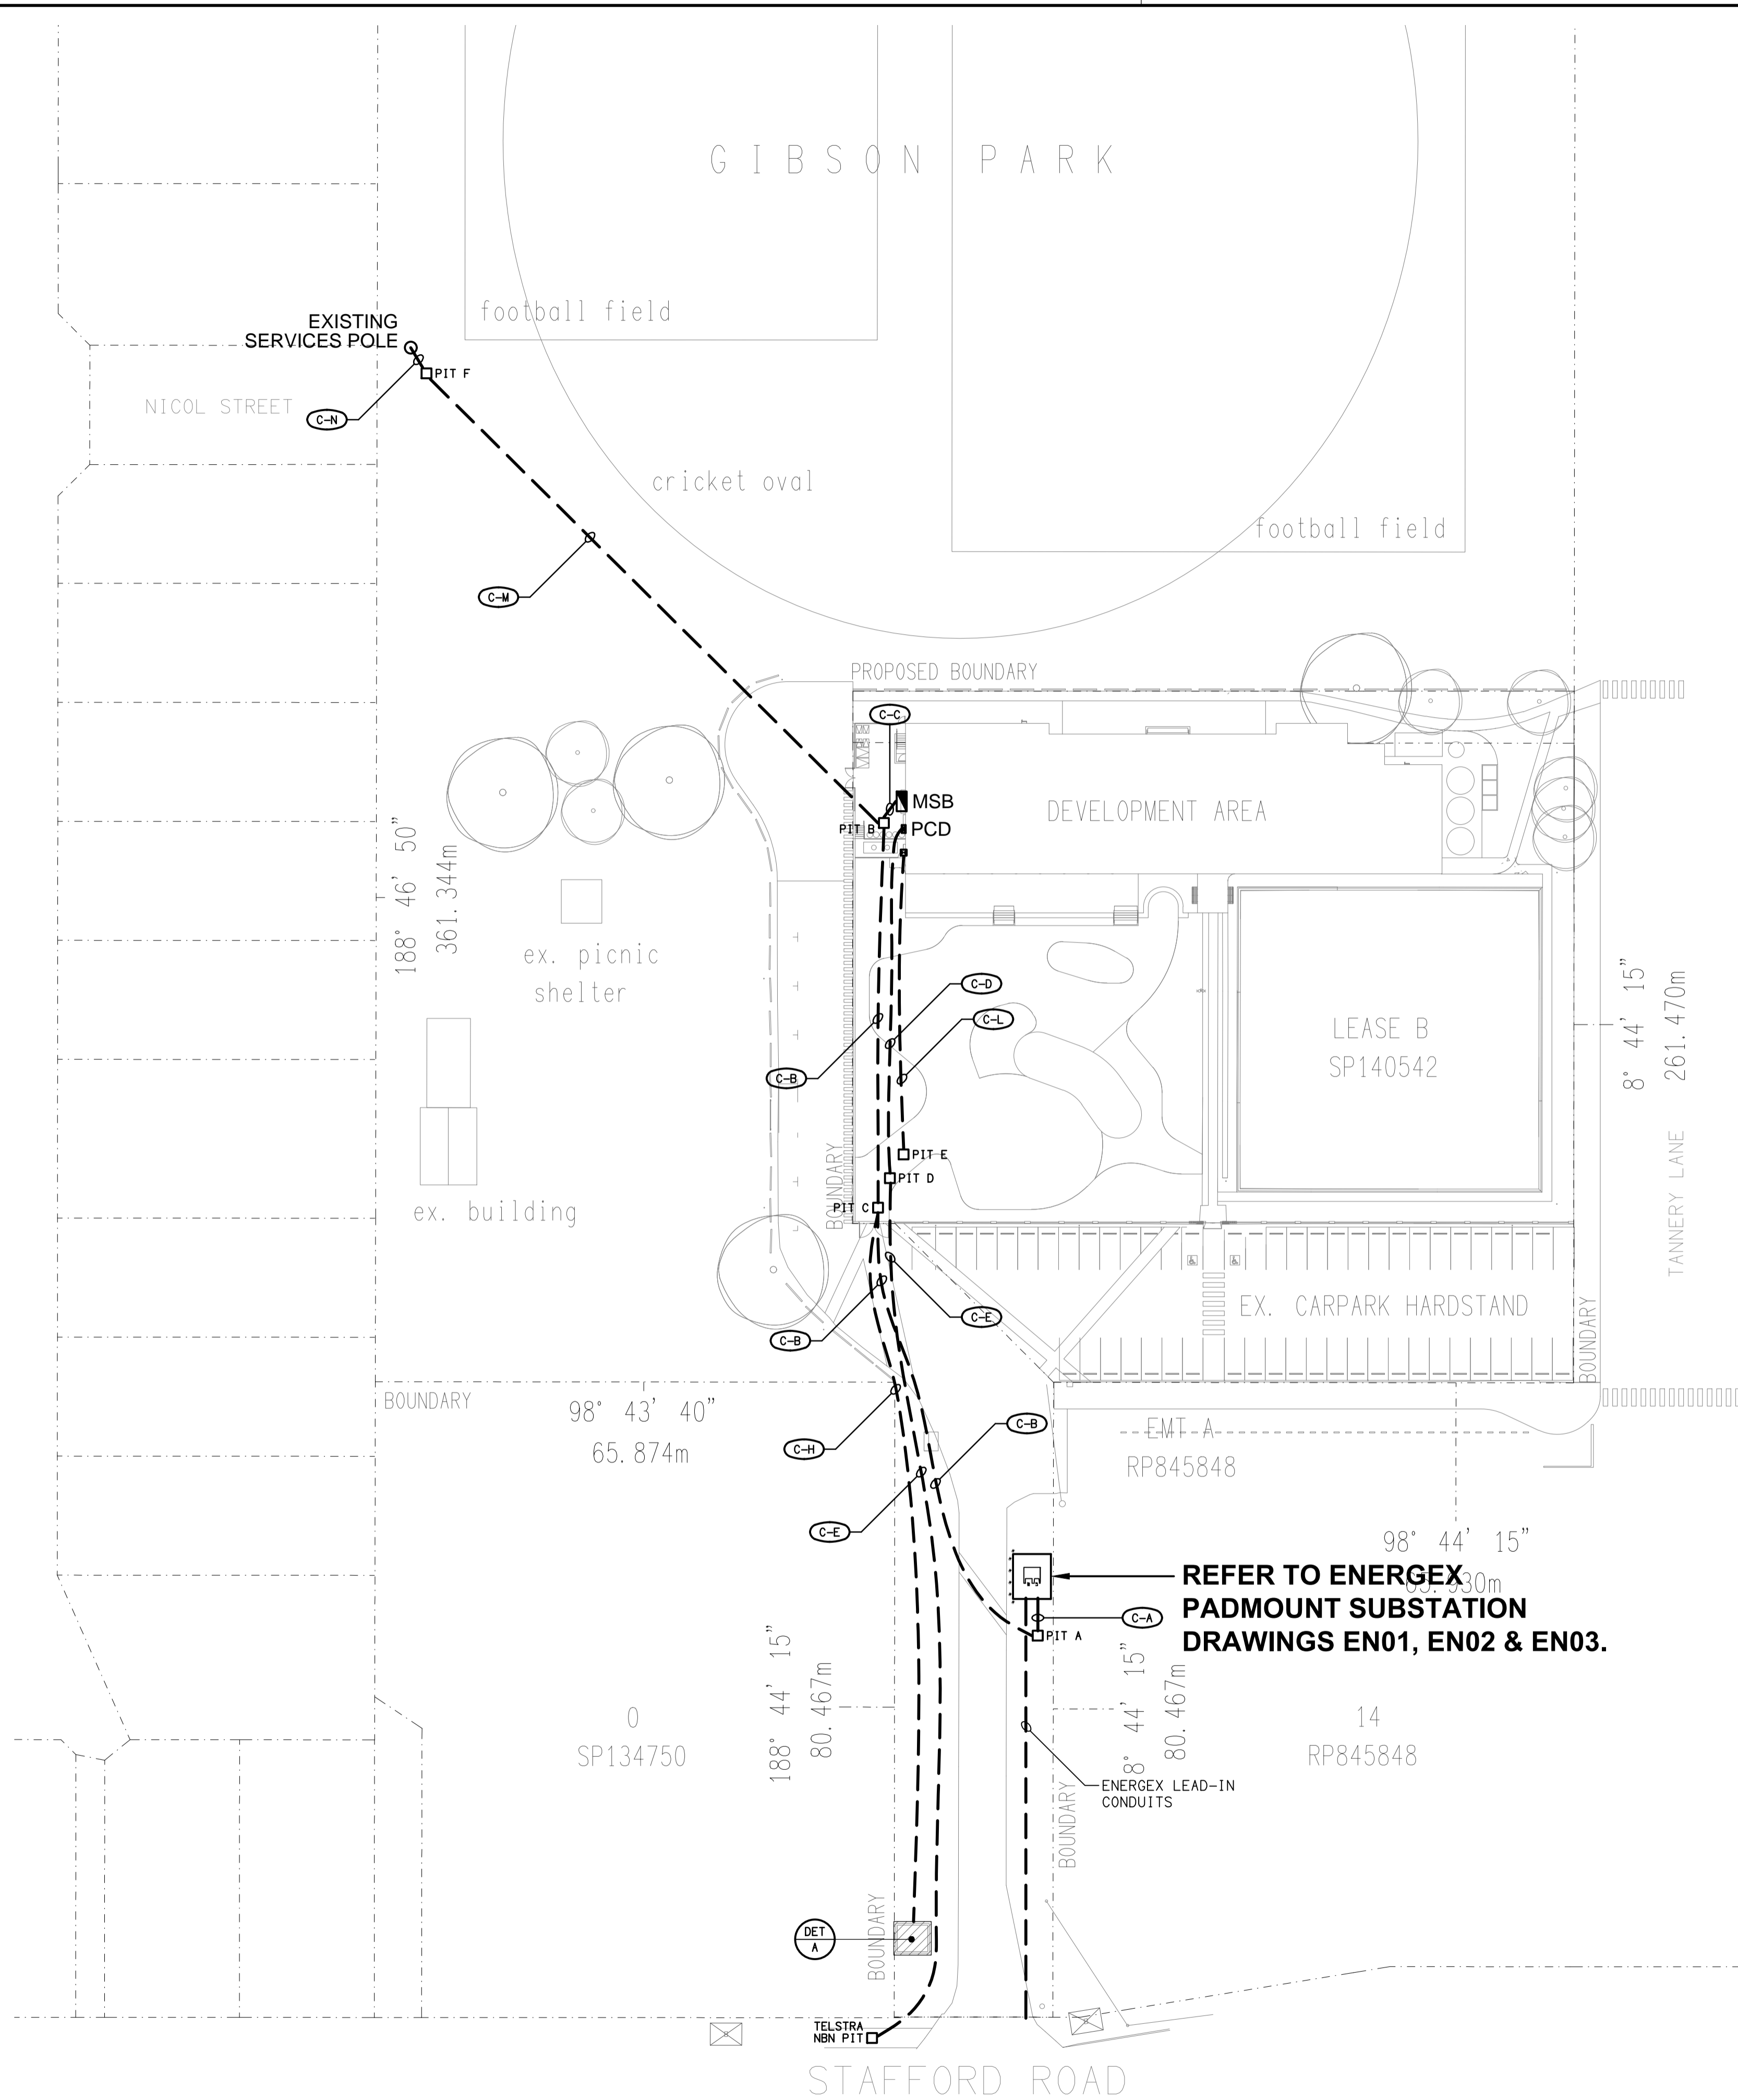

**DETAIL A**  
BOOSTER CABINET PLAN  
SCALE 1:50

**REFER TO ENERGEX  
PADMOUNT SUBSTATION  
DRAWINGS EN01, EN02 & EN03.**

ELECTRICAL DESIGN GROUP BRISBANE  
PTY LTD  
ACN 092 710 793  
TRADING AS:  
ELECTRICAL DESIGN GROUP

THE COPYRIGHT OF THIS DRAWING  
REMAINS THE PROPERTY OF THE  
ELECTRICAL DESIGN GROUP.  
USE FIGURED DIMENSIONS  
IN PREFERENCE TO SCALE.  
ALL DIMENSIONS TO BE  
VERIFIED ONSITE.

**ELECTRICAL DESIGN GROUP**  
ELECTRICAL BUILDING SERVICES CONSULTANTS  
BRISBANE GOLD COAST

P.O. Box 15, Sherwood Q.4075  
Phone: (07) 3278 4375  
Email: brisbane@edg.net.au  
Web: www.edg.net.au

PROJECT:  
**STAFFORD COMMUNITY CLUB**

352 STAFFORD ROAD, STAFFORD

B	CONSTRUCTION	17/08/2023
REV.	DESCRIPTION:	DATE:

DRAWING:  
**ELECTRICAL SERVICES  
CONDUIT & PIT SITE PLAN**

SCALE:  
1:500

AT A1

PROJECT NO:  
**C2791a**

DRAWING NO:  
**E09**

REVISION:  
**B**