
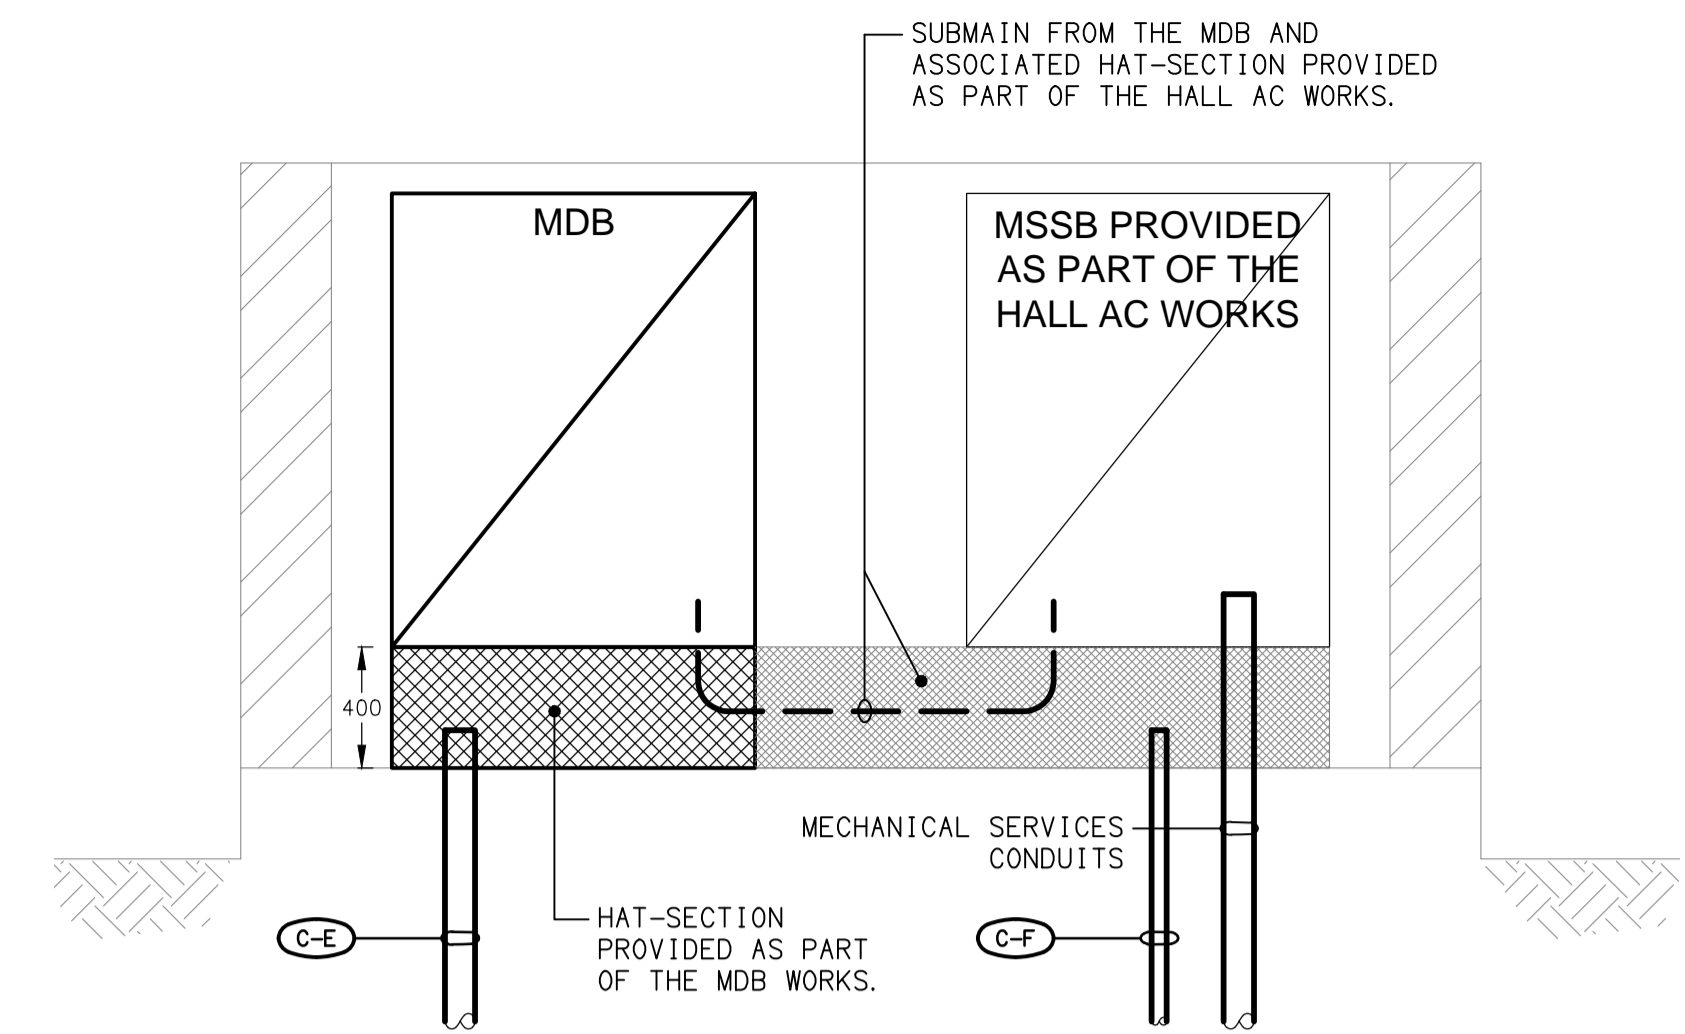


MORINDO DRIVE

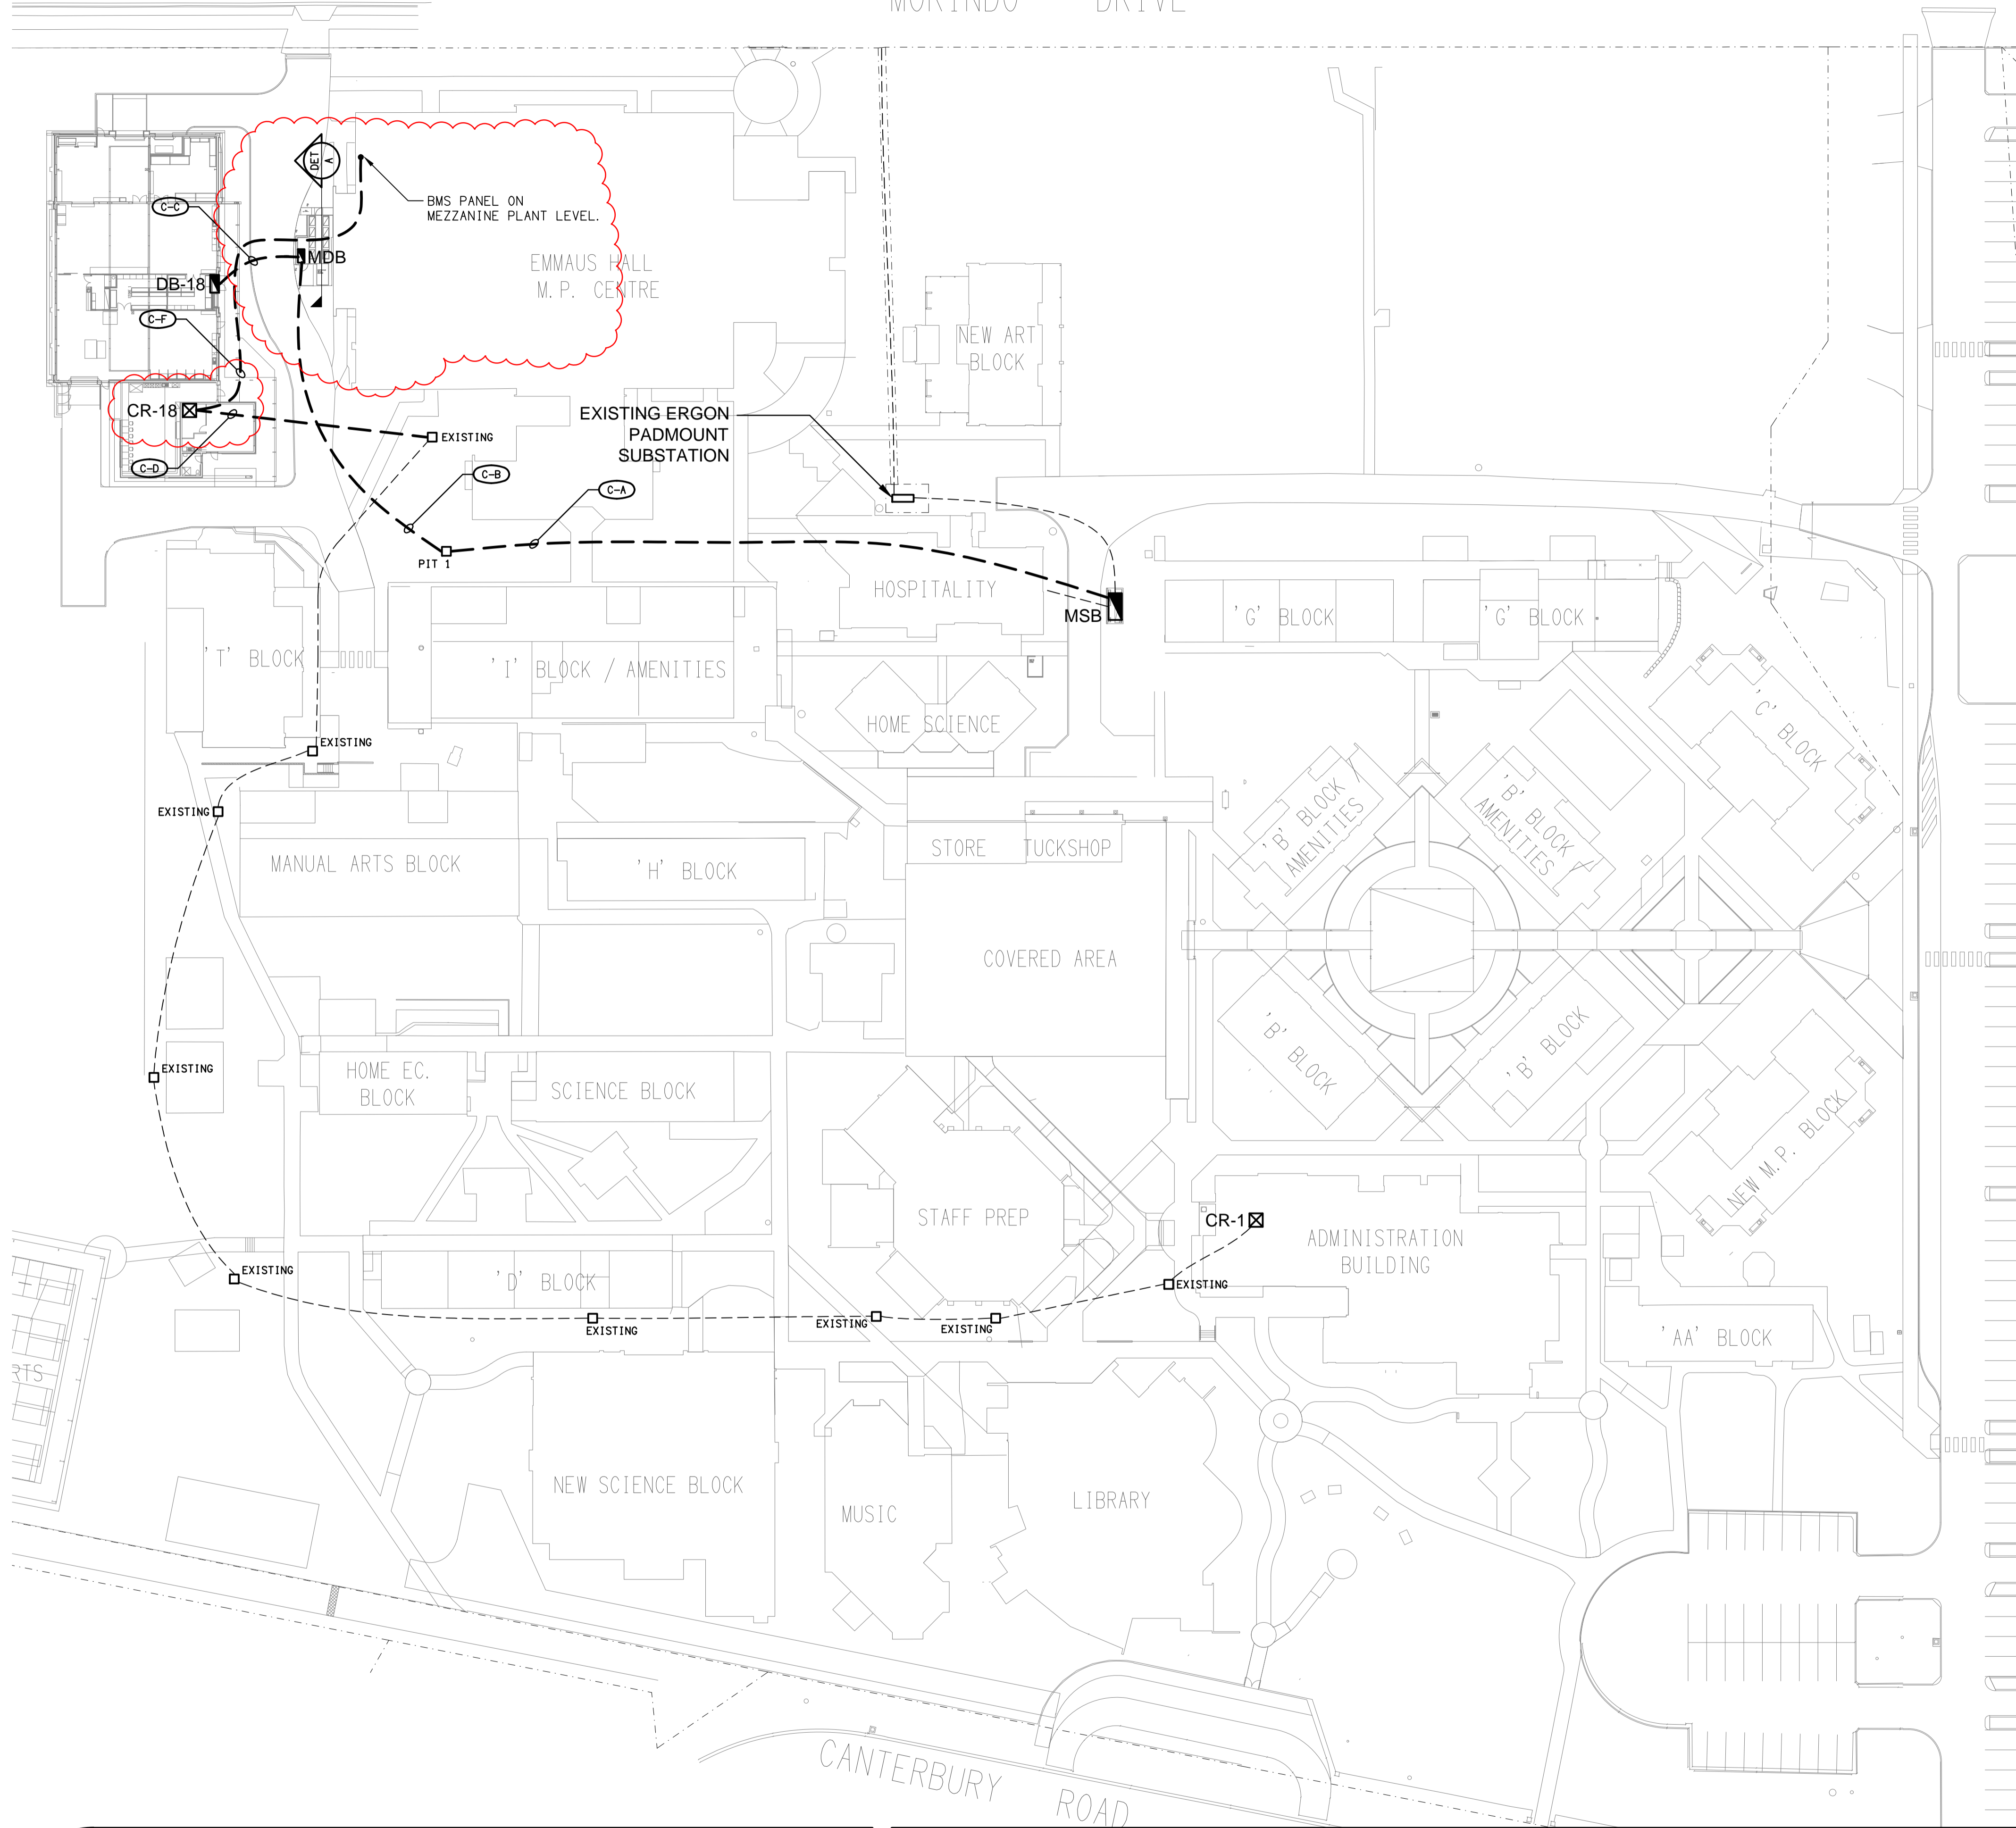


DETAIL A
MDB ELEVATION
NOT TO SCALE

CANTERBURY ROAD

REV	DATE	DESCRIPTION
D	19/09/2022	TENDER
E	24/11/2022	CONSTRUCTION
F	28/11/2022	CONSTRUCTION
G	02/03/2023	CONSTRUCTION
H	19/04/2023	CONSTRUCTION

ELECTRICAL DESIGN GROUP
ELECTRICAL BUILDING SERVICES CONSULTANTS
BRISBANE
P.O. Box 15, Sherwood Q. 4075
Phone: (07) 3278 4375
Email: brisbane@edg.net.au
Web: www.edg.net.au

CLIENT: THE ROMAN CATHOLIC TRUST CORPORATION FOR THE DIOCESE OF TOWNSVILLE
PROJECT: RYAN CATHOLIC COLLEGE, TECHNOLOGY CENTRE
DRAWING TITLE: ELECTRICAL SERVICES SITE PLAN
59 CANTERBURY ROAD, KIRWAN, QLD

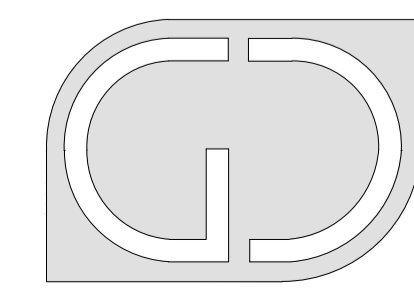

G+D GROUP (QLD)
Level 3 Toowong Terraces
31 Sherwood Road Toowong Q 4066
T (07) 3870 3722
F (07) 3870 3822
E admin@gdgroupqld.com.au

DATE: _____
SCALE 1:500 AT A1
DRAWN: _____
CHECKED: _____

C2803a
EDG PROJECT No.
E02 H
EDG DWG No. REV