


FOR CONTINUATION OF FLOOR PLAN REFER TO ZONE B ON DRAWING E03

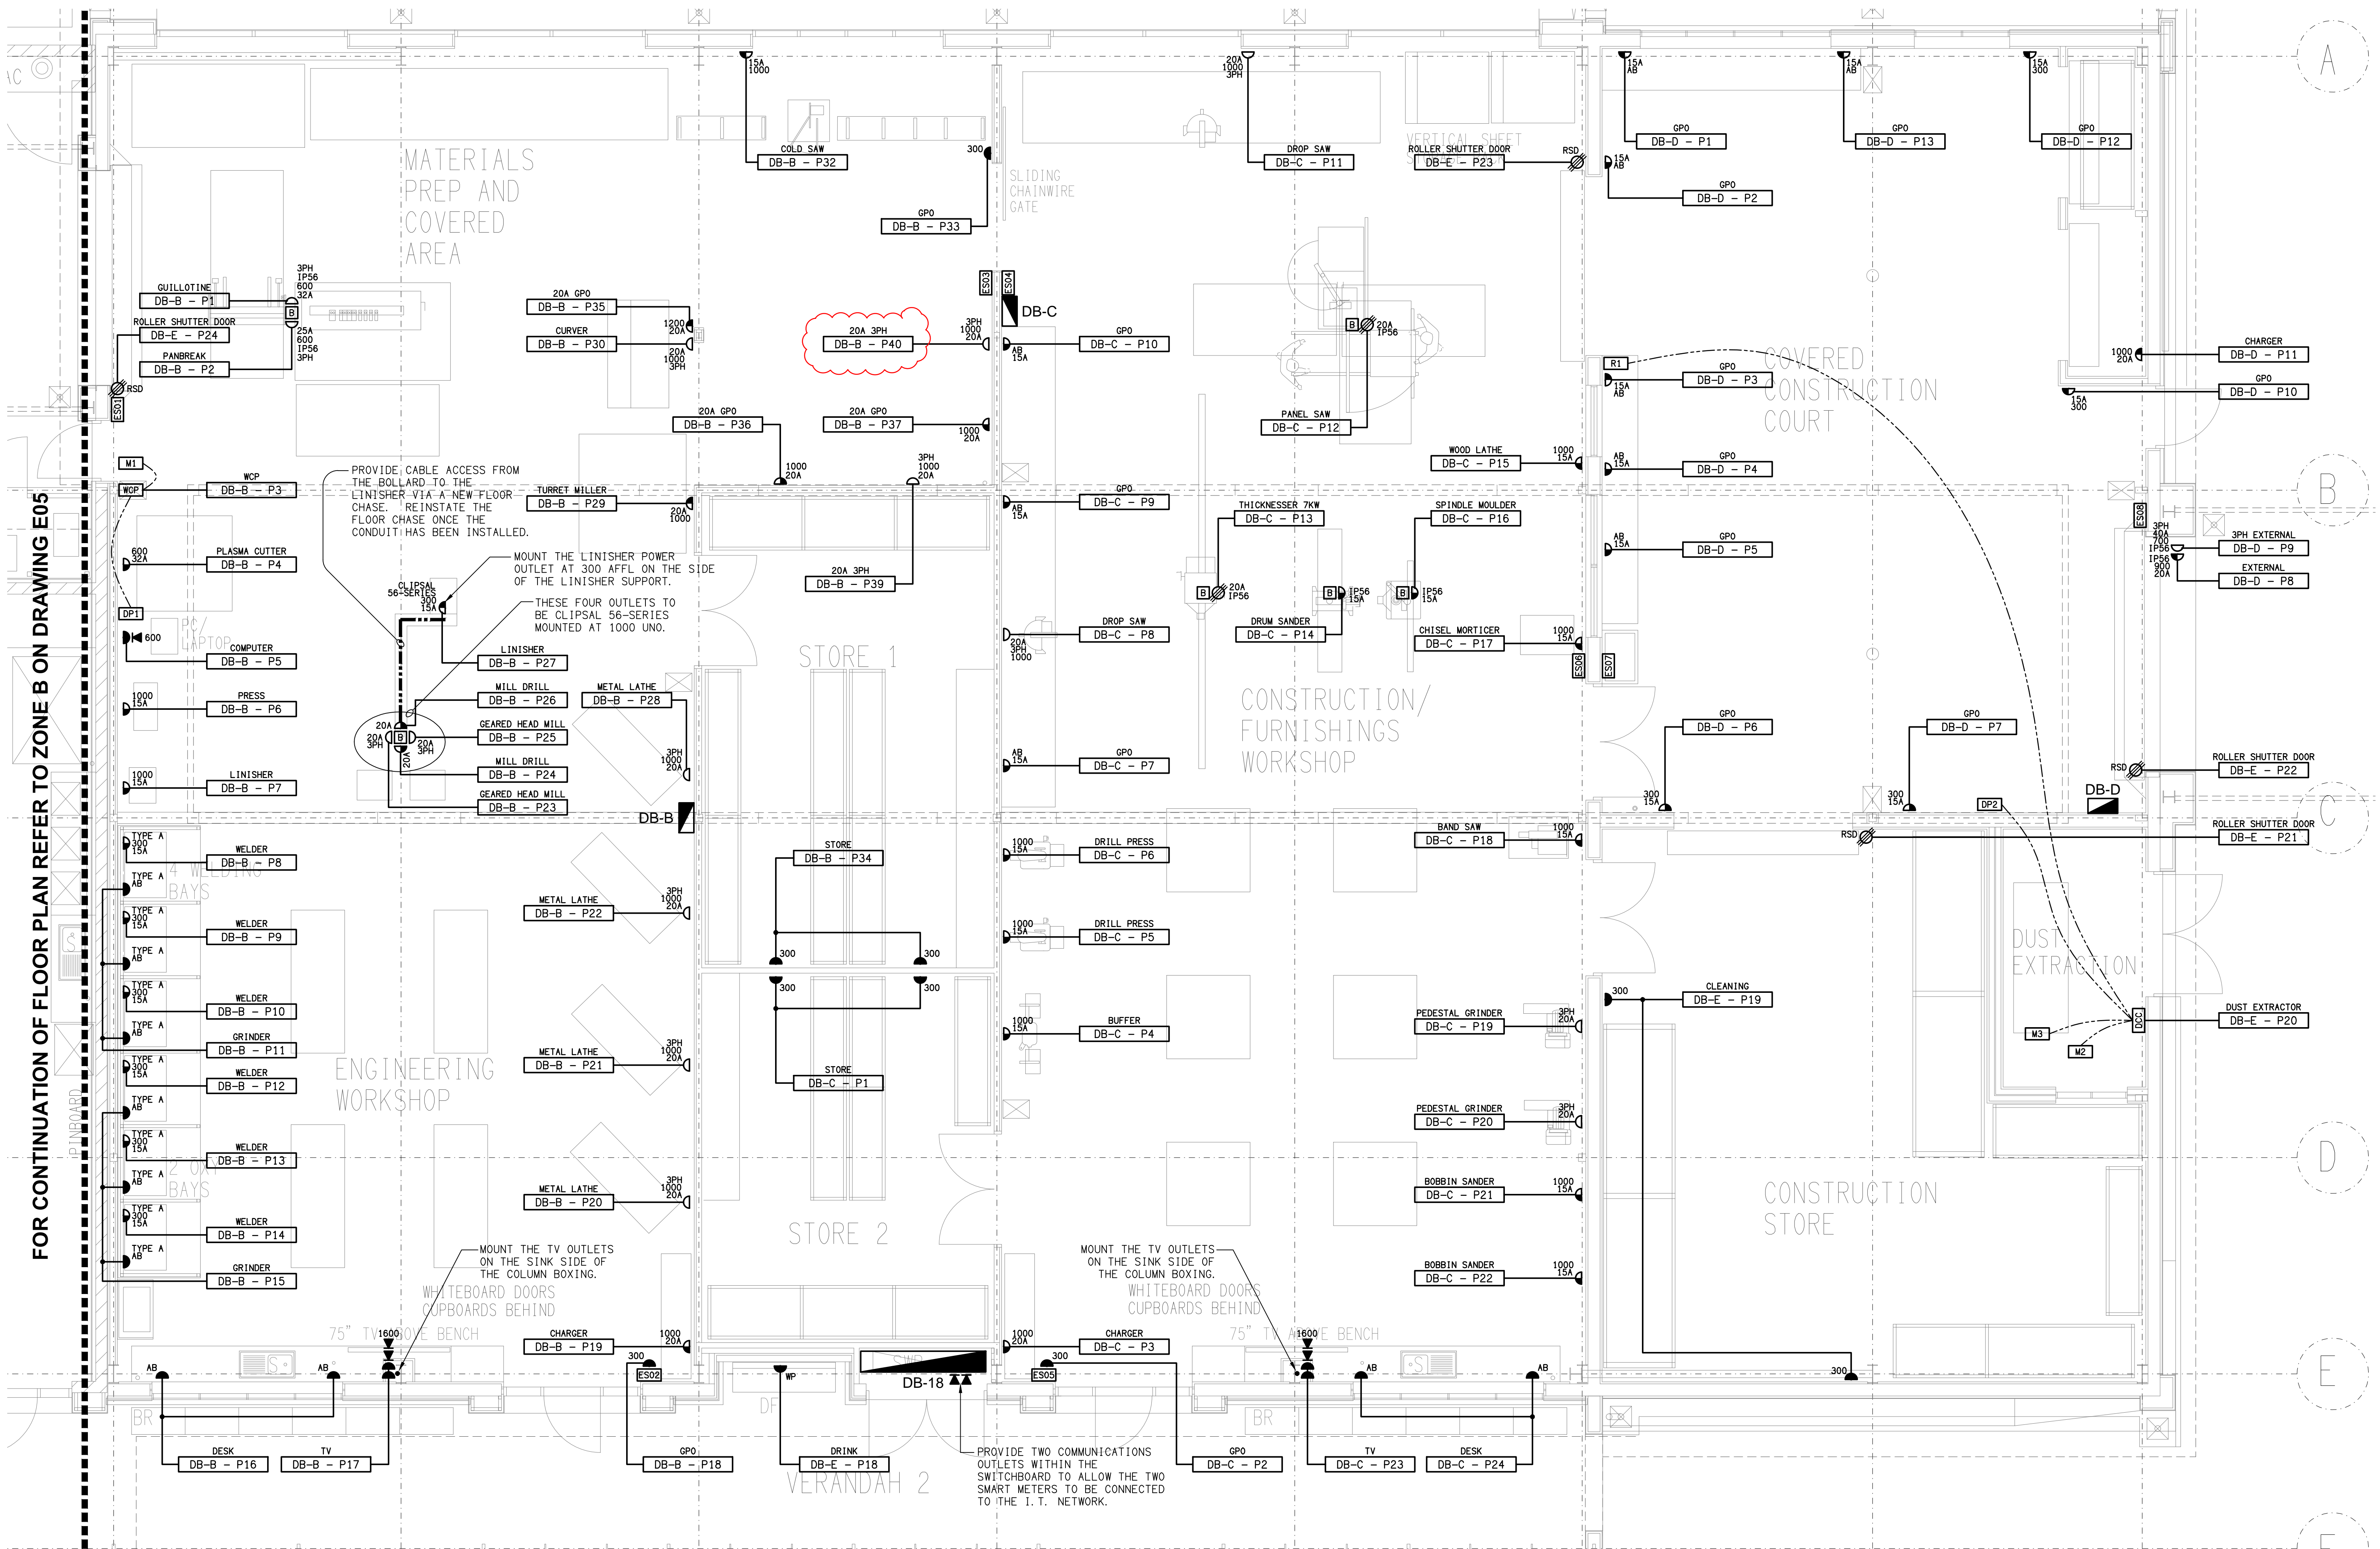

REV	DATE	DESCRIPTION
D	19/09/2022	TENDER
F	30/01/2023	CONSTRUCTION
G	16/03/2023	CONSTRUCTION
H	21/03/2023	CONSTRUCTION
J	27/03/2023	CONSTRUCTION
K	06/04/2023	CONSTRUCTION


ELECTRICAL DESIGN GROUP
 ELECTRICAL BUILDING SERVICES CONSULTANTS
 BRISBANE
 P.O. Box 15, Sherwood Q. 4075
 Phone: (07) 3278 4375
 Email: brisbane@edg.net.au
 Web: www.edg.net.au

CLIENT
THE ROMAN CATHOLIC TRUST CORPORATION FOR THE DIOCESE OF TOWNVILLE

PROJECT
RYAN CATHOLIC COLLEGE, TECHNOLOGY CENTRE

DRAWING TITLE
ELECTRICAL SERVICES FLOOR PLAN ZONE A

59 CANTERBURY ROAD, KIRWAN, QLD

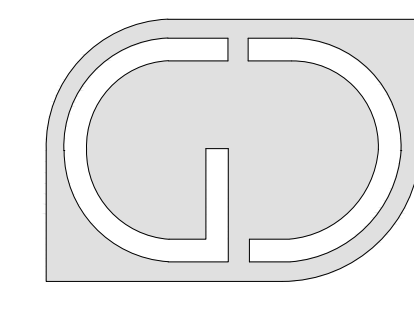

G+D GROUP (QLD)
 Level 3 Toowong Terraces
 31 Sherwood Road Toowong Q 4066
 T (07) 3870 3722
 F (07) 3870 3822
 E admin@gdgroupqld.com.au

DATE	SCALE	AT
	1:50	A1

C2803a
 EDG PROJECT No.
E04 K
 EDG DWG No. REV