

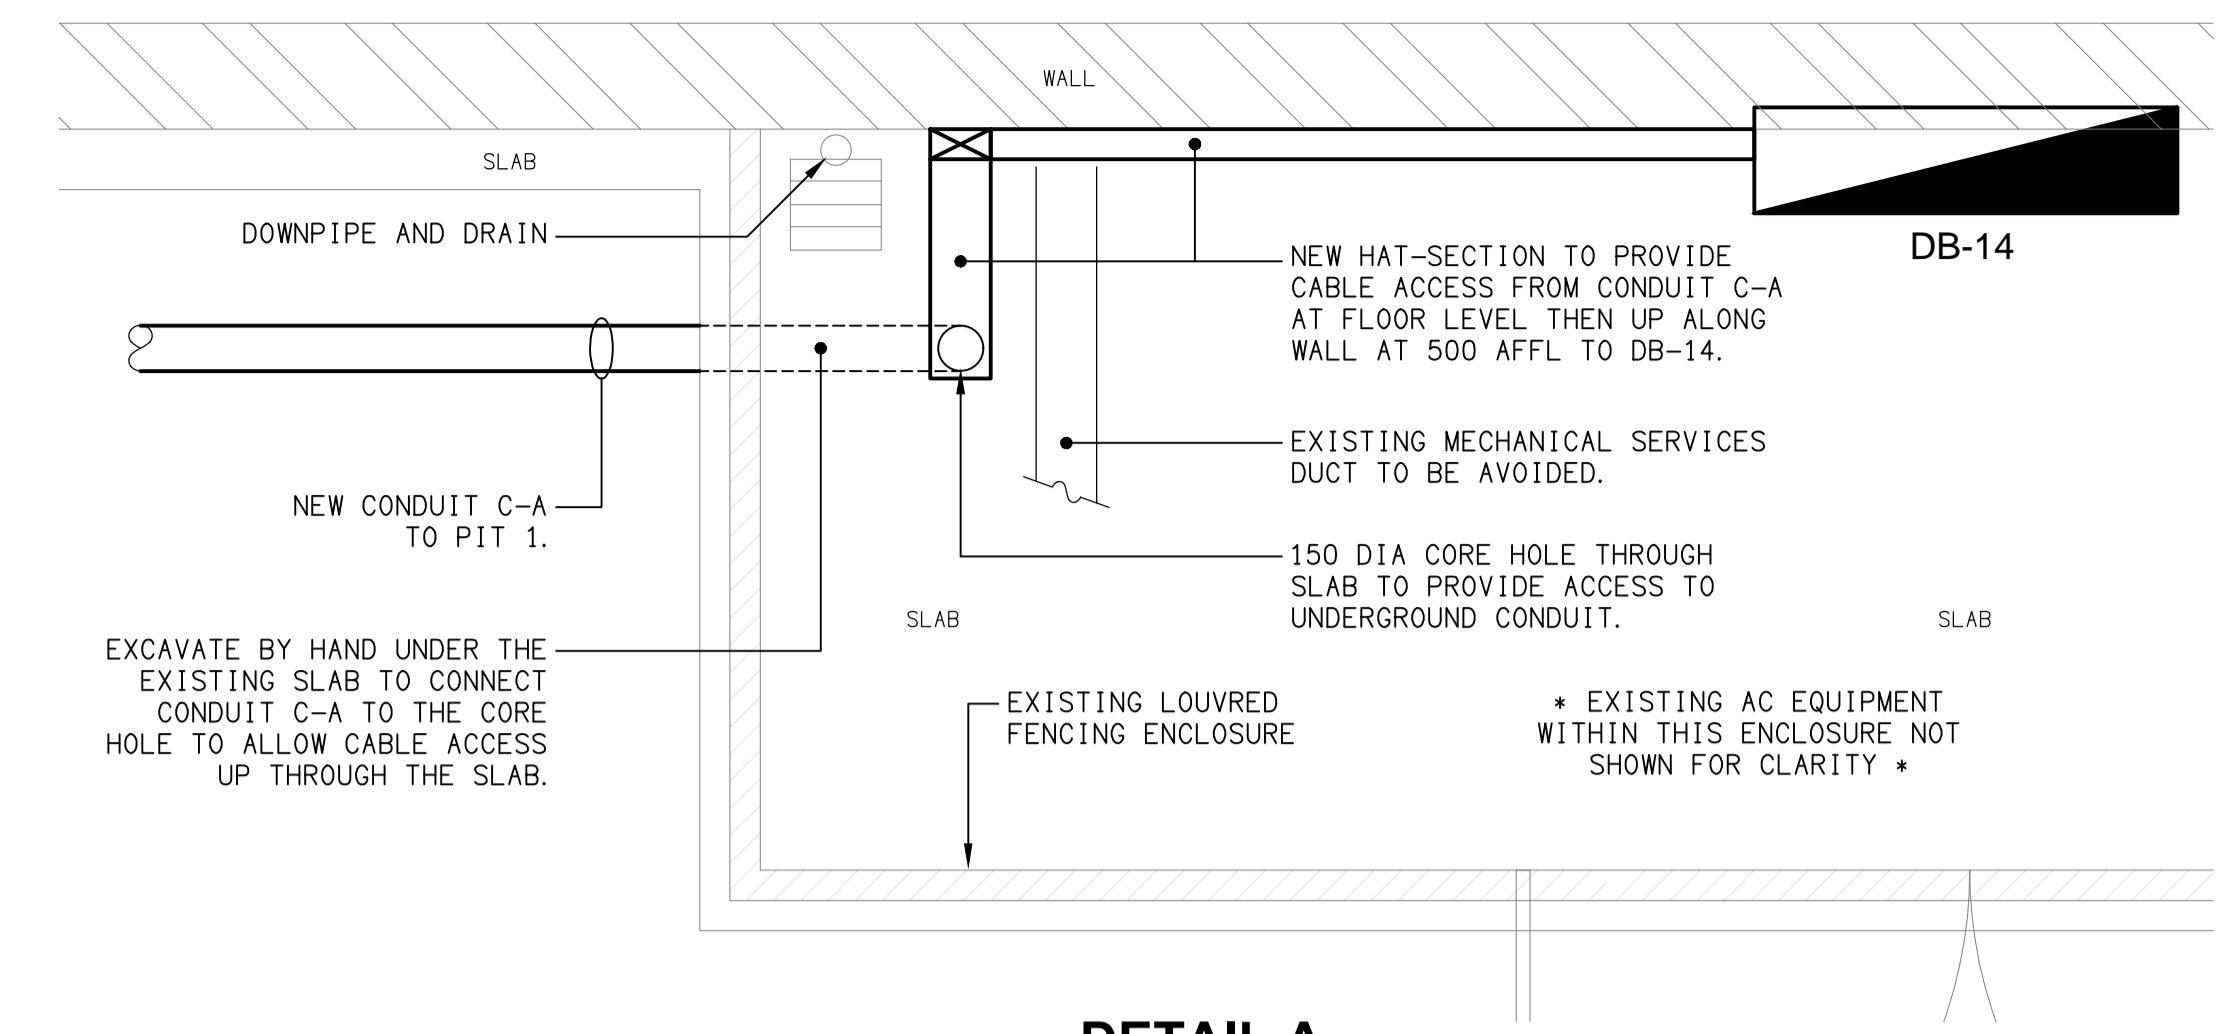


MORINDO DRIVE

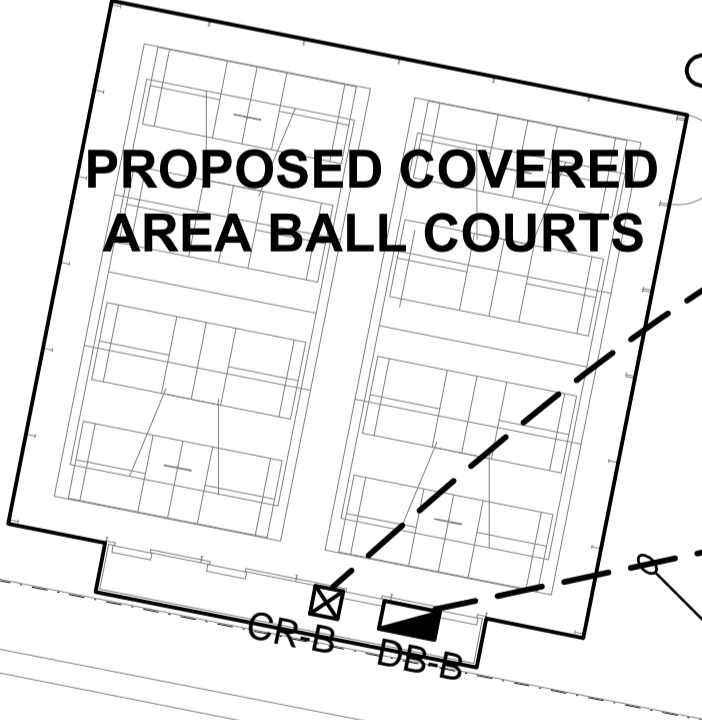

DETAIL A
DB-14 CABLE ACCESS PLAN VIEW
NOT TO SCALE

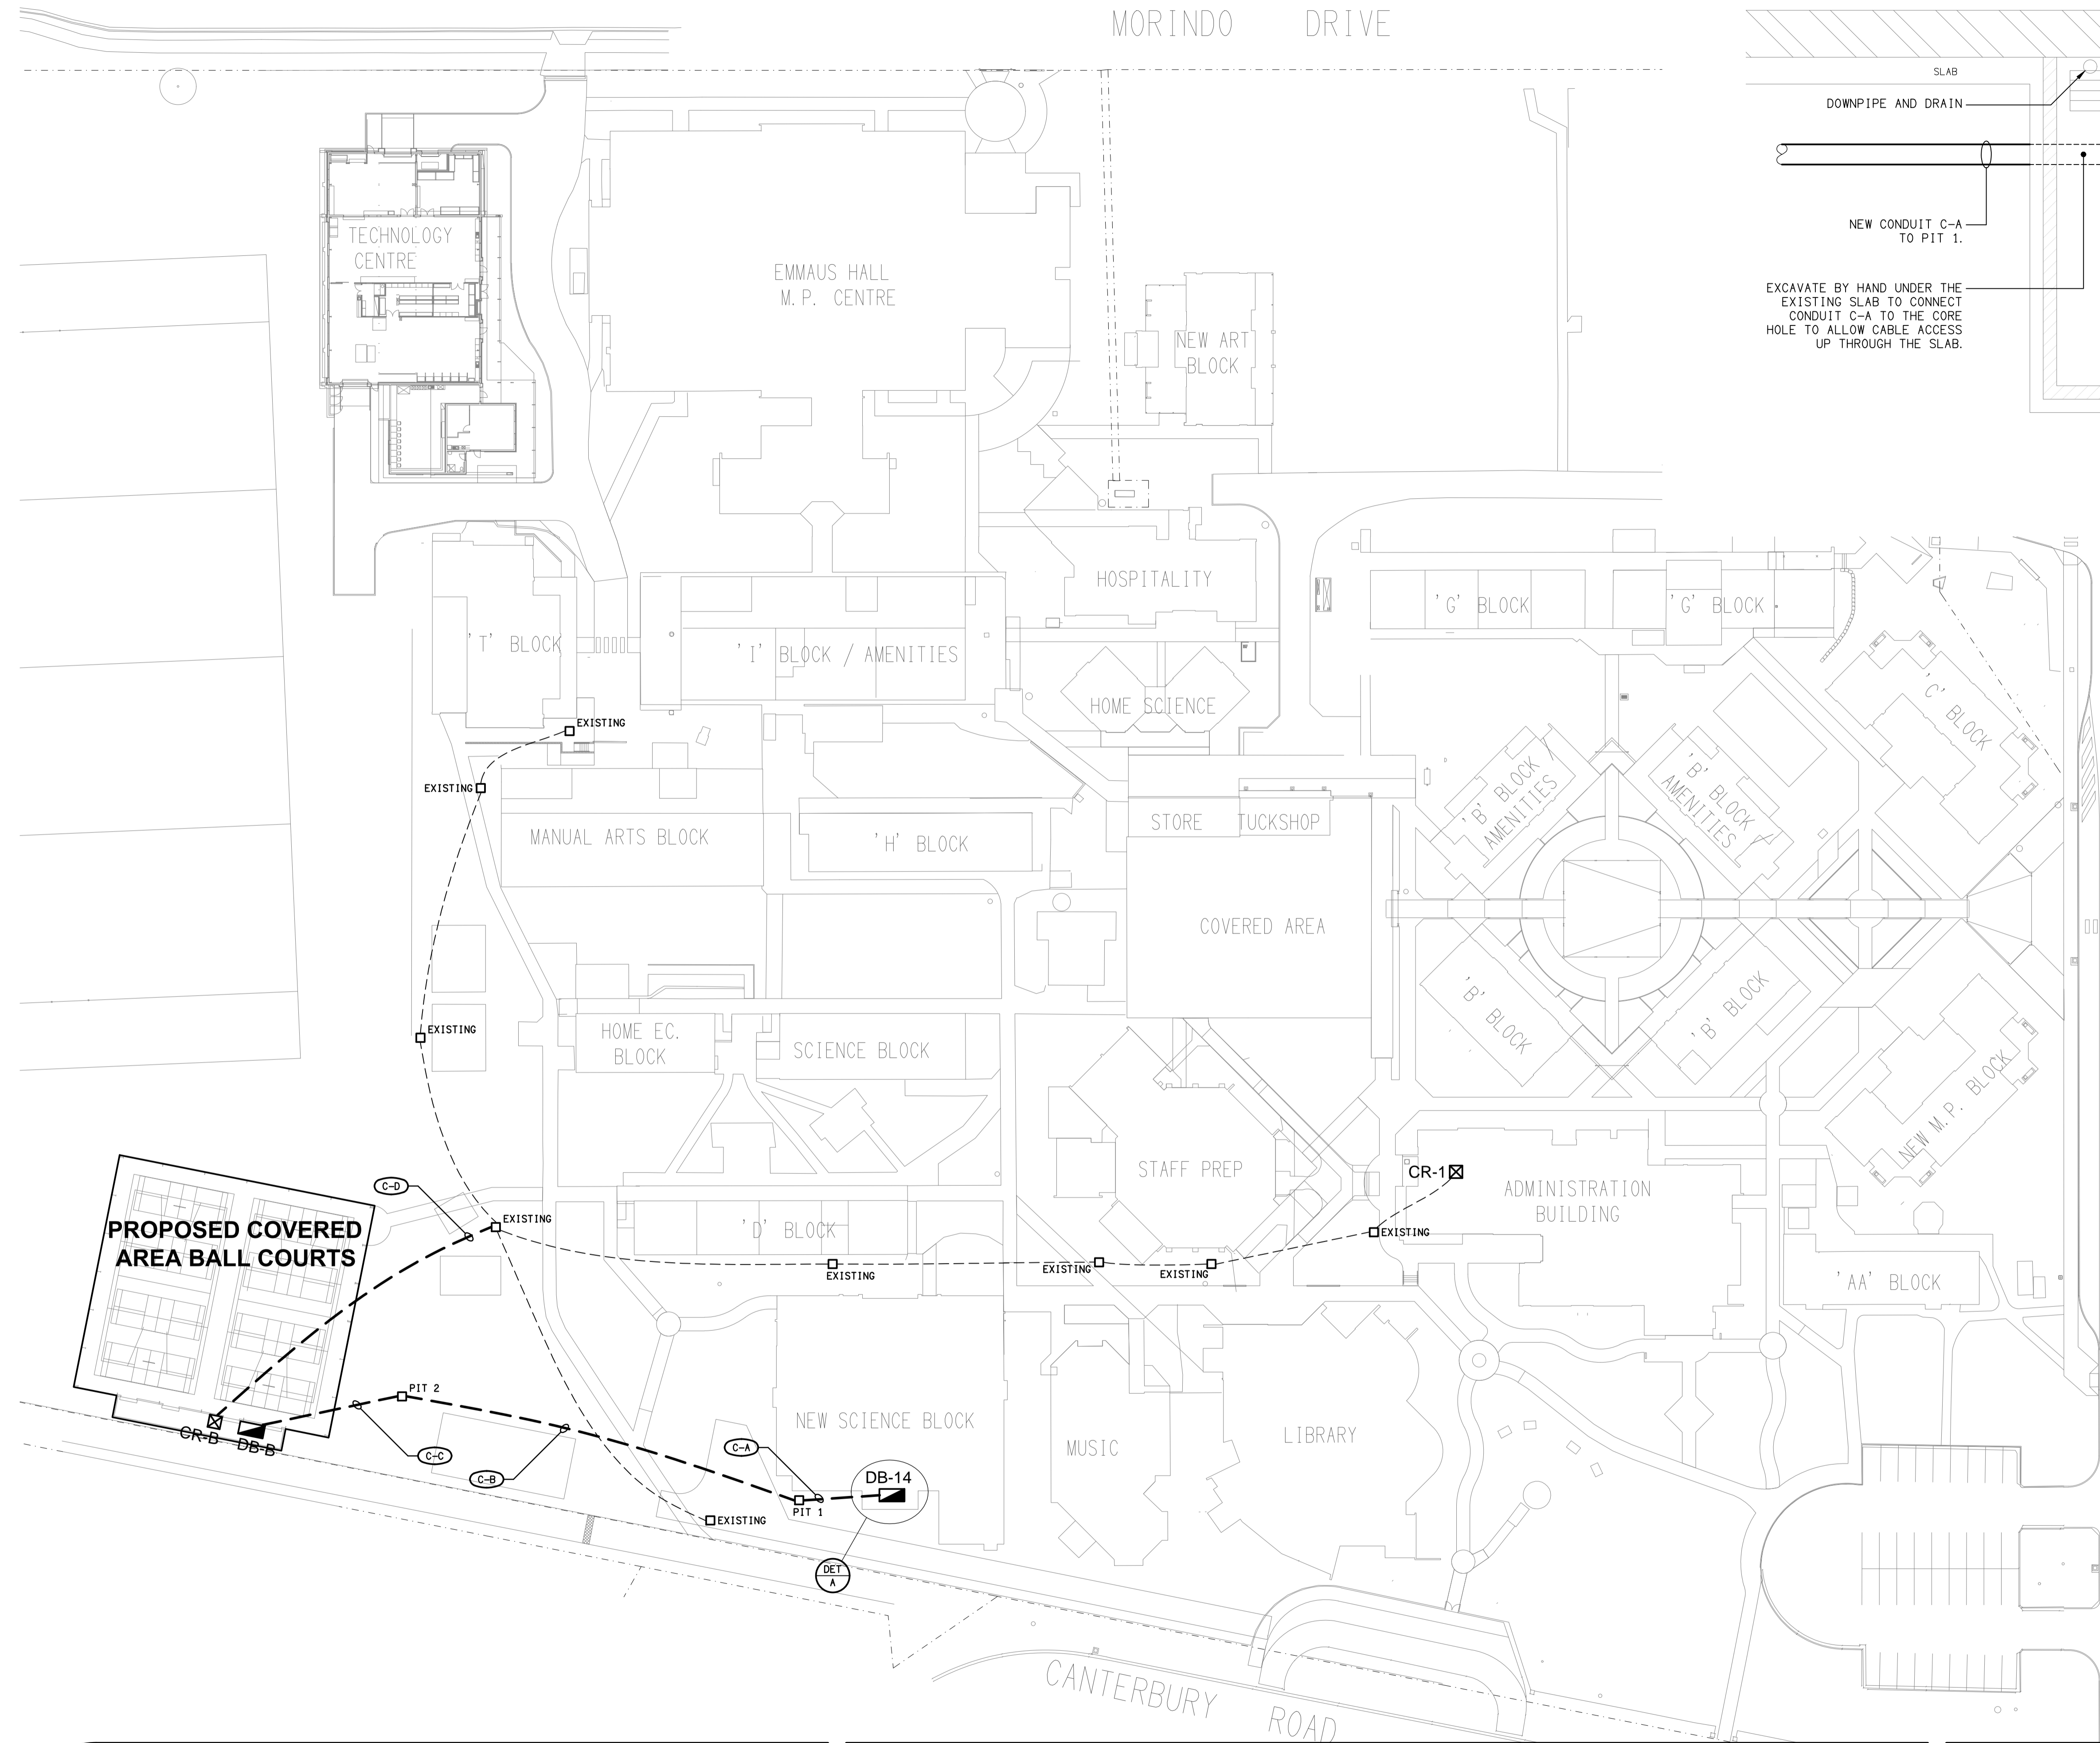


REV	DATE	DESCRIPTION
B	12/12/2022	TENDER
C	26/05/2023	CONSTRUCTION

ELECTRICAL DESIGN GROUP
ELECTRICAL BUILDING SERVICES CONSULTANTS
BRISBANE
P.O. Box 15, Sherwood Q. 4075
Phone: (07) 3278 4375
Email: brisbane@edg.net.au
Web: www.edg.net.au
GOLD COAST

CLIENT
THE ROMAN CATHOLIC TRUST CORPORATION FOR THE DIOCESE OF TOWNSVILLE

PROJECT
RYAN CATHOLIC COLLEGE, COVERED AREA BALL COURTS

DRAWING TITLE
ELECTRICAL SERVICES SITE PLAN

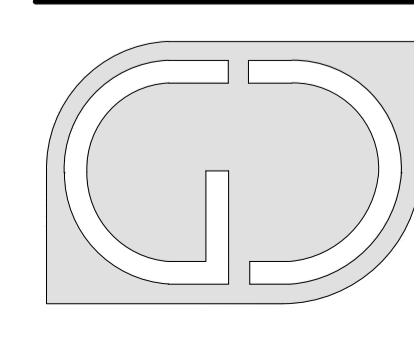

G+D GROUP (QLD)
Level 3 Toowong Terraces
31 Sherwood Road Toowong Q 4066
T (07) 3870 3722
F (07) 3870 3822
E admin@gdgroupqld.com.au

DATE	SCALE	AT
	1:500	A1

C2824a
EDG PROJECT No.
E02 C
EDG DWG No. REV

59 CANTERBURY ROAD, KIRWAN, QLD