


EQUIPMENT STORE ROOMS
FLOOR PLAN
SCALE 1:100

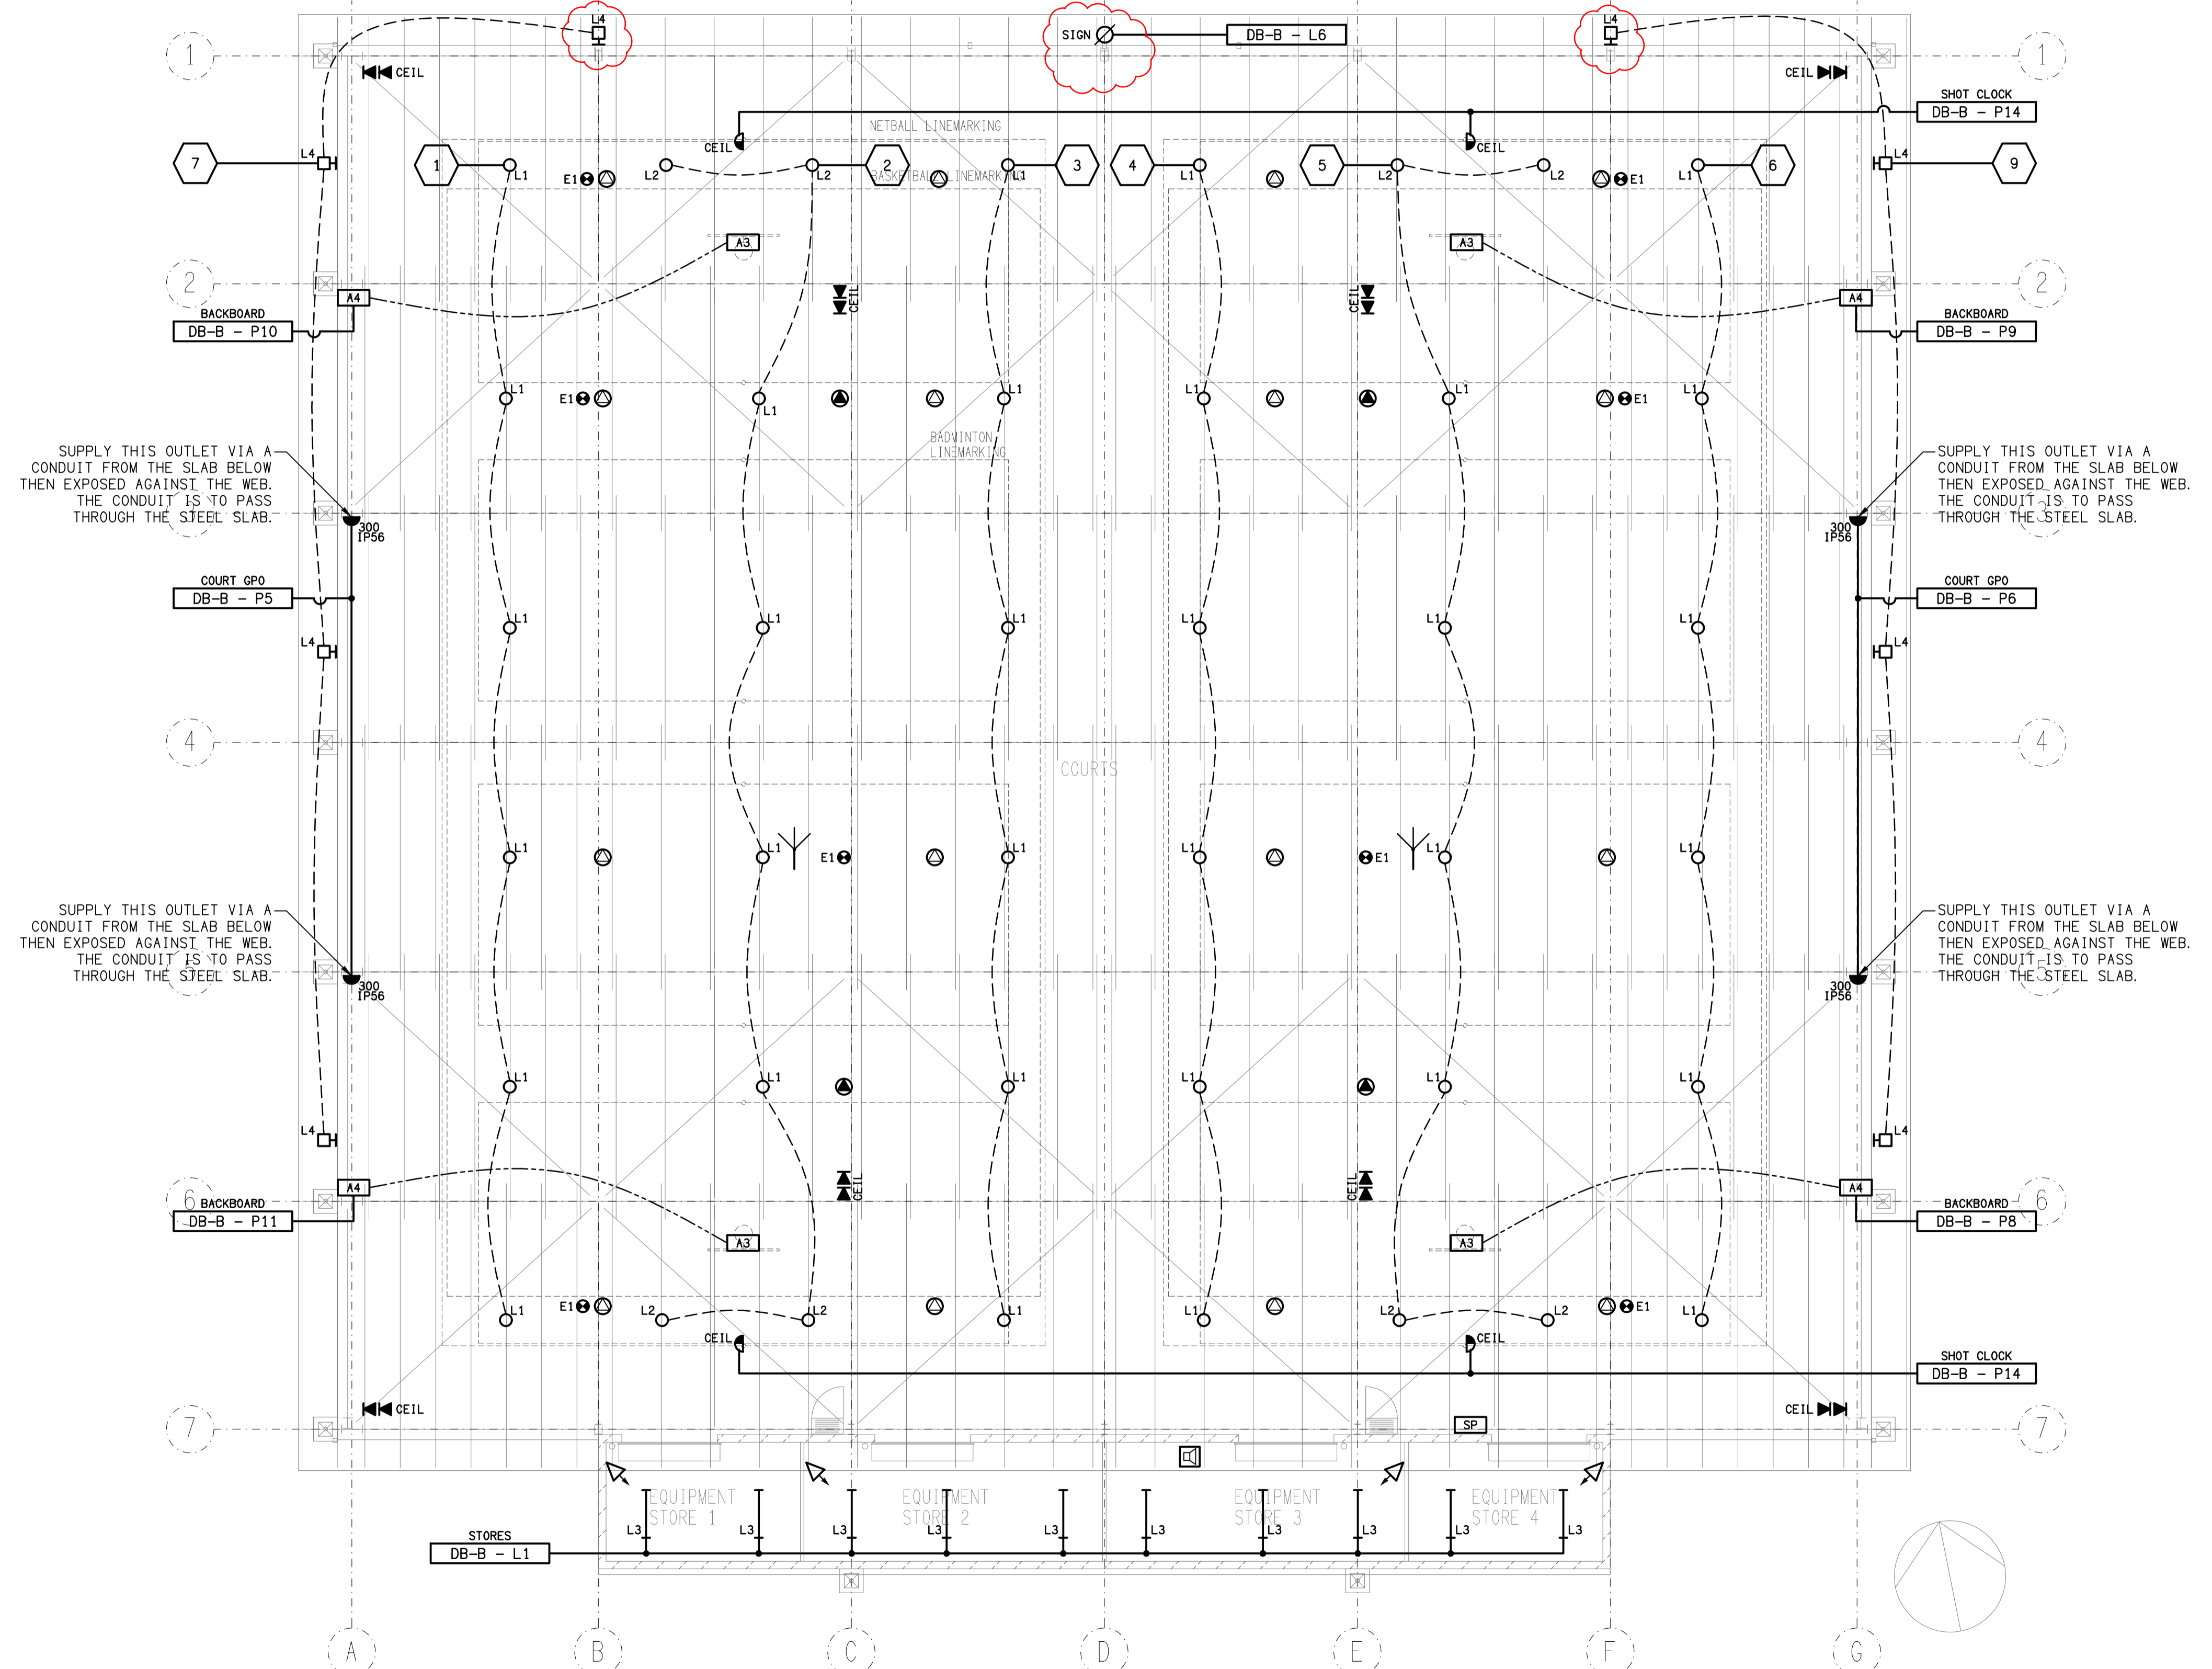


REV	DATE	DESCRIPTION
C	12/12/2022	TENDER
D	13/12/2022	TENDER
E	26/05/2023	CONSTRUCTION
F	12/07/2023	CONSTRUCTION

ELECTRICAL DESIGN GROUP
ELECTRICAL BUILDING SERVICES CONSULTANTS
BRISBANE
P.O. Box 15, Sherwood Q. 4075
Phone: (07) 3278 4375
Email: brisbane@edg.net.au
Web: www.edg.net.au
GOLD COAST

CLIENT
THE ROMAN CATHOLIC TRUST CORPORATION FOR THE DIOCESE OF TOWNSVILLE

PROJECT
RYAN CATHOLIC COLLEGE, COVERED AREA BALL COURTS
59 CANTERBURY ROAD, KIRWAN, QLD

DRAWING TITLE
ELECTRICAL SERVICES FLOOR / REFLECTED CEILING PLAN

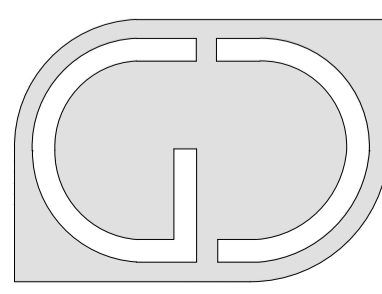

G+D GROUP (QLD)
Level 3 Toowong Terraces
31 Sherwood Road Toowong Q 4066
T (07) 3870 3722
F (07) 3870 3822
E admin@gdgroupqld.com.au

DATE _____
SCALE 1:100
DRAWN _____
CHECKED _____
C2824a
EDG PROJECT No.
E03 F
EDG DWG No. REV