



**GROUND LEVEL**  
FLOOR PLAN  
SCALE 1:50

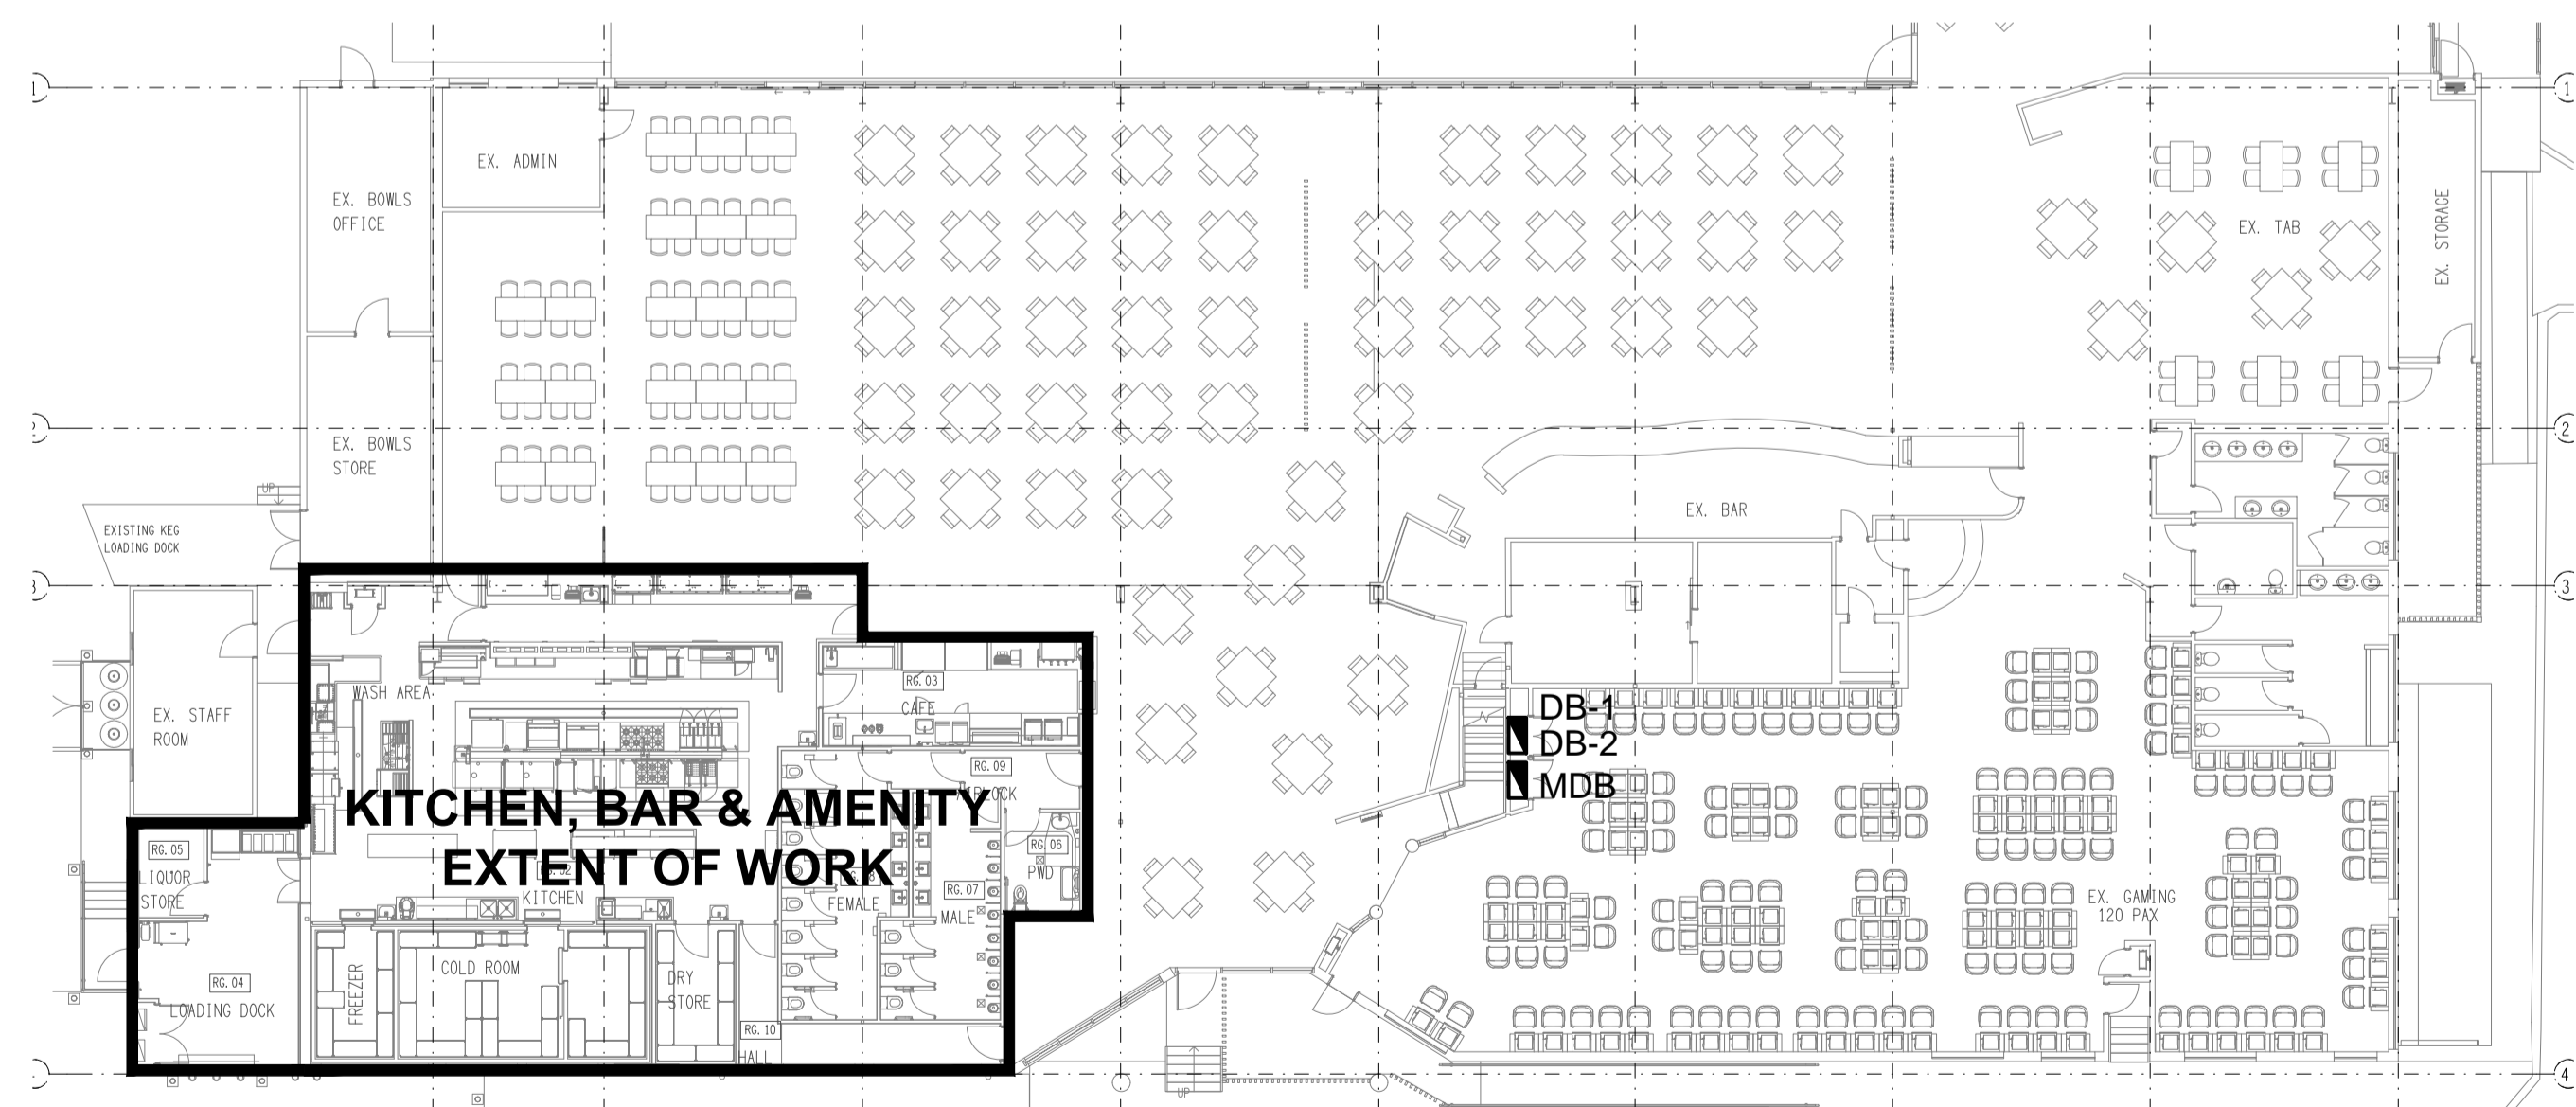

**LOCATION PLAN**  
GROUND LEVEL EXTENT OF WORKS  
SCALE 1:200

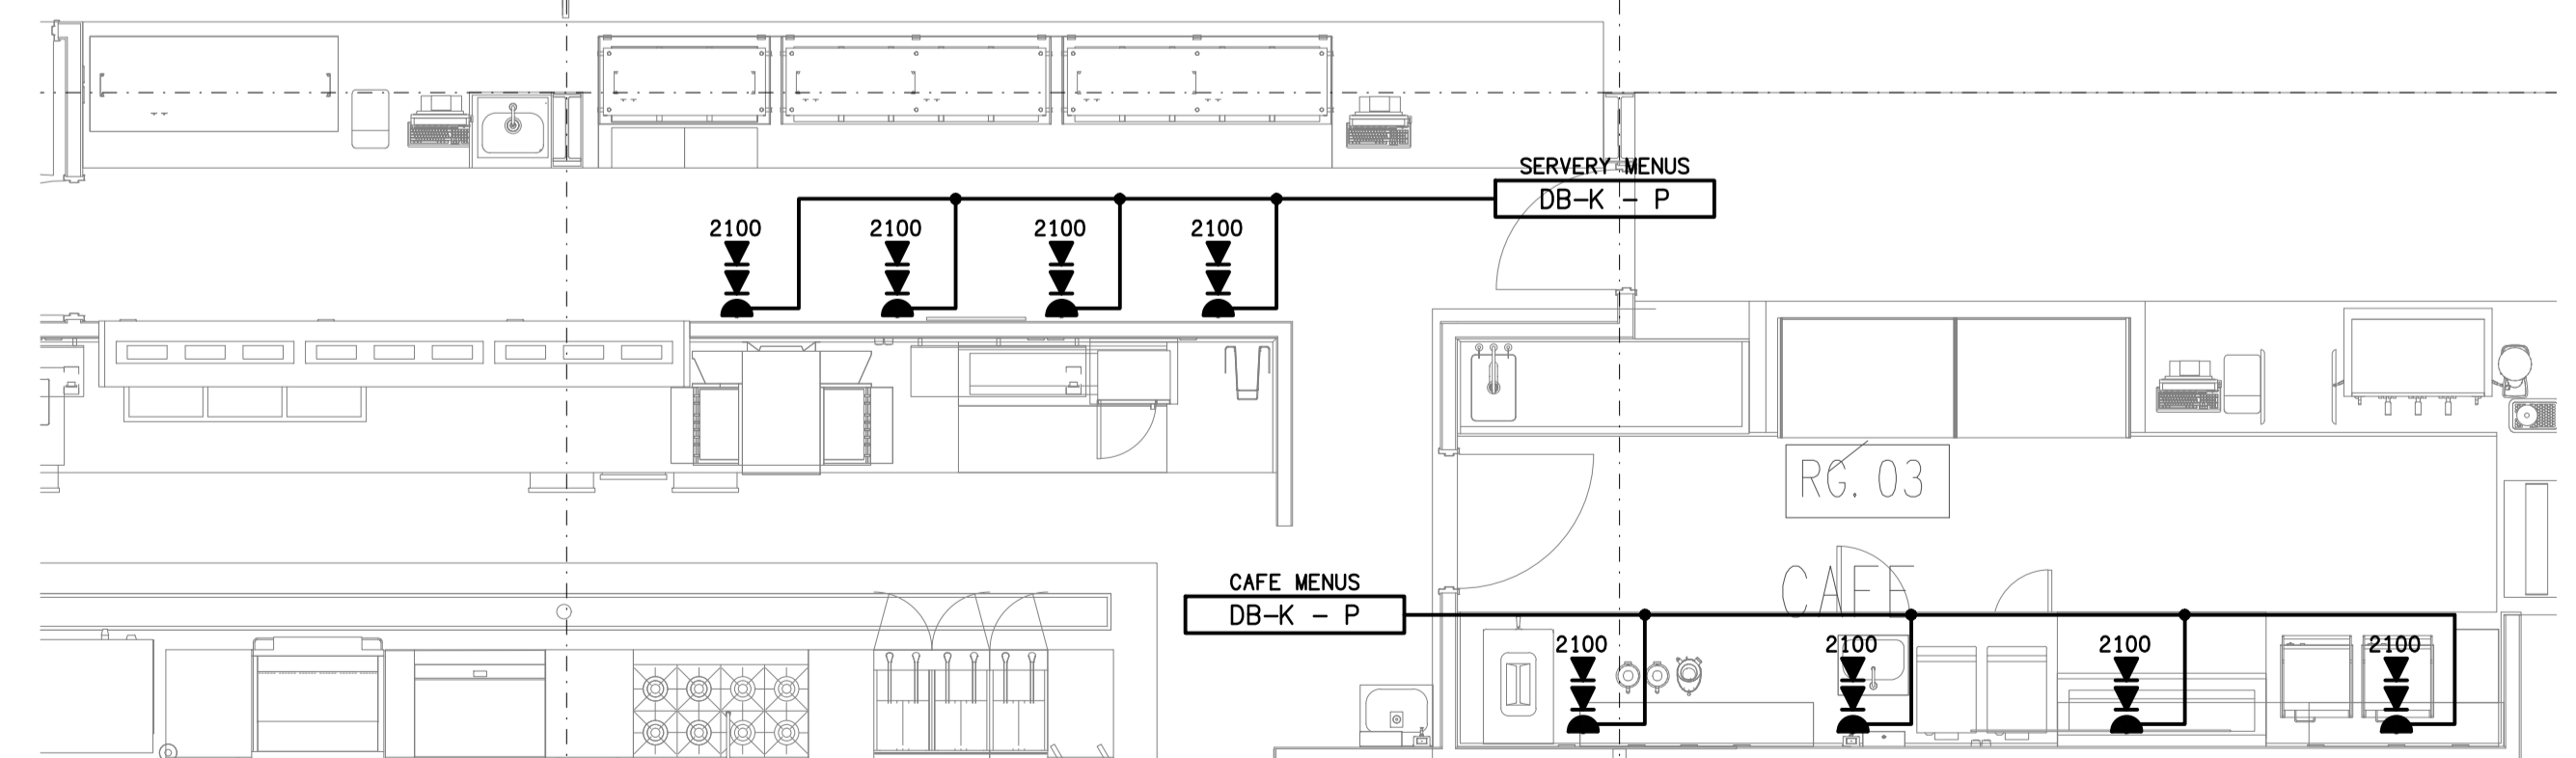

**PART PLAN**  
SERVERY & CAFE MENUS  
SCALE 1:50

ELECTRICAL DESIGN GROUP BRISBANE  
PTY LTD  
ACN 092 710 793  
TRADING AS:  
ELECTRICAL DESIGN GROUP

THE COPYRIGHT OF THIS DRAWING  
REMAINS THE PROPERTY OF THE  
ELECTRICAL DESIGN GROUP.  
USE FIGURED DIMENSIONS  
IN PREFERENCE TO SCALE.  
ALL DIMENSIONS TO BE  
VERIFIED ONSITE.

**ELECTRICAL DESIGN GROUP**  
ELECTRICAL BUILDING SERVICES CONSULTANTS  
BRISBANE GOLD COAST  
P.O. Box 15, Sherwood Q.4075  
Phone: (07) 3278 4375  
Email: brisbane@edg.net.au  
Web: www.edg.net.au

PROJECT:  
**CLUB KAWANA - STAGE 1**  
476 NICKLIN WAY, WURTULLA

C	TENDER	11/12/2024
REV.	DESCRIPTION:	DATE:
DRAWING: <b>ELECTRICAL SERVICES</b> <b>GROUND LEVEL FLOOR PLAN</b>		
SCALE: 1:50 & 1:200	PROJECT NO: <b>C2957a</b>	DRAWING NO: <b>E04</b>
AT A1	REVISION: <b>C</b>	