


THE MAJORITY OF THE ELECTRICAL SERVICES SHOWN ON THIS DRAWING HAVE BEEN REVISED AT THIS REVISION (B).

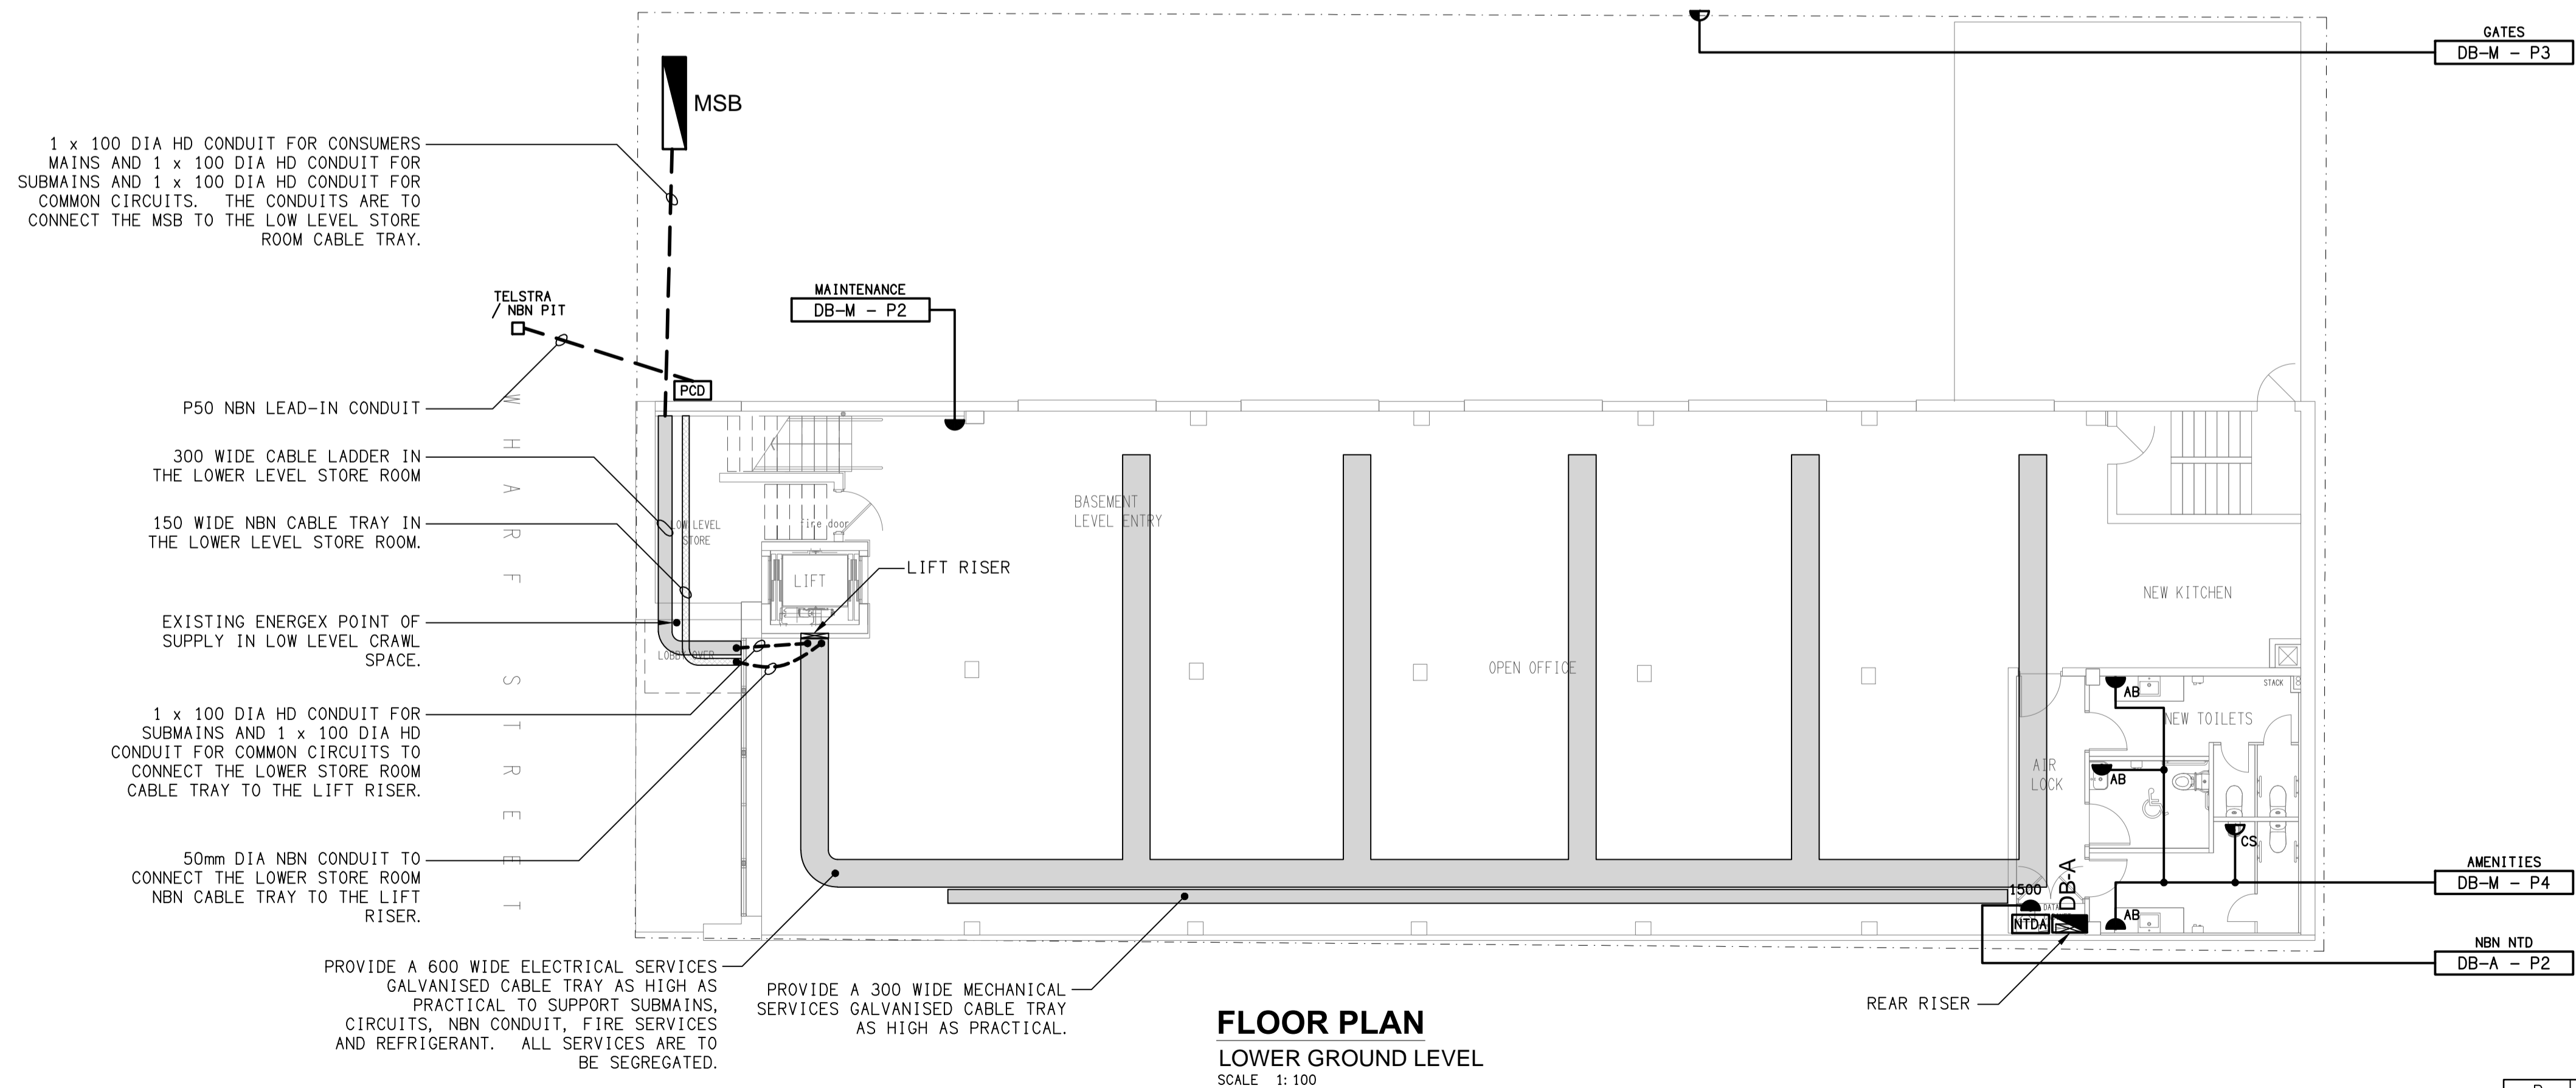

ELECTRICAL DESIGN GROUP BRISBANE PTY LTD
ACN 092 710 793

TRADING AS:
ELECTRICAL DESIGN GROUP

THE COPYRIGHT OF THIS DRAWING REMAINS THE PROPERTY OF THE ELECTRICAL DESIGN GROUP.

USE FIGURED DIMENSIONS IN PREFERENCE TO SCALE.

ALL DIMENSIONS TO BE VERIFIED ONSITE.

ELECTRICAL DESIGN GROUP
ELECTRICAL BUILDING SERVICES CONSULTANTS
BRISBANE GOLD COAST

P.O. Box 15, Sherwood Q.4075
Phone: (07) 3278 4375
Email: brisbane@edg.net.au
Web: www.edg.net.au

PROJECT:
143 WHARF STREET, SPRING HILL

BRISBANE

B	TENDER	21/04/2023
REV:	DESCRIPTION:	DATE:

DRAWING:
ELECTRICAL SERVICES
LOWER GROUND
FLOOR PLAN & REFLECTED CEILING PLAN

SCALE:
1:100

AT A1

PROJECT NO:
C3017a

DRAWING NO:
E02

REVISION:
B