



**FLOOR PLAN**  
LOWER GROUND LEVEL  
SCALE 1:100

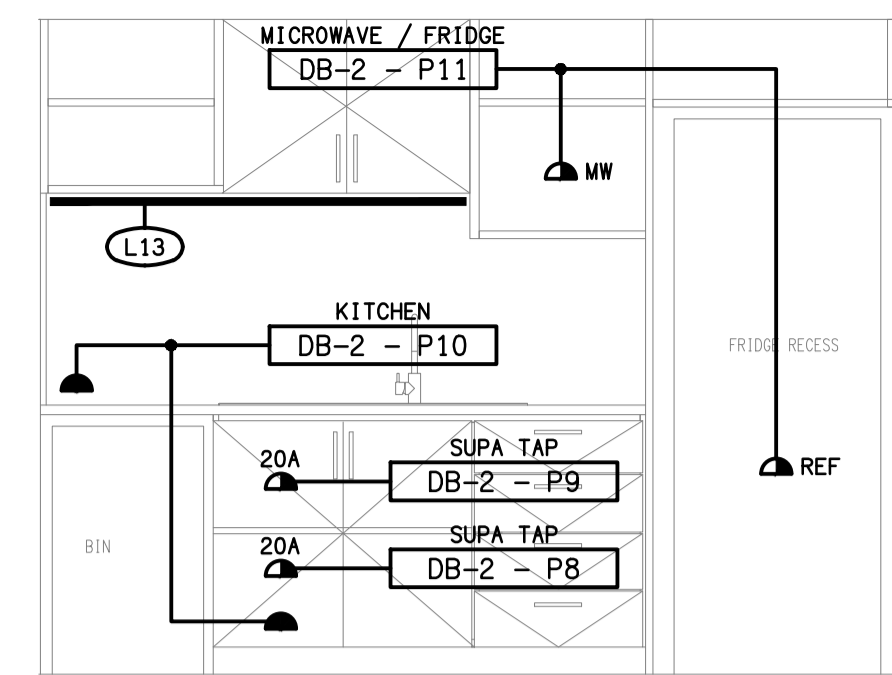

**DETAIL A**  
STAFF ROOM KITCHENETTE ELEVATION  
SCALE 1:25

DETAIL NO LONGER REQUIRED

DETAIL NO LONGER REQUIRED

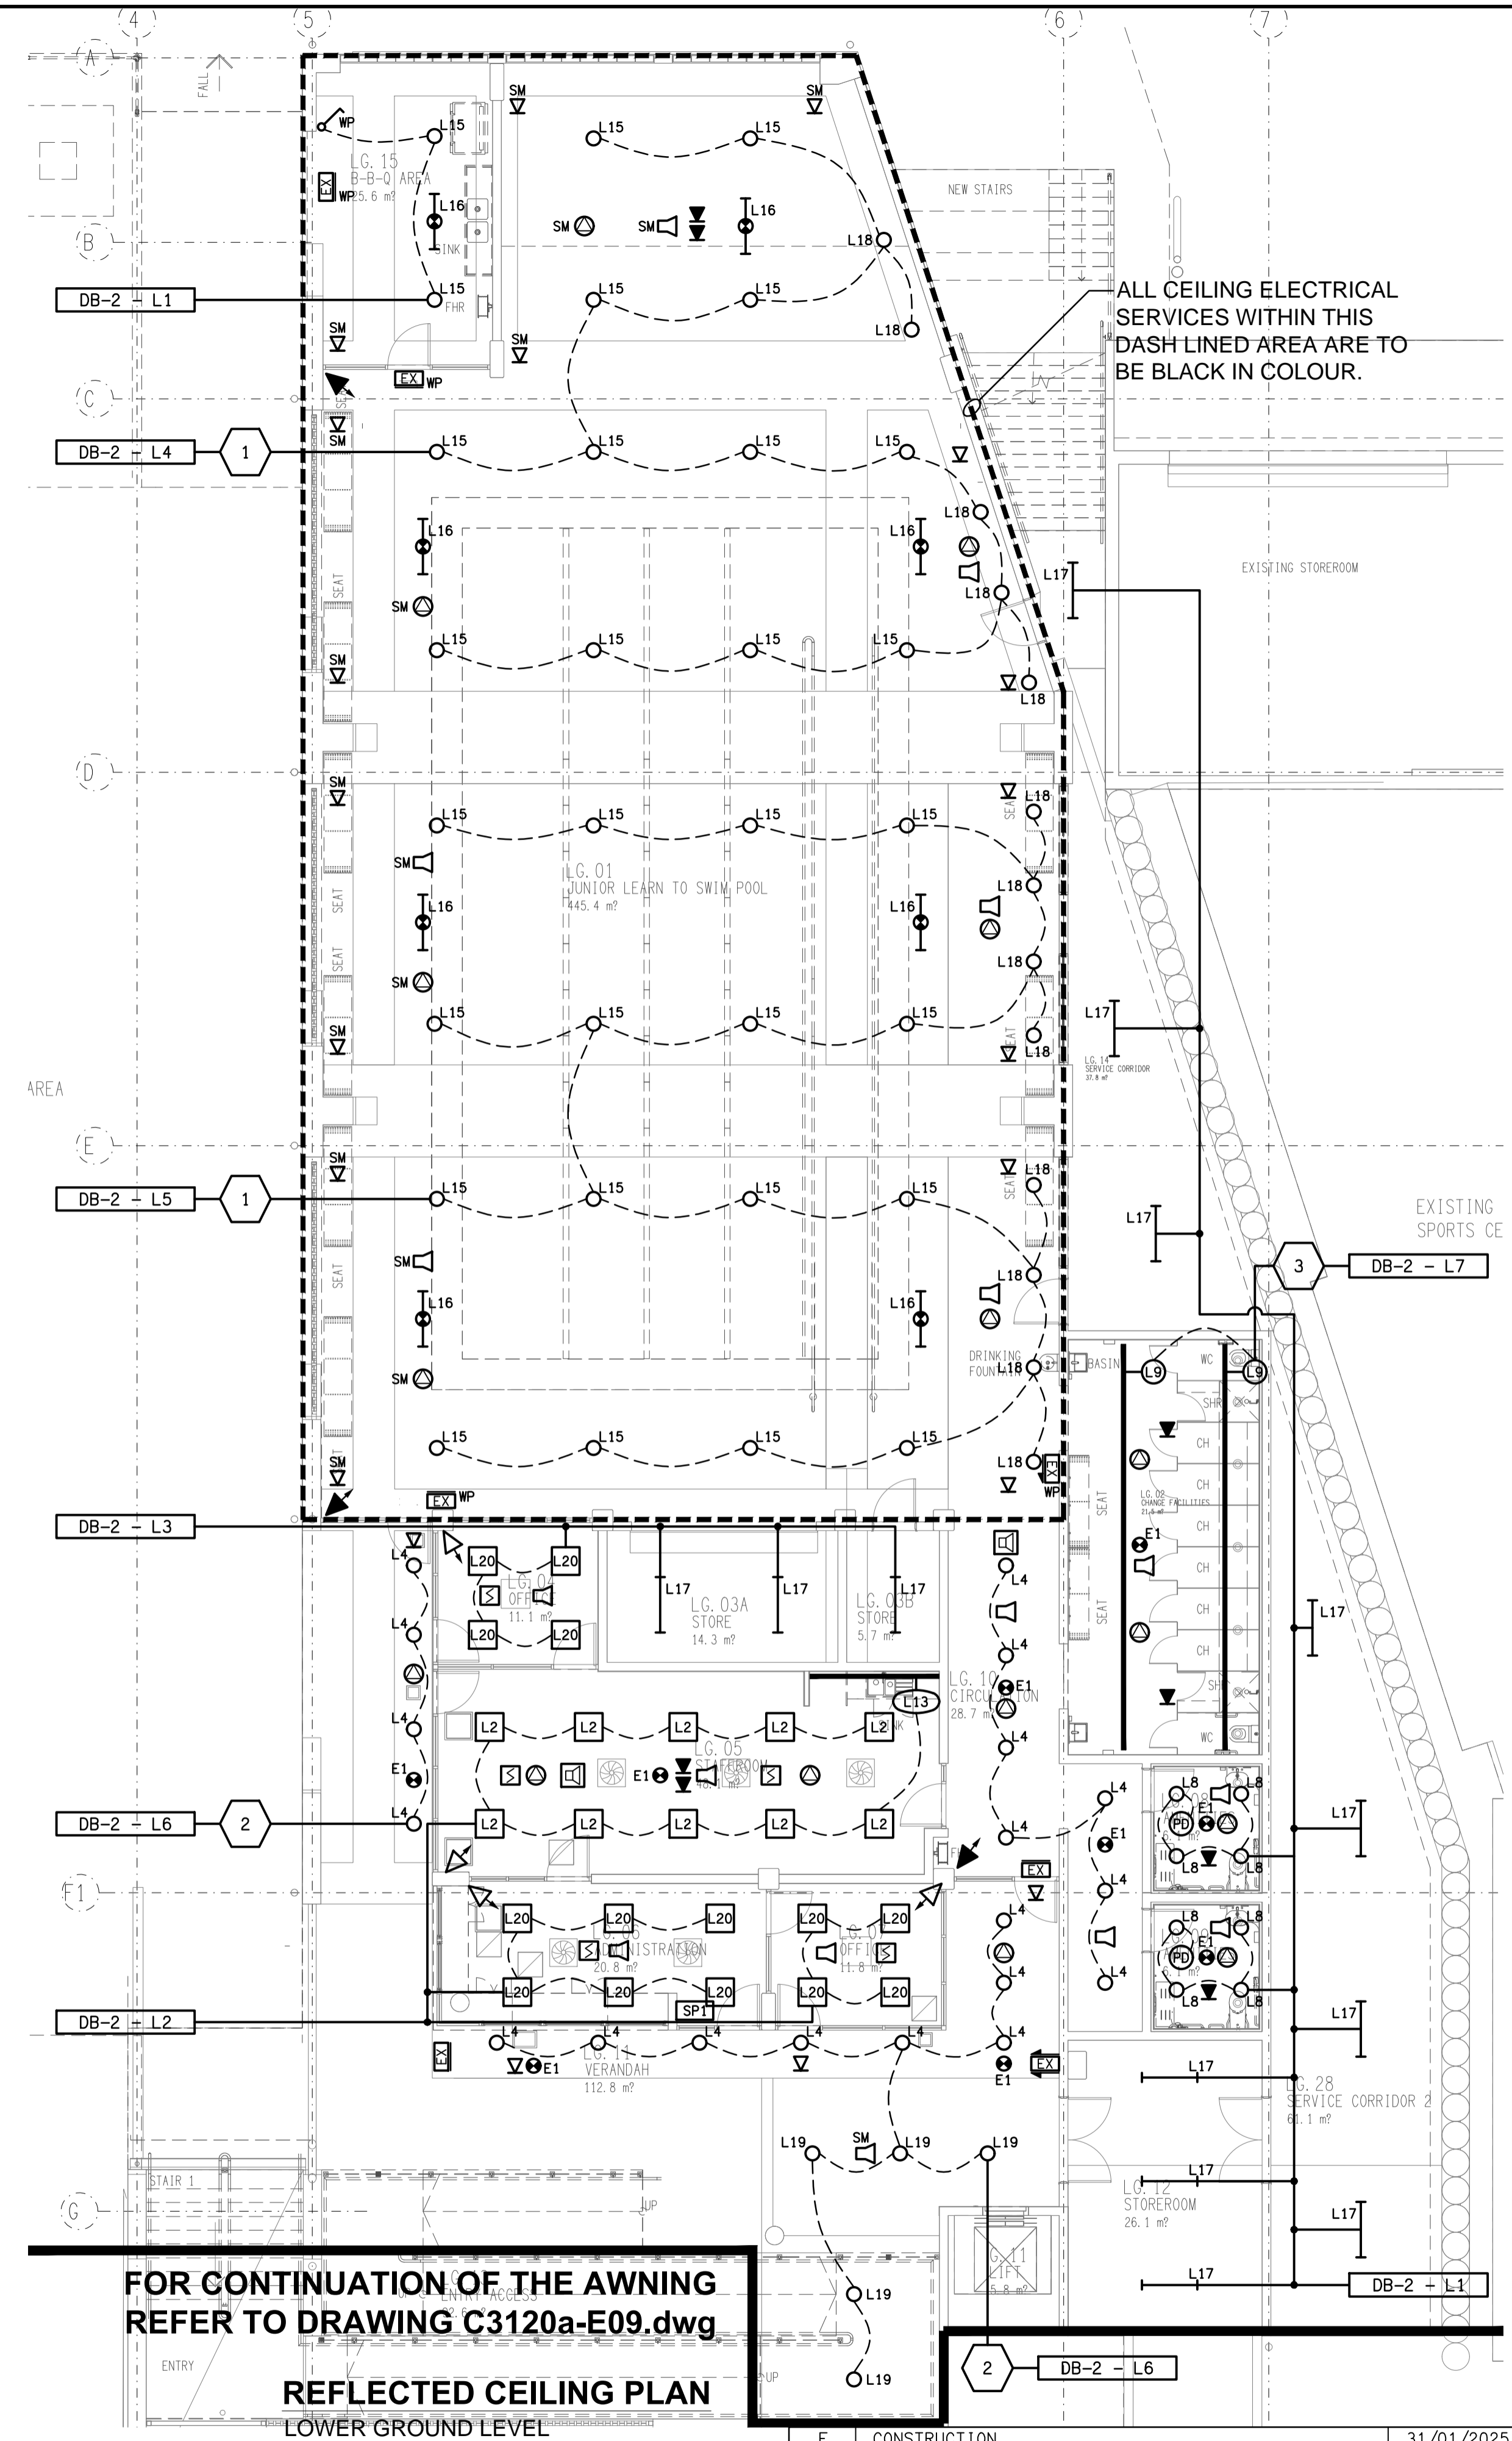

**FOR CONTINUATION OF THE AWNING  
REFER TO DRAWING C3120a-E09.dwg**

**REFLECTED CEILING PLAN**  
LOWER GROUND LEVEL  
SCALE 1:100

ELECTRICAL DESIGN GROUP BRISBANE  
PTY LTD  
ACN 092 710 793  
TRADING AS:  
ELECTRICAL DESIGN GROUP

THE COPYRIGHT OF THIS DRAWING  
REMAINS THE PROPERTY OF THE  
ELECTRICAL DESIGN GROUP.  
USE FIGURED DIMENSIONS  
IN PREFERENCE TO SCALE.  
ALL DIMENSIONS TO BE  
VERIFIED ONSITE.

**ELECTRICAL DESIGN GROUP**  
ELECTRICAL BUILDING SERVICES CONSULTANTS  
BRISBANE GOLD COAST  
P.O. Box 15, Sherwood Q. 4075  
Phone: (07) 3278 4375  
Email: brisbane@edg.net.au  
Web: www.edg.net.au

PROJECT:  
**ST JOHN'S ANGLICAN COLLEGE  
FOREST LAKE  
AQUATIC CENTRE STAGE 1  
COLLEGE AVENUE, FOREST LAKE**

F	CONSTRUCTION	31/01/2025
REV:	DESCRIPTION:	DATE:
DRAWING: <b>ELECTRICAL SERVICES AQUATIC CENTRE LOWER GROUND PLANS</b>		
SCALE: 1:100	PROJECT NO: AT A1 <b>C3120a</b>	DRAWING NO: <b>E03</b>
		REVISION: <b>F</b>