




GROUND LEVEL
FLOOR PLAN
SCALE 1:100

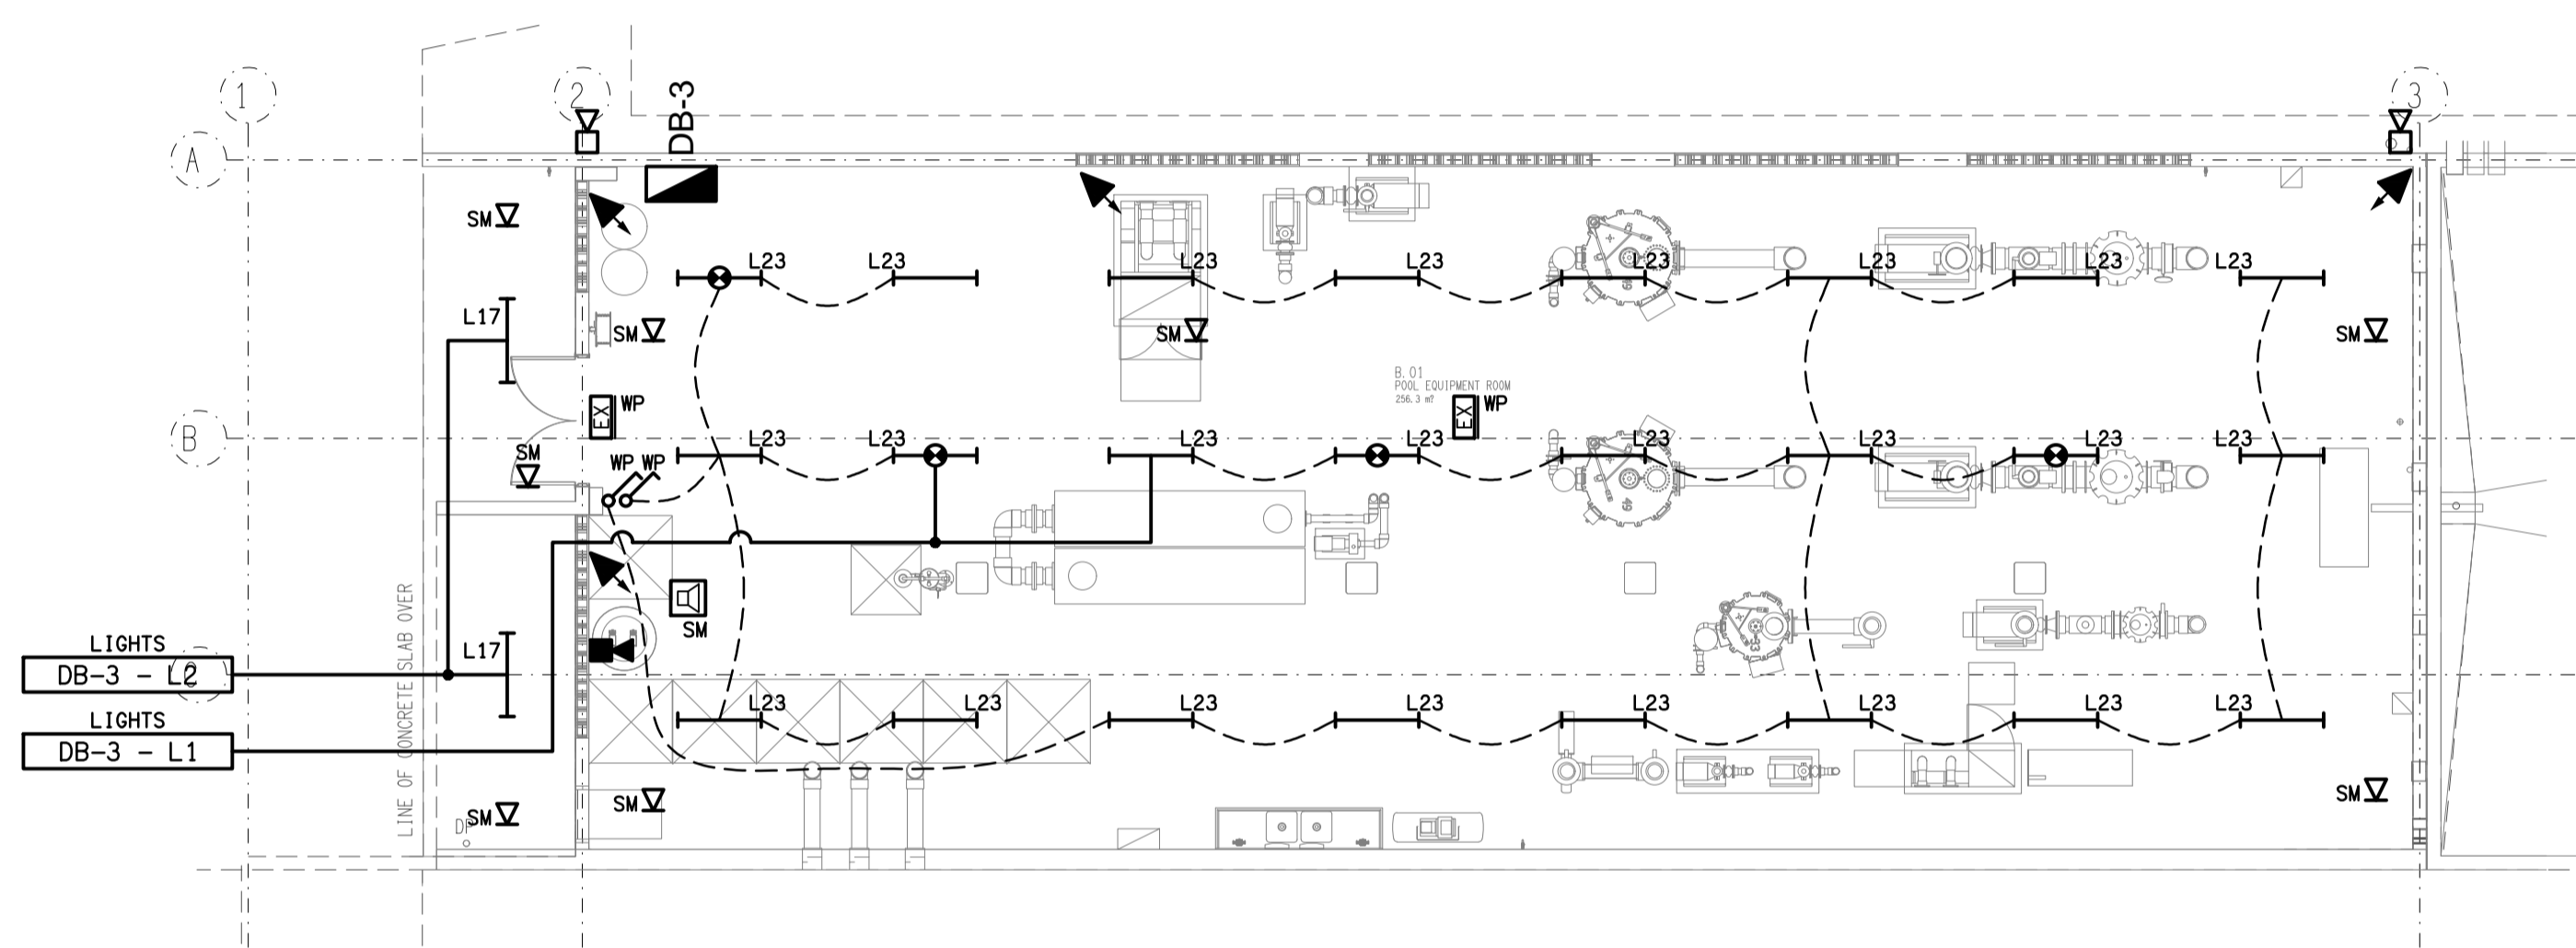


BASEMENT LEVEL
REFLECTED CEILING PLAN
SCALE 1:100

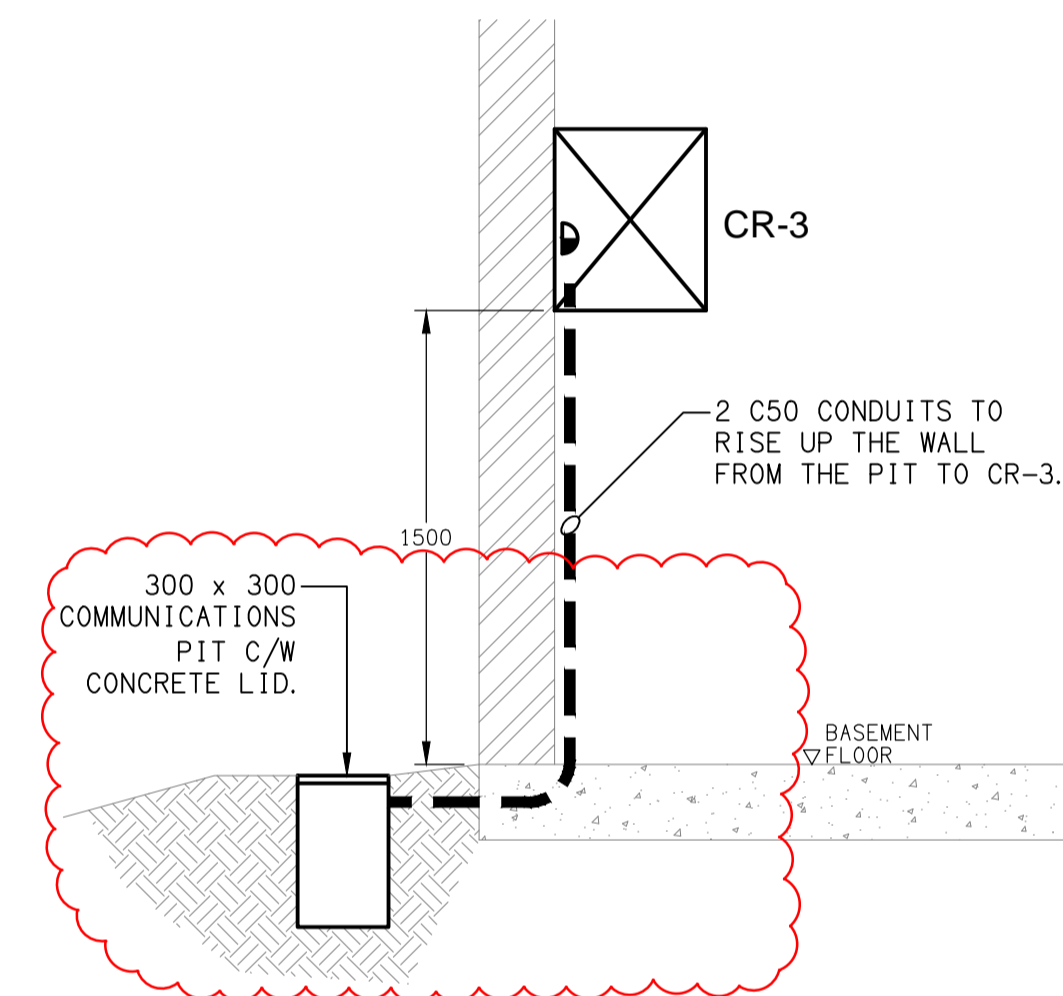

DETAIL A
COMMUNICATION RACK CR-3 SECTION
NOT TO SCALE

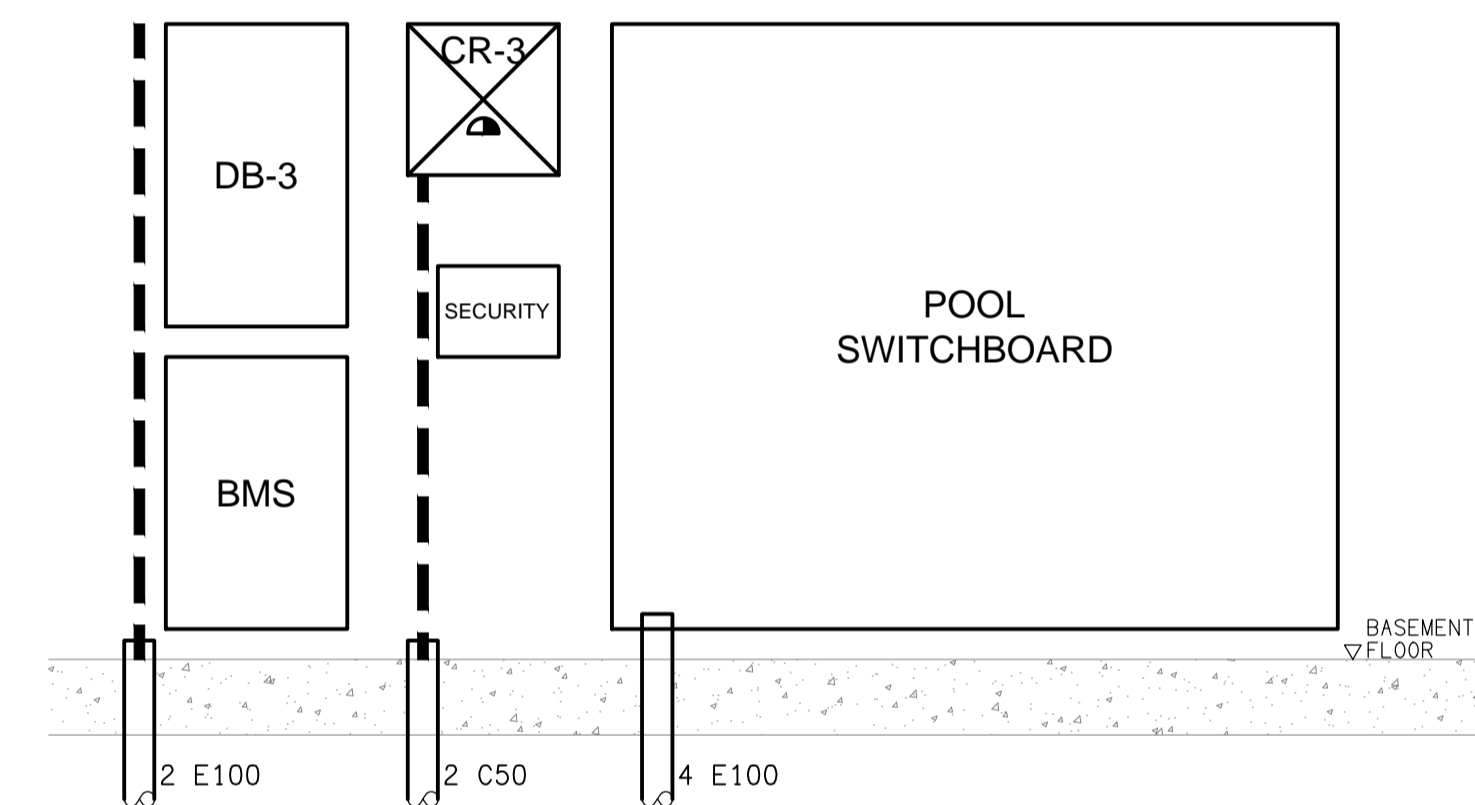

DETAIL B
ELECTRICAL EQUIPMENT ELEVATION
NOT TO SCALE

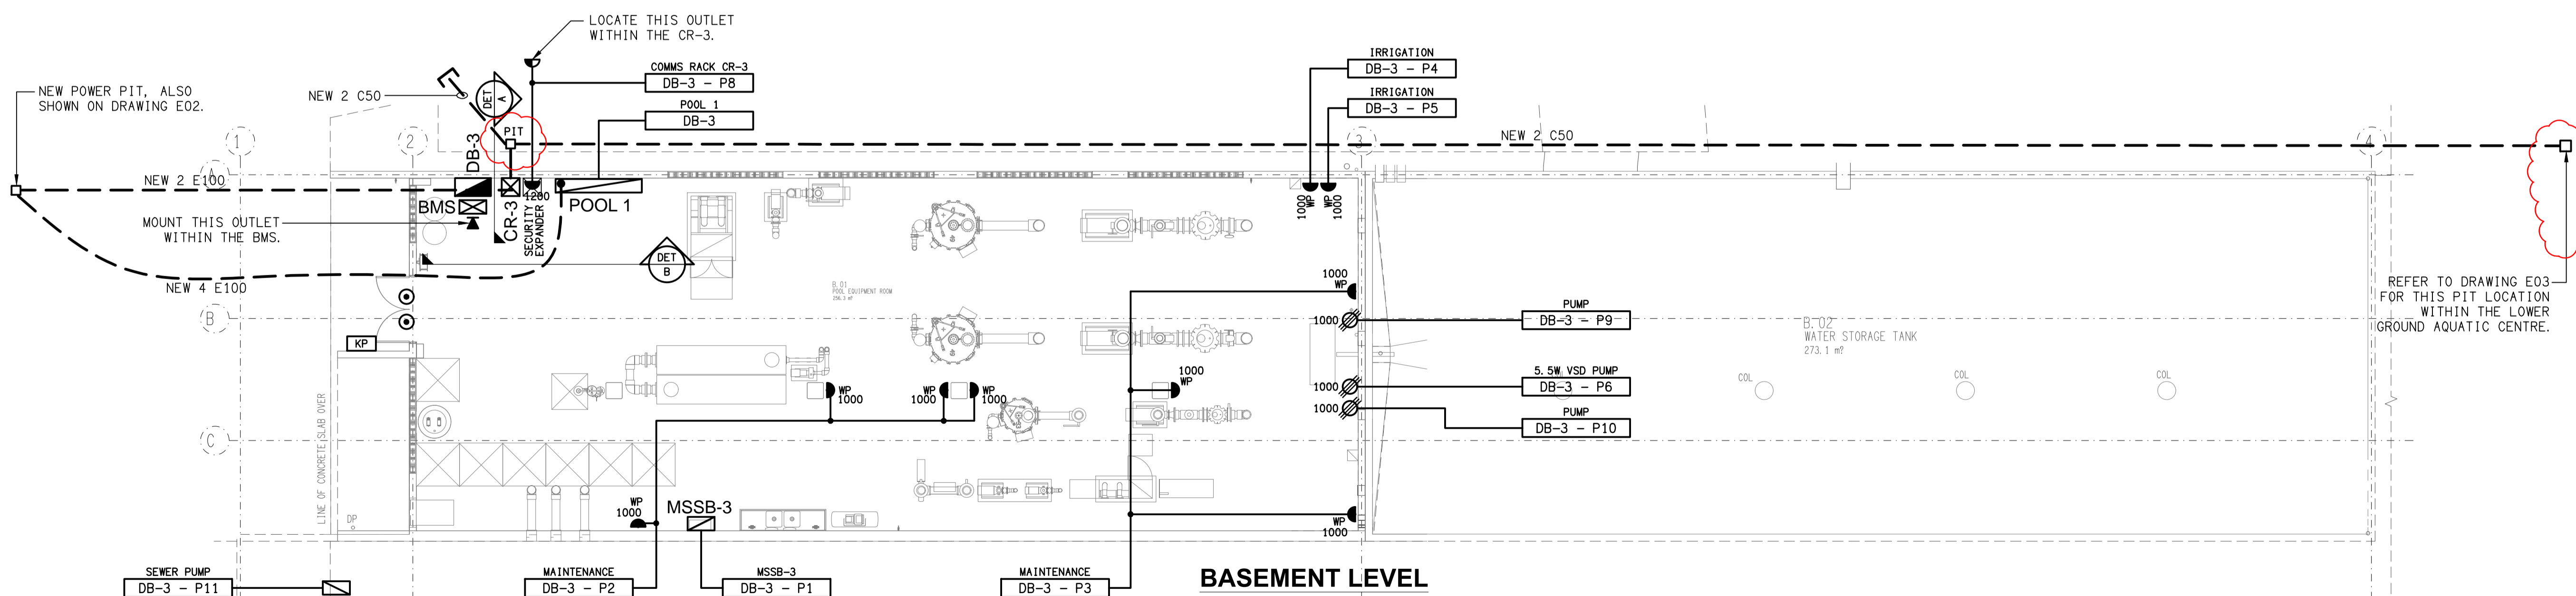

BASEMENT LEVEL
FLOOR PLAN
SCALE 1:100

REFER TO DRAWING E03 FOR THIS PIT LOCATION WITHIN THE LOWER GROUND AQUATIC CENTRE.

ELECTRICAL DESIGN GROUP BRISBANE PTY LTD
ACN 092 710 793
TRADING AS:
ELECTRICAL DESIGN GROUP

THE COPYRIGHT OF THIS DRAWING REMAINS THE PROPERTY OF THE ELECTRICAL DESIGN GROUP.
USE FIGURED DIMENSIONS IN PREFERENCE TO SCALE.
ALL DIMENSIONS TO BE VERIFIED ONSITE.

ELECTRICAL DESIGN GROUP
ELECTRICAL BUILDING SERVICES CONSULTANTS
BRISBANE GOLD COAST

P.O. Box 15, Sherwood Q.4075
Phone: (07) 3278 4375
Email: brisbane@edg.net.au
Web: www.edg.net.au

PROJECT:
ST JOHN'S ANGLICAN COLLEGE
FOREST LAKE
AQUATIC CENTRE STAGE 1
COLLEGE AVENUE, FOREST LAKE

F	CONSTRUCTION	31/01/2025
REV:	DESCRIPTION:	DATE:

DRAWING:
ELECTRICAL SERVICES
POOL EQUIPMENT BUILDING PLANS

SCALE:
1:100

AT A1

PROJECT NO:
C3120a

DRAWING NO:
E07

REVISION:
F