



**NORTH**  
EXTERNAL BUILDING ELEVATION  
SCALE 1:100

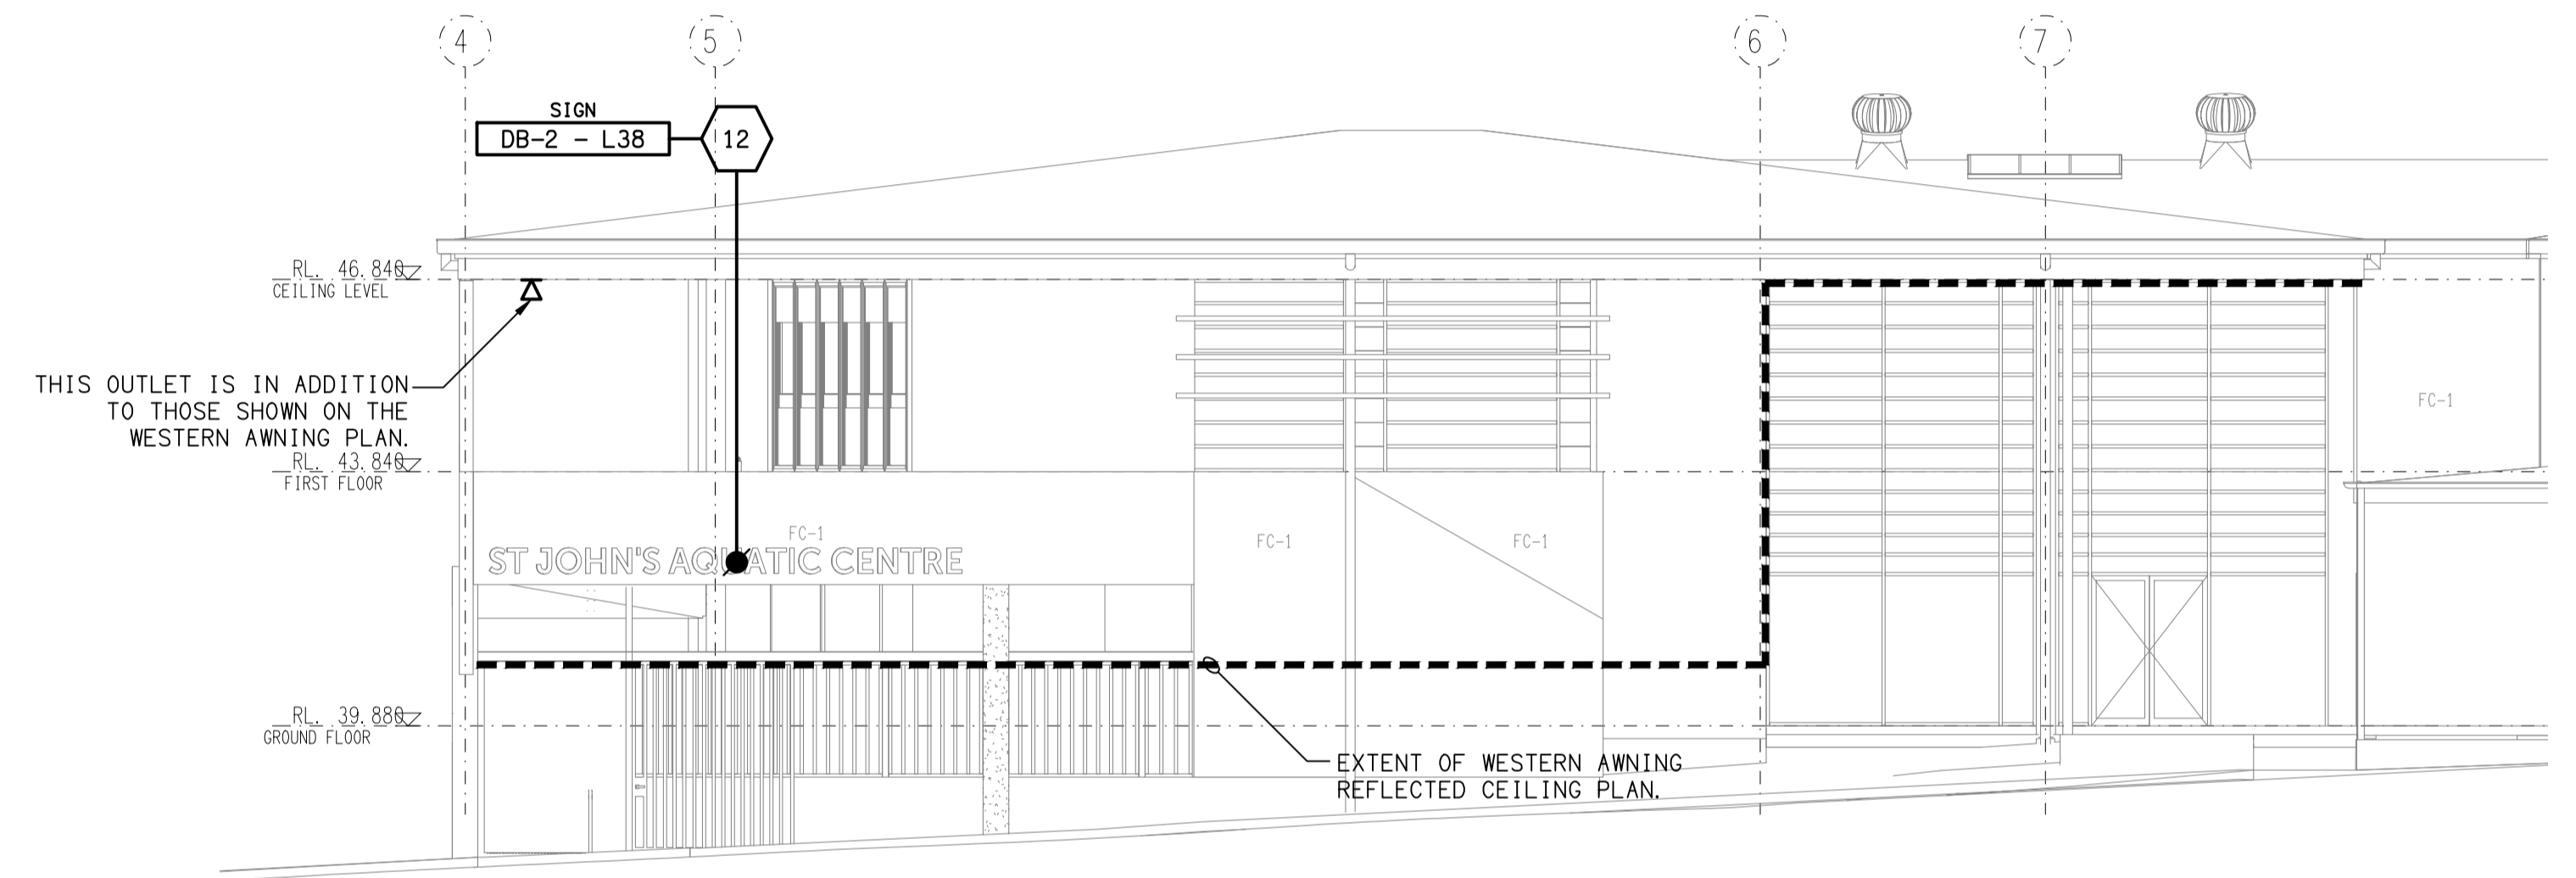

**WEST**  
EXTERNAL BUILDING ELEVATION  
SCALE 1:100

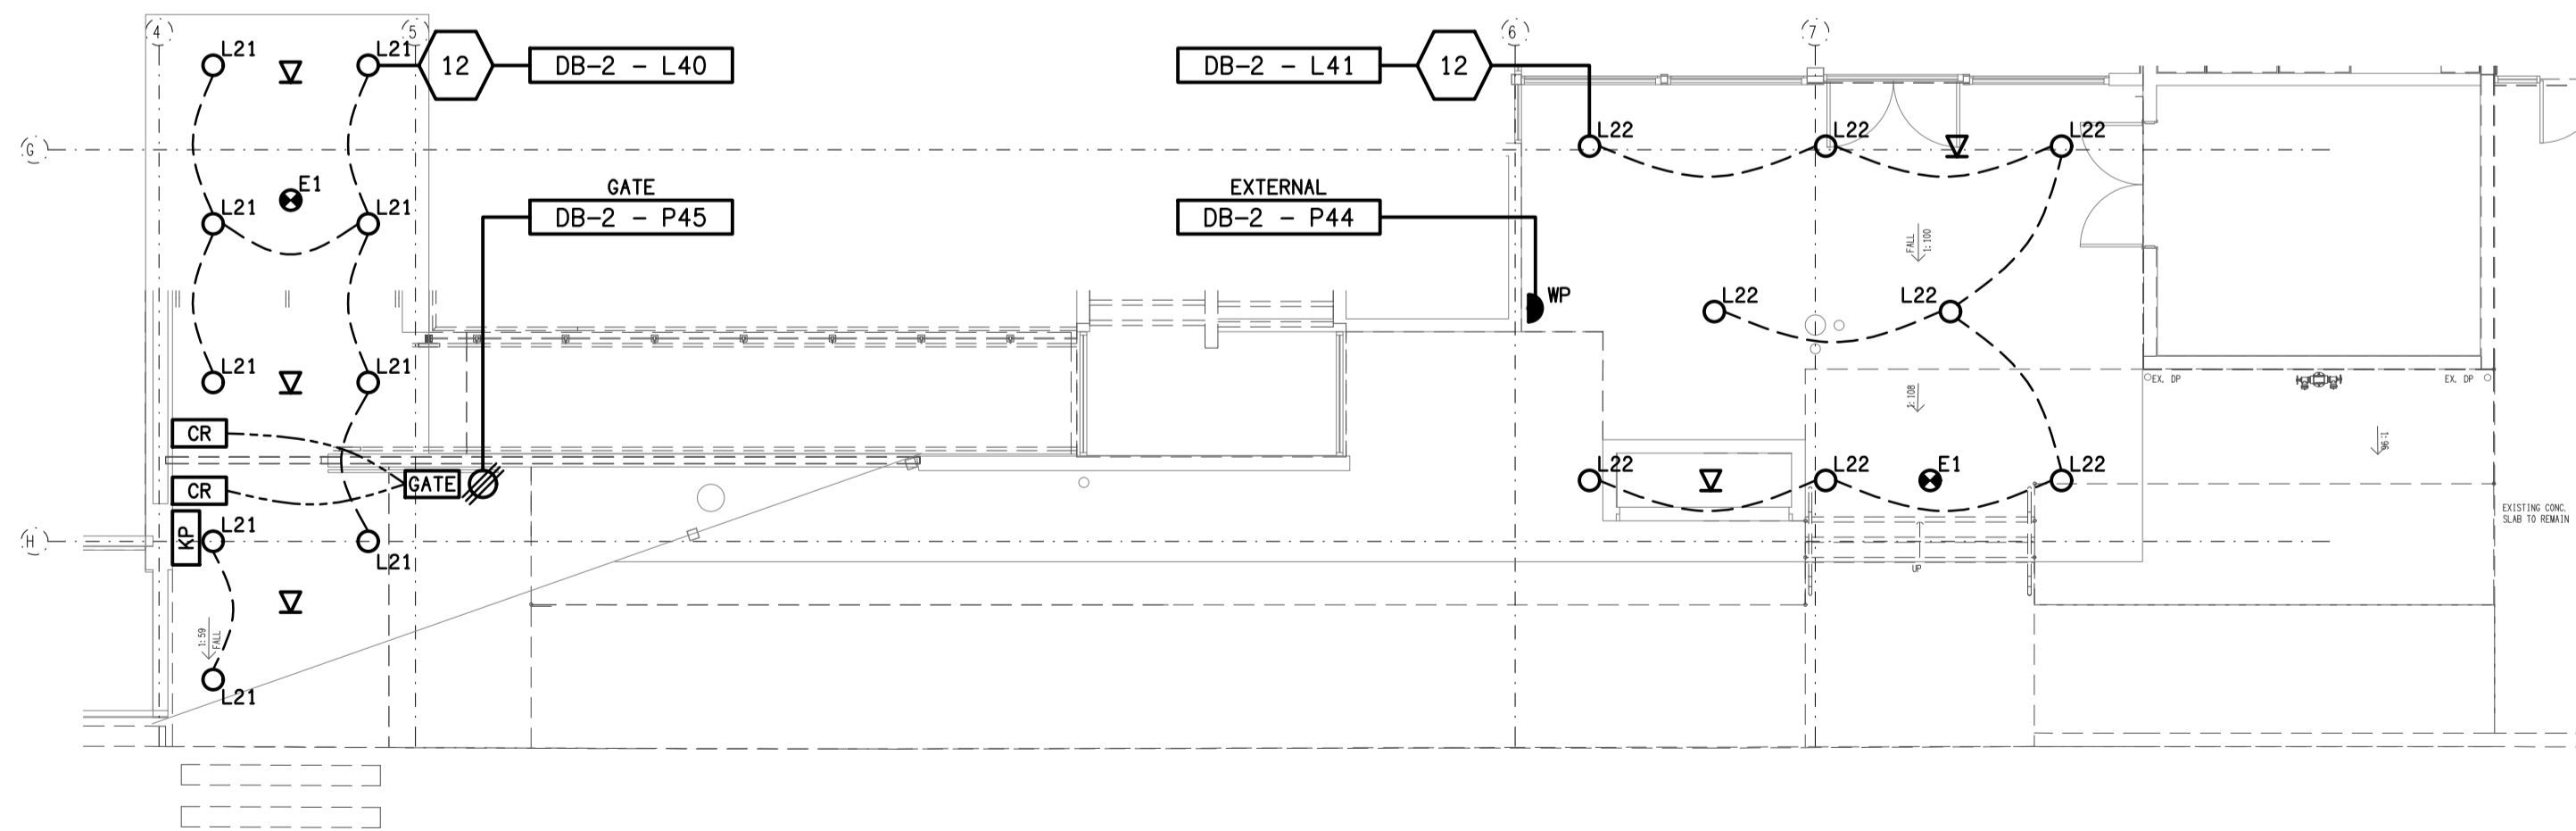

**WESTERN AWNING**  
FLOOR / REFLECTED CEILING PLAN  
SCALE 1:100

ELECTRICAL DESIGN GROUP BRISBANE  
PTY LTD  
ACN 092 710 793  
TRADING AS:  
ELECTRICAL DESIGN GROUP

THE COPYRIGHT OF THIS DRAWING  
REMAINS THE PROPERTY OF THE  
ELECTRICAL DESIGN GROUP.  
USE FIGURED DIMENSIONS  
IN PREFERENCE TO SCALE.  
ALL DIMENSIONS TO BE  
VERIFIED ONSITE.

**ELECTRICAL DESIGN GROUP**  
ELECTRICAL BUILDING SERVICES CONSULTANTS  
BRISBANE GOLD COAST

P.O.Box 15, Sherwood Q.4075  
Phone: (07) 3278 4375  
Email: brisbane@edg.net.au  
Web: www.edg.net.au

PROJECT:  
**ST JOHN'S ANGLICAN COLLEGE  
FOREST LAKE  
AQUATIC CENTRE STAGE 1  
COLLEGE AVENUE, FOREST LAKE**

C	CONSTRUCTION	02/09/2024
REV.	DESCRIPTION:	DATE:

DRAWING: <b>ELECTRICAL SERVICES WESTERN AWNING PLAN &amp; EXTERNAL ELEVATIONS</b>			
SCALE: 1:100	PROJECT NO: <b>C3120a</b>	DRAWING NO: <b>E09</b>	REVISION: <b>C</b>