


ELECTRICAL SERVICES
WITHIN THIS DASH LINED
AREA ARE TO BE REMOVED

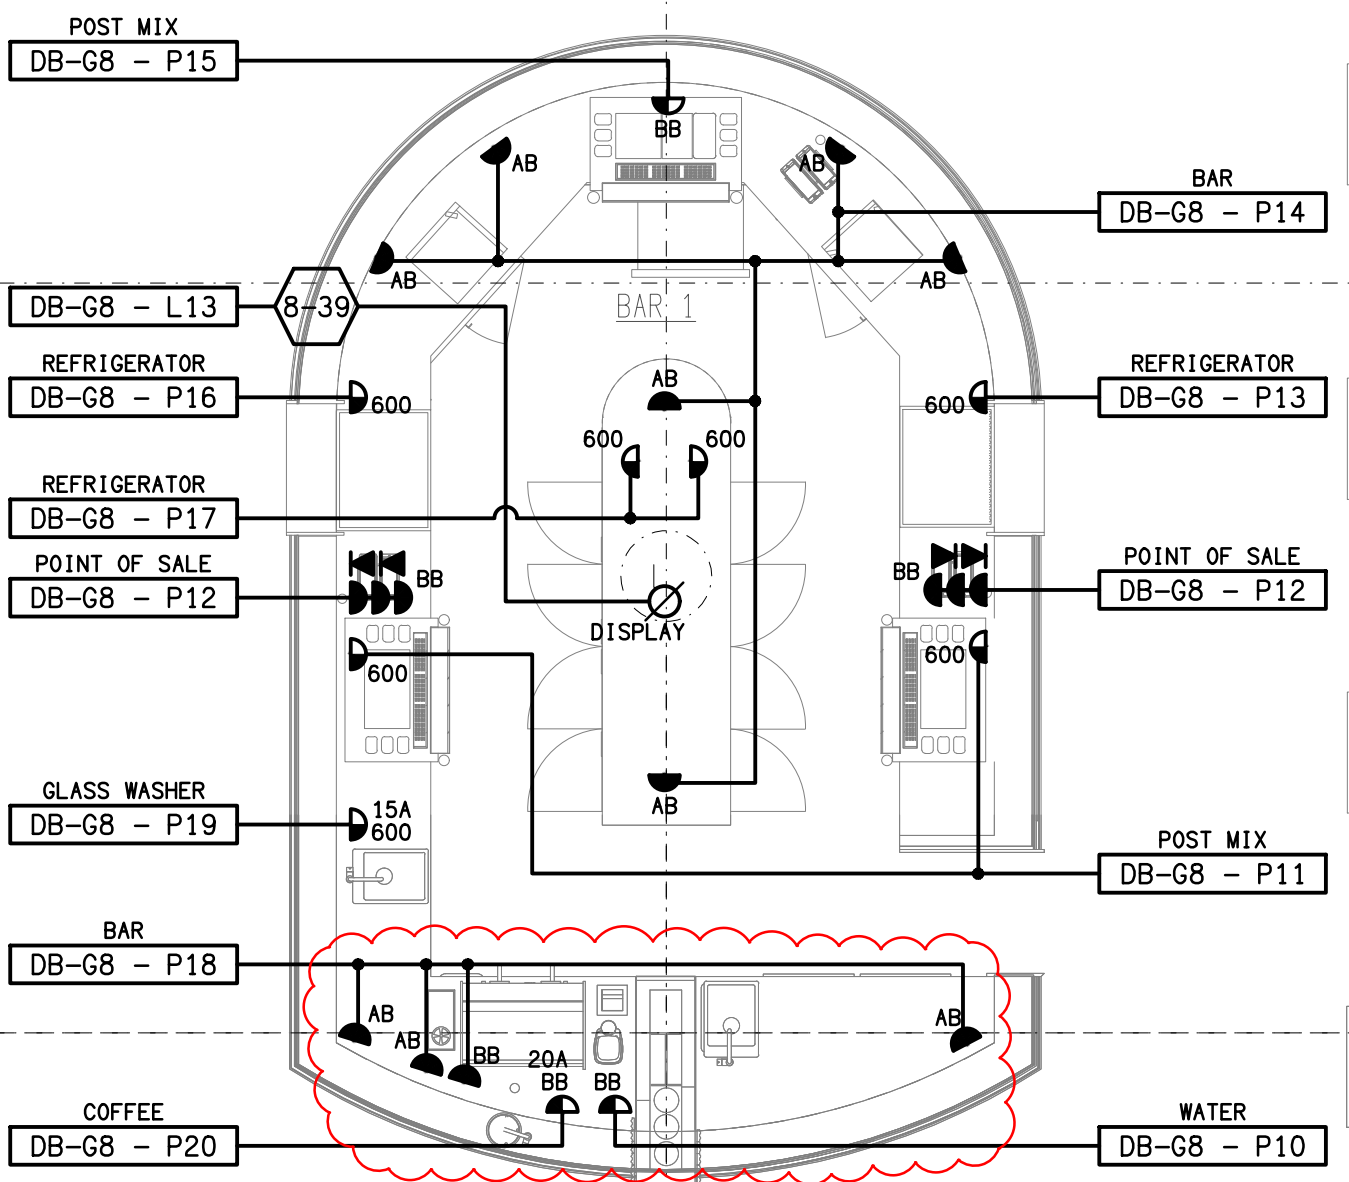

DETAIL A
BISTRO BAR FLOOR PLAN
SCALE 1:50

G	CONSTRUCTION	12/09/2025
REV:	DESCRIPTION:	DATE:

ELECTRICAL DESIGN GROUP
ELECTRICAL BUILDING SERVICES CONSULTANTS

BRISBANE: P.O. Box 15 Sherwood Qld 4075
Phone: (07) 3278 4375
Email: brisbane@edg.net.au
Web: www.edg.net.au

ELECTRICAL DESIGN GROUP BRISBANE PTY LTD
ACN 092 710 793

TRADING AS:
ELECTRICAL DESIGN
GROUP

PROJECT:
**SUNNYBANK COMMUNITY
SPORTS CLUB**

SITE ADDRESS:
**470 McCULLOUGH STREET
SUNNYBANK**

SCALE: 1:100 UNO SHEET SIZE: AT A1

DRAWING TITLE:

**ELECTRICAL SERVICES
BISTRO & BAR
FLOOR PLAN**

PROJECT NO: DRAWING NO: REVISION:

C3179a E05 G