



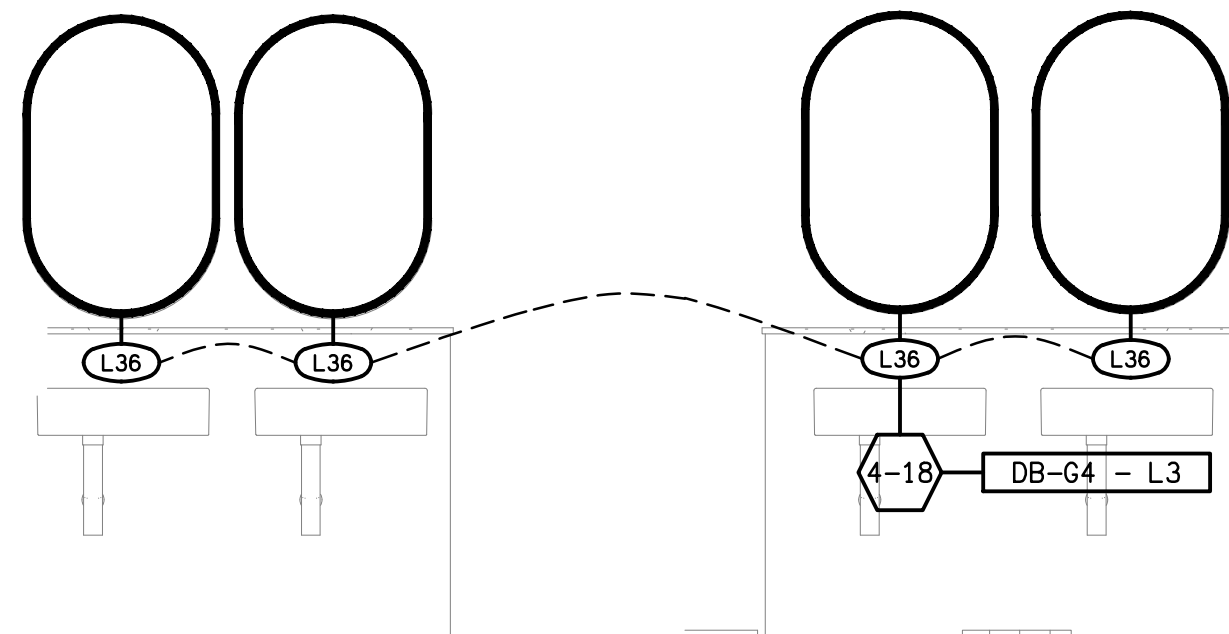


DETAIL A
FEMALE WC ELEVATION
SCALE 1:25


DETAIL B
MALE WC ELEVATION
SCALE 1:25

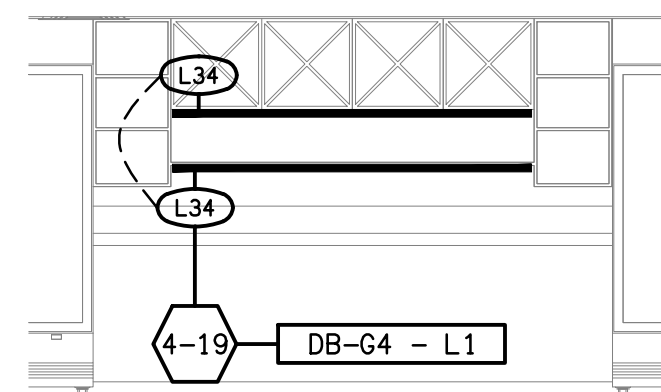

DETAIL C
BAR REAR WALL ELEVATION
SCALE 1:50

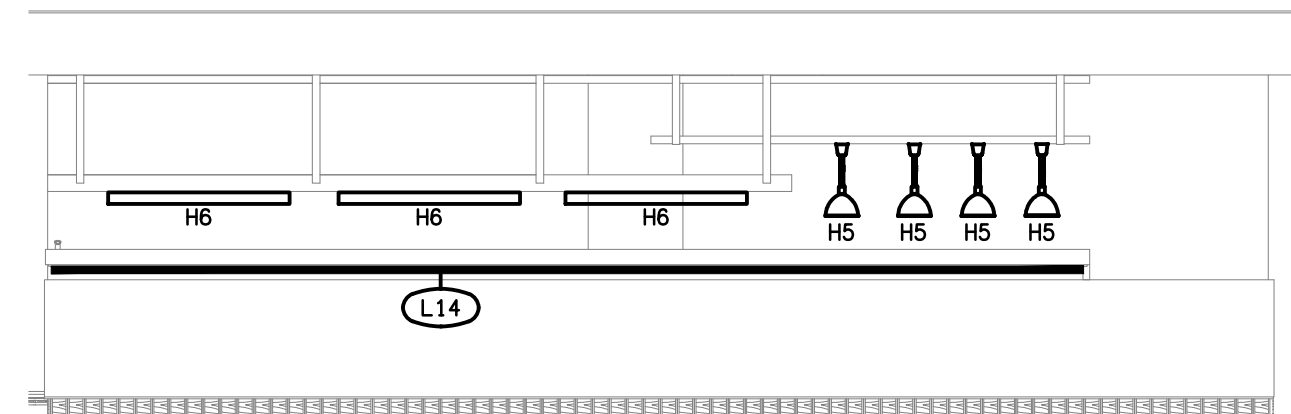

DETAIL D
SERVERY COUNTER ELEVATION
SCALE 1:50

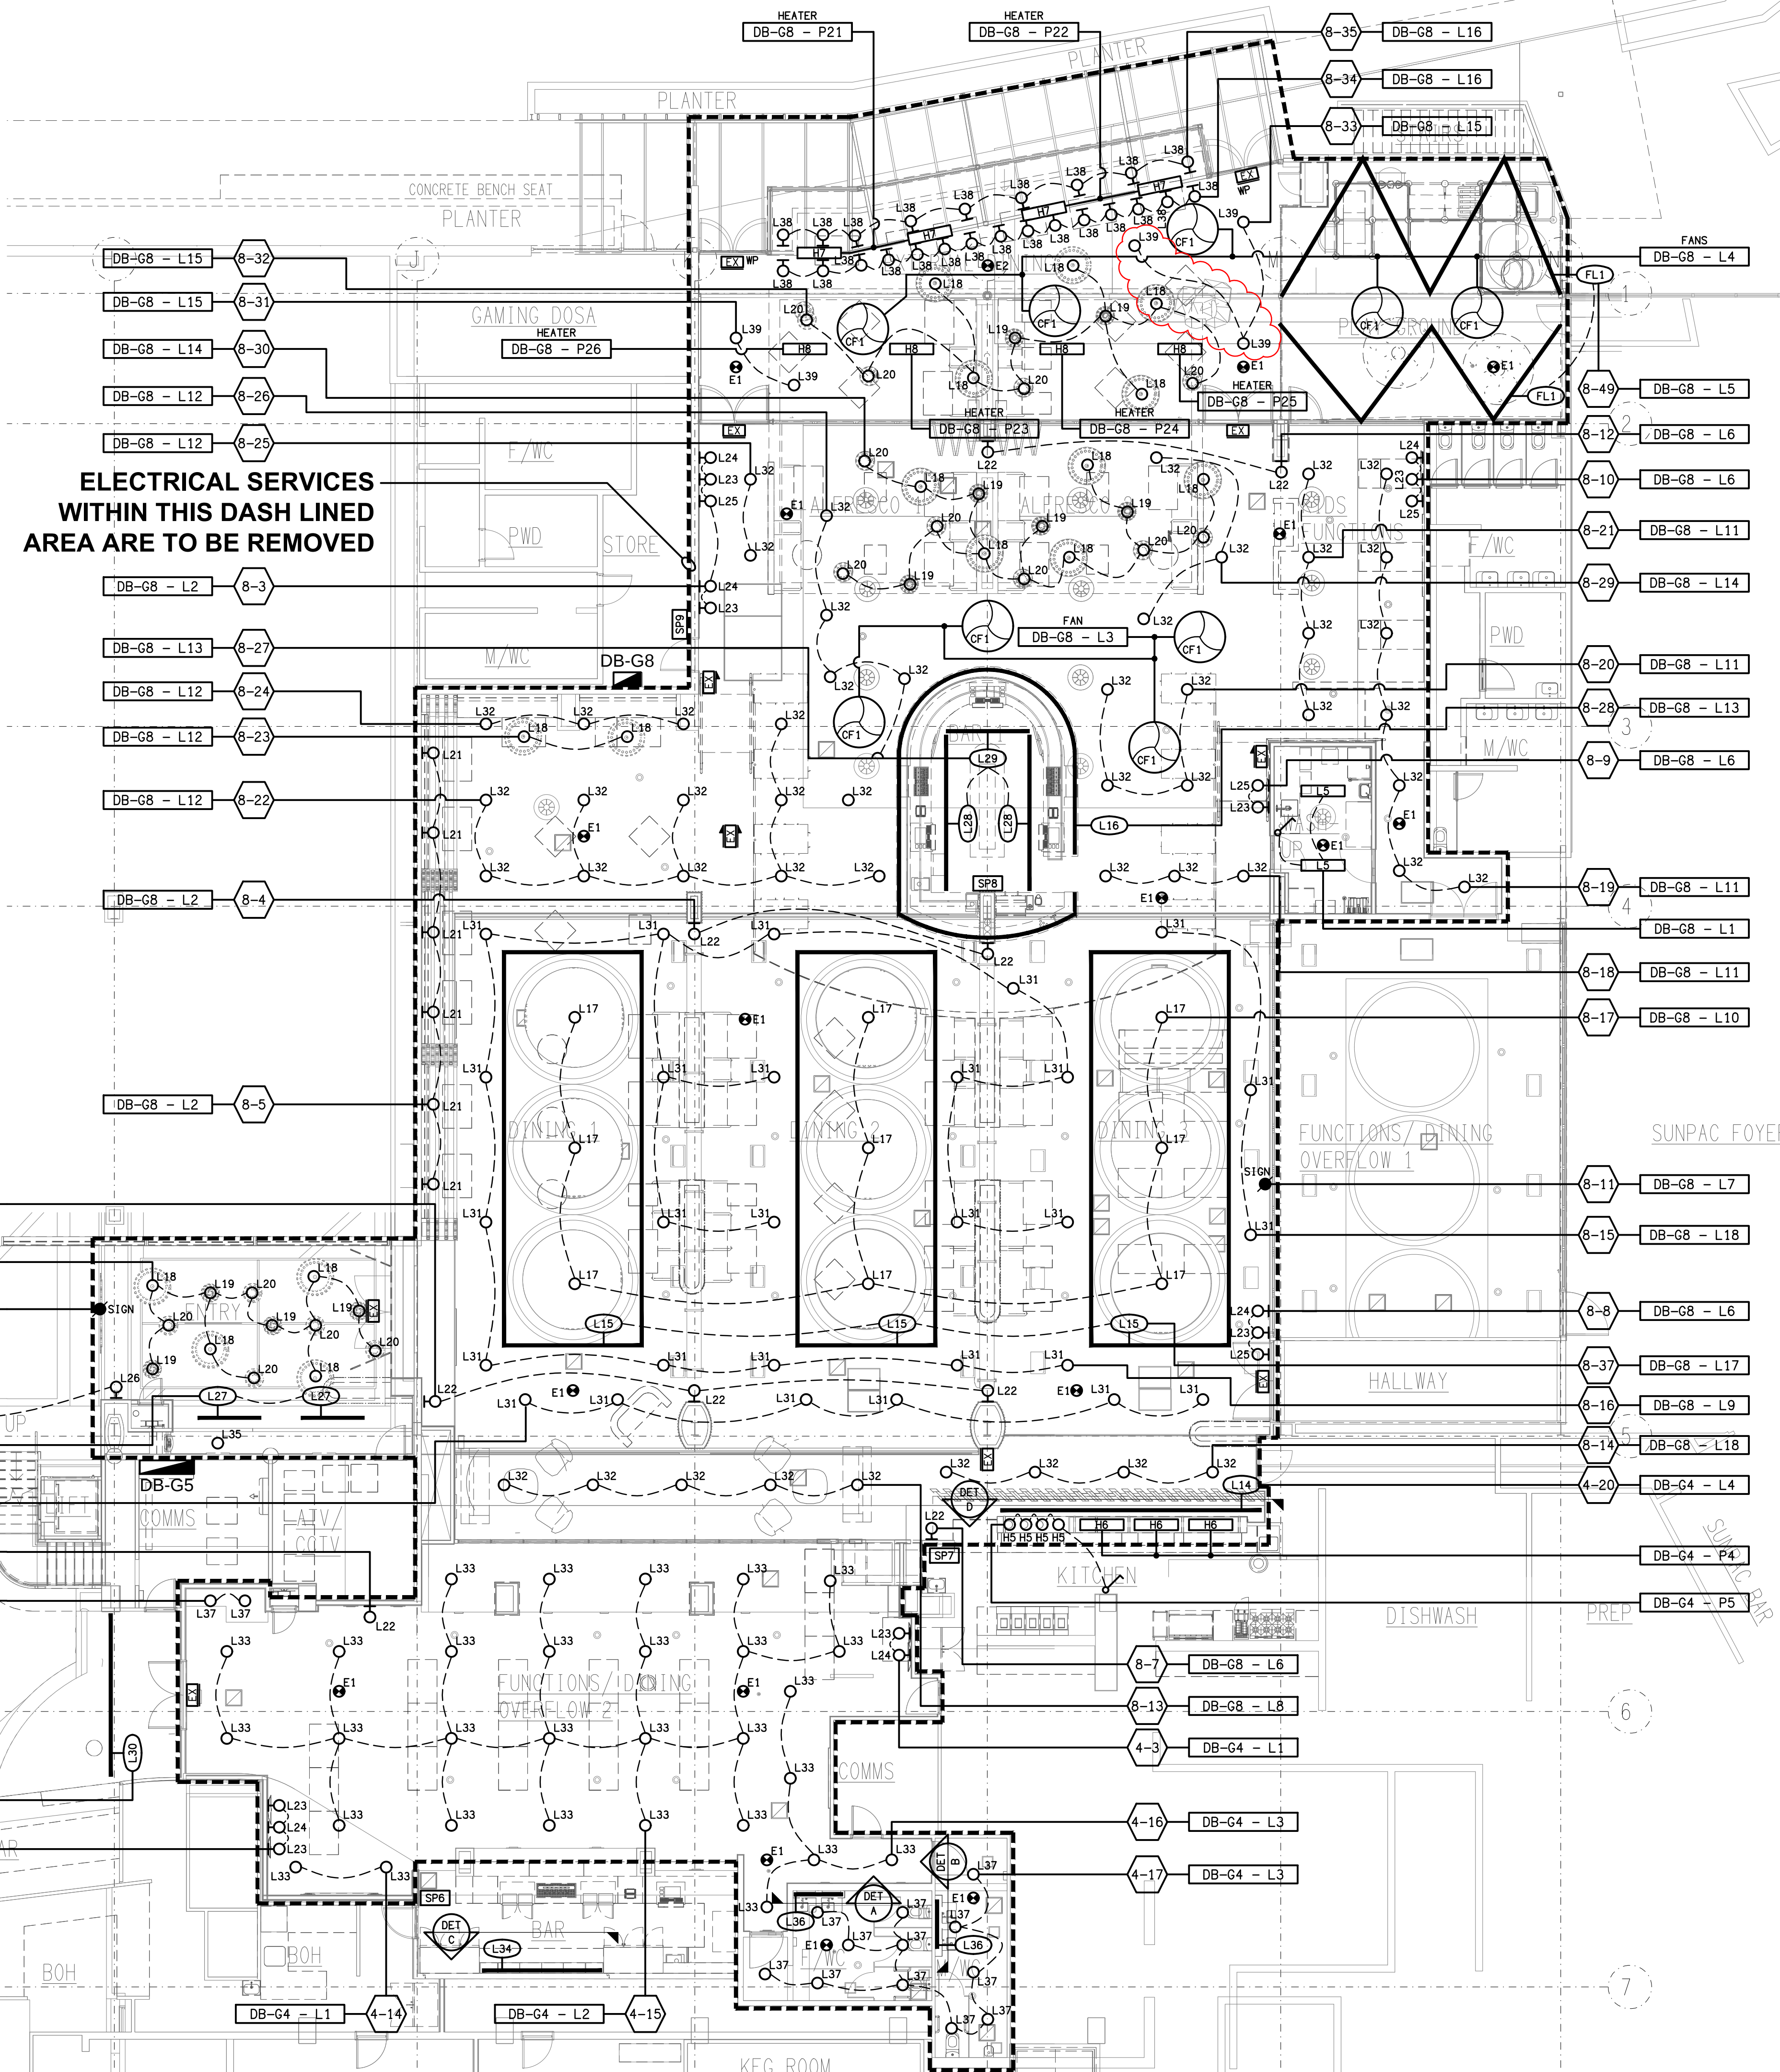

**ELECTRICAL SERVICES
WITHIN THIS DASH LINED
AREA ARE TO BE REMOVED**

THE COPYRIGHT OF THIS DRAWING REMAINS THE PROPERTY OF
THE ELECTRICAL DESIGN GROUP.

USE FIGURED DIMENSIONS IN PREFERENCE TO SCALE.

ALL DIMENSIONS TO BE VERIFIED ONSITE.

G	CONSTRUCTION	25/07/2025
REV:	DESCRIPTION:	DATE:

ELECTRICAL DESIGN GROUP
ELECTRICAL BUILDING SERVICES CONSULTANTS

BRISBANE: P.O. Box 15 Sherwood Qld 4075
Phone: (07) 3278 4375
Email: brisbane@edg.net.au
Web: www.edg.net.au

ELECTRICAL DESIGN GROUP BRISBANE PTY LTD
ACN 092 710 793

TRADING AS:
ELECTRICAL DESIGN
GROUP

PROJECT:
**SUNNYBANK COMMUNITY
SPORTS CLUB**

SITE ADDRESS:
470 McCULLOUGH STREET
SUNNYBANK

SCALE: 1:100 UNO
SHEET SIZE: AT A1

DRAWING TITLE:

**ELECTRICAL SERVICES
BISTRO & BAR
REFLECTED CEILING PLAN**

PROJECT NO: DRAWING NO: REVISION:

C3179a E06 G