


DETAIL A
STAFF KITCHENETTE ELEVATION
SCALE 1:25

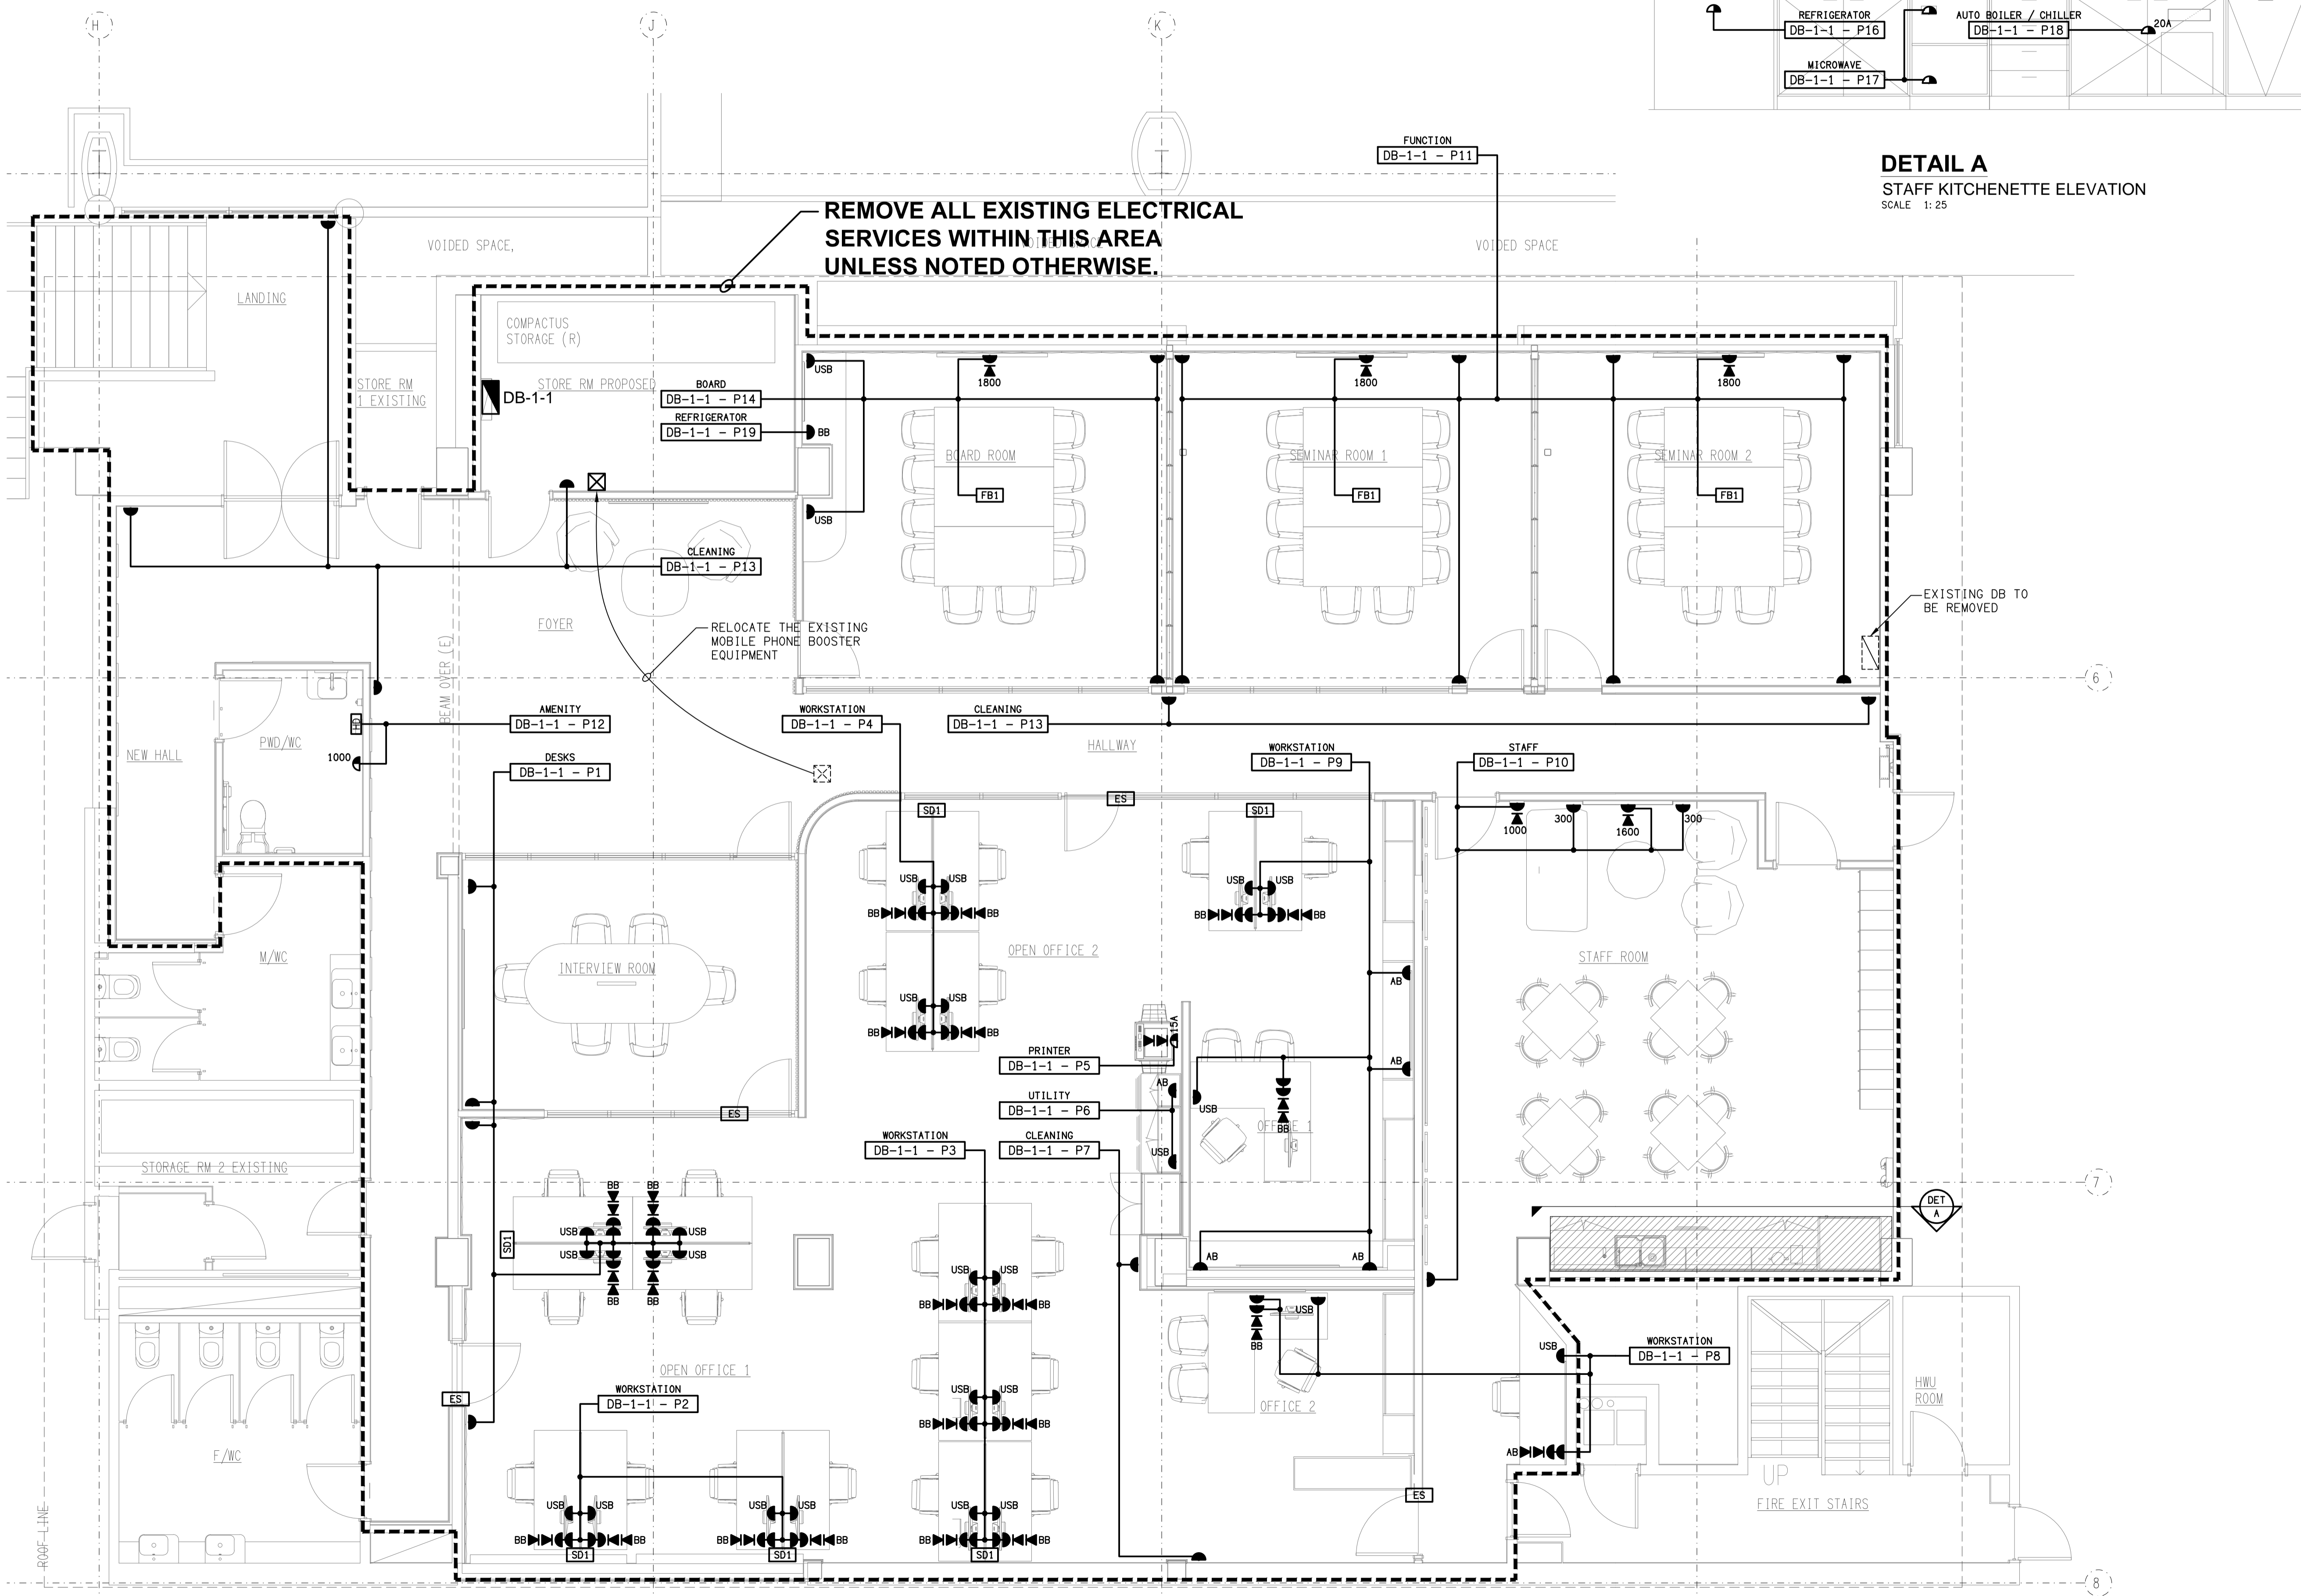

REMOVE ALL EXISTING ELECTRICAL SERVICES WITHIN THIS AREA UNLESS NOTED OTHERWISE.

E	CONSTRUCTION	12/02/2025
REV:	DESCRIPTION:	DATE:

ELECTRICAL DESIGN GROUP
ELECTRICAL BUILDING SERVICES CONSULTANTS

BRISBANE: P.O. Box 15 Sherwood Qld 4075
Phone: (07) 3278 4375
Email: brisbane@edg.net.au
Web: www.edg.net.au

ELECTRICAL DESIGN GROUP BRISBANE PTY LTD
ACN 092 710 793

TRADING AS:
ELECTRICAL DESIGN GROUP

PROJECT:
SUNNYBANK COMMUNITY SPORTS CLUB

SITE ADDRESS:
470 McCULLOUGH STREET
SUNNYBANK

SCALE: 1:50 UNO SHEET SIZE: AT A1

DRAWING TITLE:
**ELECTRICAL SERVICES
LEVEL 1 OFFICE
FLOOR PLAN**

PROJECT NO. DRAWING NO. REVISION:
C3179a E08 E