



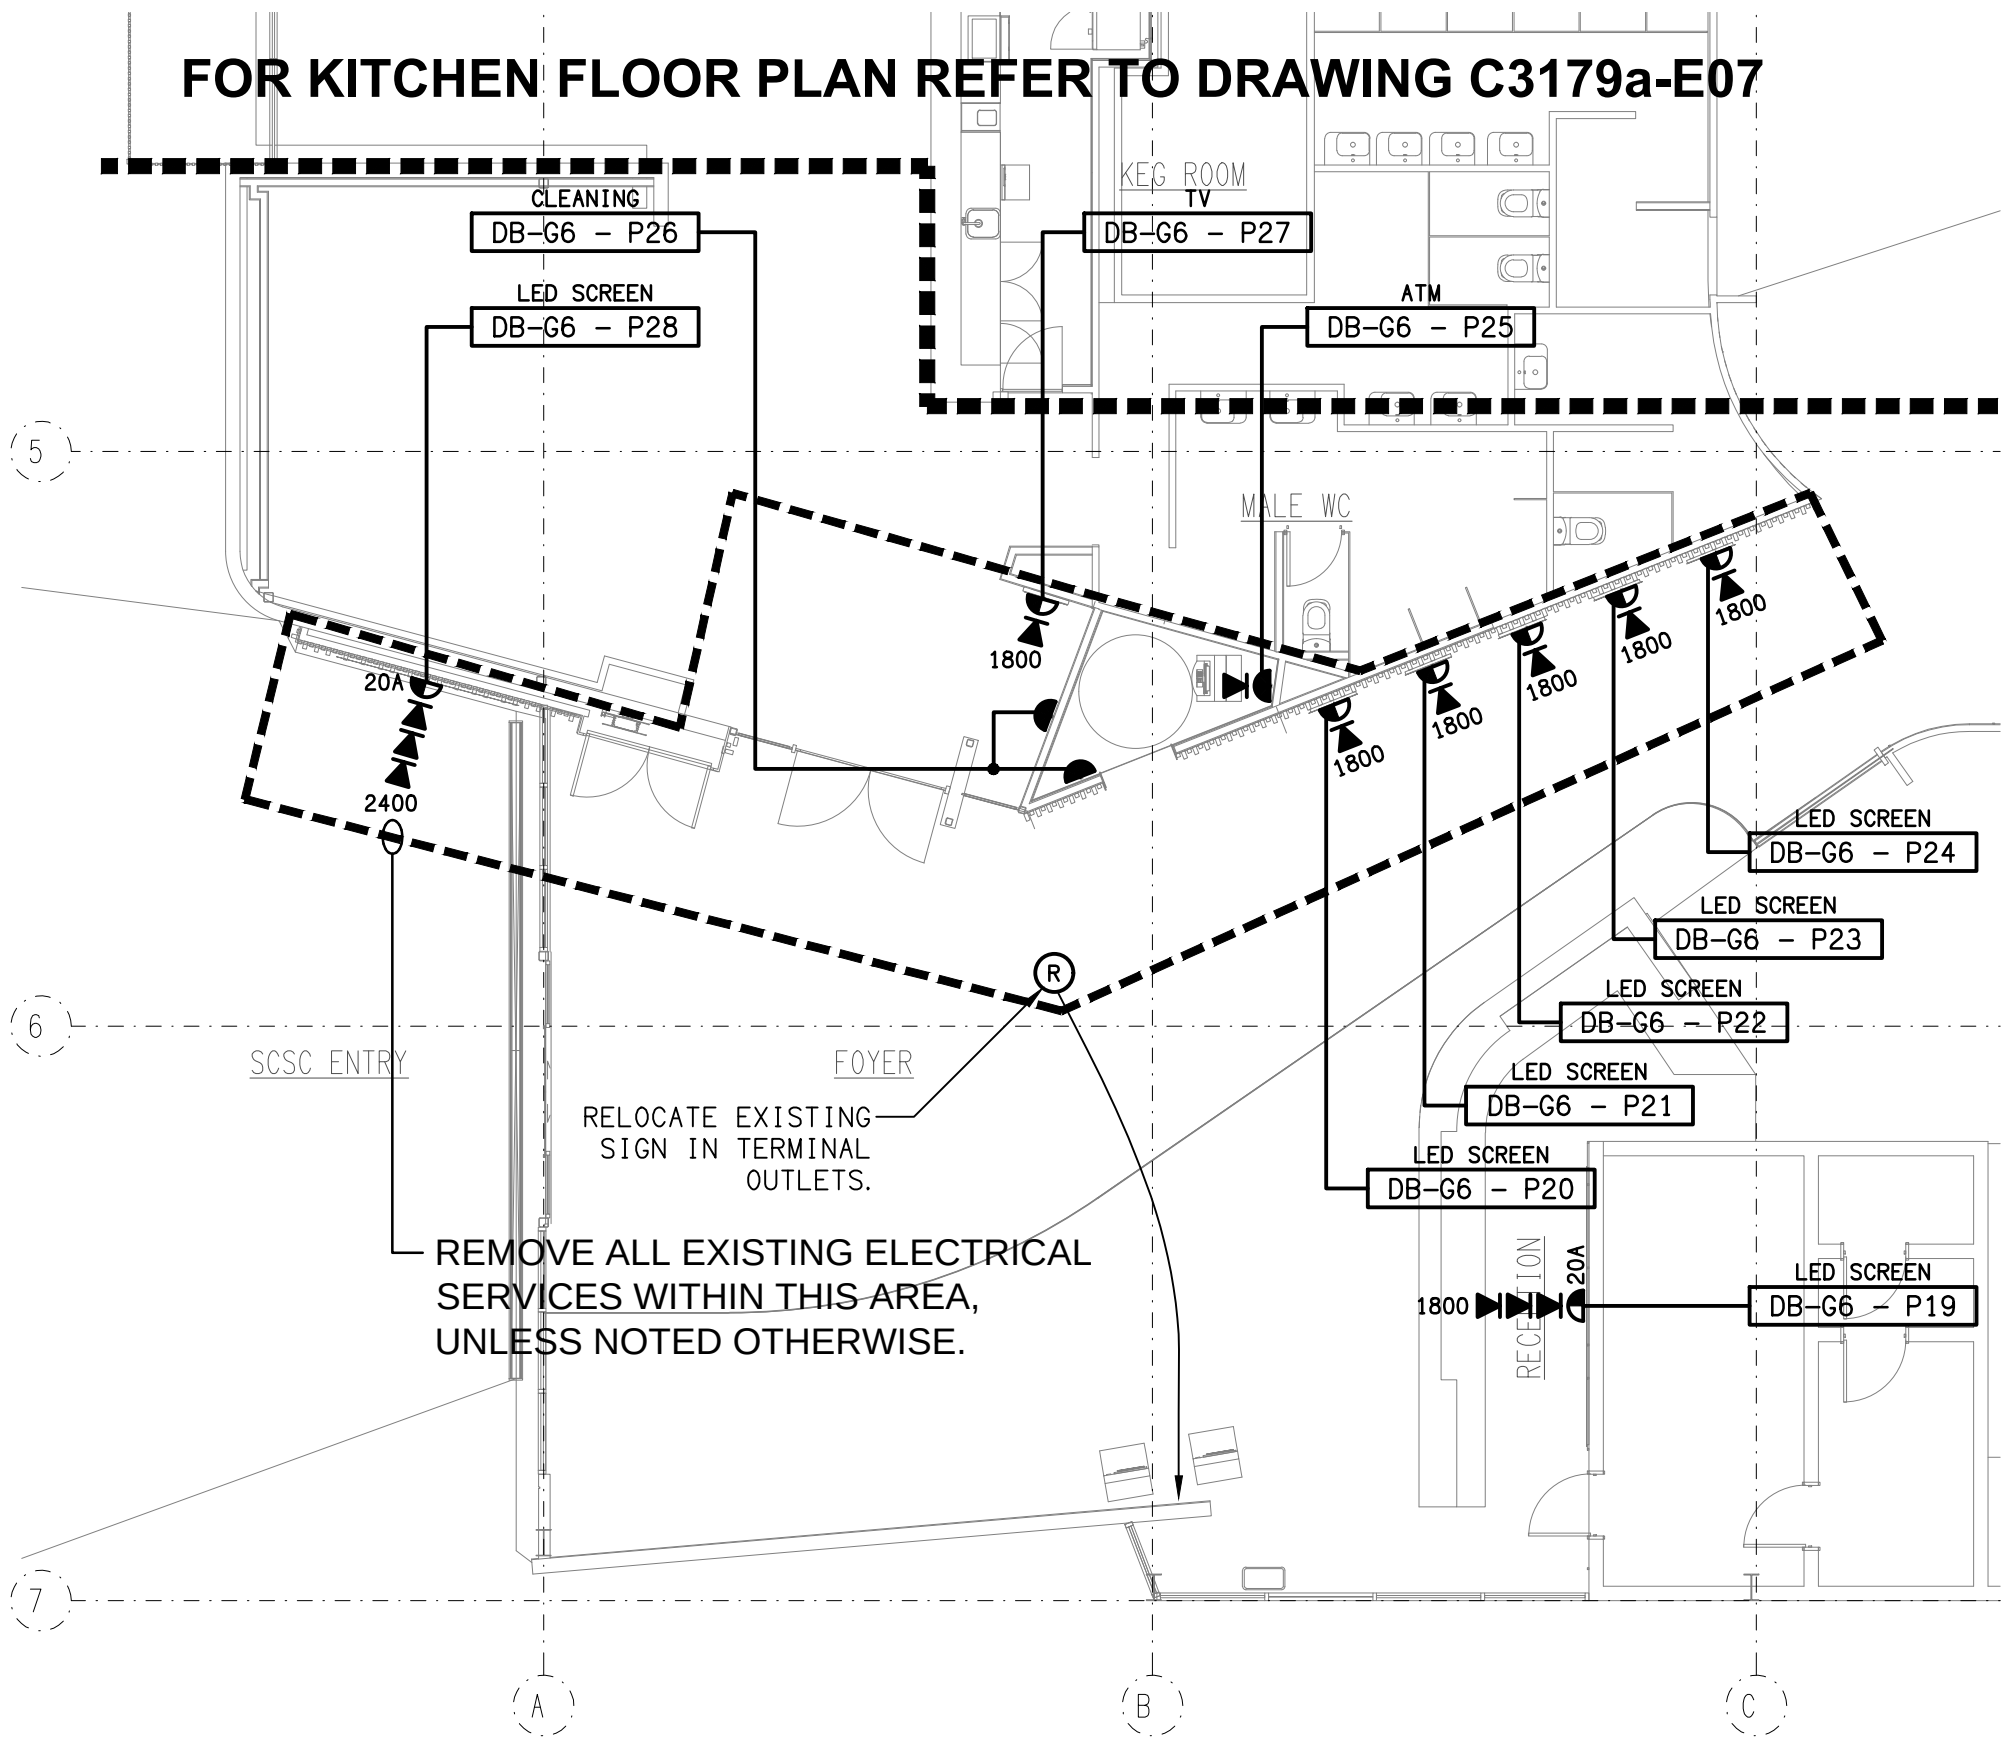

FLOOR PLAN
PROPOSED FOYER
SCALE 1: 100

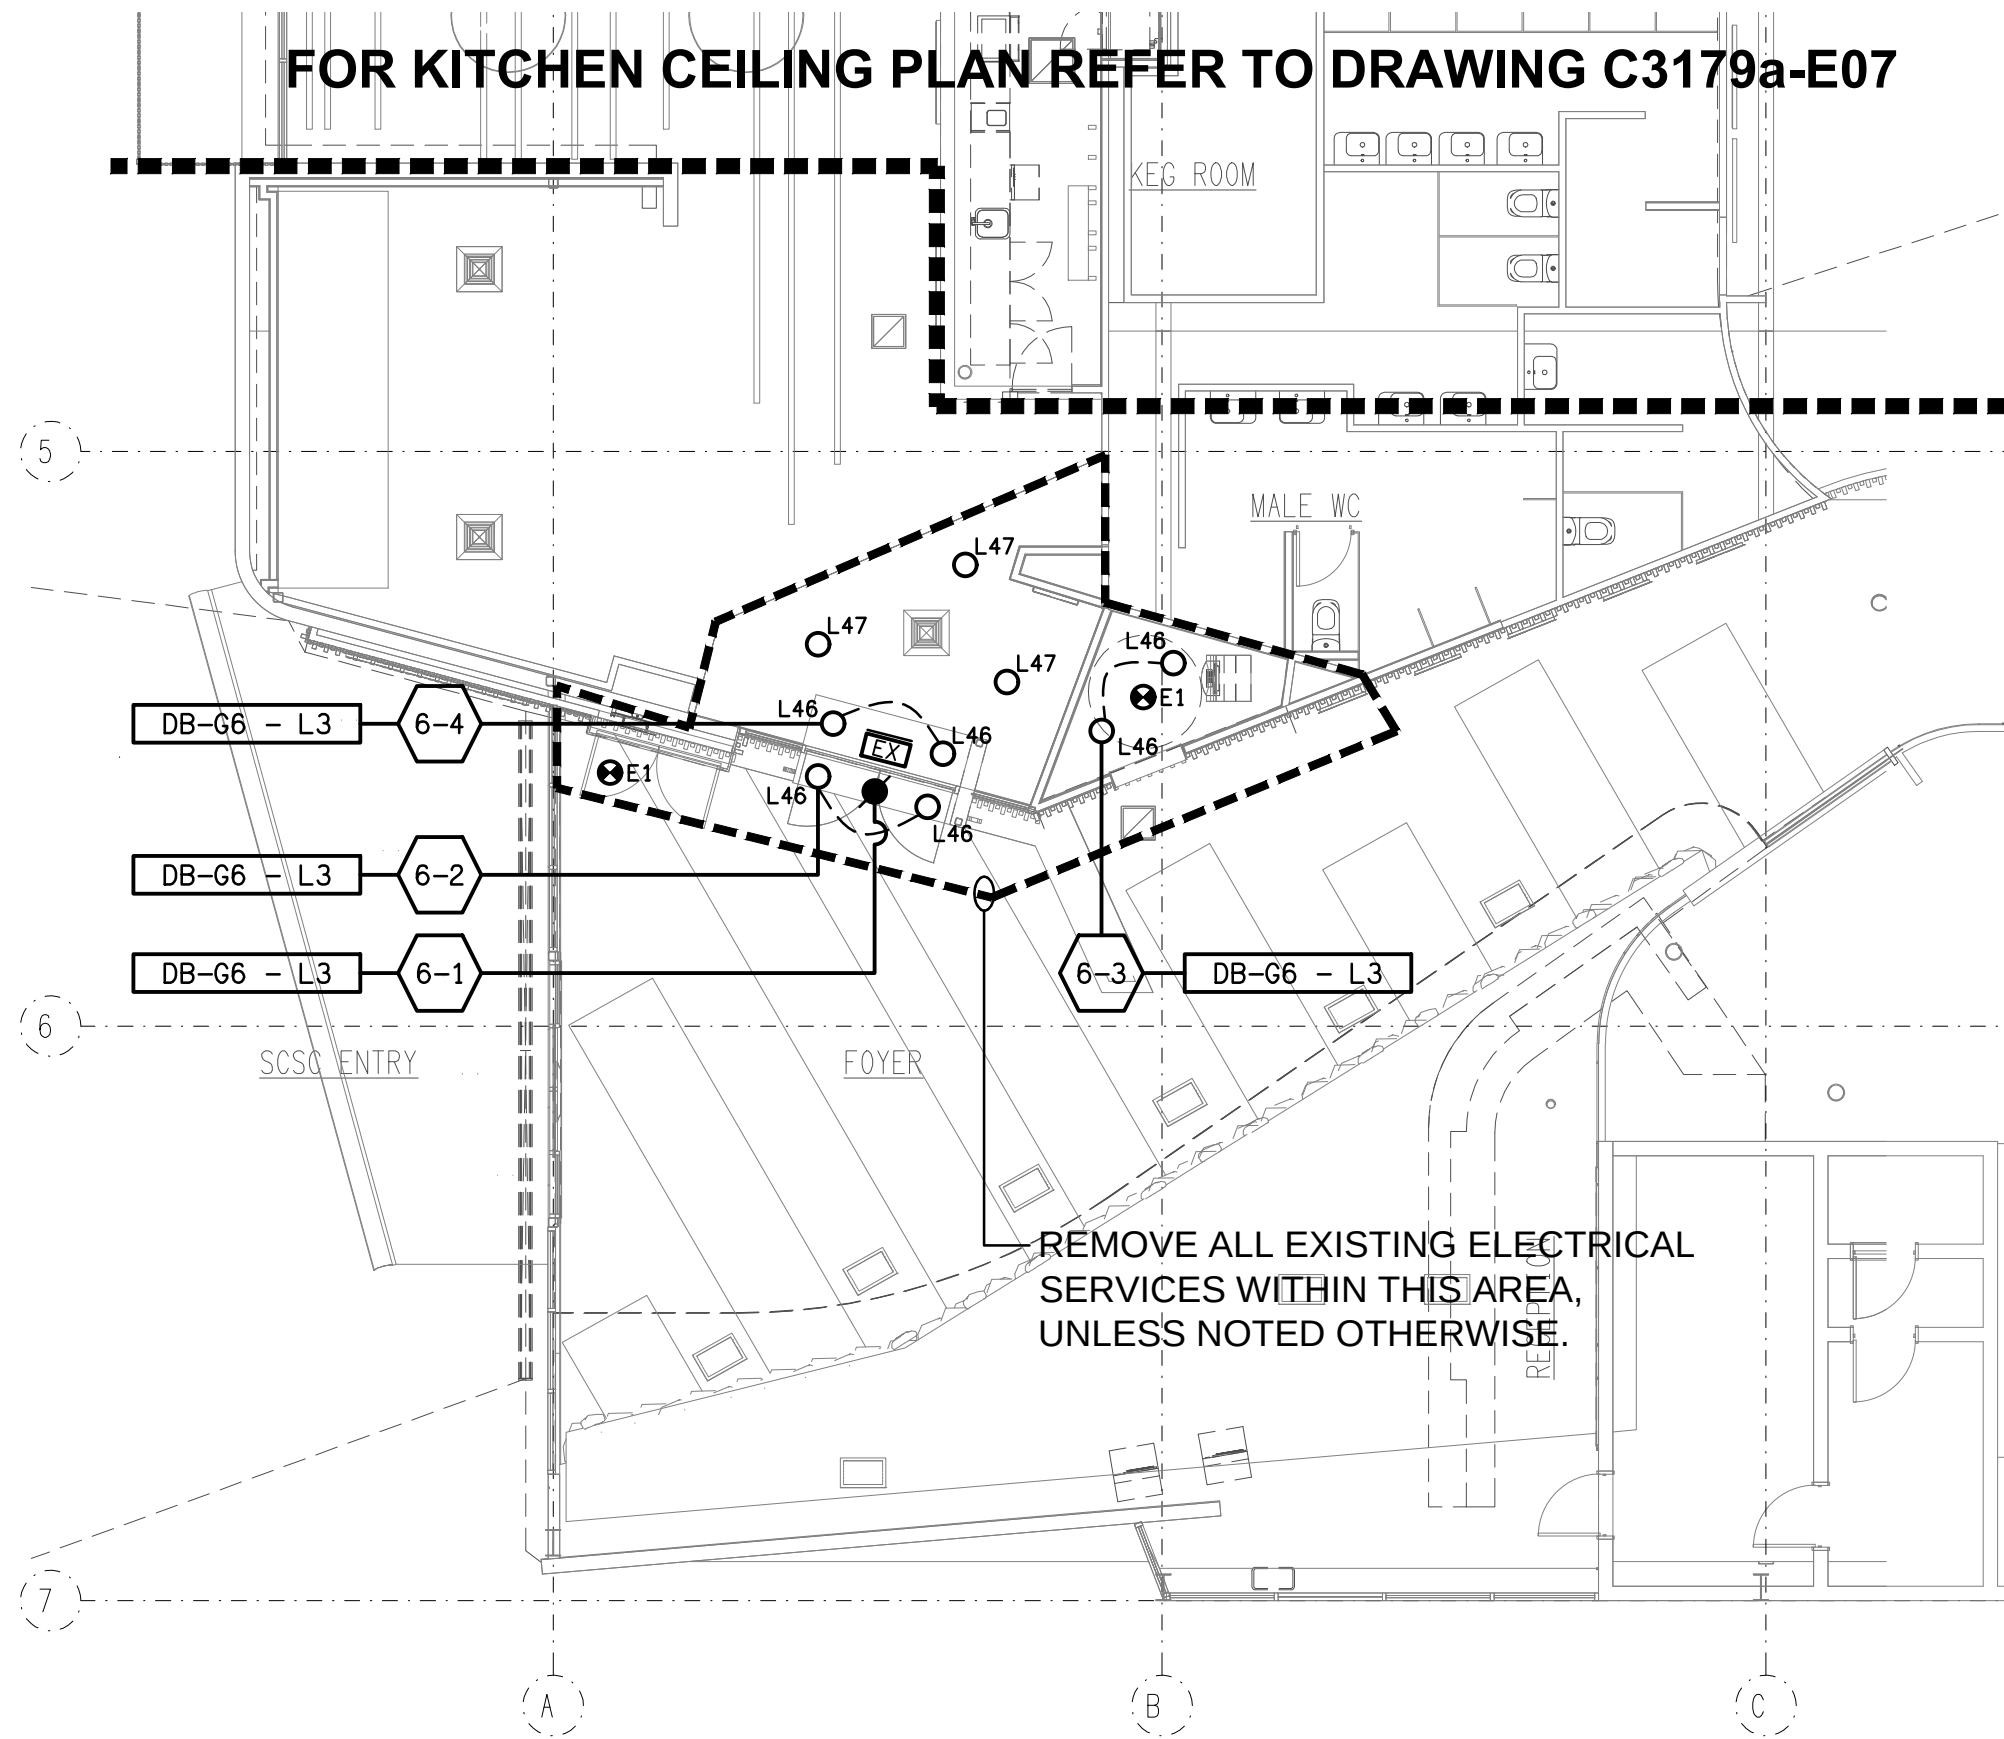

REFLECTED CEILING PLAN
PROPOSED FOYER
SCALE 1: 100

A	CONSTRUCTION	04/08/2025
REV:	DESCRIPTION:	DATE:

ELECTRICAL DESIGN GROUP
ELECTRICAL BUILDING SERVICES CONSULTANTS

BRISBANE: P.O. Box 15 Sherwood Qld 4075
Phone: (07) 3278 4375
Email: brisbane@edg.net.au
Web: www.edg.net.au

ELECTRICAL DESIGN GROUP BRISBANE PTY LTD
ACN 092 710 793

TRADING AS:
ELECTRICAL DESIGN
GROUP

PROJECT:

**SUNNYBANK COMMUNITY
SPORTS CLUB**

SITE ADDRESS:

470 McCULLOUGH STREET
SUNNYBANK

SCALE: SHEET SIZE:

1:100 UNO AT A1

DRAWING TITLE:

**ELECTRICAL SERVICES
GROUND LEVEL
FOYER PLANS**

PROJECT NO: DRAWING NO: REVISION:

C3179a E10 A