


SITE PLAN
EXISTING POWER DISTRIBUTION
SCALE 1: 500

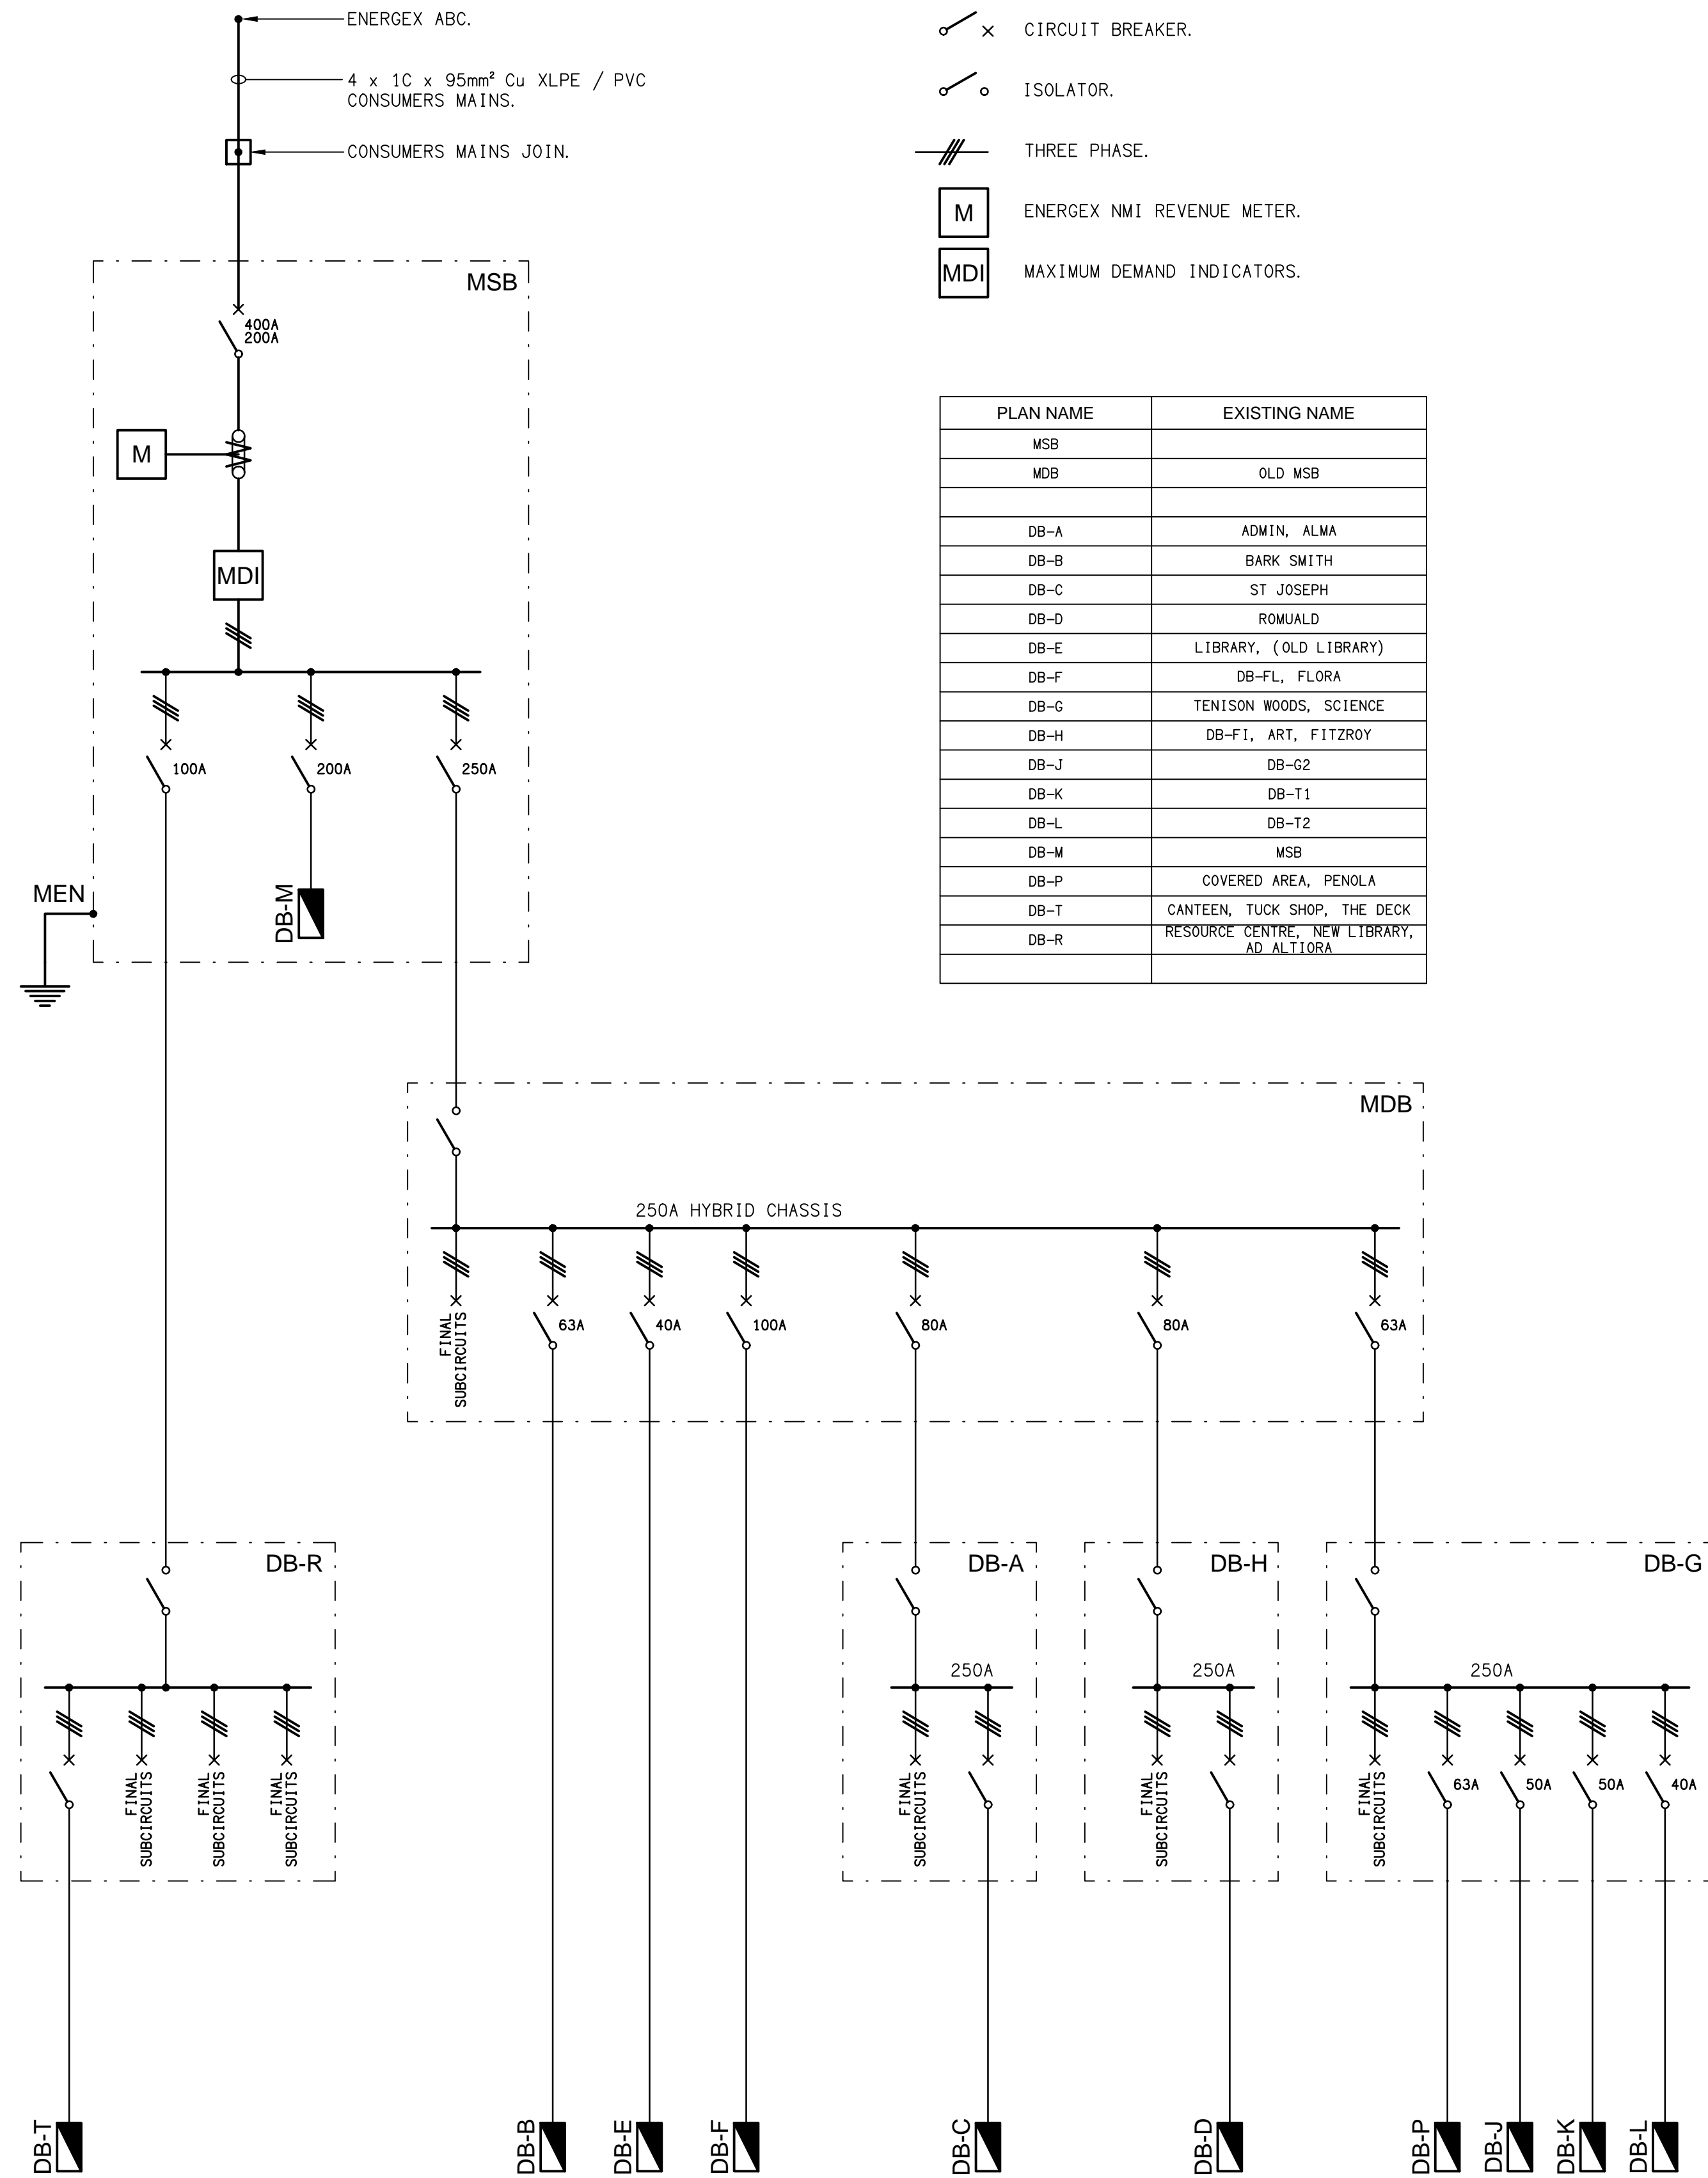

LEGEND:

- CIRCUIT BREAKER.
- ISOLATOR.
- THREE PHASE.
- ENERGEN NMI REVENUE METER.
- MAXIMUM DEMAND INDICATORS.

PLAN NAME	EXISTING NAME
MSB	
MDB	OLD MSB
DB-A	ADMIN, ALMA
DB-B	BARK SMITH
DB-C	ST JOSEPH
DB-D	ROMUALD
DB-E	LIBRARY, (OLD LIBRARY)
DB-F	DB-FL, FLORA
DB-G	TENISON WOODS, SCIENCE
DB-H	DB-FI, ART, FITZROY
DB-J	DB-G2
DB-K	DB-T1
DB-L	DB-T2
DB-M	MSB
DB-P	COVERED AREA, PENOLA
DB-T	CANTEEN, TUCK SHOP, THE DECK
DB-R	RESOURCE CENTRE, NEW LIBRARY, AD ALTIORA

SCHEMATIC
EXISTING POWER DISTRIBUTION
NOT TO SCALE

ELECTRICAL DESIGN GROUP BRISBANE
PTY LTD
ACN 092 710 793
TRADING AS:
ELECTRICAL DESIGN GROUP

THE COPYRIGHT OF THIS DRAWING
REMAINS THE PROPERTY OF THE
ELECTRICAL DESIGN GROUP.
USE FIGURED DIMENSIONS
IN PREFERENCE TO SCALE.
ALL DIMENSIONS TO BE
VERIFIED ONSITE.

ELECTRICAL DESIGN GROUP
ELECTRICAL BUILDING SERVICES CONSULTANTS
BRISBANE GOLD COAST

P.O.Box 15, Sherwood Q.4075
Phone: (07) 3278 4375
Email: brisbane@edg.net.au
Web: www.edg.net.au

PROJECT:
**OUR LADY'S COLLEGE, ANNERLEY
POWER SUPPLY UPGRADE**

15 CHESTER ROAD, ANNERLEY

B	TENDER	06/02/2025
REV.	DESCRIPTION:	DATE:

DRAWING: ELECTRICAL SERVICES EXISTING POWER DISTRIBUTION SITE PLAN & SCHEMATIC			
SCALE: 1:500	PROJECT NO: C3219a	DRAWING NO: E01	REVISION: B