




SITE PLAN
PROPOSED STAGE 1 DISTRIBUTION
SCALE 1:500

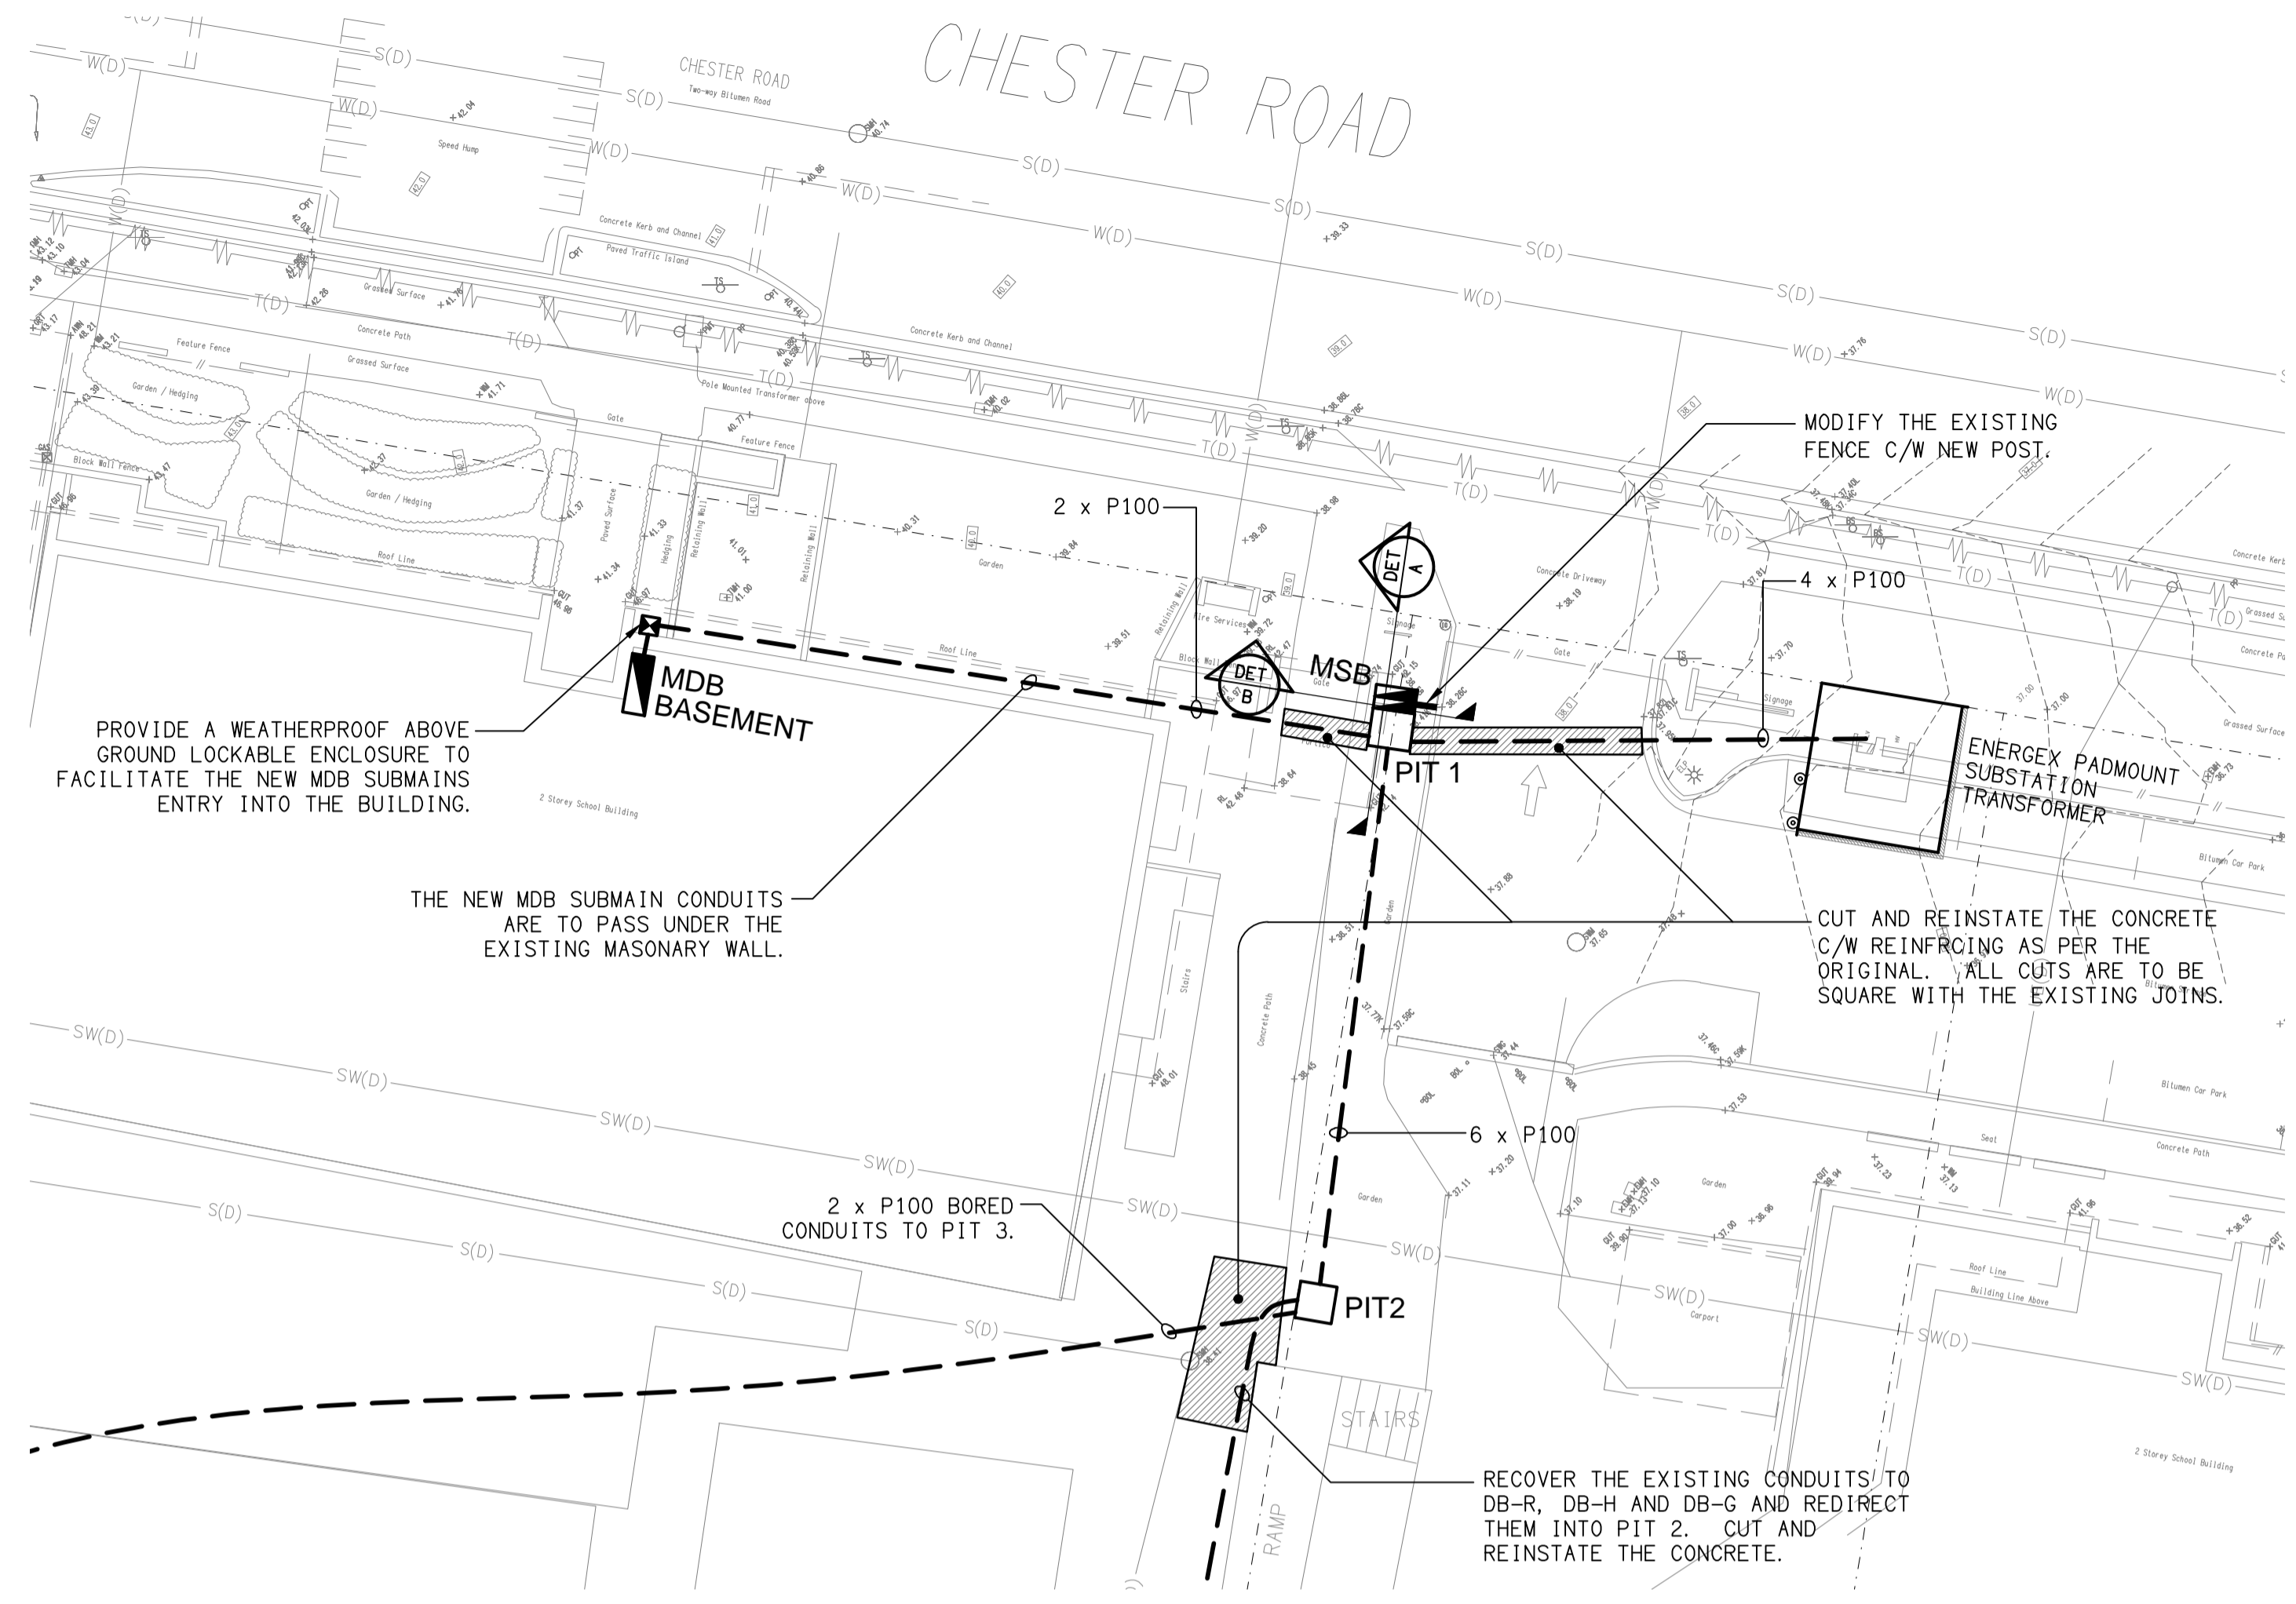

PART PLAN
CONDUIT AND LANDSCAPE WORKS
SCALE 1:200

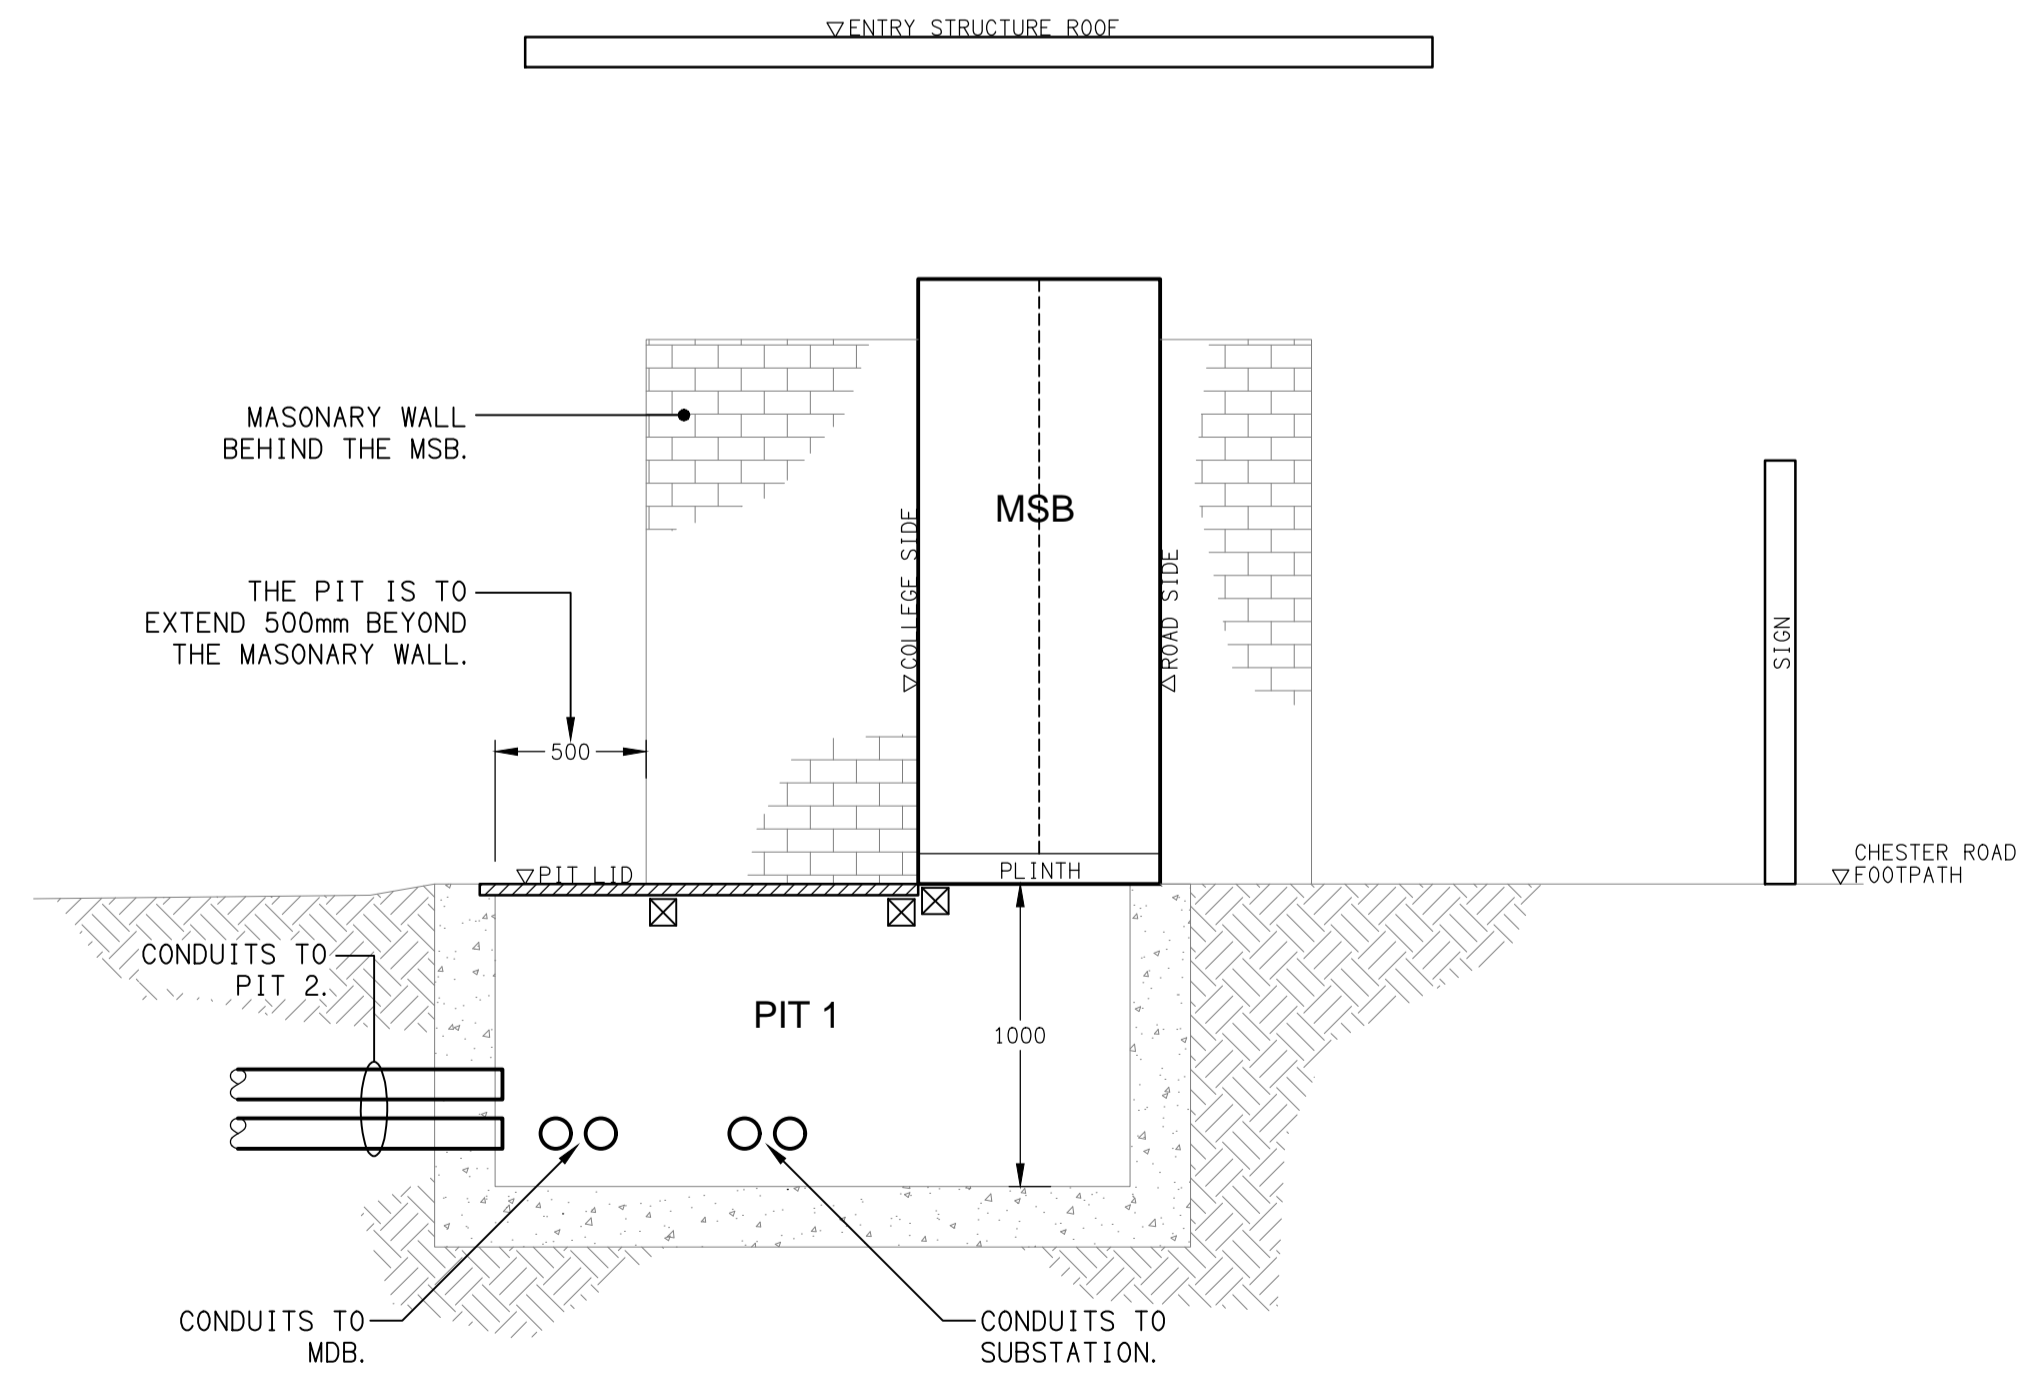

DETAIL A
MSB & PIT 1 SECTION
NOT TO SCALE

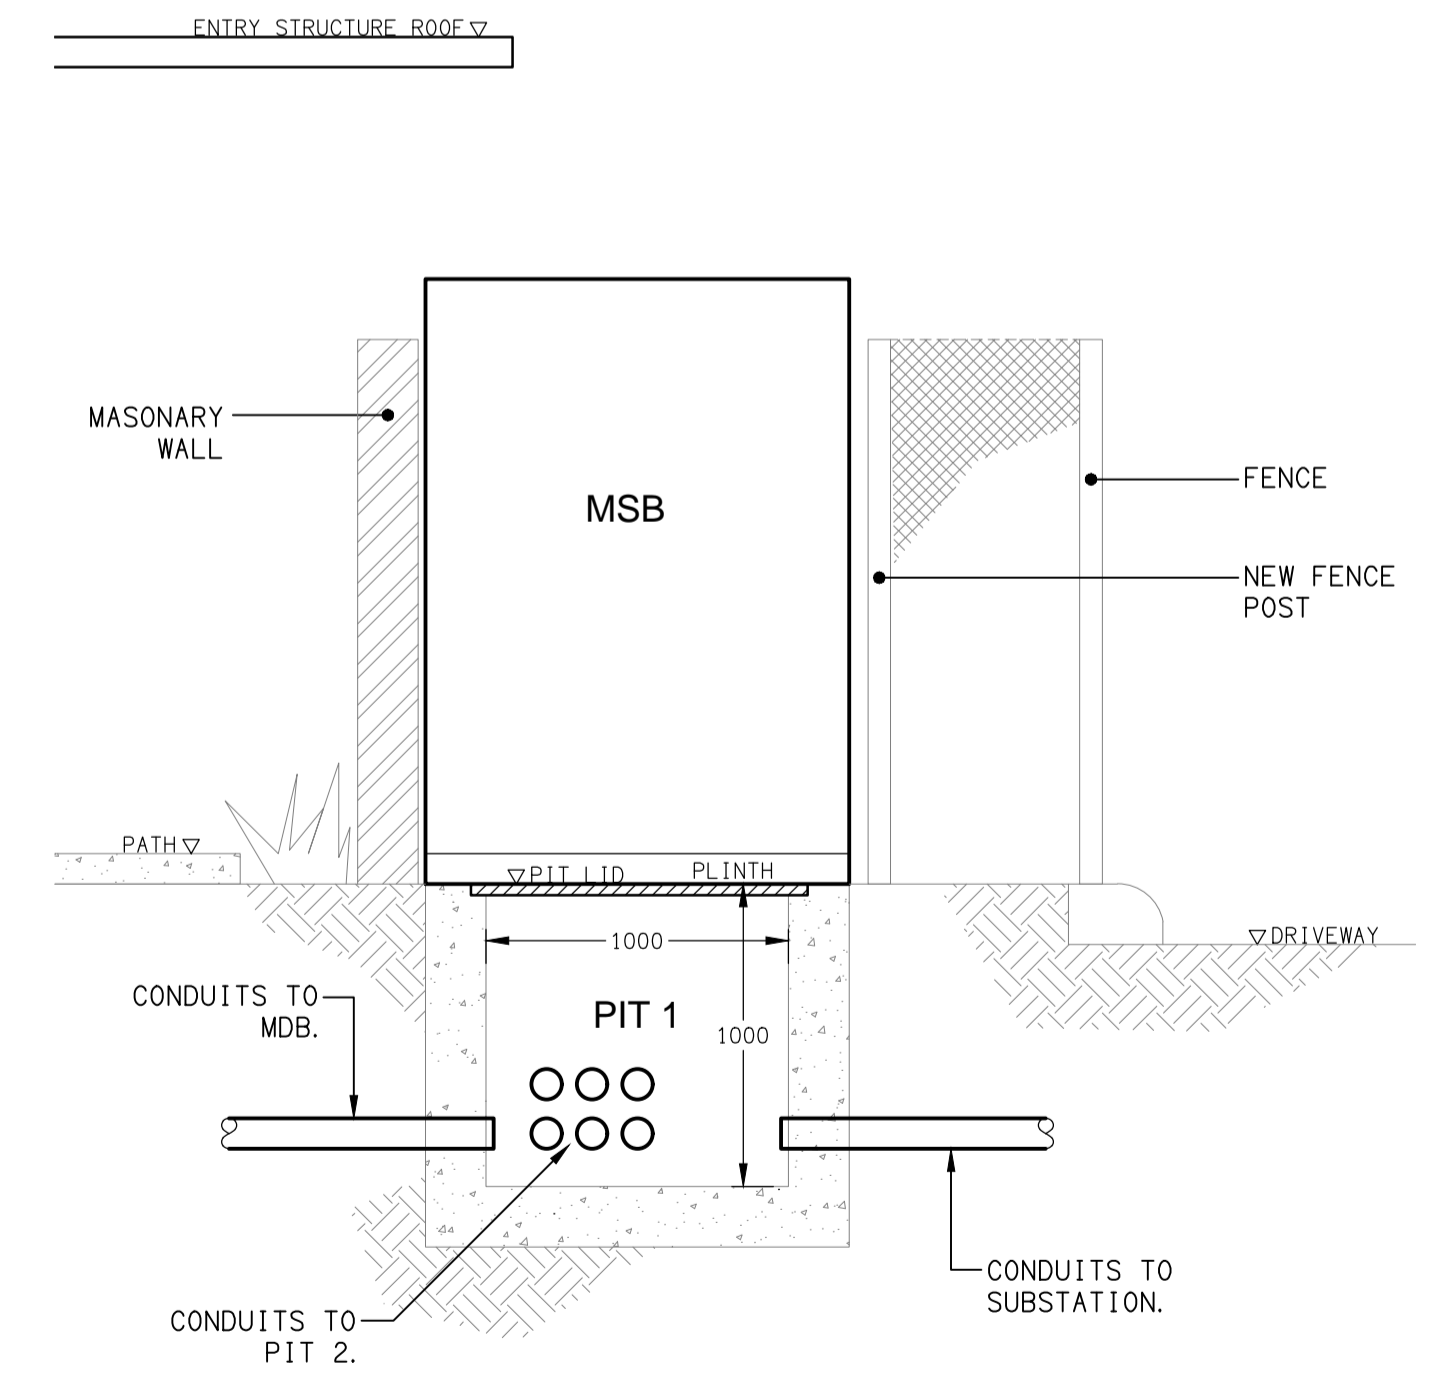

DETAIL B
MSB & PIT 1 SECTION
NOT TO SCALE

ELECTRICAL DESIGN GROUP BRISBANE
PTY LTD
ACN 092 710 793
TRADING AS:
ELECTRICAL DESIGN GROUP

THE COPYRIGHT OF THIS DRAWING
REMAINS THE PROPERTY OF THE
ELECTRICAL DESIGN GROUP.
USE FIGURED DIMENSIONS
IN PREFERENCE TO SCALE.
ALL DIMENSIONS TO BE
VERIFIED ONSITE.

ELECTRICAL DESIGN GROUP
ELECTRICAL BUILDING SERVICES CONSULTANTS
BRISBANE GOLD COAST
P.O. Box 15, Sherwood Q.4075
Phone: (07) 3278 4375
Email: brisbane@edg.net.au
Web: www.edg.net.au

PROJECT:
**OUR LADY'S COLLEGE, ANNERLEY
POWER SUPPLY UPGRADE**
15 CHESTER ROAD, ANNERLEY

C	TENDER	06/02/2025
REV.	DESCRIPTION:	DATE:
DRAWING: ELECTRICAL SERVICES PROPOSED STAGE 1 POWER DISTRIBUTION SITE PLAN		
SCALE: 1:500 UNO	PROJECT NO: C3219a	DRAWING NO: E03
AT A1	REVISION: C	