



DETAIL A
MITSUBISHI KITCHENETTE ELEVATION
SCALE 1:25

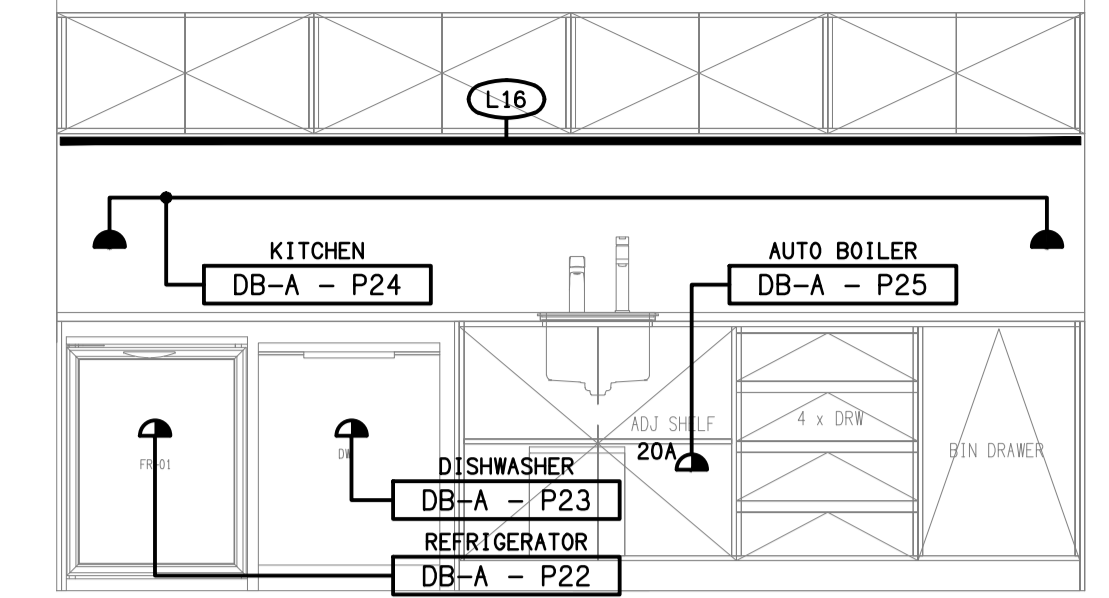

DETAIL B
KIA KITCHENETTE ELEVATION
SCALE 1:25

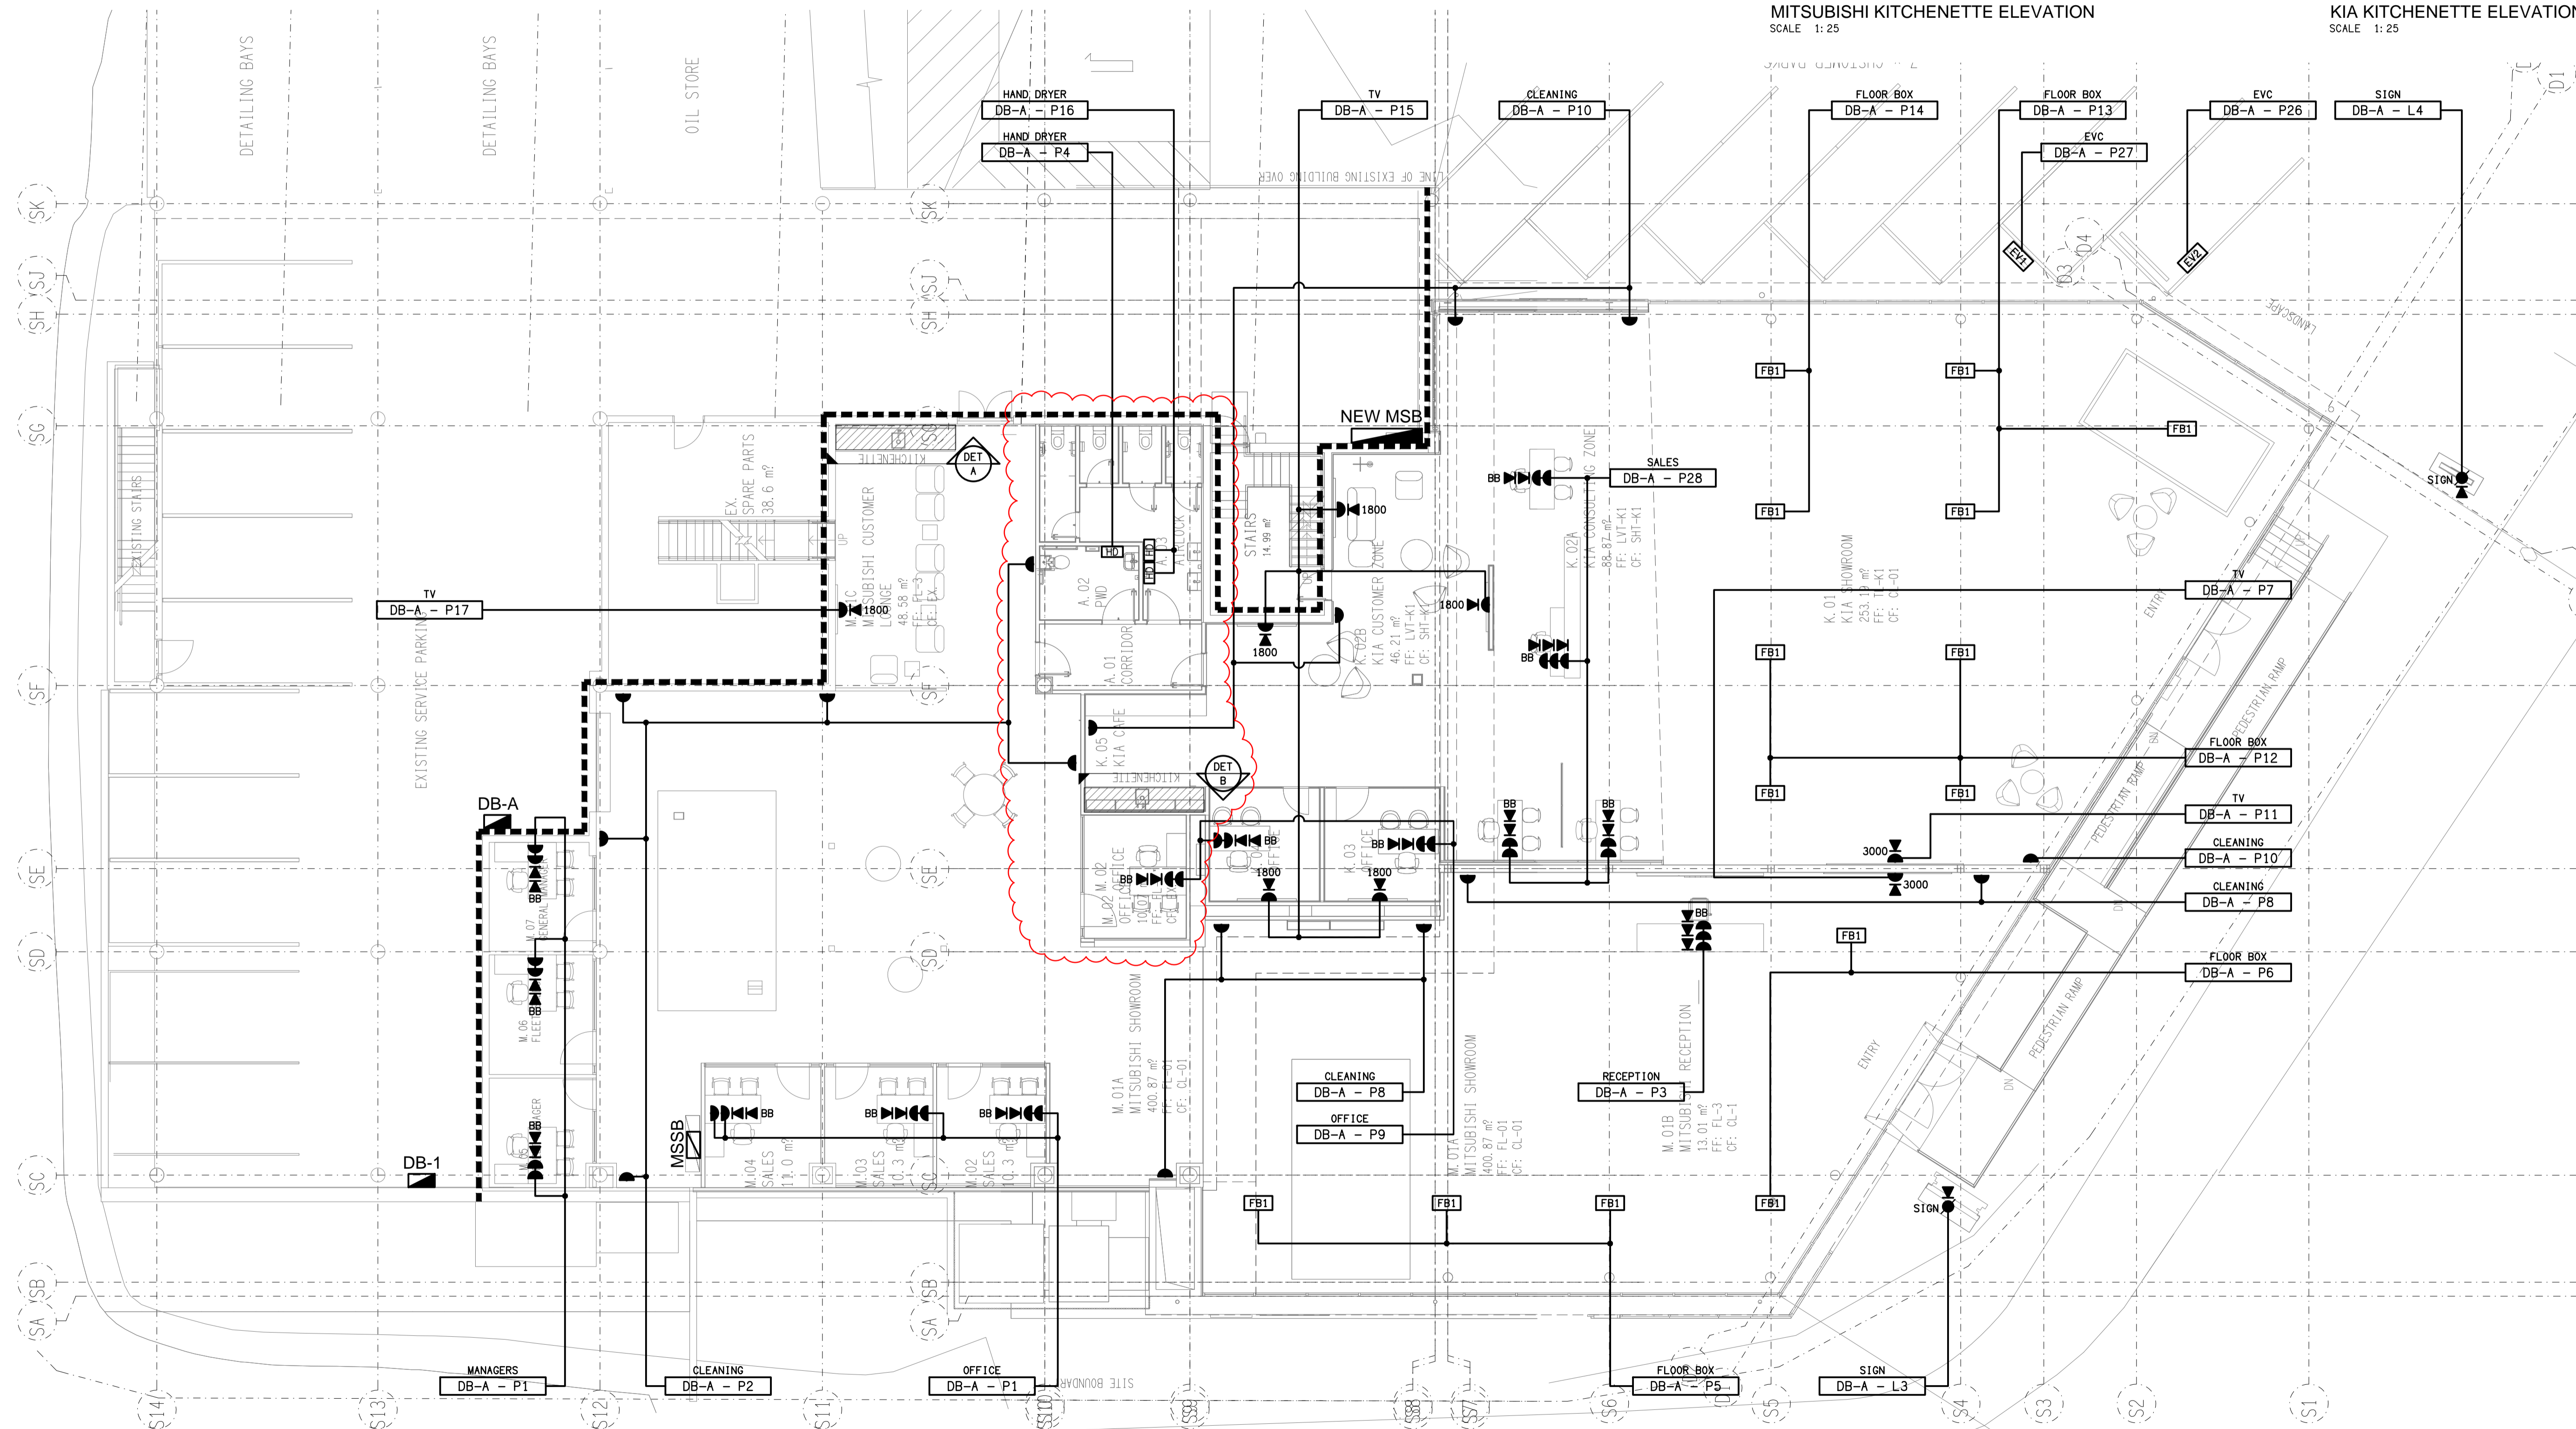

ELECTRICAL DESIGN GROUP BRISBANE
PTY LTD
ACN 092 710 793
TRADING AS:
ELECTRICAL DESIGN GROUP

THE COPYRIGHT OF THIS DRAWING
REMAINS THE PROPERTY OF THE
ELECTRICAL DESIGN GROUP.
USE FIGURED DIMENSIONS
IN PREFERENCE TO SCALE.
ALL DIMENSIONS TO BE
VERIFIED ON SITE.

ELECTRICAL DESIGN GROUP
ELECTRICAL BUILDING SERVICES CONSULTANTS
BRISBANE GOLD COAST

P.O. Box 15, Sherwood Q.4075
Phone: (07) 3278 4375
Email: brisbane@edg.net.au
Web: www.edg.net.au

PROJECT:
TOOWONG KIA & MITSUBISHI

601 MILTON ROAD, TOOWONG

D	CONSTRUCTION	17/02/2025
REV:	DESCRIPTION:	DATE:

DRAWING:
**ELECTRICAL SERVICES
GROUND LEVEL SHOWROOM
FLOOR PLAN**

SCALE: 1:100 UNO	AT A1	PROJECT NO: C3227a	DRAWING NO: E04	REVISION: D
---------------------	-------	------------------------------	---------------------------	-----------------------